
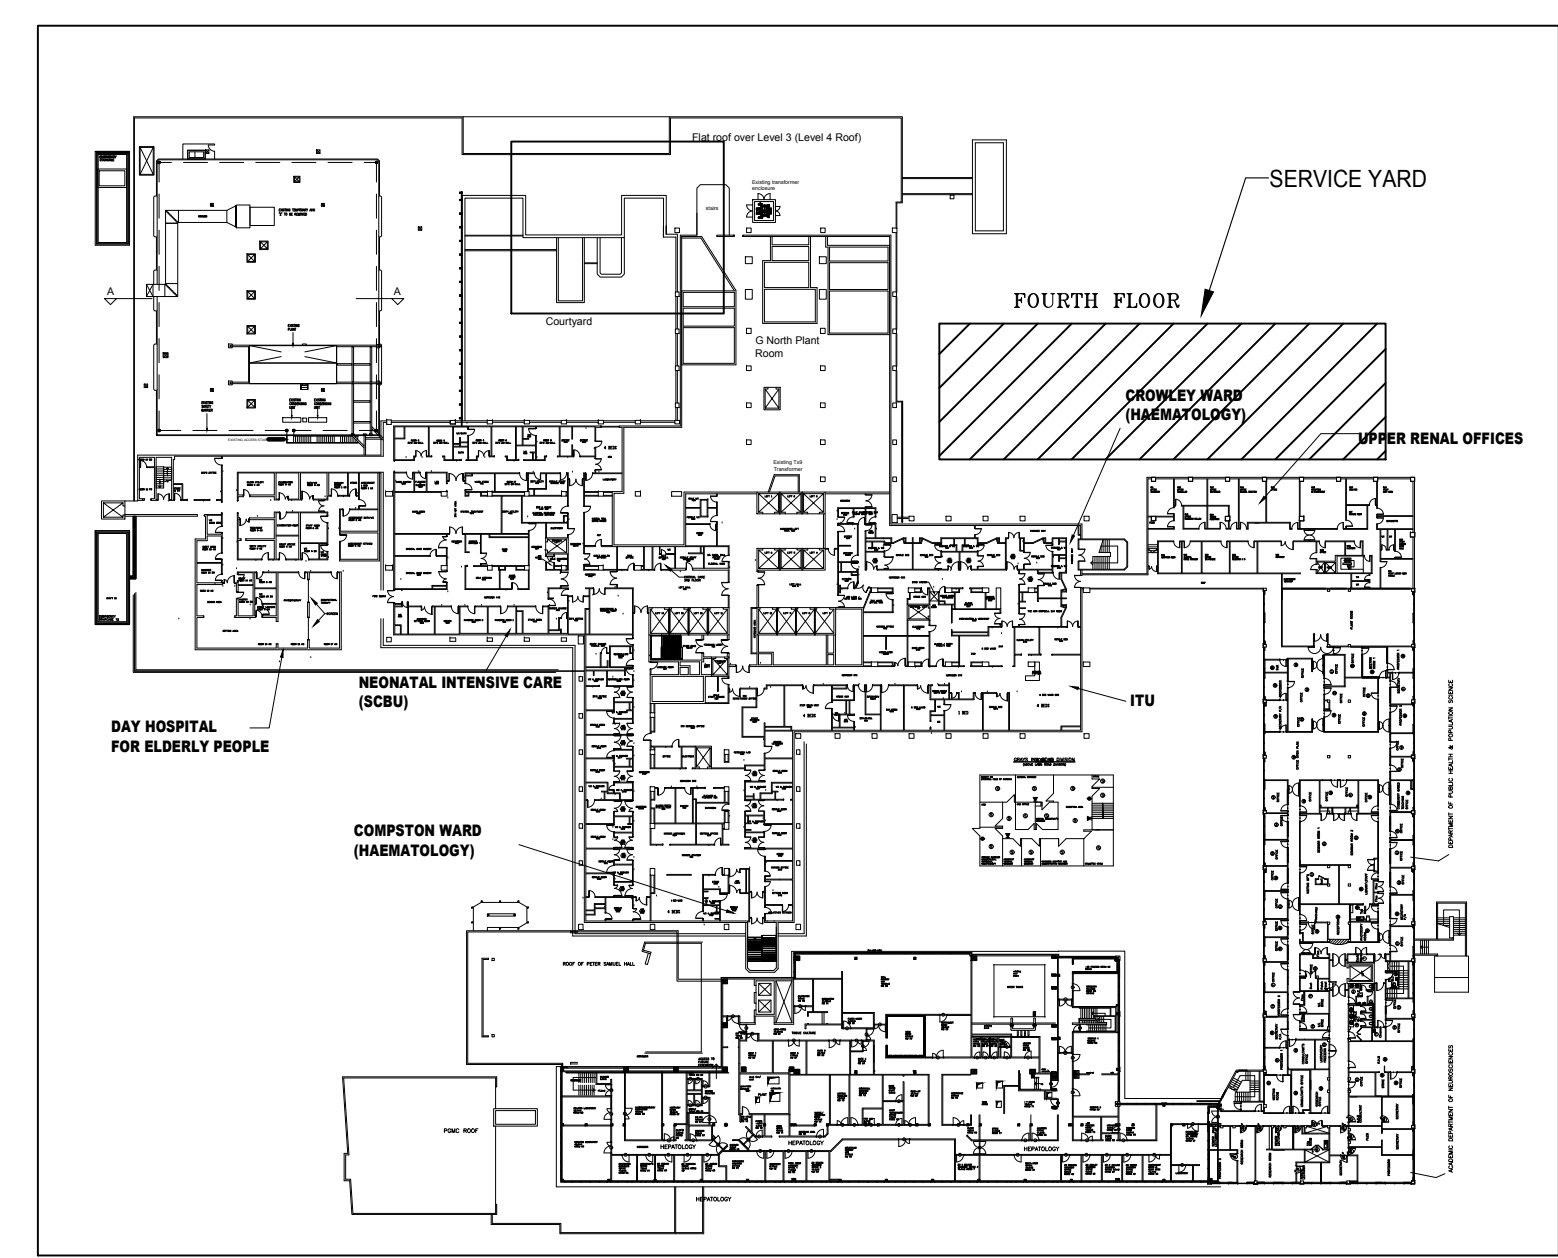


SEE SHEET 1
FOR CONTINUATION

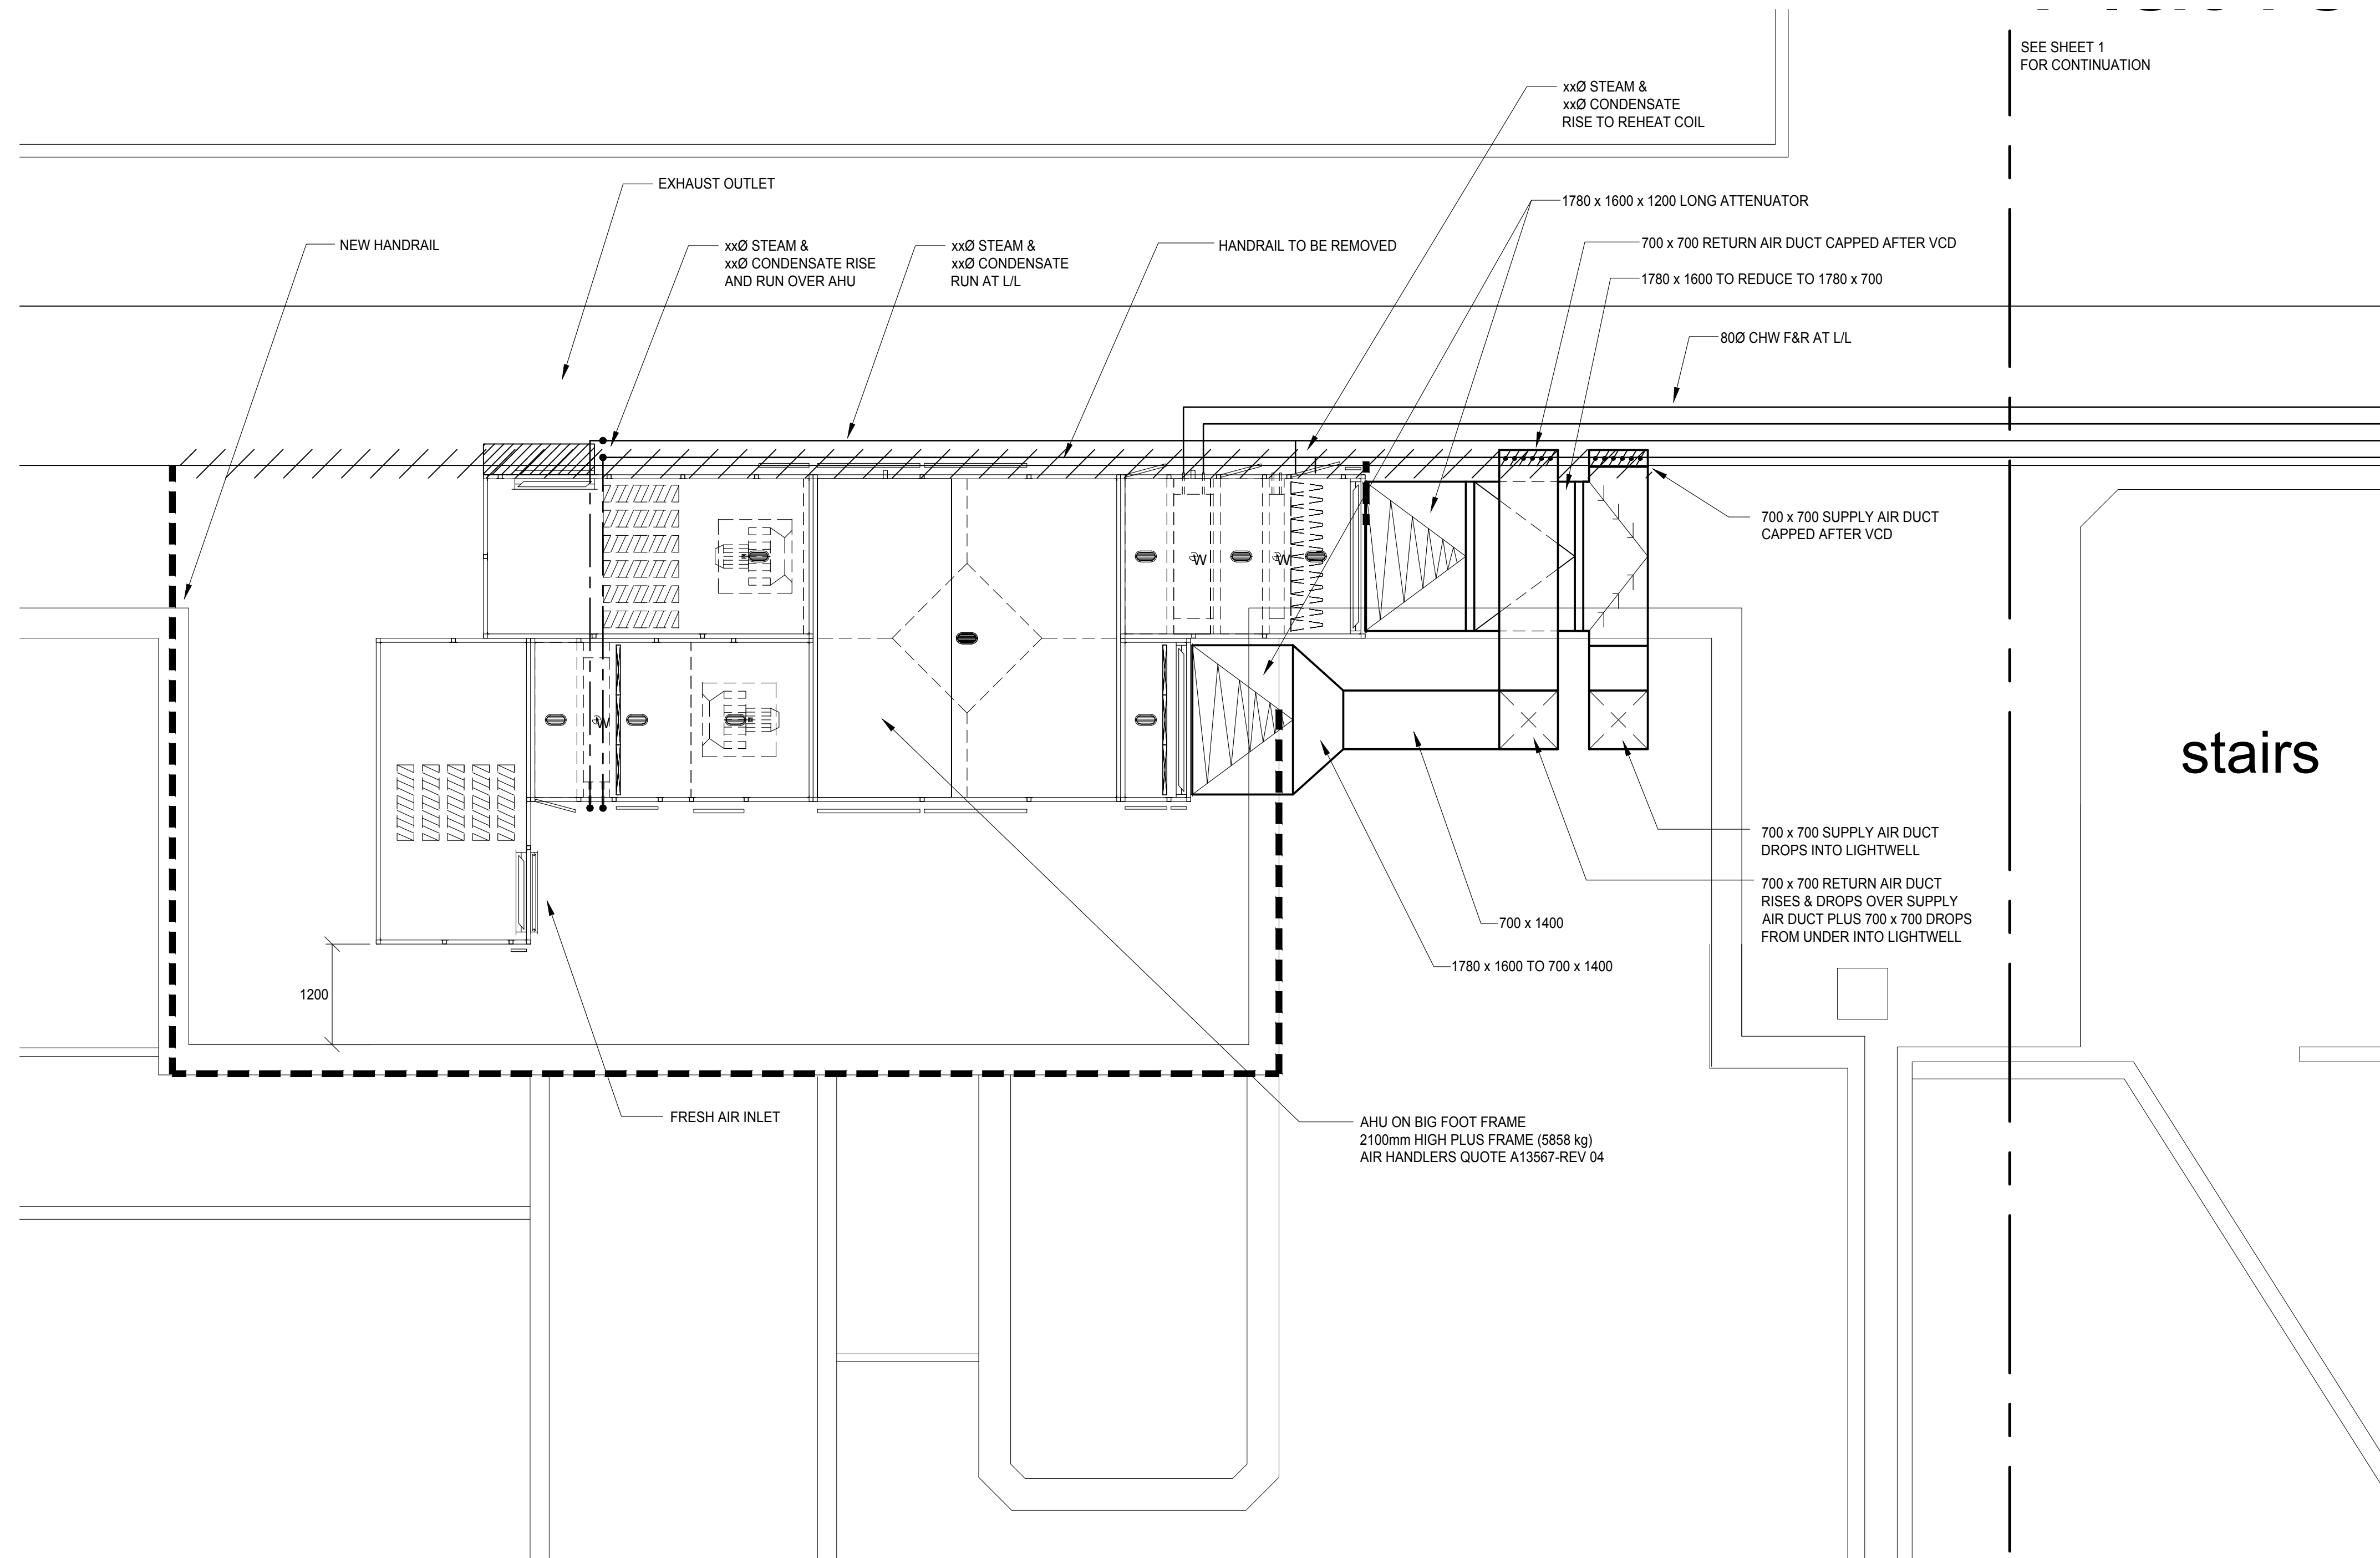

SITE PLAN

Legend

PHASE 2 WORKS

Notes

1. PHASE 1 WORKS INCLUDE THE PROCUREMENT, DELIVERY AND CRANAGE INTO POSITION THE AHU AND CHILLER ONTO A BIG FOOT FRAME SYSTEM. ALL DUCTWORK AND CONTROLS FORM STAGE 2 WORKS.
2. THE WORKS SHOWN ON THIS DRAWING SHALL BE PROCURED AND UNDERTAKEN BY THE MAIN CONTRACTOR NOT THE MECHANICAL SUB-CONTRACTOR.

This drawing is copyright & may not be altered, reproduced or used other than for the Contract Works for which it is issued without the written permission of Stuart McCurry & Partners Limited.
Do not scale this drawing. Verify all dimensions & structural details on site. If in doubt, ask before acting.
Read this drawing in conjunction with the appropriate Specification(s).
The purpose of this drawing when issued as a Tender Drawing is to enable tenderers to interpret correctly the design and to submit competitive tenders for the works. A Tender Drawing whether original or amended shall not be used as an installation Drawing except under the terms contained in the conditions of Tender.

edition	date	designed	drawn	checked
P1	28.06.18	SG	MM	
P1 PRELIMINARY ISSUE				

job title
**ROYAL FREE HOSPITAL
THIRD FLOOR
HDU FEASIBILITY**

drawing title
**Mechanical Services
PHASE 2
LEVEL 4
PLANT LAYOUT
SHEET 1 of 2**

job no. 18028 scale 1:50@A1 status PRELIMINARY

Consulting Engineers ~ Building Services

Stuart McCurry & Partners Limited
SMP House
South Street
Wendover, Aylesbury,
Buckinghamshire HP22 6EF
Email : engineers@smpengineering.co.uk
Web : www.stuart-mccurry-partners.co.uk
Tel : 01296 696780 Fax : 01296 696447

drawing no. 02-M-04-200-01 edition P1