
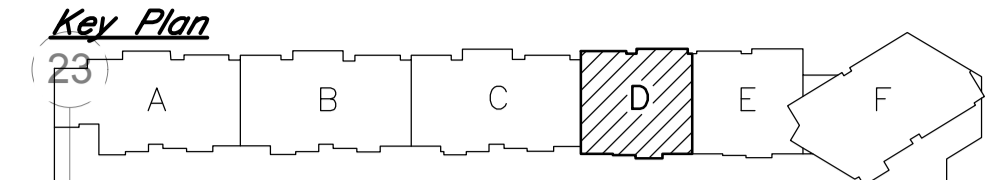


COMPANY OF ORIGIN	ARCHITECTS DRAWING No.
Pollard Thomas Edwards	029_L(00)_D_100_G
ORIGINAL FILE NAME	029_L(00)_D_100_G
ORIGINAL DRAWING TITLE	REV. DATE RECEIVED
General Arrangement Plan Block D - Level 0	G 14-06-17

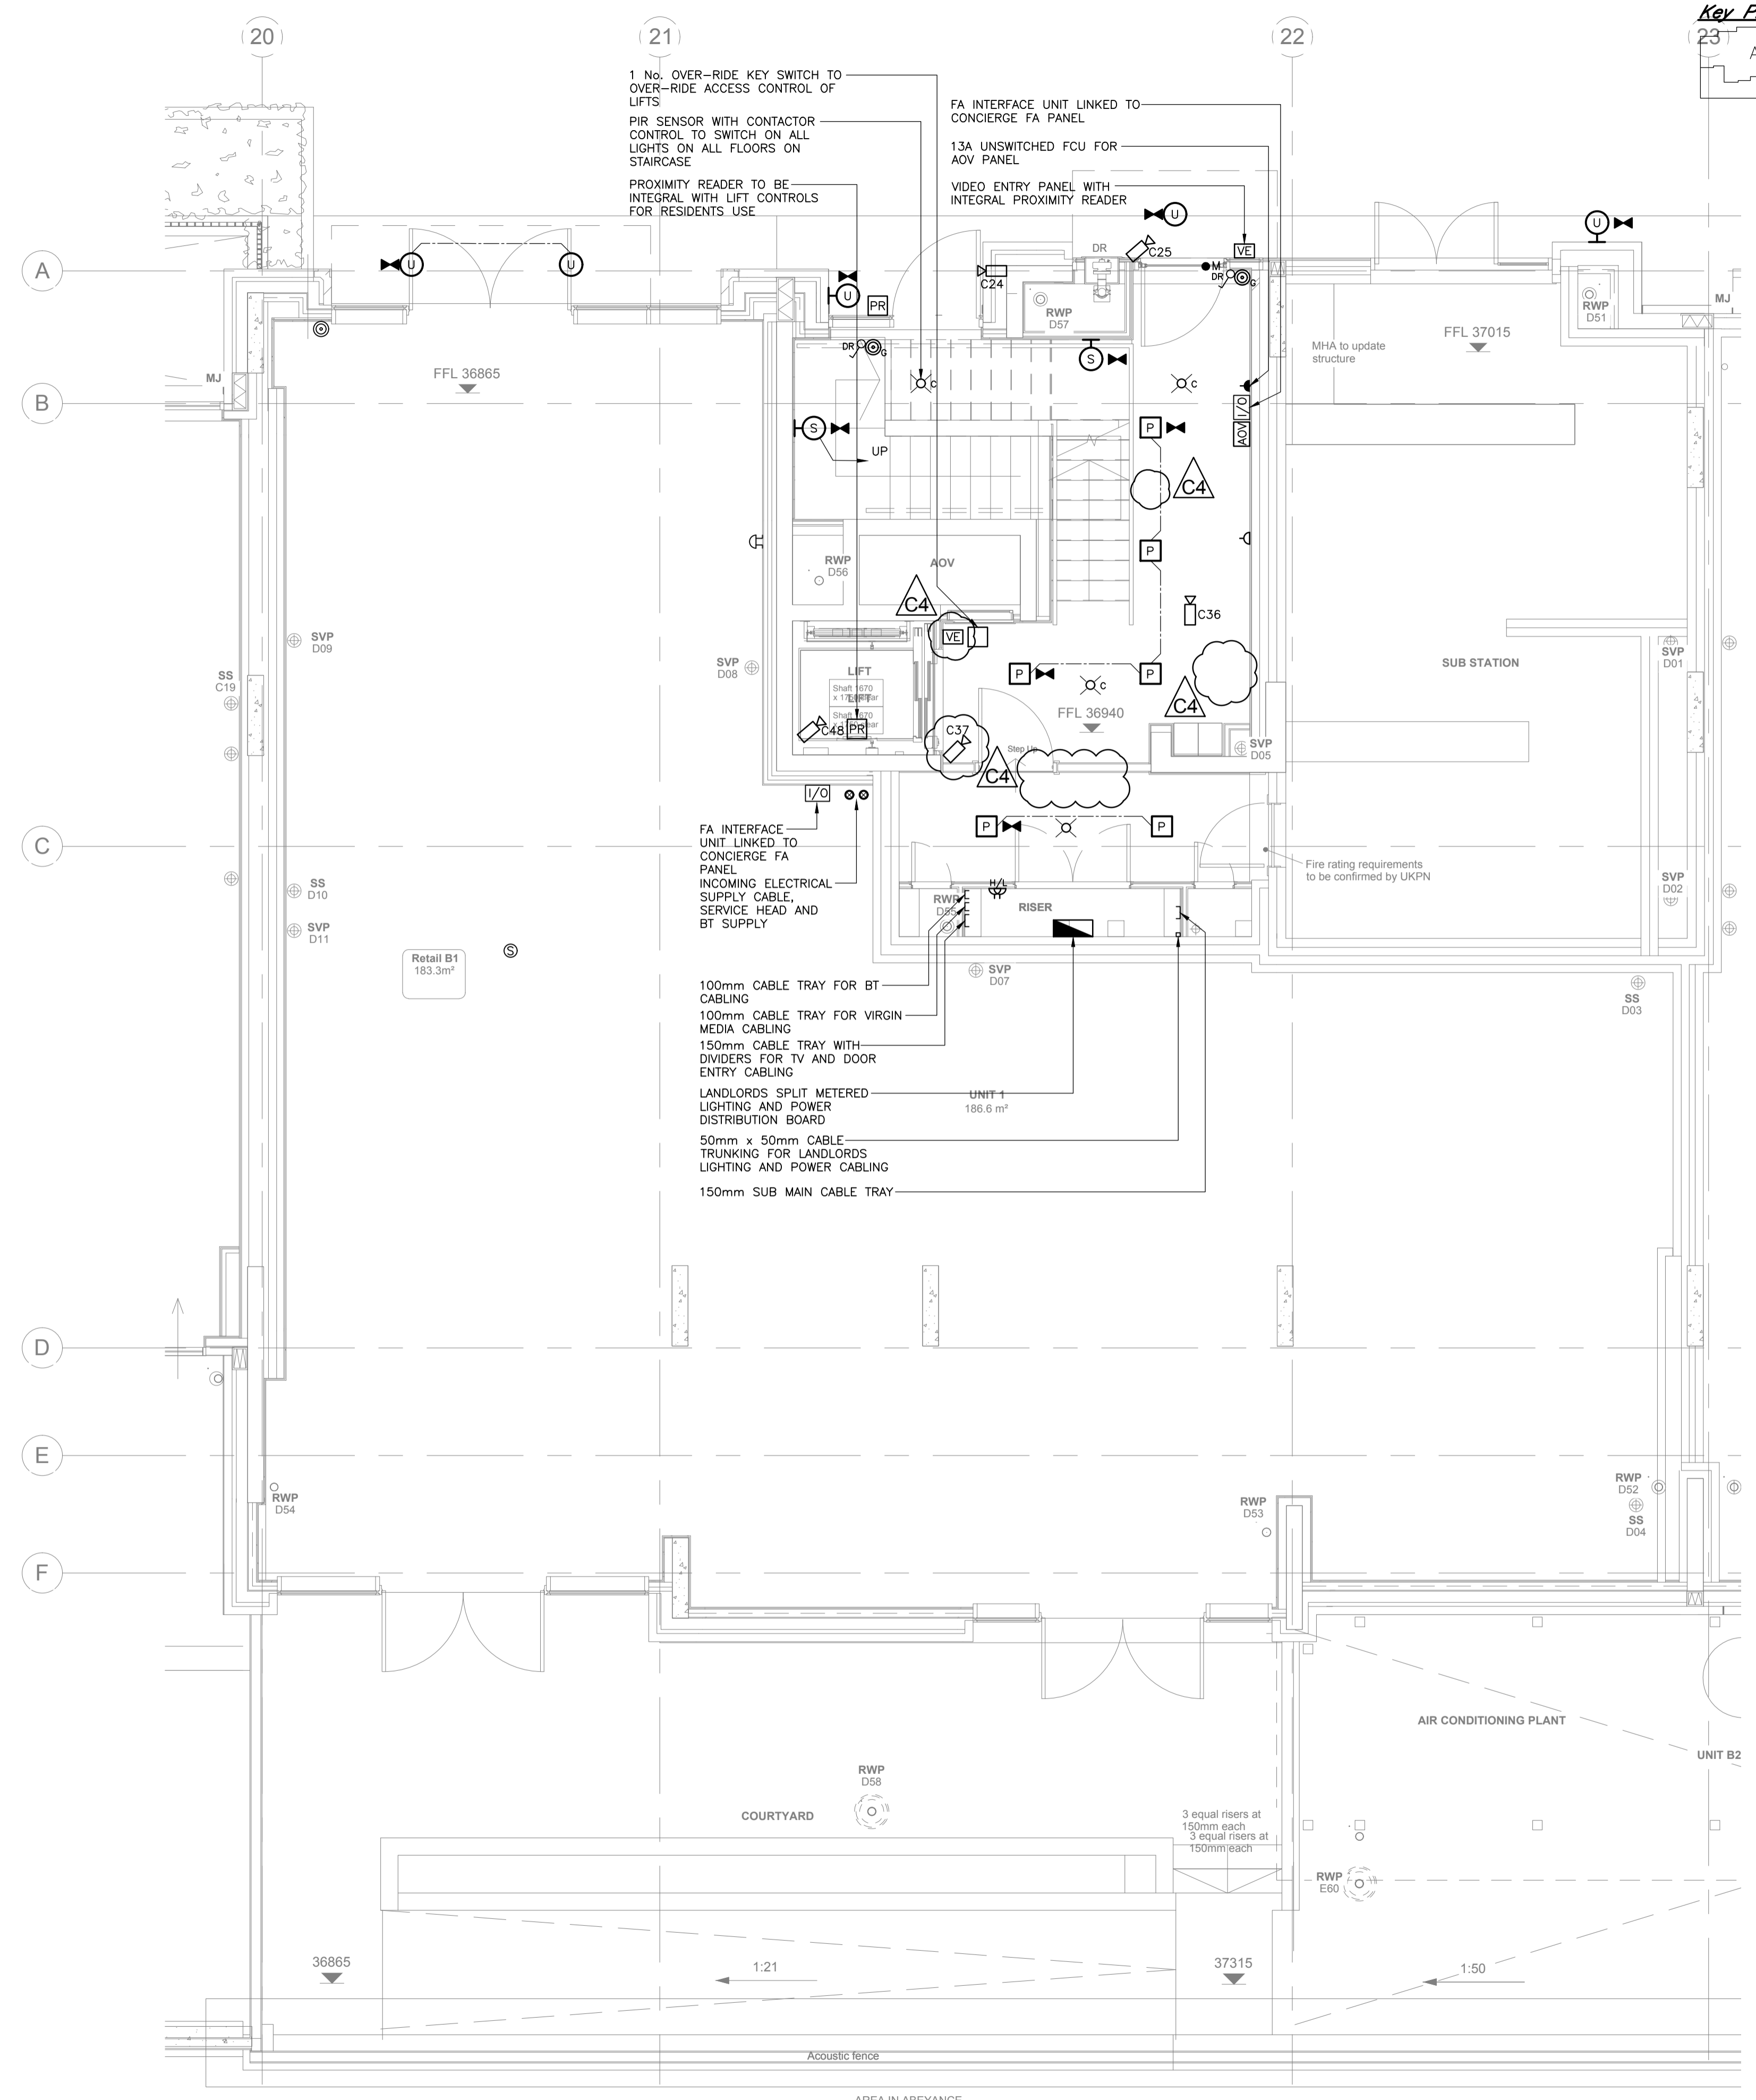


**NOTES**

1. ALL DIMENSIONS ARE IN MILLIMETRES UNLESS OTHERWISE INDICATED.
2. THIS DRAWING SHALL BE READ IN CONJUNCTION WITH THE SPECIFICATION AND ALL OTHER DRAWINGS.

C4	03.10.17	REVISED AS CLOUDED.	PK MD
C3	14.06.17	REVISED TO SUIT LATEST ARCHITECTS LAYOUT AND AS CLOUDED.	PK MD
C2	04.04.17	FIRE ALARM ADDED TO RETAIL UNIT	PK MD
C1	31.03.17	<b>CONSTRUCTION ISSUE</b>	LT MD

Date	Revision	Dwn	Chk

**Norman Bromley Partnership LLP**  
consulting engineers  
Bridge House,  
97-101 High Street,  
Tonbridge,  
Kent. TN9 1DR

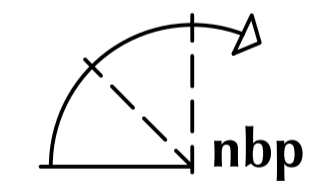

Tel. No. (01732) 773737 Fax No. (01732) 773353  
Email: mail@normanbromley.co.uk

Client  
**WATES LIVING SPACES**

Project  
**ABBAY ROAD**

Service  
**Electrical Engineering**

Title  
**BLOCK D LEVEL 0  
GROUND FLOOR PLAN  
ELECTRICAL SERVICES LAYOUT**

Scale	Date	Drawn	Approved
1:50@A1	NOV'16	JP	MD
DRAWING No.	REV.		
EBS 1536-D/2	C4		

**CONSTRUCTION**