


- NOTES**
- LUMINAIRE WITHIN LICHWELL /CANOPY AREAS CONNECTED TO EXTERNAL LIGHTING DISTRIBUTION BOARD, TIME CLOCK AND PHOTO CELL, CONTROLLED USING 3 CORE 1.5mm XLPE/SWA/LSF CABLES
 - FOR ELECTRICAL LEGEND AND KEY OF ROOM TYPE SYMBOLS REFER TO DRG No. 3463/0200/E14RD

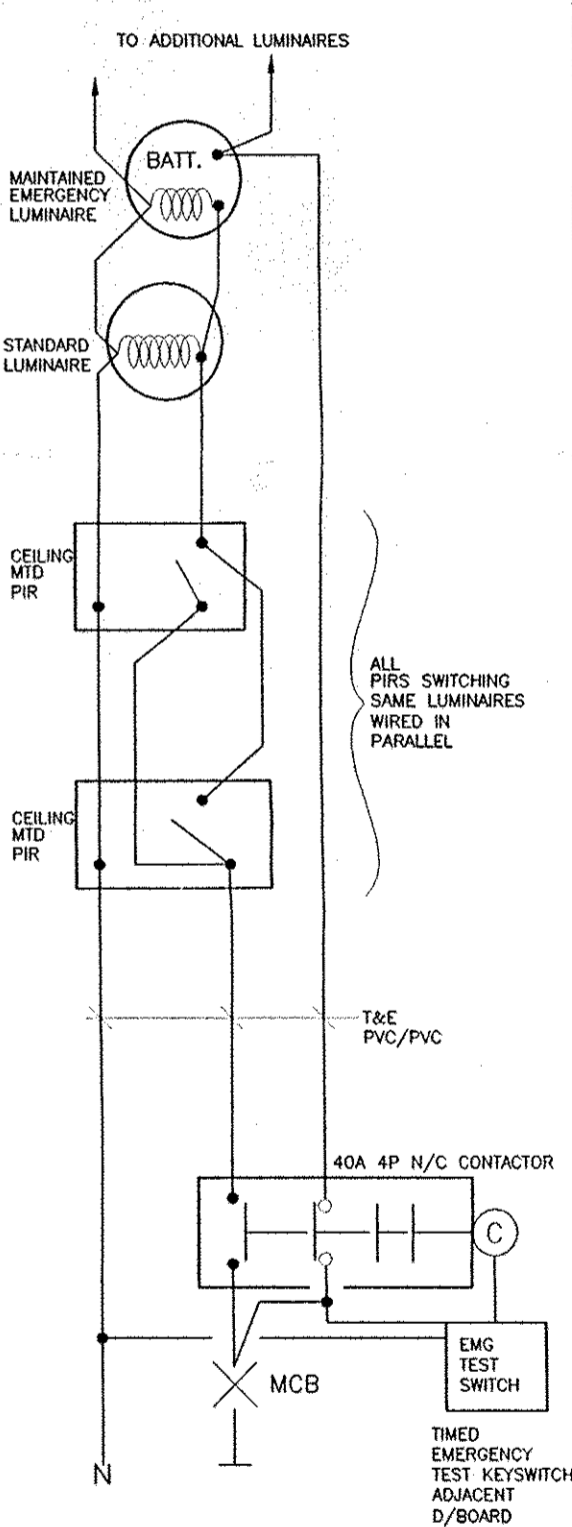

RECORD DRAWING
05/04/01

AIRPORT HOUSE
PURLEY WAY
CROYDON
SURREY
CR0 0XZ

MACDONALD
DESIGN
PARTNERSHIP
BUILDING SERVICES
CONSULTING ENGINEERS

TEL: 0181-781-1990
FAX: 0181-781-1980

MECHANICAL SERVICES LTD
HEATING AIR CONDITIONING AND ELECTRICAL ENGINEERS
Orchard House, Purley Road, S.Croydon, Surrey. CR2 6EZ. Tel:0208-681 8782 Fax:0208-686 1030

MSL

DRAWN BY: L BENNETT
CHECKED BY:
DATE: FEB. 00
SCALE: 1:50 (A1)

DRAWING No: 3463/0200/E01 RD
REV: TENDER PRELIMINARY
CONTRACT RECORD

TITLE: LOWER GROUND FLOOR
LIGHTING & FIRE ALARM LAYOUT
FELLOWSHIP HOUSE
21-25 MECKLENBURGH SQUARE
LONDON