


Lighting	
	Wall Luminaire
	Pendant
	Single Point Source Luminaire (Downlight)
	Decorative Striplight
	Linear Fluorescent Luminaire
	Double Point Source Luminaire (Downlight)
Fire Alarm	
	Fire Alarm
	Heat detector

Note: Indicative lighting design layout. MEP Engineers to confirm lighting levels and quantities of fittings. Refer to MEP layouts for full electrical layouts

- General Notes:
- For all M&E requirements including Plant layout refer to Edward Pearce information.
 - For AV requirements refer to Edward Pearce proposals
 - For Lighting requirements refer to Edward Pearce proposals
 - For all Swimming Pool information including Pool Plant layout refer to swimming pool consultant's information.

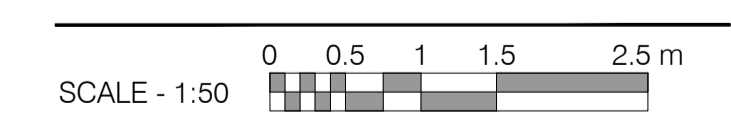

Rev:	Comments:	By:	Date:
B	New design for Rear Extension	KS	24-08-2018

PLANNING

Client:
-
Project Title:
24 Heath Drive, London, NW3 7SB
Drawing Title:
Reflected Ceiling Plan
Second Floor

Scale: 1:50@A1
Date: JAN 18
Drawn: ST
Checked: HV

kyson
Studio
28 Scrutton Street
London
UK
EC2A 4RP
T: +44(0) 20 7247 2462
E: enquiries@kyson.co.uk
W: www.kyson.co.uk

Project No.: 508-16
Drawing No.: 2102
Revision: B

Do not scale this drawing. All dimensions must be checked on site. All rights reserved. No reproduction in any material form is permitted without consent.