



**PLAN**  
SCALE 1:25

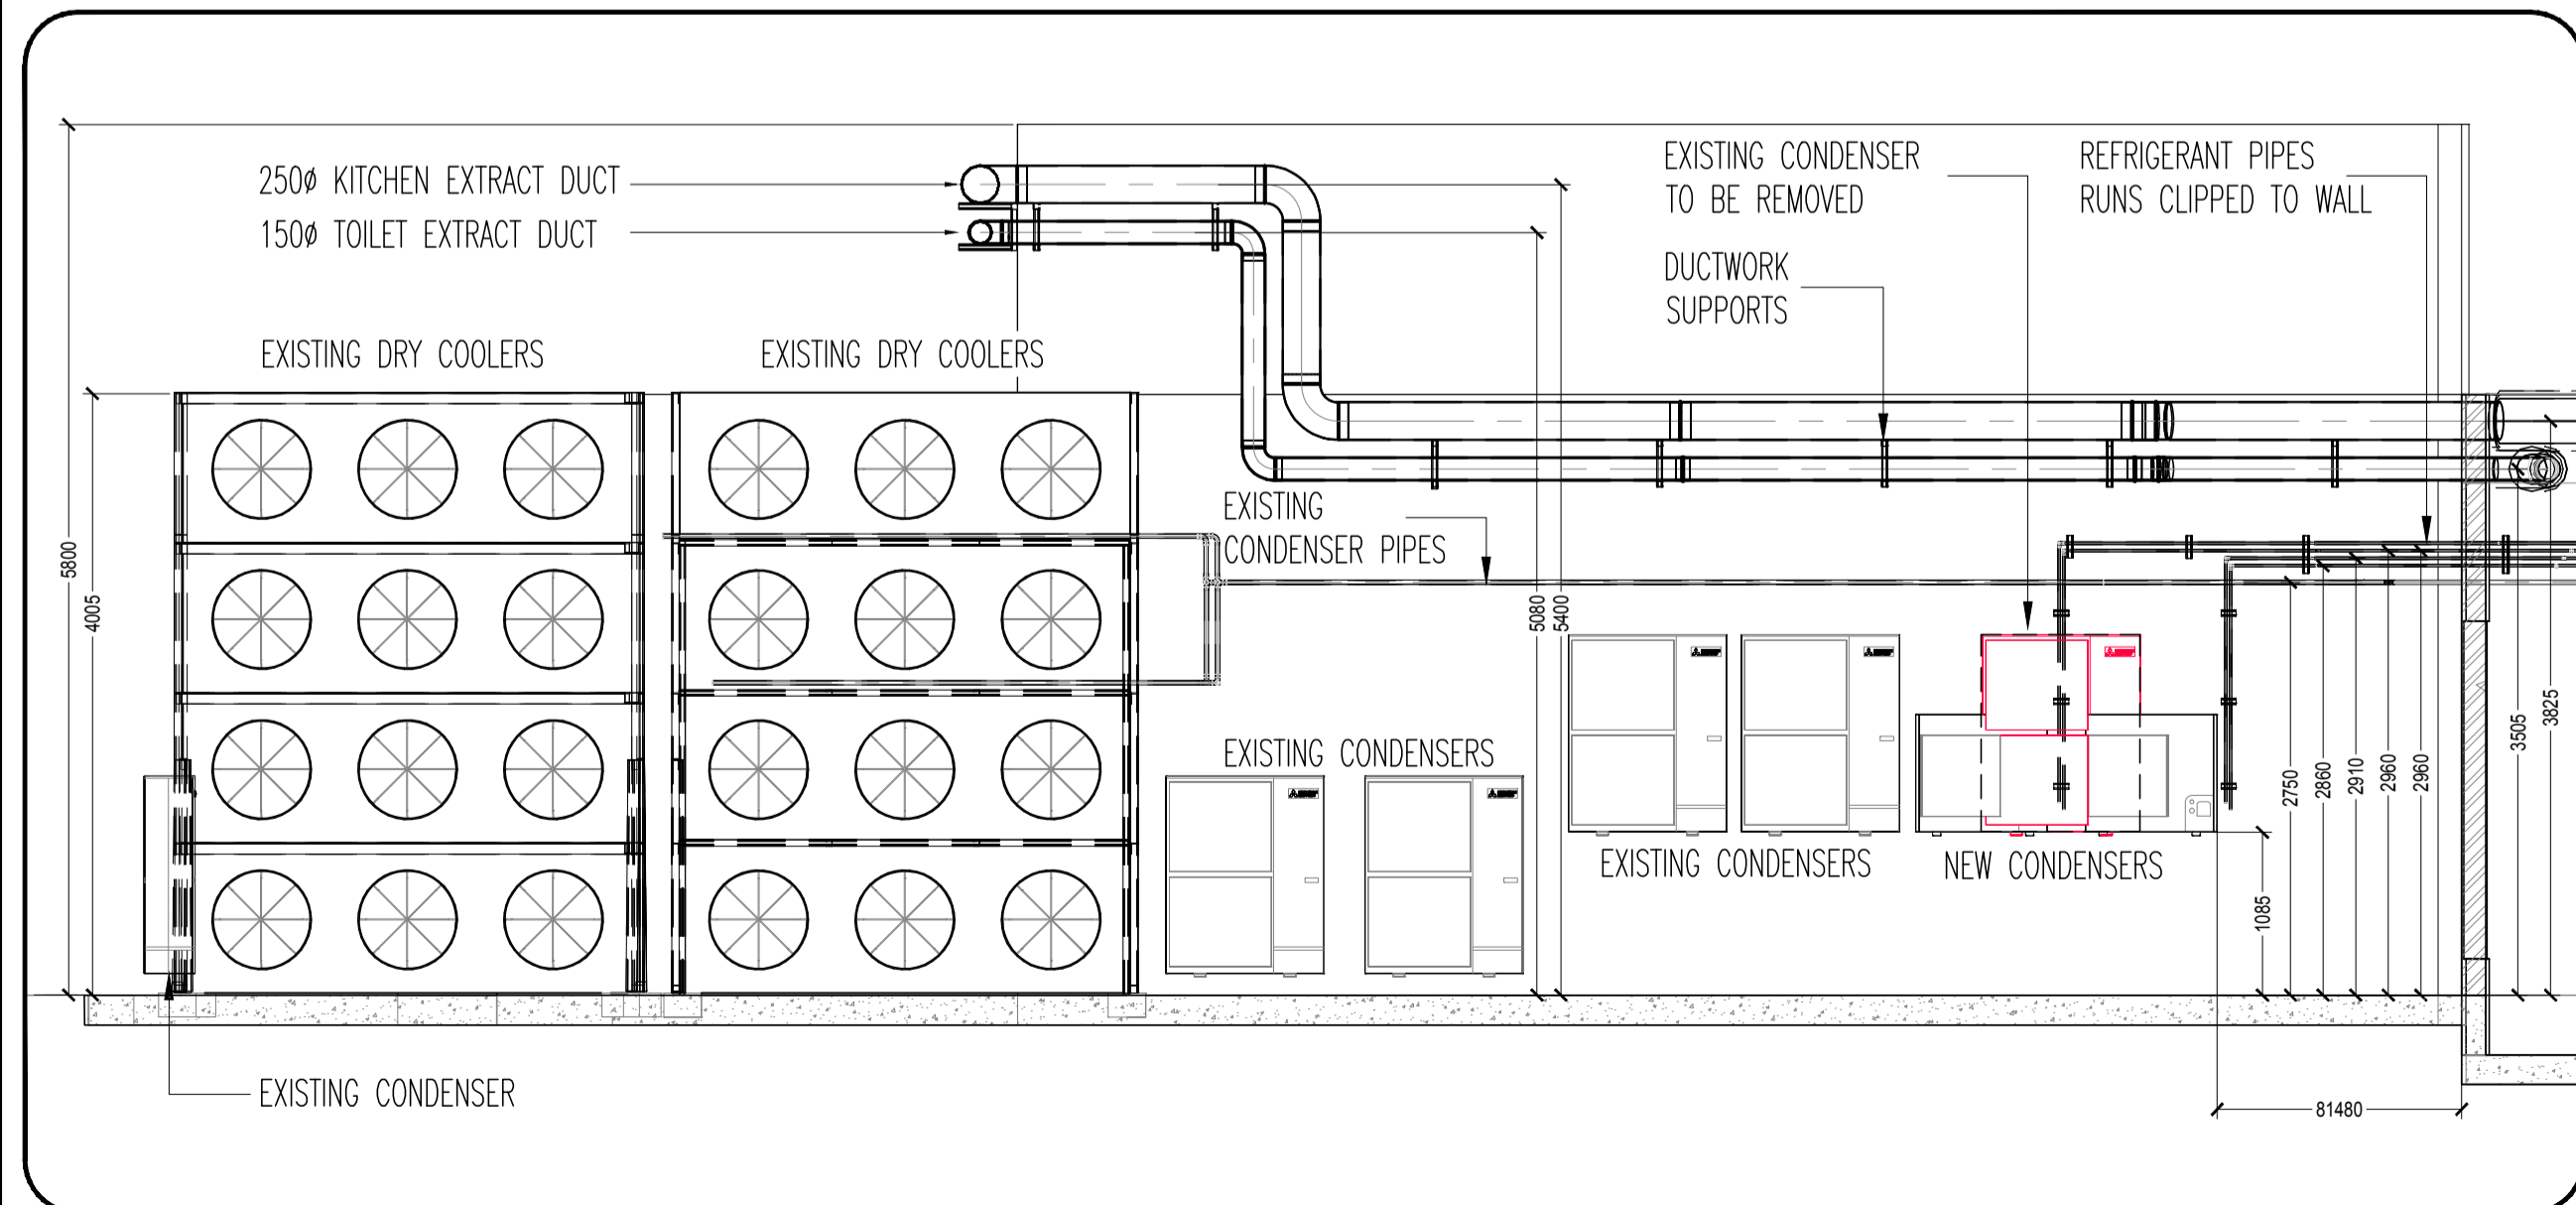

**SECTION A-A**  
SCALE 1:50

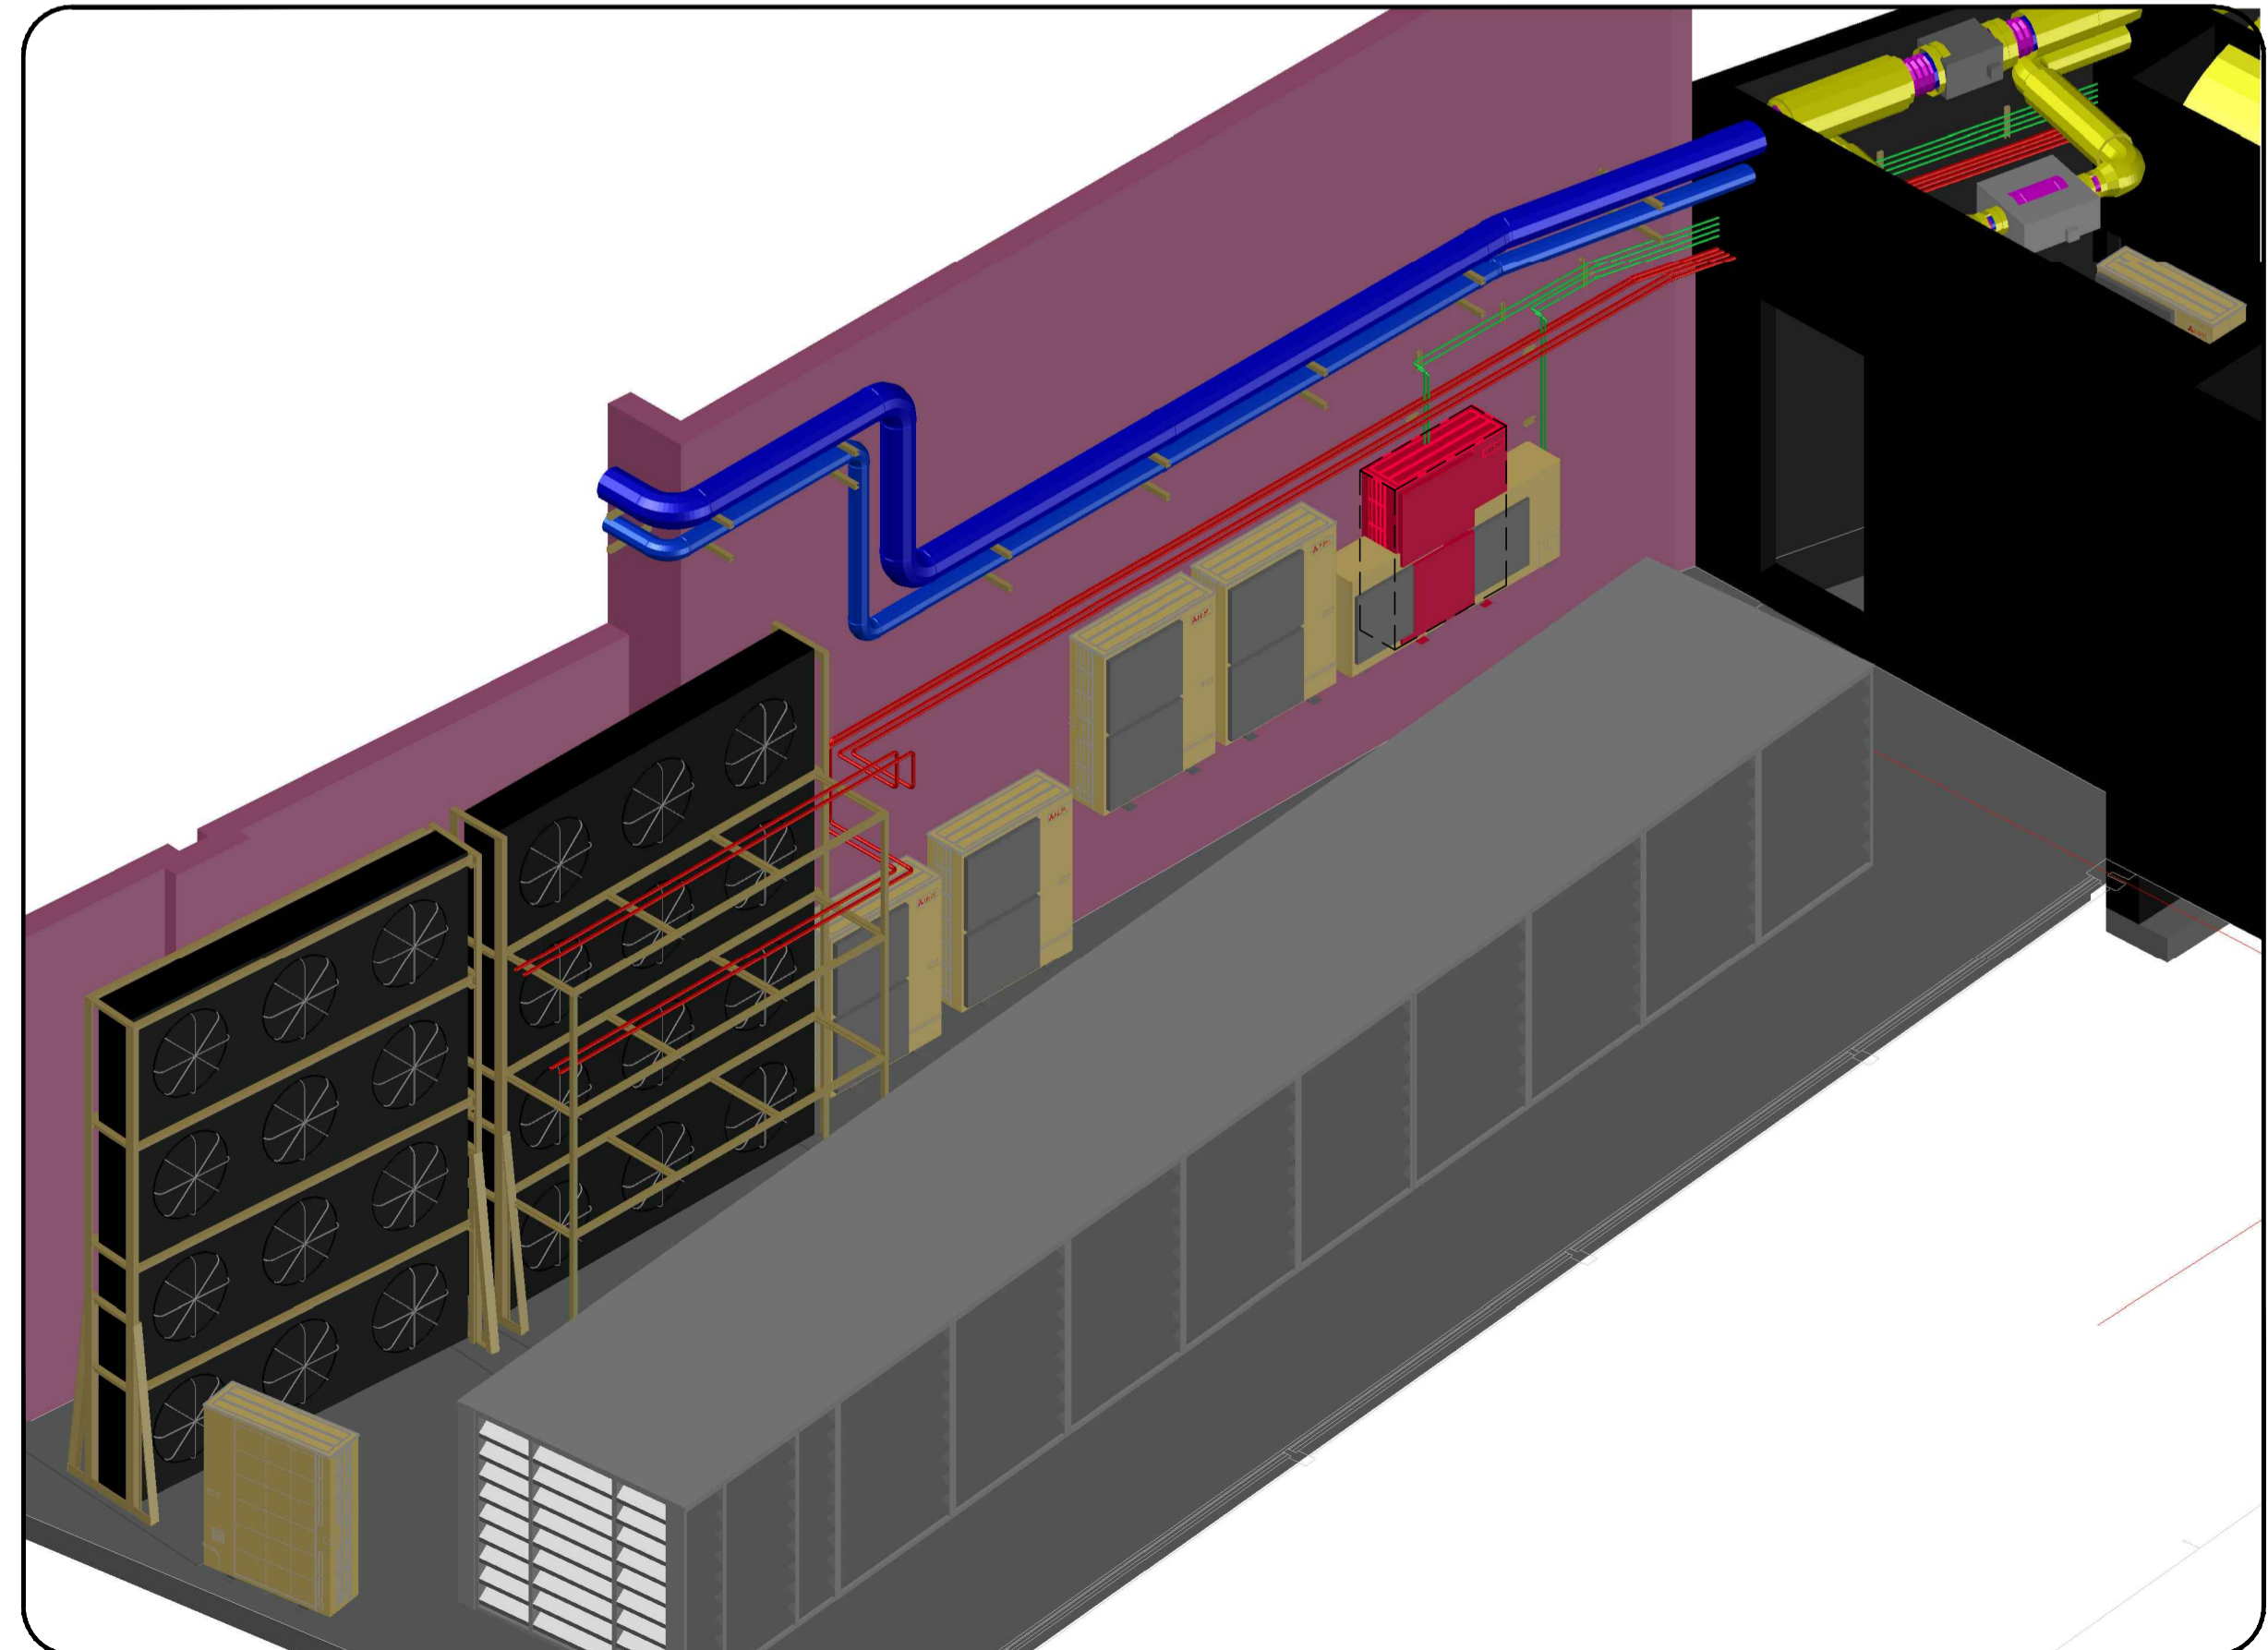

**ISOMETRIC VIEW**

**DO NOT SCALE THIS DRAWING**

- GENERAL NOTES:-
- DO NOT SCALE FROM THIS DRAWING. ALL DIMENSIONS MUST BE CHECKED / VERIFIED ON SITE.
  - ALL DIMENSIONS IN MILLIMETERS UNLESS OTHERWISE STATED.
  - THIS DRAWING TO BE READ IN CONJUNCTION WITH THE LATEST ARCHITECTURAL, STRUCTURAL & BUILDING SERVICES DRAWINGS.
  - THIS DRAWING TO BE READ IN CONJUNCTION WITH ALL THE LATEST SCHEMATICS, SPECIFICATIONS & SCHEDULES.
  - ANY DISCREPANCIES NOTED ON SITE ARE TO BE REPORTED TO THE ENGINEER IMMEDIATELY.

**NOTES**

- DUCTWORK BETWEEN KITCHEN / LOBBY WALL TO BE FIRE RATED, TO PREVENT SMOKE LEAKAGE ON ESCAPE ROUTE AND WITHIN CORE 2 GROUND FLOOR PLANTROOM, TO PLANTROOM TO EXTERNAL LOUVRE.

**DRAWINGS TO BE READ IN CONJUNCTION WITH:**

- 6000-DR-M106 BAR/KITCHEN CORRIDOR & PLANT ROOM LAYOUT & SECTIONS
- 6000-DR-M107 BAR/KITCHEN HIGH LEVEL PIPEWORK SERVICES LAYOUT & SECTIONS
- 6000-DR-M108 BAR/KITCHEN HIGH LEVEL DUCTWORK SERVICES LAYOUT & SECTIONS
- 6000-DR-M109 BAR/KITCHEN LOW LEVEL PUBLIC HEALTH & ELECTRICAL SERVICES LAYOUT
- 6000-DR-M110 BAR/KITCHEN HIGH LEVEL CONTAINMENT & ELEC SERVICES LAYOUT & SECTIONS
- 6000-DR-M111 LIGHTWELL EXISTING AND NEW SERVICES LAYOUT
- 6000-DR-M112 BAR/KITCHEN & PLANT ROOM CO-ORDINATED SERVICES LAYOUT & SECTIONS
- 6000-DR-DET-01 GENERAL DETAILS.

**DRAWING STATUS**

**FOR APPROVAL**

17/08/18	ISSUED FOR APPROVAL	00
07/08/18	ISSUED FOR APPROVAL	0
<b>DATE</b>	<b>REVISION</b>	<b>No.</b>

**CONTRACT**

**200 GRAYS IN ROAD**

**TITLE**

**LIGHTWELL EXISTING & NEW  
PLANT ARRANGEMENT LAYOUT  
& SECTIONS**

**ARCHITECT**

**CONRAN & PARTNERS**

**CONSULTANT**

**N.D.Y DESIGN CHECKED BY MALA**

**MALA**

9 Hewett Street,  
London EC2A 3NN  
Tel: 020 7456 1200  
Fax: 020 7456 1201  
Email: mala@mala.co.uk

SCALE 1:25 & 1:50	DATE 02/08/18	
DRAWN PAN	DRG No. 6000-DR-M111	00