



**PLAN**  
SCALE 1:25

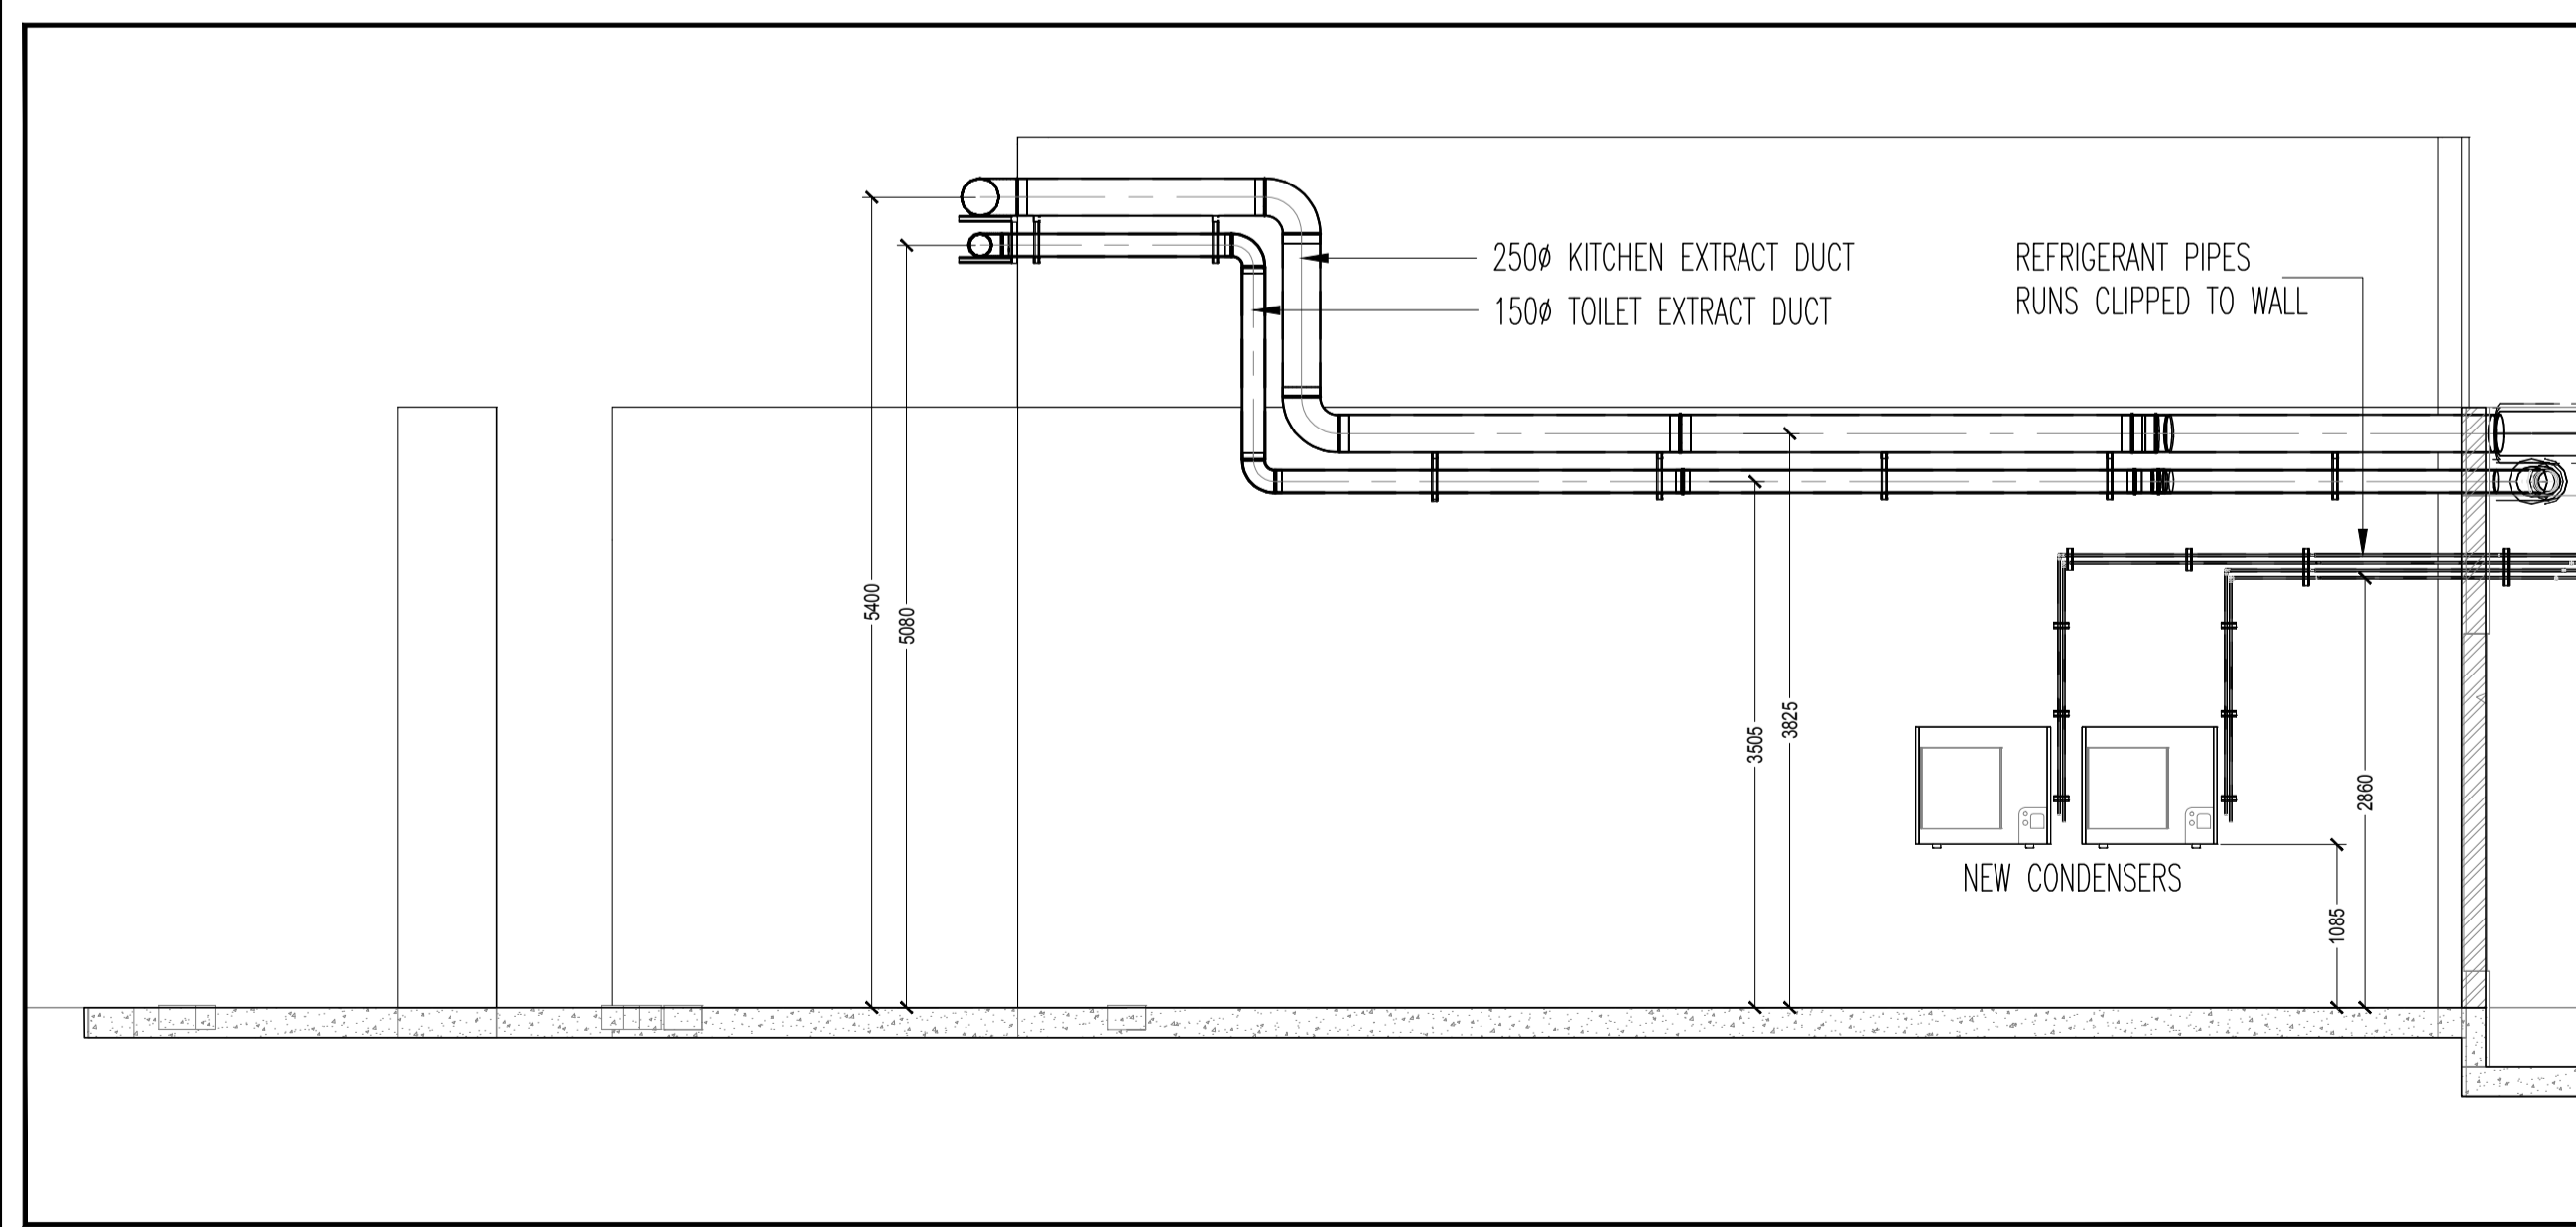

**SECTION A-A**  
SCALE 1:50

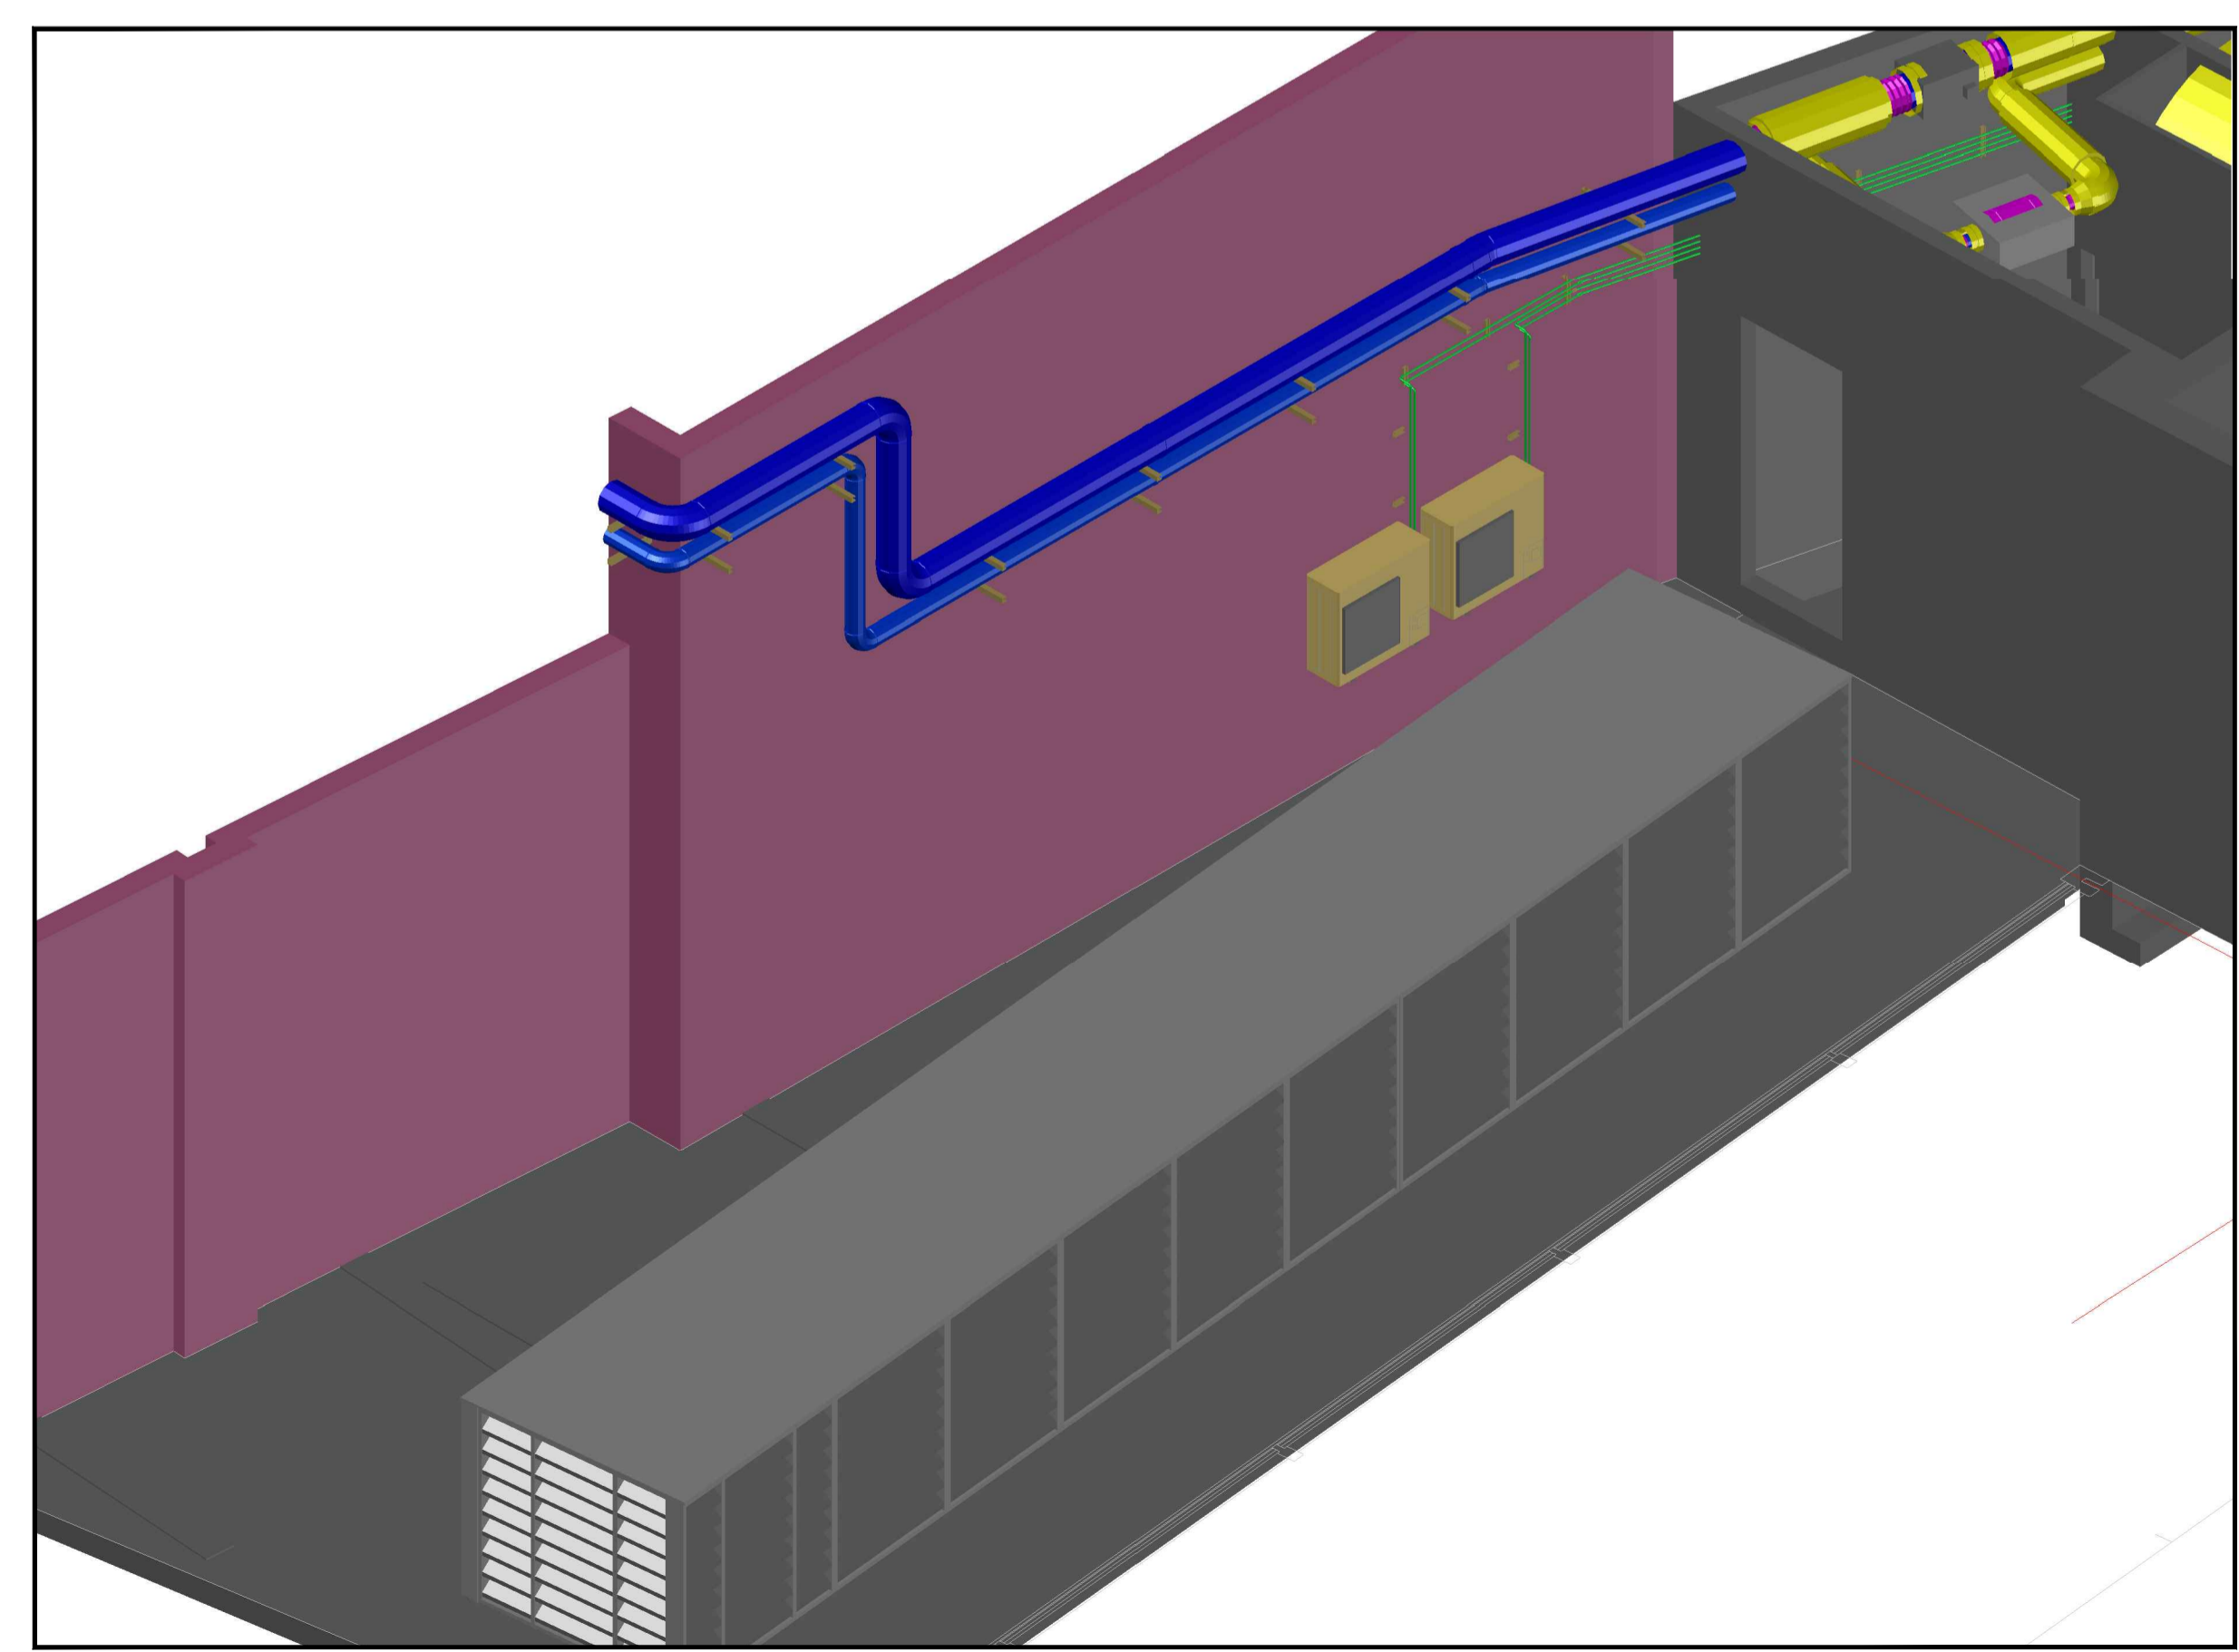

**ISOMETRIC VIEW 'A'**

**DO NOT SCALE THIS DRAWING**

- GENERAL NOTES:-
- DO NOT SCALE FROM THIS DRAWING. ALL DIMENSIONS MUST BE CHECKED / VERIFIED ON SITE.
  - ALL DIMENSIONS IN MILLIMETERS UNLESS OTHERWISE STATED.
  - THIS DRAWING TO BE READ IN CONJUNCTION WITH THE LATEST ARCHITECTURAL, STRUCTURAL & BUILDING SERVICES DRAWINGS.
  - THIS DRAWING TO BE READ IN CONJUNCTION WITH ALL THE LATEST SCHEMATICS, SPECIFICATIONS & SCHEDULES.
  - ANY DISCREPANCIES NOTED ON SITE ARE TO BE REPORTED TO THE ENGINEER IMMEDIATELY

**NOTES**

DRAWINGS TO BE READ IN CONJUNCTION WITH:

- DRAWING NO:- 6000-DR-M115  
LIGHT WELL EXISTING / REDUNDANT CONDENSERS TO BE REMOVED LAYOUT & SECTIONS
- DRAWING NO:- 6000-DR-M111  
LIGHT WELL EXISTING AND NEW SERVICES LAYOUT & SECTIONS

**DRAWING STATUS**  
**FOR INFORMATION**

DATE	REVISION	No.
30/08/18	ISSUED FOR INFORMATION	0

**CONTRACT**  
200 GRAYS IN ROAD

**TITLE**  
LIGHT WELL NEW CONDENSERS / EXTRACT DUCTWORK LAYOUT & SECTIONS

**ARCHITECT**  
CONRAN & PARTNERS

**CONSULTANT**  
N.D.Y DESIGN CHECKED BY MALA

**MALA** 9 Hewett Street,  
London EC2A 3NN  
Tel: 020 7456 1200  
Fax: 020 7456 1201  
Email: mala@mala.co.uk

SCALE 1:25 & 1:50	DATE 02/08/18	
DRAWN WB	DRG No. 6000-DR-M116	0