 



Basement Floor Plan

1 : 100

LIGHTING LEGEND				LUMENS	WATTAGE	QUANTITY	CONTROL
	A	LUNA L6 1200LM - WALL MOUNTED AT 3.2M		1205	14	18	TIMECLOCK / PHOTOCCELL
	B	LUNA L4 1300LM - WALL MOUNTED AT 3.2M		1307	14	7	TIMECLOCK / PHOTOCCELL

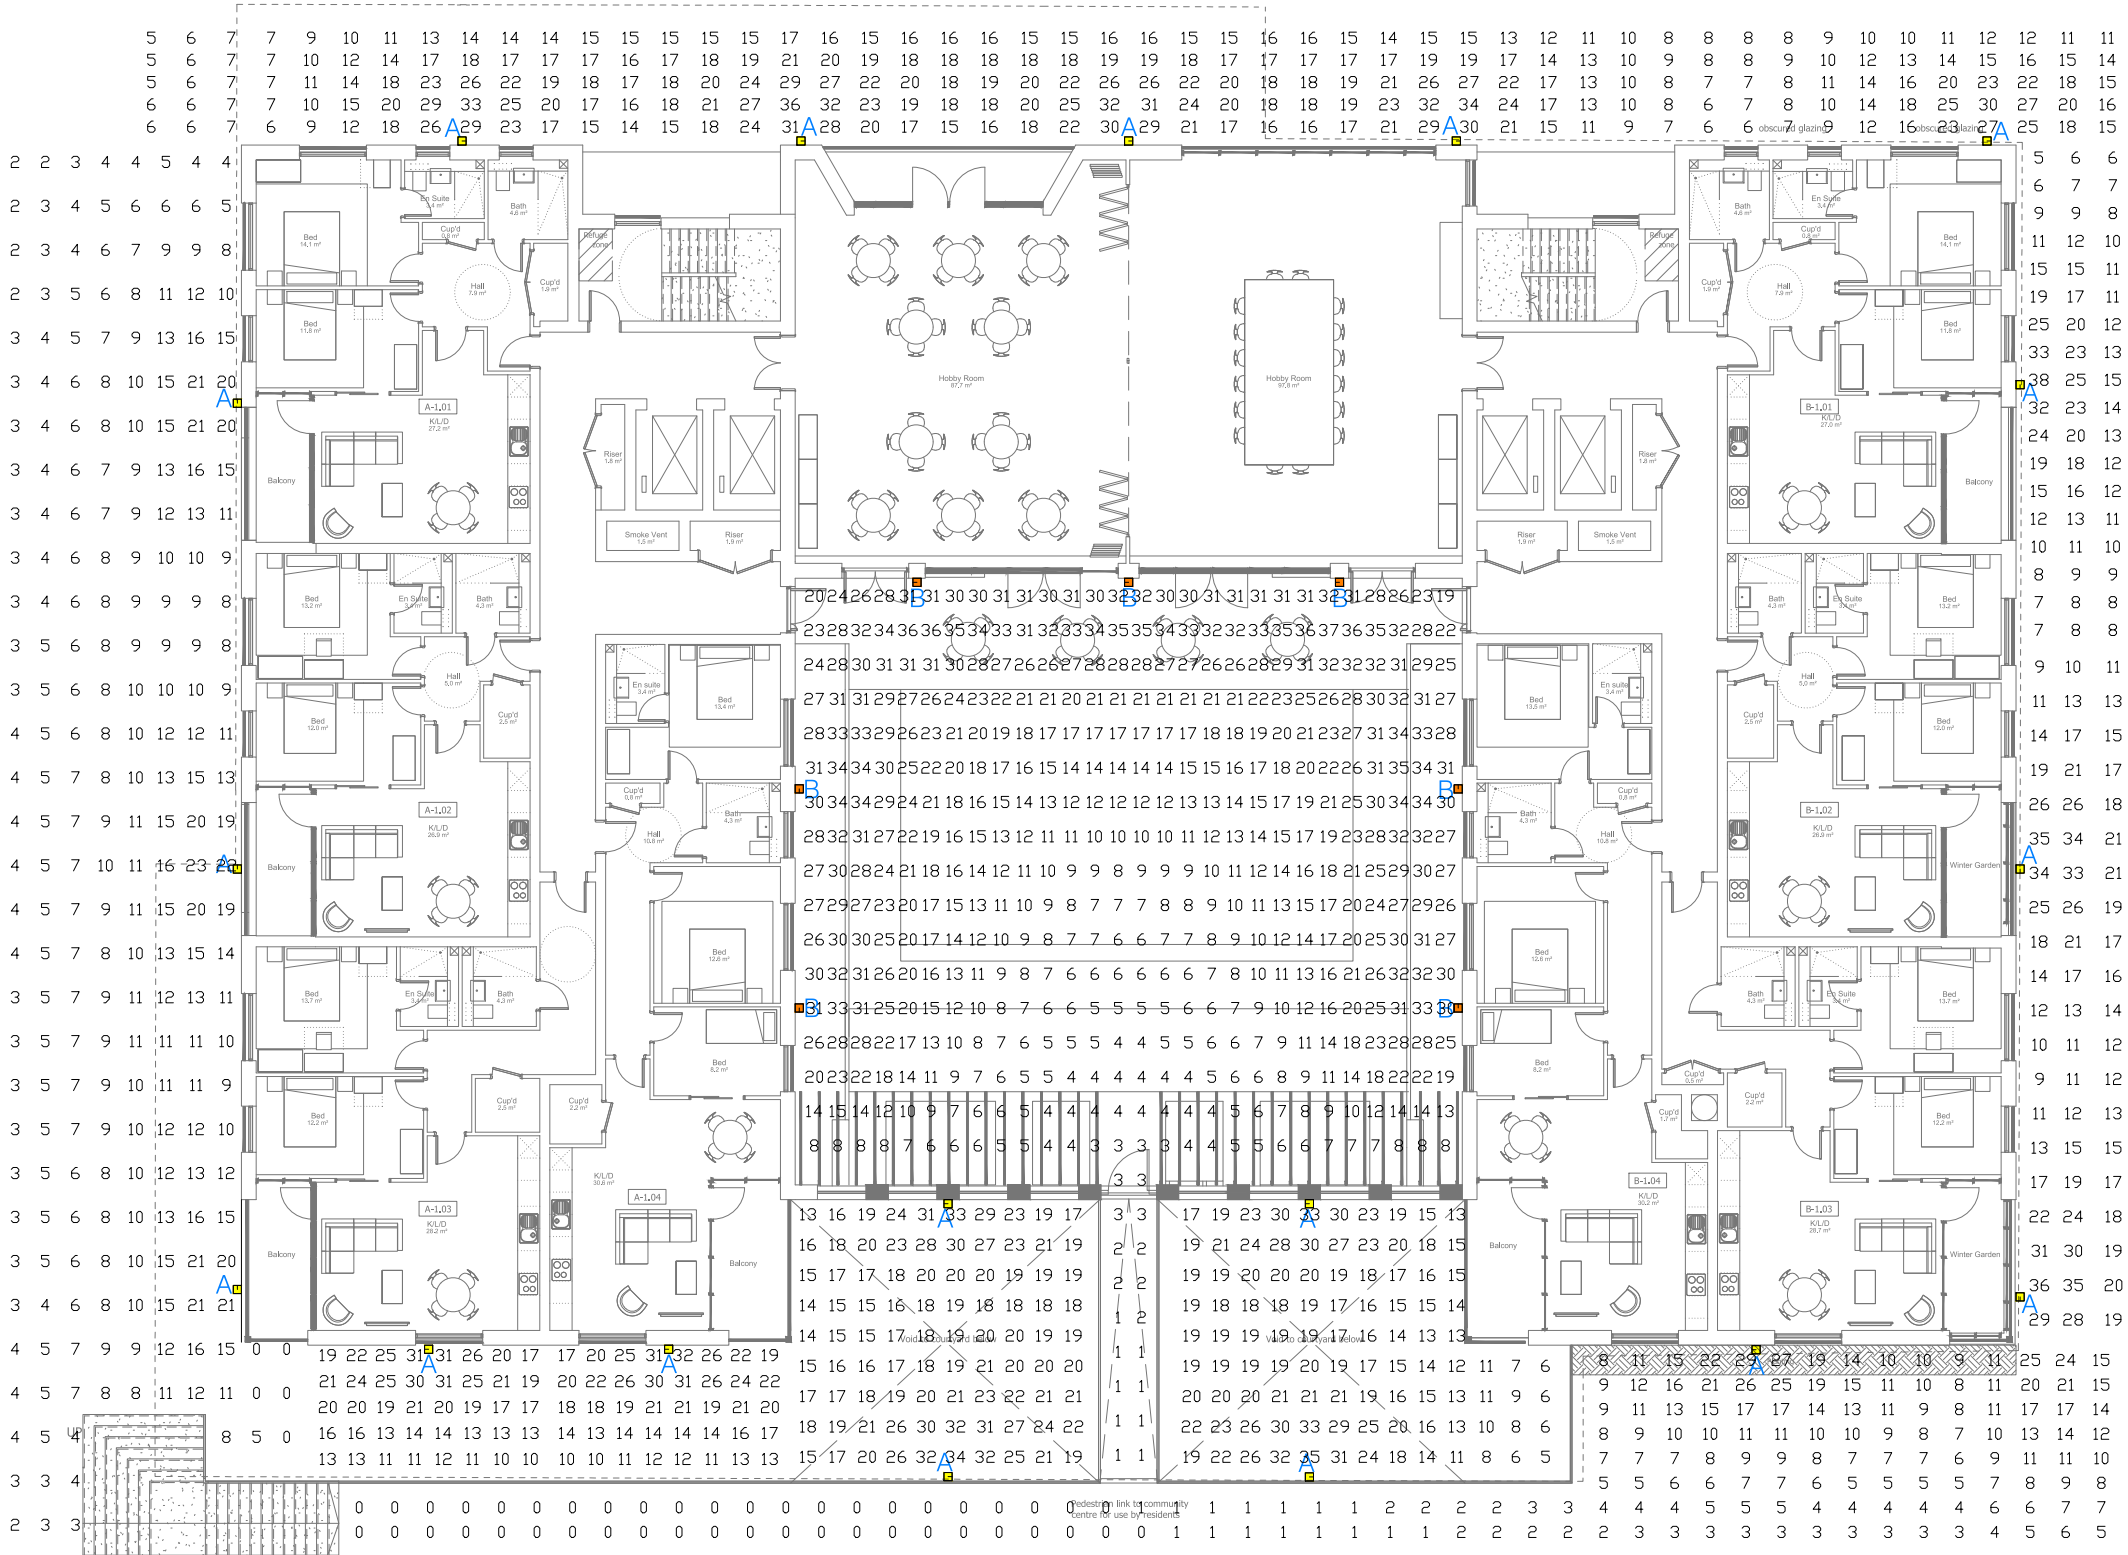

P	05.06.18	PLANNING ISSUE	AK	DM	
Rev	Date	Revision	Drawn	CK'd	
Client					
Project					
ASSISTED LIVING DEVELOPMENT INGESTRE ROAD, CAMDEN					
Drawing Title					
PROPOSED BUILDING EXTERNAL LIGHTING					
McKee Associates Ltd Unity House Westwood Park Wigan WN3 4HE Web : www.mckeeassociates.co.uk					
Cad Drawn	MS	Date	JUNE 2018	Scale	1:100 @ A1
Checked	DM	Date	JUNE 2018	Rev.	P
Dwg No :		P0097 EX (60) 001			