


Important notes for electrical contractor

All directional light fittings to be angled by electrical contractor onto product/ displays/ artwork/ tables/ other in accordance with the lighting drawing/ any designer or client instructions. This must be carried out in advance of the final lighting commissioning/ any programming visit by the lighting consultant/ dimming engineer. Into Lighting do not carry out any works at high level. Where DMX control is shown on the lighting layout the DMX control cabling should be wired in a daisy-chain using Belden 9841 cable, the maximum cable length from the source of the DMX output to the furthest DMX driver is 250m. A maximum of 32 DMX units can be connected to each DMX universe. If you have any questions about how to wire the DMX signal cable please contact Into on 0845 873 7013 or at technical@into.co.uk

Important note for emergency lighting design and specification

Where Into Lighting drawings show layouts for emergency lighting these are provisional layouts to help ensure sympathetic integration into the architecture and general lighting scheme. It is the responsibility of the mechanical and electrical consultant/ contractor to ensure that the emergency lighting scheme and specification meets with BS5266 and any local requirements. Where Into Lighting drawings do not show provisional layouts for emergency lighting it is the responsibility of the mechanical and electrical consultant/ contractor to provide the layout and specification.

It is the responsibility of the installing electrical contractor/ consultant to ensure the appropriate specification, supply and install of fire and/or acoustic hoods / down lights where required. The specification should meet with the specific site requirements, be fully compatible with any down lights specified and be installed in accordance with the manufacturers guidelines.

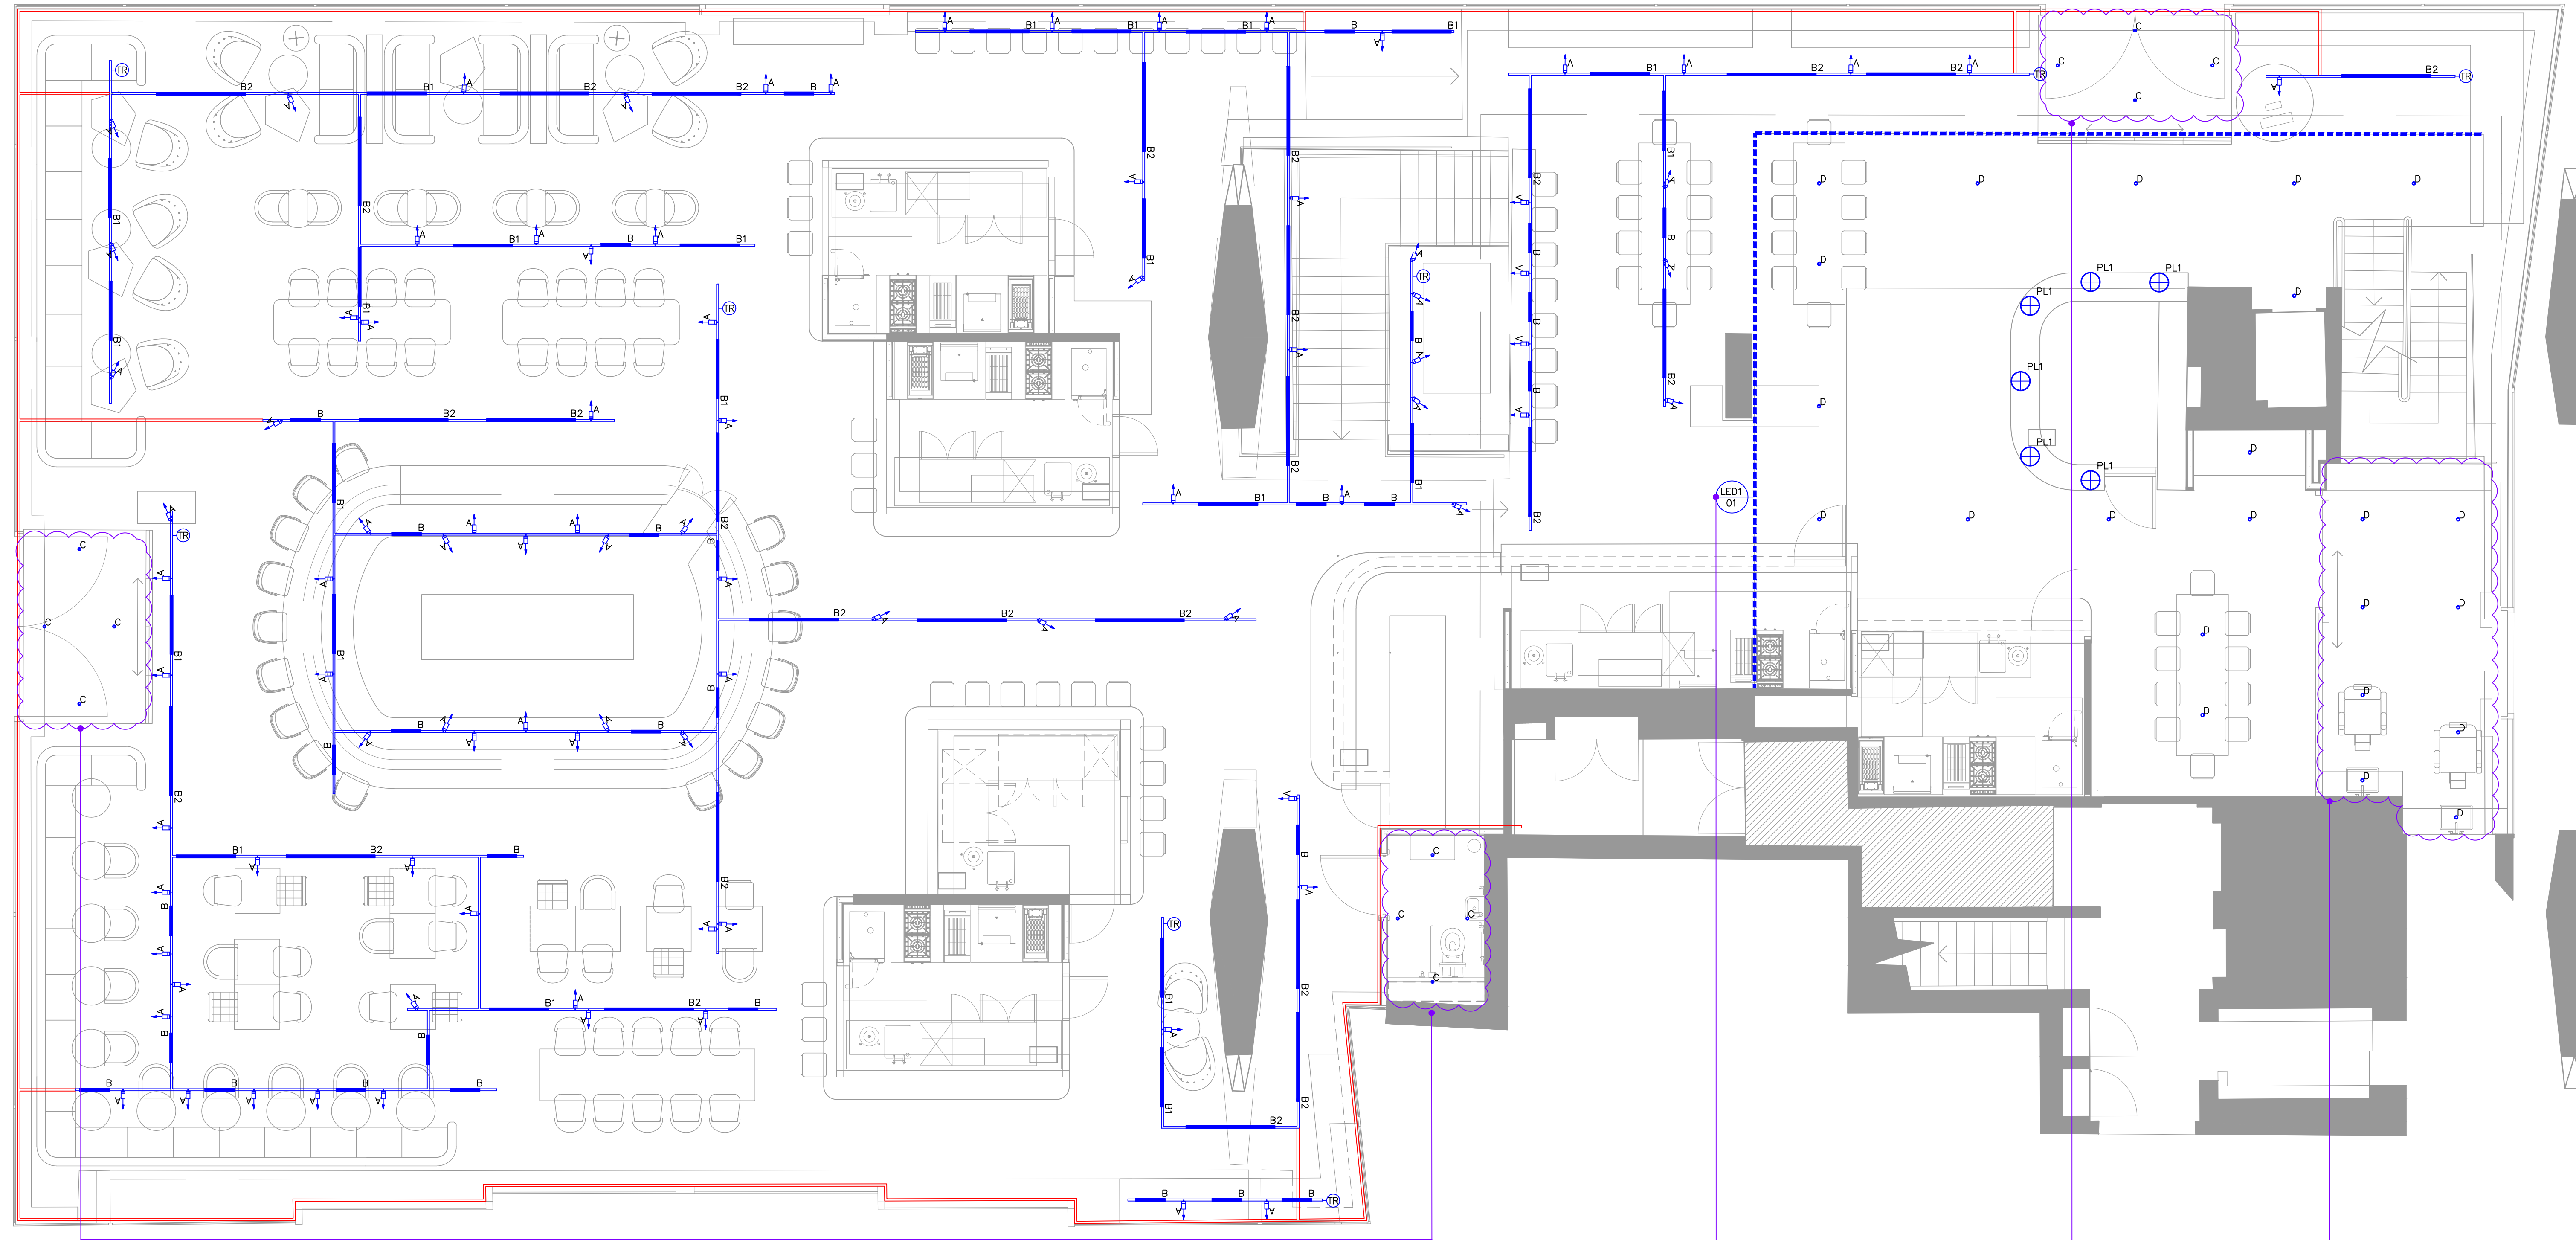

NOTE:
EXACT POSITIONS OF LIGHTING ARE TO BE CONFIRMED.
DEPENDANT ON INFORMATION FROM THE INTERIOR DESIGNER
& LIGHTING CALCULATIONS.

TYPE: C
SURFACE MOUNTED ADJUSTABLE
SPOTLIGHTS MOUNTED TO ON TOP OF
THE FALSE CEILING TO ILLUMINATE TO
ARTWORK. EXACT LOCATION /DETAIL TO
BE CONFIRMED.

TYPE: LED1.01
SURFACE MOUNTED LINEAR LUMINAIRE
CONCEALED WITHIN MEZZANINE
BALUSTRADE WASHING UP. EXACT
LOCATION / DETAIL TO BE CONFIRMED.

TYPE: C
SURFACE MOUNTED ADJUSTABLE
SPOTLIGHTS MOUNTED TO ON TOP OF
THE FALSE CEILING TO ILLUMINATE TO
ARTWORK. EXACT LOCATION /DETAIL TO
BE CONFIRMED.

NOTE:
LIGHTING WITHIN THIS AREA IS TO BE
CONFIRMED.

INTO LIGHTING LEGEND									
	TRACK MOUNTED ADJUSTABLE SPOTLIGHT C/W 240V 9W LED		TRACK MOUNTED LINEAR LUMINAIRE C/W 240V 26W LED PER 920MM		SURFACE MOUNTED ADJUSTABLE SPOTLIGHT C/W 500MA 7W LED		SURFACE MOUNTED LINEAR LUMINAIRE C/W 24V 13.2W LED		SUSPENDED 3 CIRCUIT TRACK
	TRACK MOUNTED LINEAR LUMINAIRE C/W 240V 13W LED PER 460MM		TRACK MOUNTED LINEAR LUMINAIRE C/W 240V 38W LED PER 1380MM		RECESSED ADJUSTABLE DOWNLIGHT C/W 700MA 2.4W LED		SUSPENDED FEATURE PENDANT – FITTING TO BE CONFIRMED		PERIMETER LIGHTING TROUGH TO ARCHITECTS DETAIL

Symbols in key are not to scale

PROVISIONAL ONLY

Rev C

Rev B

Rev A GENERAL REVISION

Project Title STREET MARKETS LTD, CENTRE POINT, LINK BUILDING, W1			Drawing Title PROVISIONAL LIGHTING LAYOUT – GROUND FLOOR RCP		
Date 11.09.18	Drawn CM	Scale 1:50 @ A1	Project 12561	Number C01	Revision A

into

into Lighting Ltd
4 O'Meara Street
London
SE1 1TE
T: +44 (0) 845 873 7013
F: +44 (0) 845 873 7018
E: email@into.co.uk

This drawing and all associated documents issued for the purposes of design information remain the intellectual property of into Lighting Limited.
The drawing and all associated documents are information developed from their contents may not be distributed to third parties without prior consent from into Lighting Limited. In the event that this occurs, into Lighting Limited reserves the right to remove a design from the drawing and to take any action deemed appropriate.
All dimensions must be checked on site
Do not scale from this drawing