


Folded Aluminium face panel finished to RAL 6009
 330mmH opal acrylic inlay letters illuminated
 82mmH opal acrylic inlay letters illuminated
 Fascia and shopfront painted RAL 6009
 Standard external weather louvre finished to RAL 6009

D-G-01

W-G-01

7200mm x 800mm x 100mm external illuminated sign, comprising an aluminium sign case finish RAL 6009, housing white LED modules & transformer.
 Sign face to have fret cut apertures, back with white opal acrylic.
 Letter only to illuminate. Estimated brightness 150-200 cd/m²


Aluminium sign case finished RAL 6009
 5mm thick opal acrylic sign panels with lettering only to illuminate
 Internal white LED modules

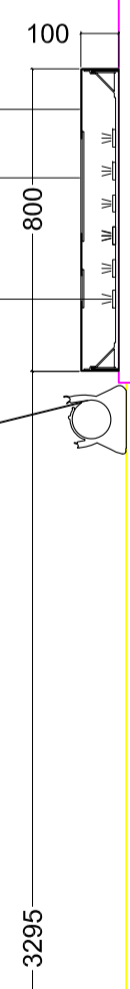

NOTE : DDC to confirm existing levels on site

Pavement level at side entrance
 EFL +34.360 AOD

 Pavement level at front entrance
 EFL +34.13 AOD



Job Number:	HK3213-P5	Drawn By:	JT	Scale:	1:20@A1
Drawing Title:	Planning Details 10 - Shopfront Signage	Date:	21/09/2018	Revision:	B
Revision Notes:					
REV A - JT 06/09/18					
• Amended annotation type					
• Amended postcode type					
REV B - JT 21/09/18					
• Omitted exterior cart					
Job Title:	Naturally Ltd				
Site Address:	259 Kentish Town Road, London, NW5 2JT				
Notes: Any discrepancies are to be reported to HK Interiors immediately. Contractor/Manufacturer to check all dimensions on site. Do not rescale this drawing. This drawing is copyright of HK Interiors. Copyright is reserved and the drawing should not be copied, related or reproduced in any part without prior written consent.					

Section 1-1 - Shop Front
 Scale 1:20 @ A1