

This drawing is the property of Giasullo Engineering. Copyright is reserved to them and the drawing is issued on the condition that it is not copied, either wholly or in part, without the written consent of Giasullo Engineering.

All Dimensions to be checked and verified on site prior to the commencement of any work. No construction is to be conducted based on these drawings.

GIASULLO ENGINEERING LTD

26 heyford Avenue
London, SW8 1ED
www.giasulloengineering.co.uk


DRAWING STATUS
APPLICATION

CLIENT
RITORNO
30 Great Queen Street WC2B 5BB
London

PROJECT TITLE
RITORNO RESTAURANT
COVENT GARDEN

DRAWING TITLE
Proposed Floor-plan
PLAN PROPOSED FINAL HIGH
LEVEL LIGHTING

PROJECT NO.	SCALE
104	1/50 @ A1 1/100 @ A3
DATE	DRAWN
26.09.2018	SD
DRAWING NO.	APPROVED
104-PL-08	FG
	REVISION
	1

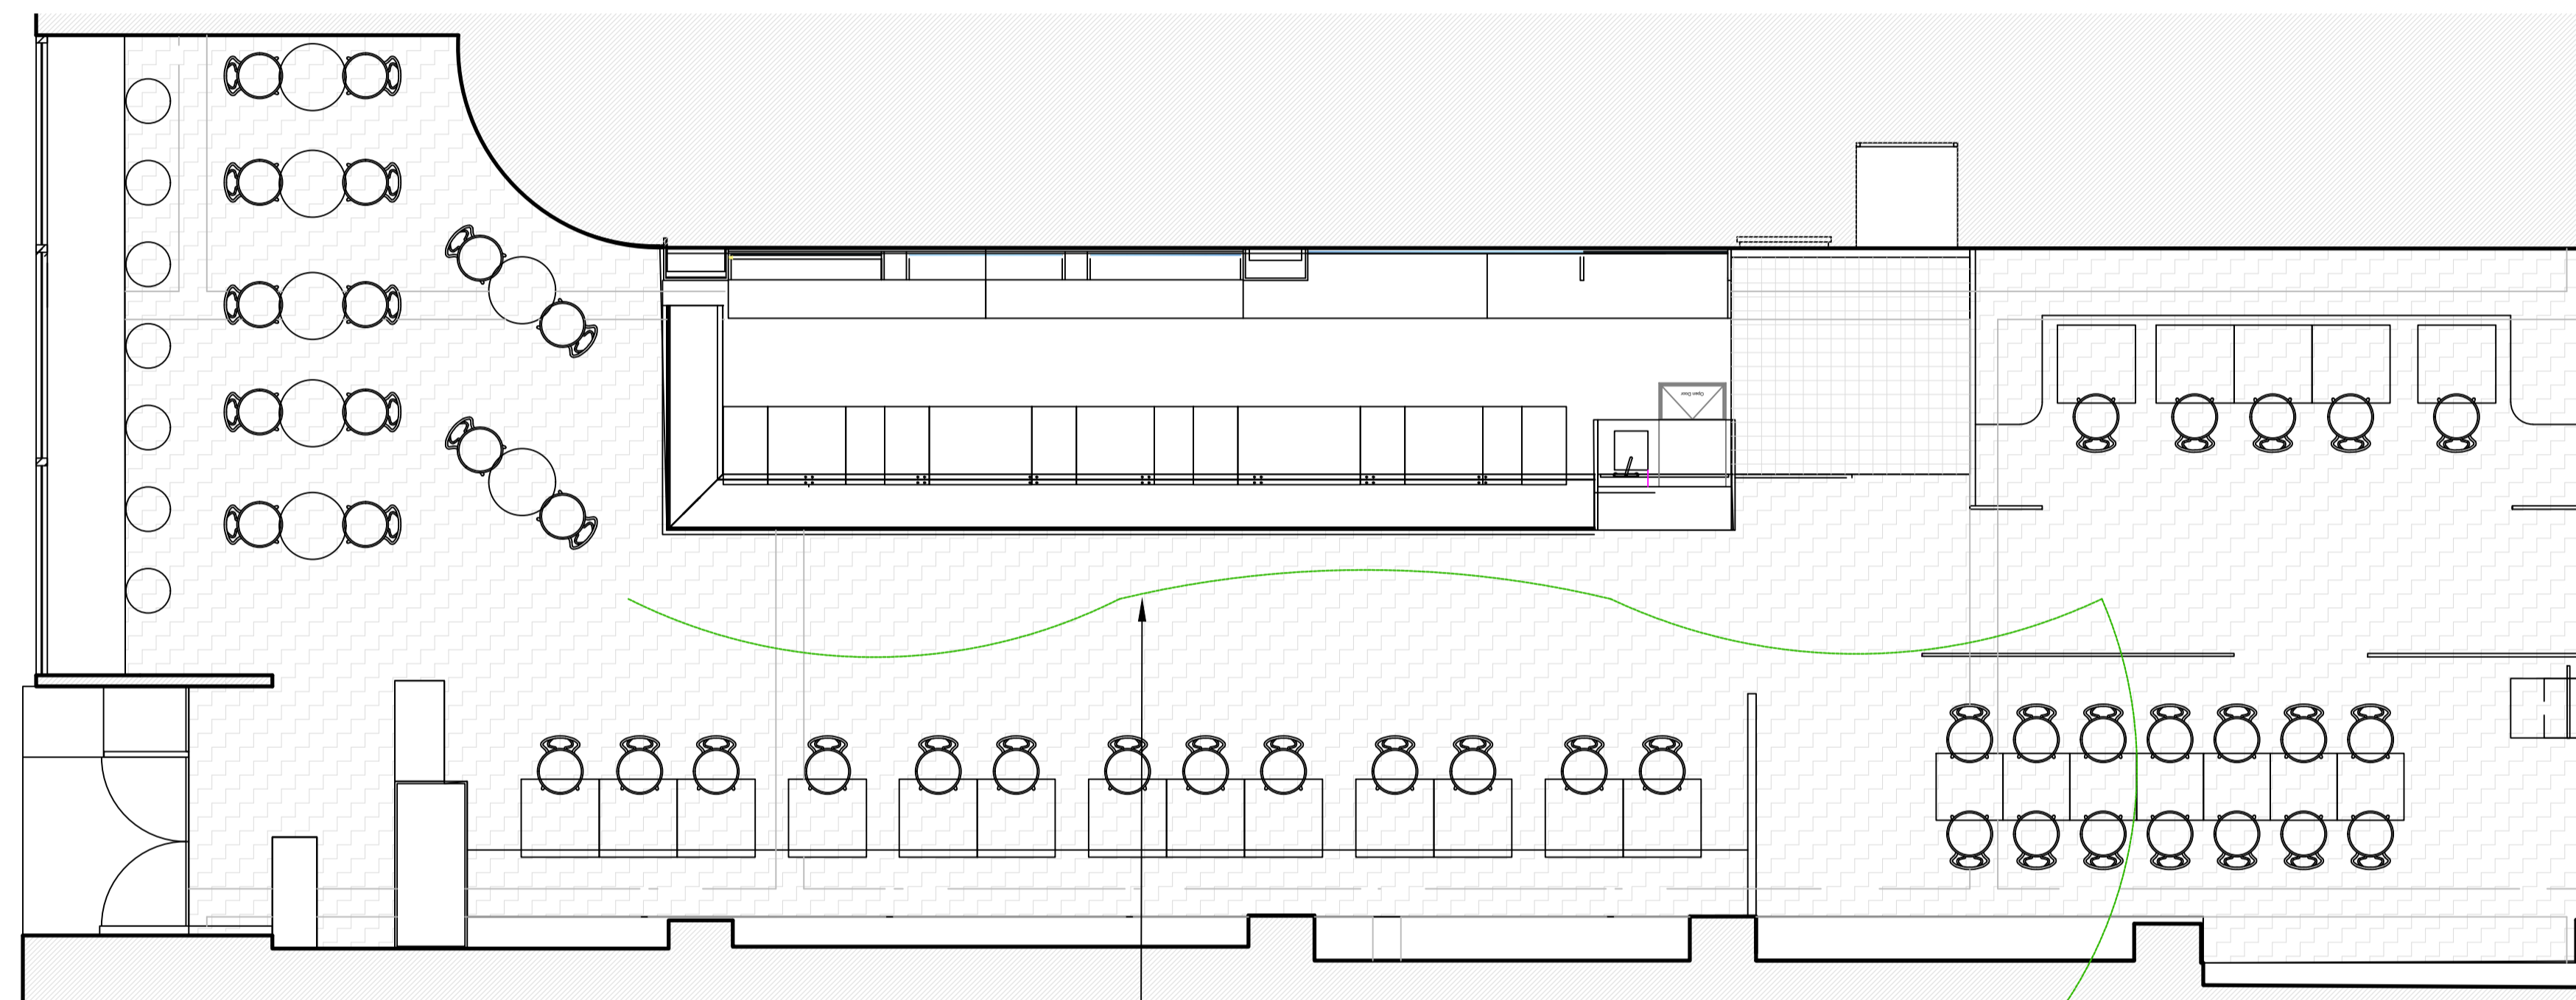

**EXISTING
DOWNLIGHTS TO BE
RETAINED**

1 Ground Floor Plan
Scale 1:50@A1

LP1- DIMMABLE
CEILING FLUSH
MOUNTED LIGHT
REFER TO FF&E
SCHEDULE

LP1
C-03

