


0m 1m 2m 3m 4m 5m
1:50 scale

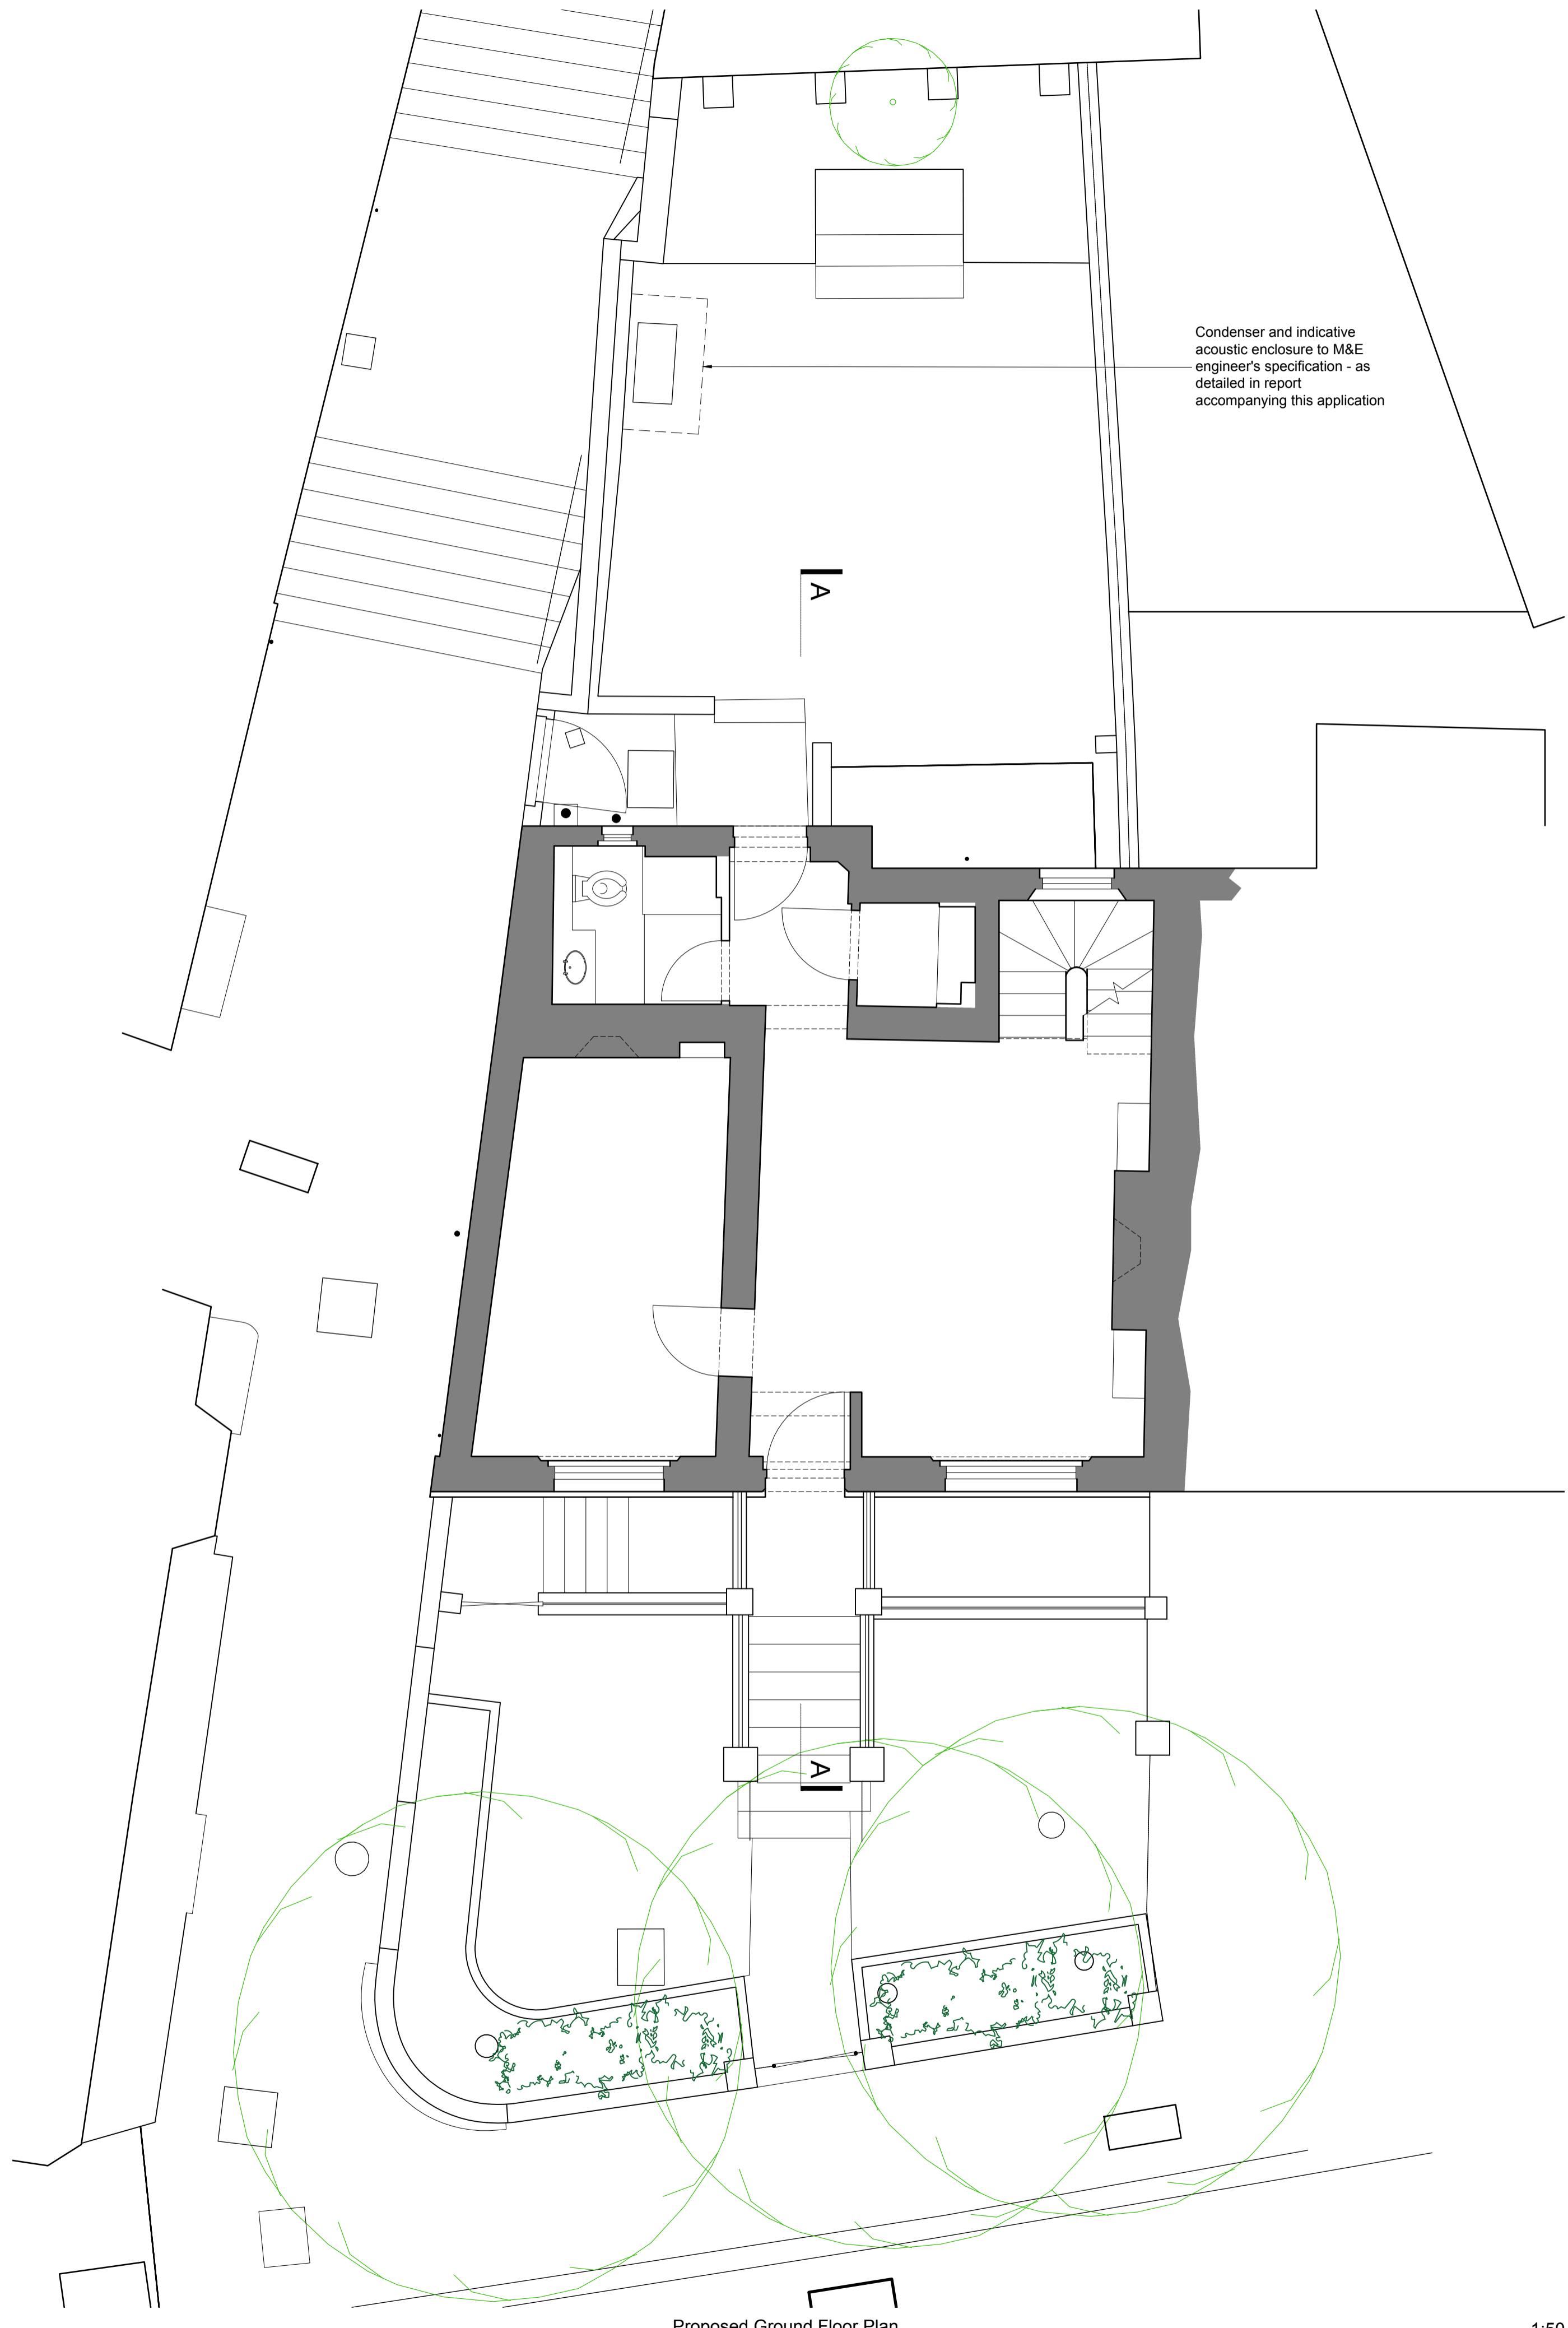


Condenser and indicative acoustic enclosure to M&E engineer's specification - as detailed in report accompanying this application

A

A

Proposed Ground Floor Plan

1:50

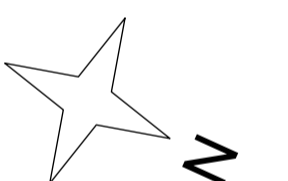

ALL DIMENSIONS APPROXIMATE

SCHEME DESIGN SUBJECT TO STRUCTURAL ENGINEER /SERVICES ENGINEER, & PLANNERS COMMENT

FOR PLANNING

Description

BB PARTNERSHIP LTD
CHARTERED ARCHITECTS

Studios 33-34, 10 Hornsey St, London, N7 8EL
Tel 020 7336 8555 - e-mail - architect@bbpartnership.co.uk

client
Andrew and Michaela Saffrin

project
1 The Mount
Hampstead
NW3 6SZ

drawing
Proposed Ground Floor Plan

date	scale	drawn by
Oct 18	1:50@A1/1:100@A3	MC

drg.no.	revision
FWG_1020	-

© 2018 BB PARTNERSHIP LIMITED - ALL RIGHTS RESERVED
DO NOT SCALE - CHECK ALL DIMENSIONS ON SITE