




Do Not Scale.
All Figured Dimensions To Be Checked On Site Prior To Construction.
All Copyright Reserved.

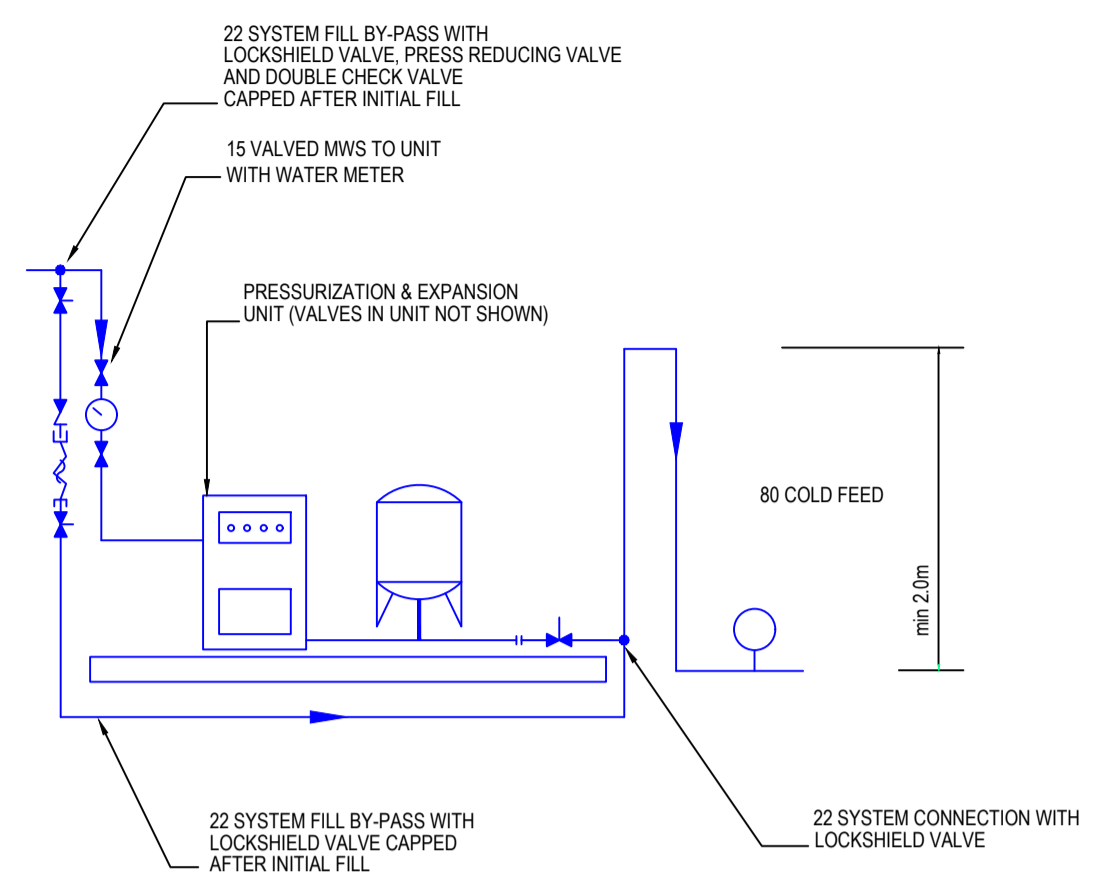


SCHEMATIC 1:
PRESSURISATION UNIT
ARRANGEMENT LPHW/CHW/COND.
WATER

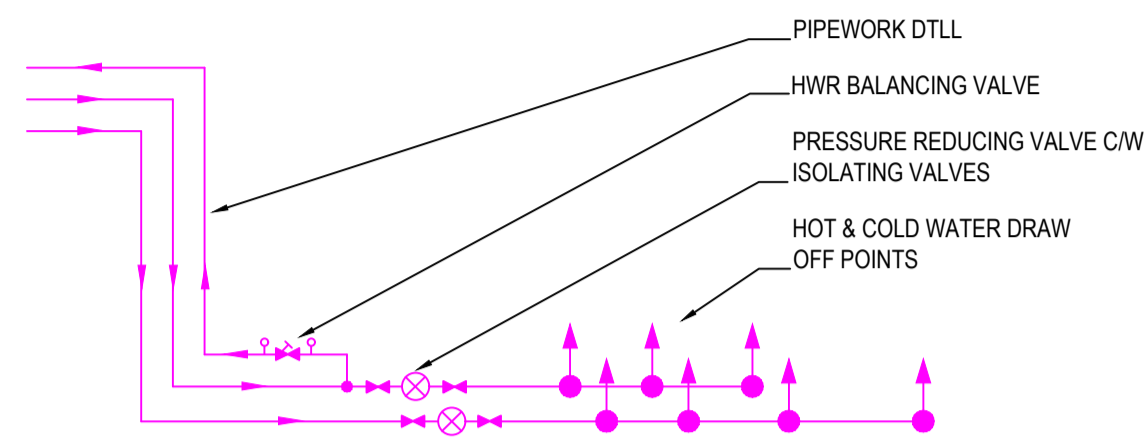

SCHEMATIC 2:
THIS ARRANGEMENT SHALL BE
PROVIDED FOR ALL H&CWS SINGLE
OR MULTI-POINT DRAW-OFF POINTS

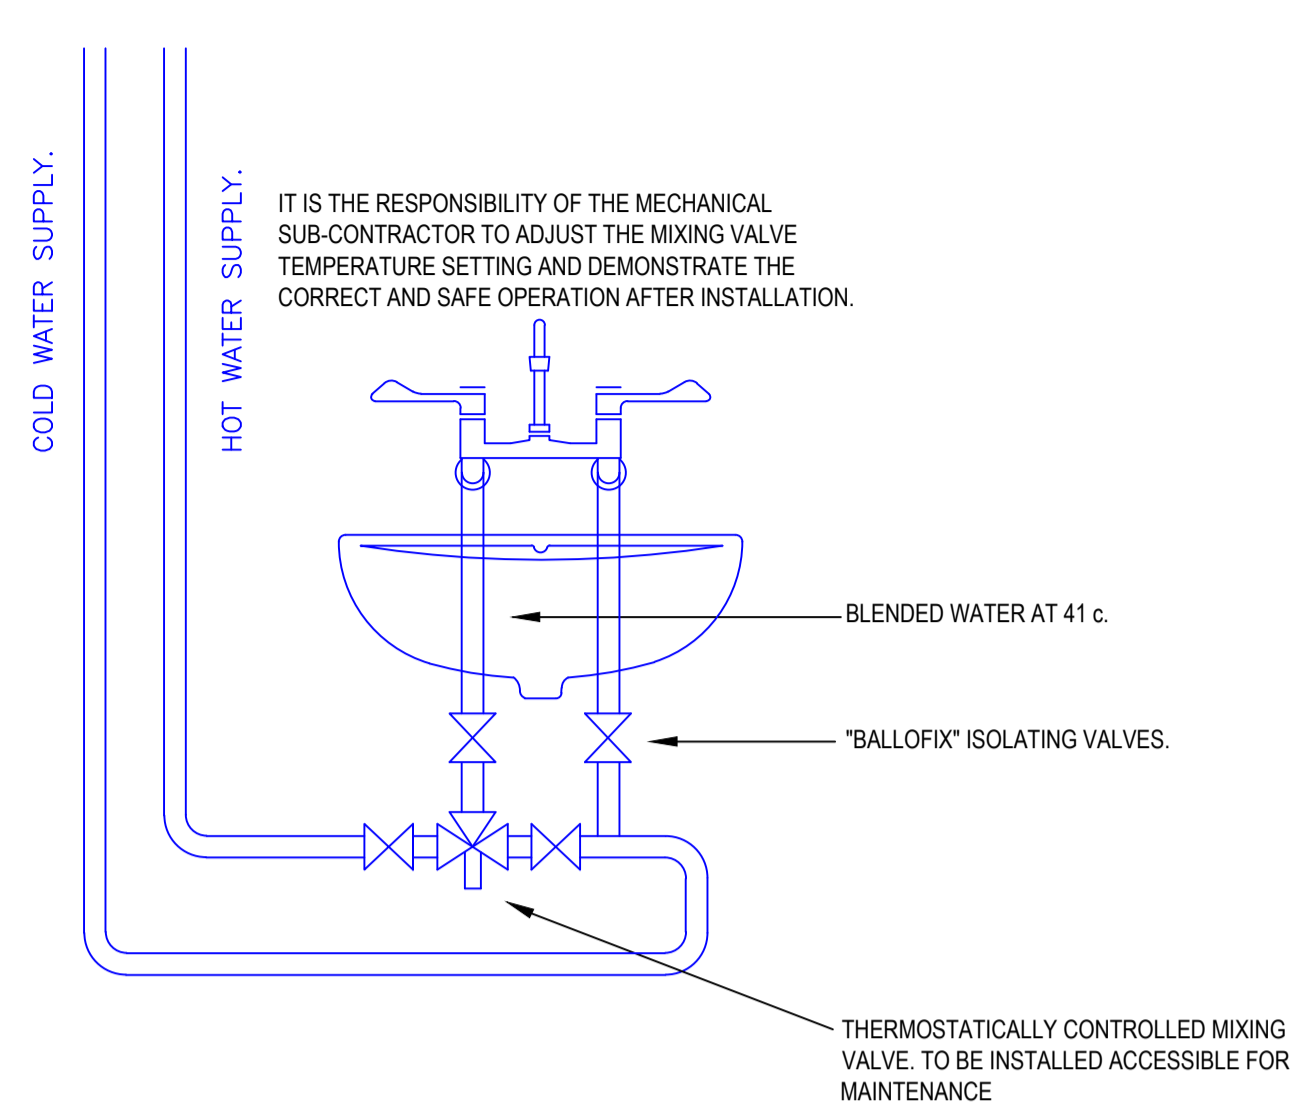


SCHEMATIC 3:
THERMOSTATIC MIXING VALVE
DETAIL

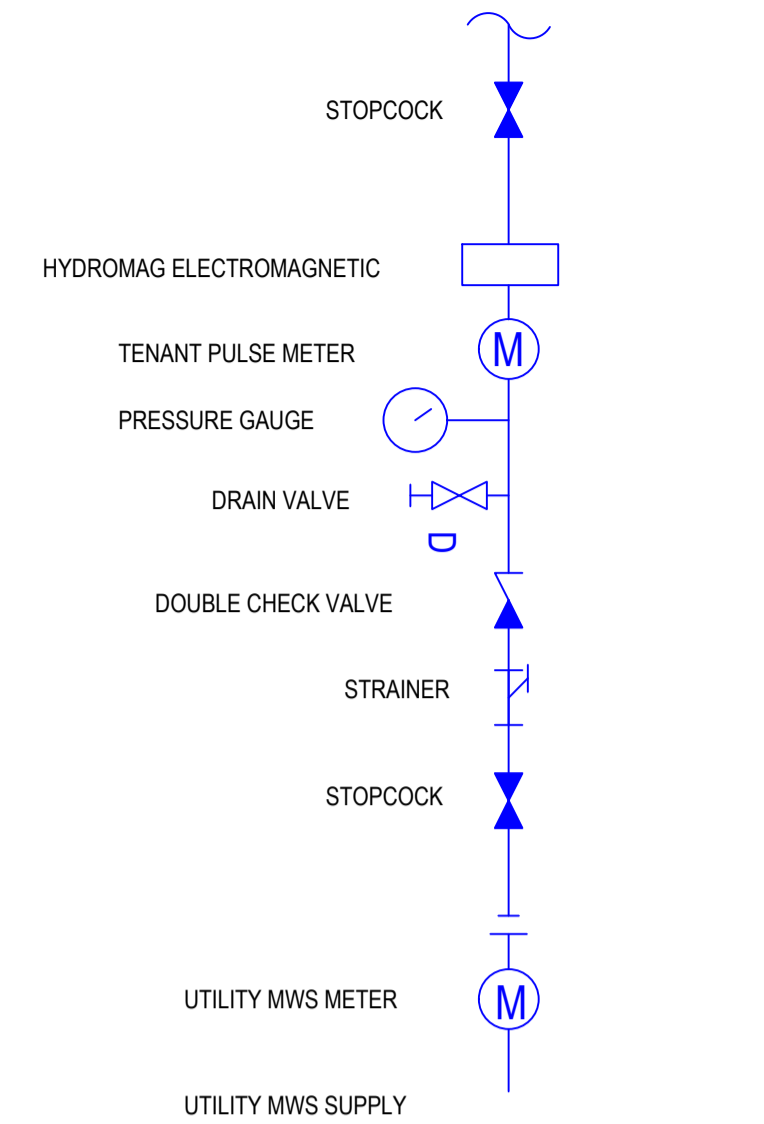


SCHEMATIC 4:
VALVE ARRANGEMENT ON INCOMING
LANDLORD SUPPLIES


GENERAL NOTES:
1. ALL SERVICES/ROUTES THROUGHOUT BUILDING TO BE FULLY CO-ORDINATED ON SITE.
2. DRAWING TO BE READ IN CONJUNCTION WITH MECHANICAL INSTALLATION SPECIFICATION AND ALL OTHER RELEVANT DRAWINGS.

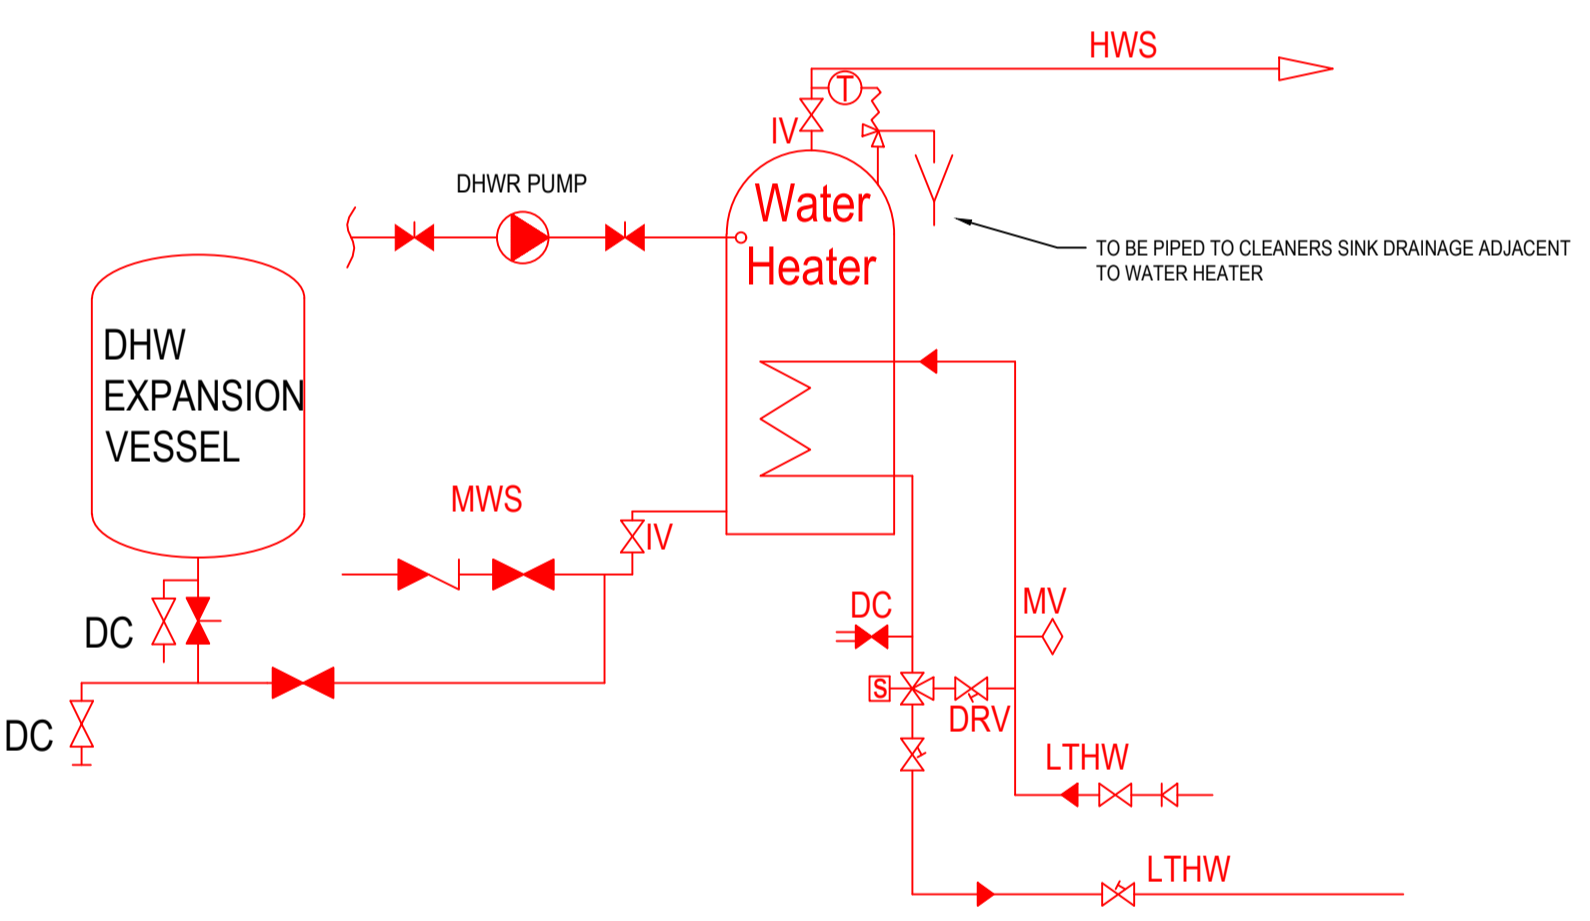


SCHEMATIC 5:
TYPICAL CYLINDER DETAIL

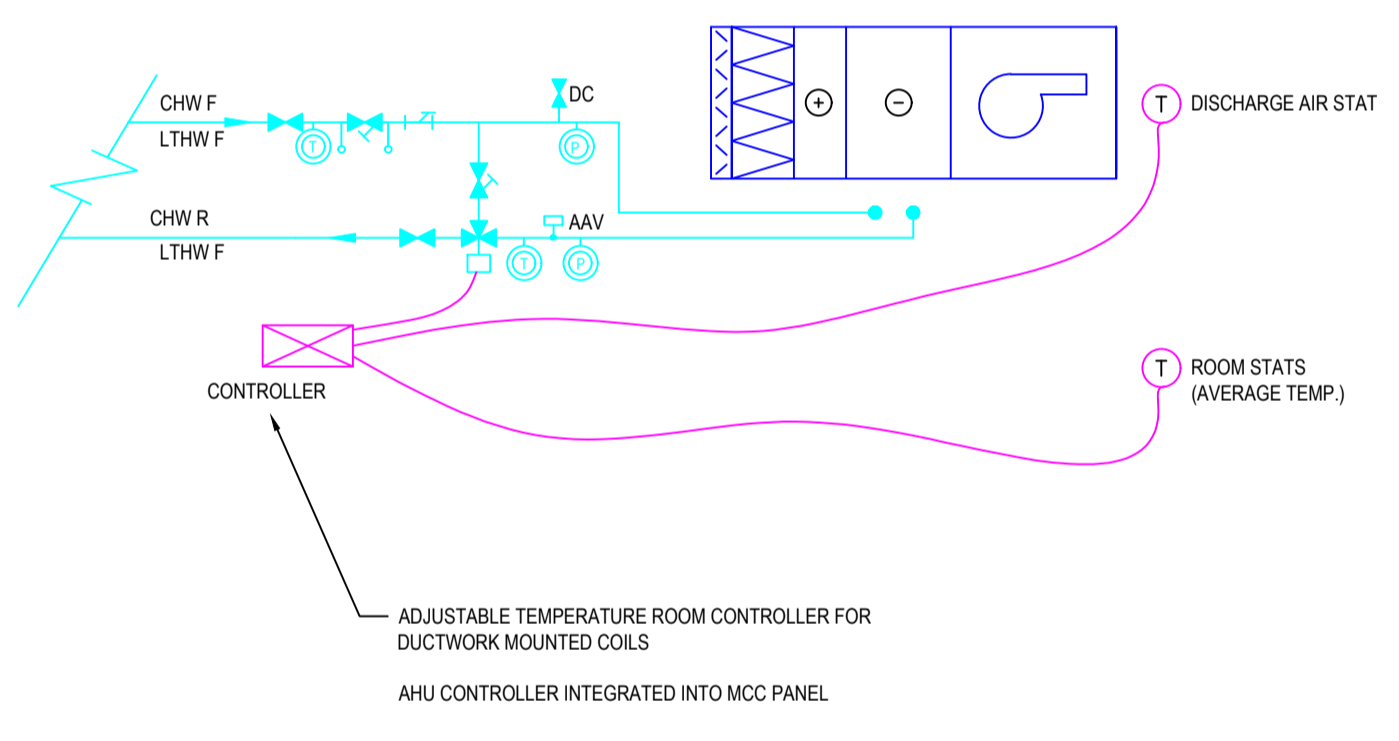


SCHEMATIC 6:
TYPICAL HEATER BATTERY / COOLING COIL DETAIL

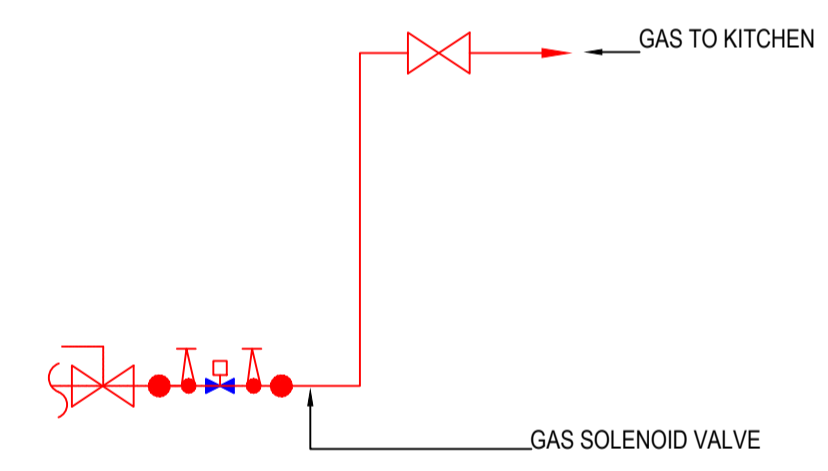

SCHEMATIC 10:
GAS SCHEMATIC

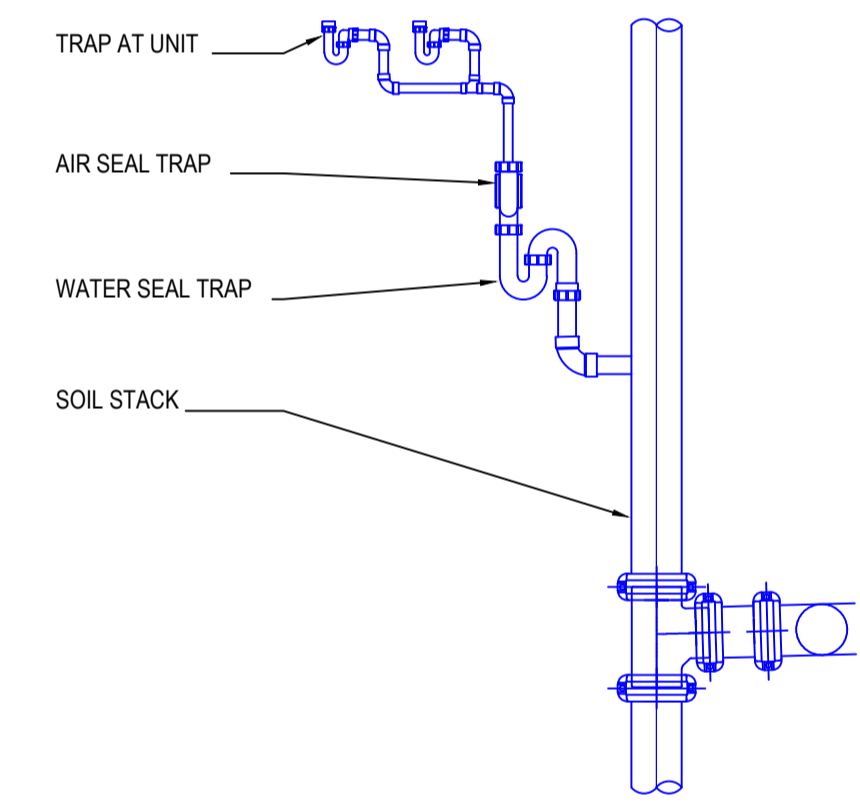

SCHEMATIC 11:
TYPICAL CONDENSATE DETAIL

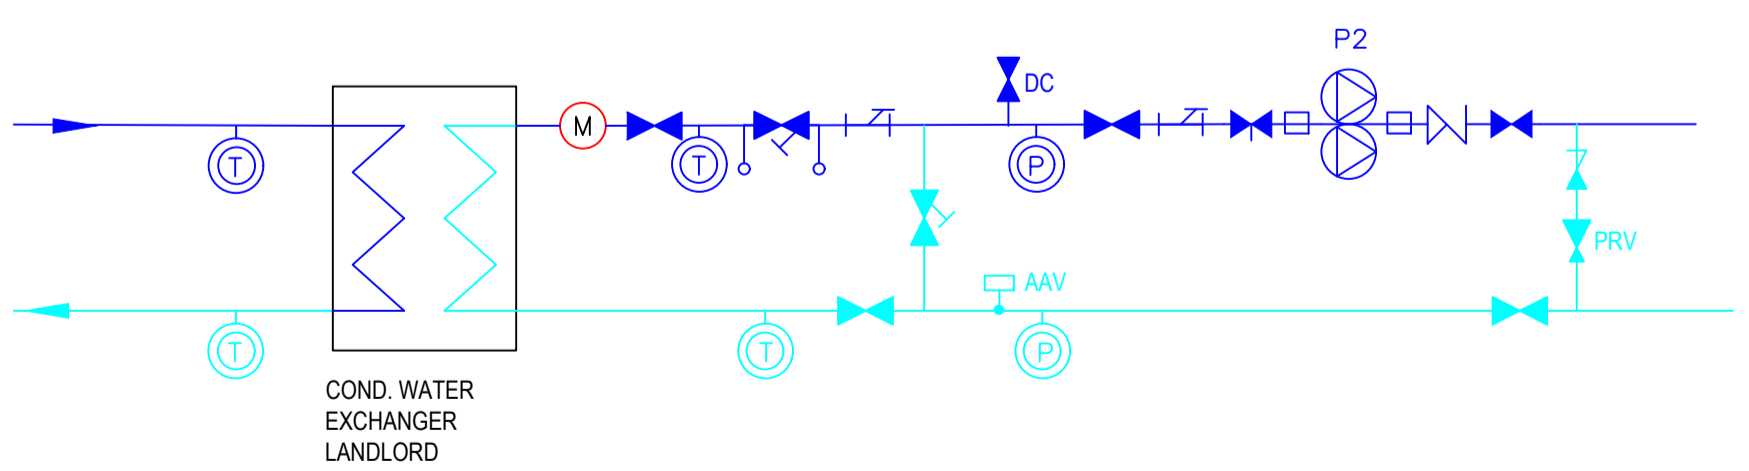

SCHEMATIC 9:
COND. WATER CONNECTION TO LANDLORD SYSTEM

A	TENDER ISSUE	H/N	28/09/2018
REV	DETAILS	BY	APP DATE

CLIENT: **STREET MARKETS LTD**

PROJECT: **CENTRE POINT, LINK BUILD. W1**

DRAWING TITLE: **MECHANICAL DETAILS**

DRAWN BY: H.NISIC	APPROVED BY:	DATE: SEP'18
PROJECT No.: L2171	DRAWING No.: M020	SCALE: NTS



LEHNDING SERVICES DESIGN LTD
Unit 10, 10 Redlands Crescent, Laine, Co. Antrim, N. Ireland. BT40 1FF. Tel: +44(0) 2838 277 123.
Global House, Ashley Avenue, Epsom, London, KT18 5AD. Tel: +44(0) 1372 253 207.
Web: www.lehding.co.uk Email: info@lehding.co.uk