

DO NOT SCALE check all dimensions on site












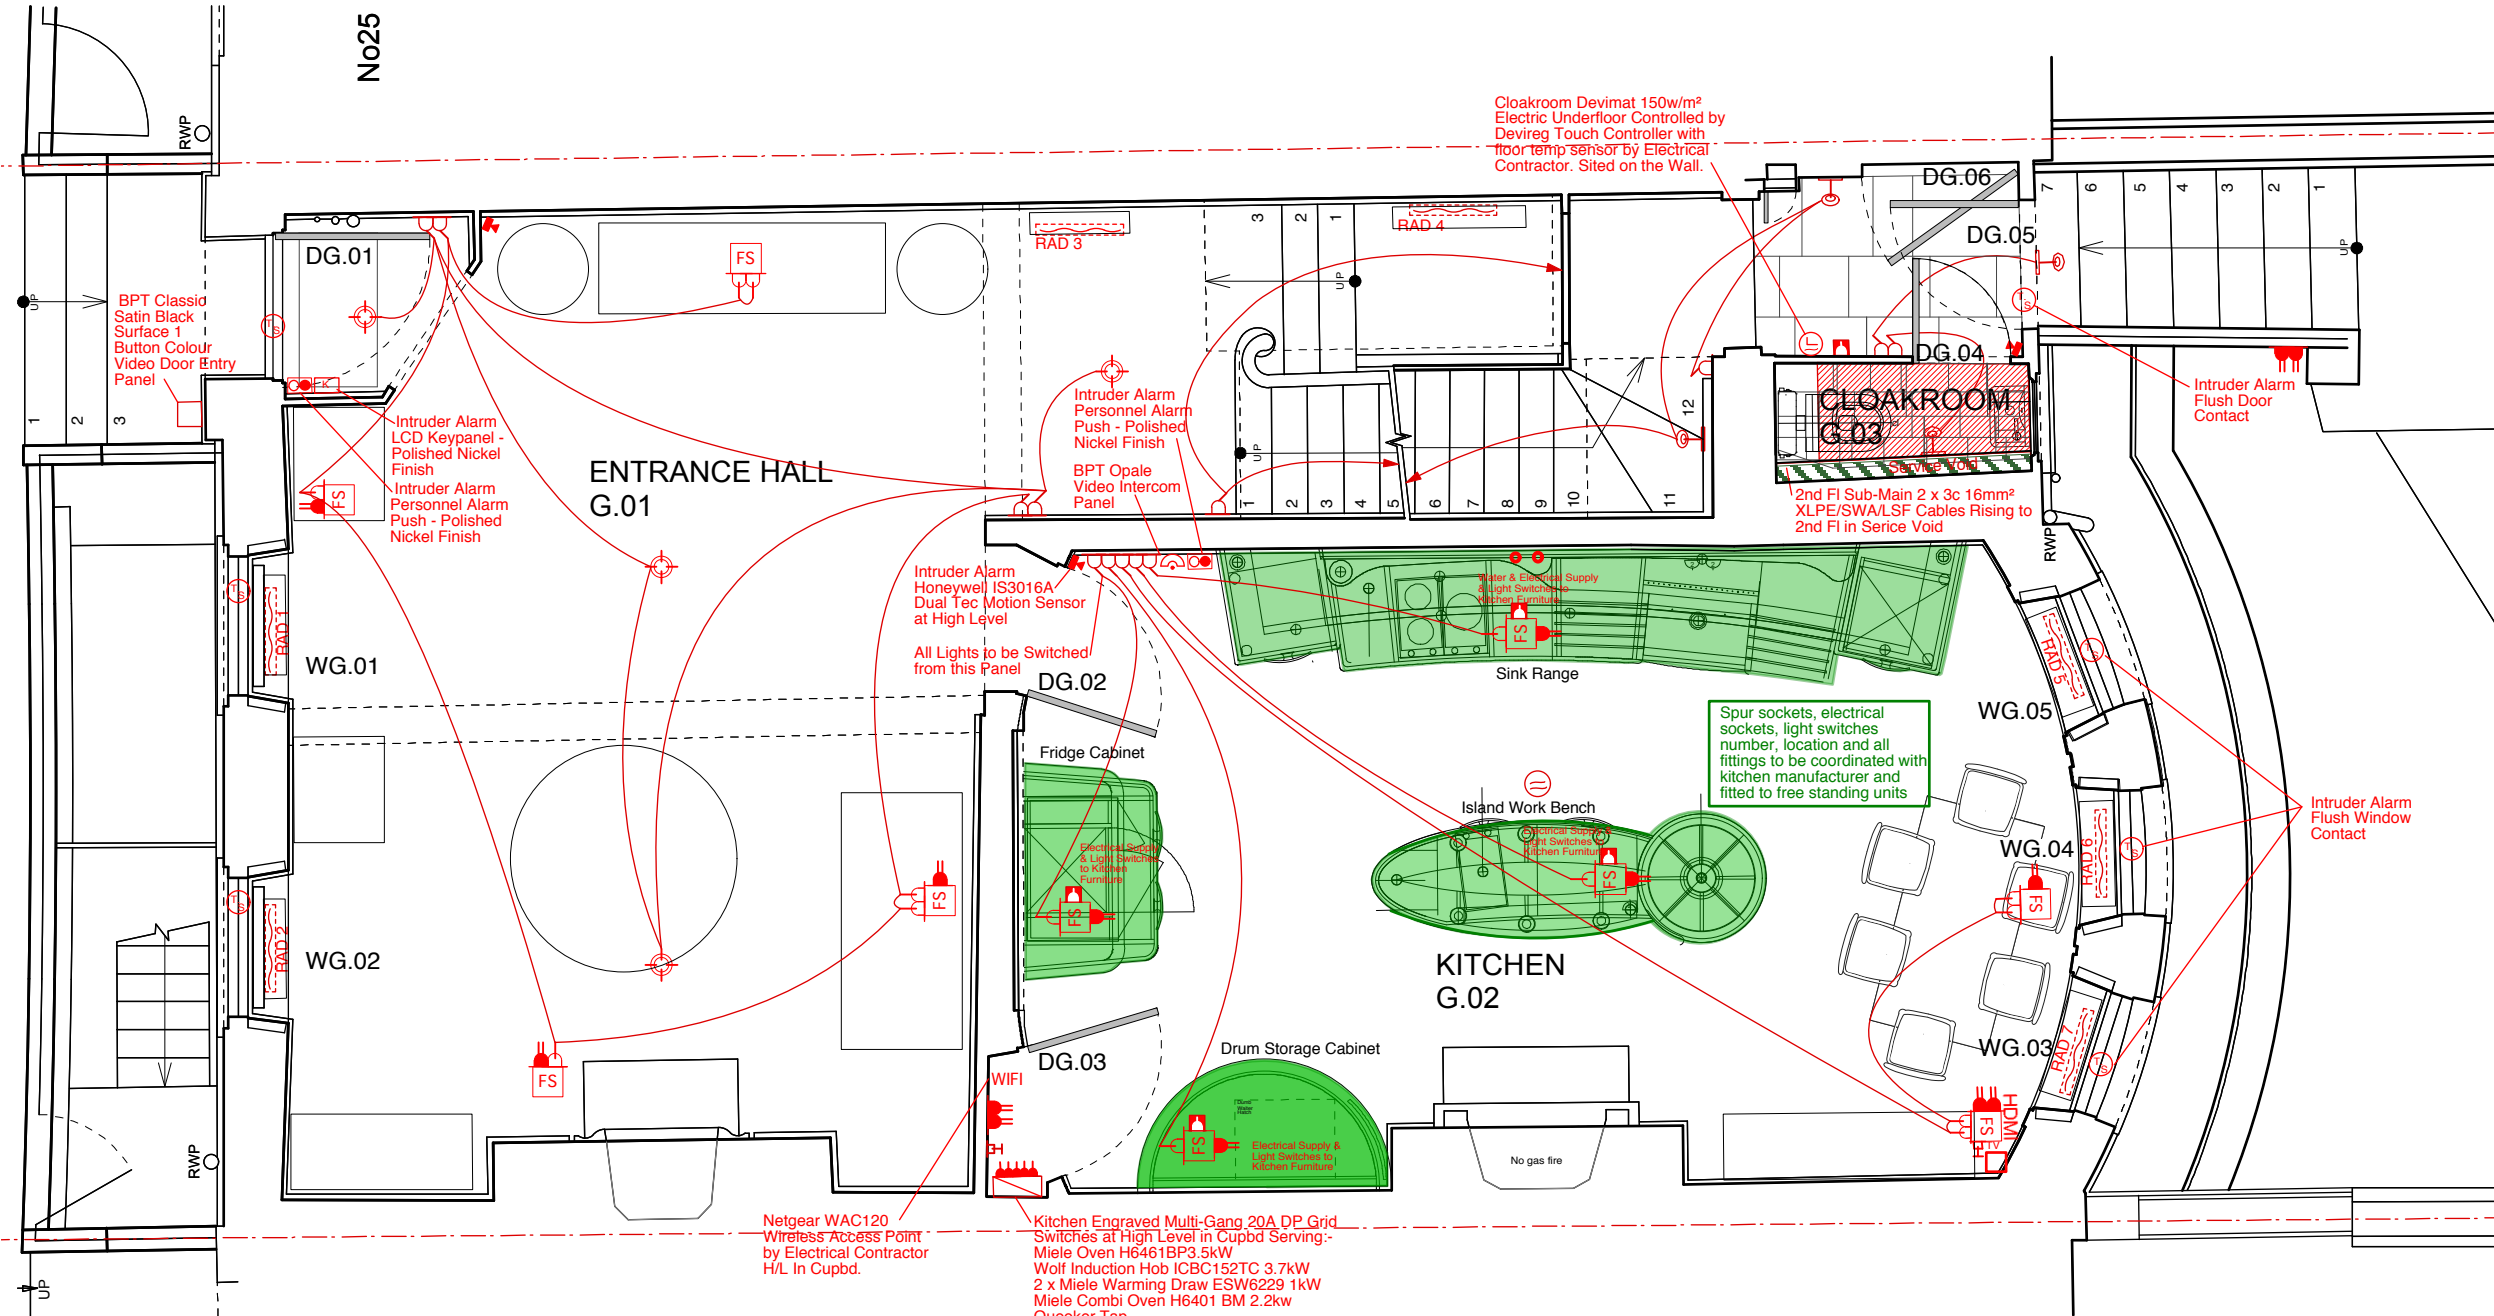














LOWER GROUND FLOOR PLAN

Butler Hegarty Architects
 Unit 208 A2, 159-163 Marlborough Road, London, N19 4NF
 tel: 020 72638933 email: mail@butlerhegartyarchitects.co.uk



24 Church Row
 Title: Proposed Lower Ground Floor Services Plan
 Drawing No: 0919317/Sk70 Scale 1:50 @ A3



-  Underfloor Heating
-  Switch
-  Pendant Light
-  Recessed Down Light
-  Wall Light
-  Track With Picture Lights
-  5 Amp Single Socket Outlet
-  13 Amp Single Socket Outlet
-  Fused Spur Socket
-  Double Socket Outlet
-  Double Socket & USB Outlet
-  Radiator
-  Smoke Alarm & Heat Detector
-  Devired Touch Programmer Wired to Floor Temperature Probe.
-  Dual Data / Telephone Socket Outlet
-  Floor Socket Outlet
-  TV outlet
-  Multi Gang Grid Switch
-  Honeywell IS3016A Dual Tech Motion Detector
-  Intruder Alarm
-  BPT Opale Door Entry Video/comm Unit.
-  Intruder Alarm Keypad
-  Intruder Alarm Personnel Alarm Push

DO NOT SCALE check all dimensions on site



1 : 50


GROUND FLOOR PLAN









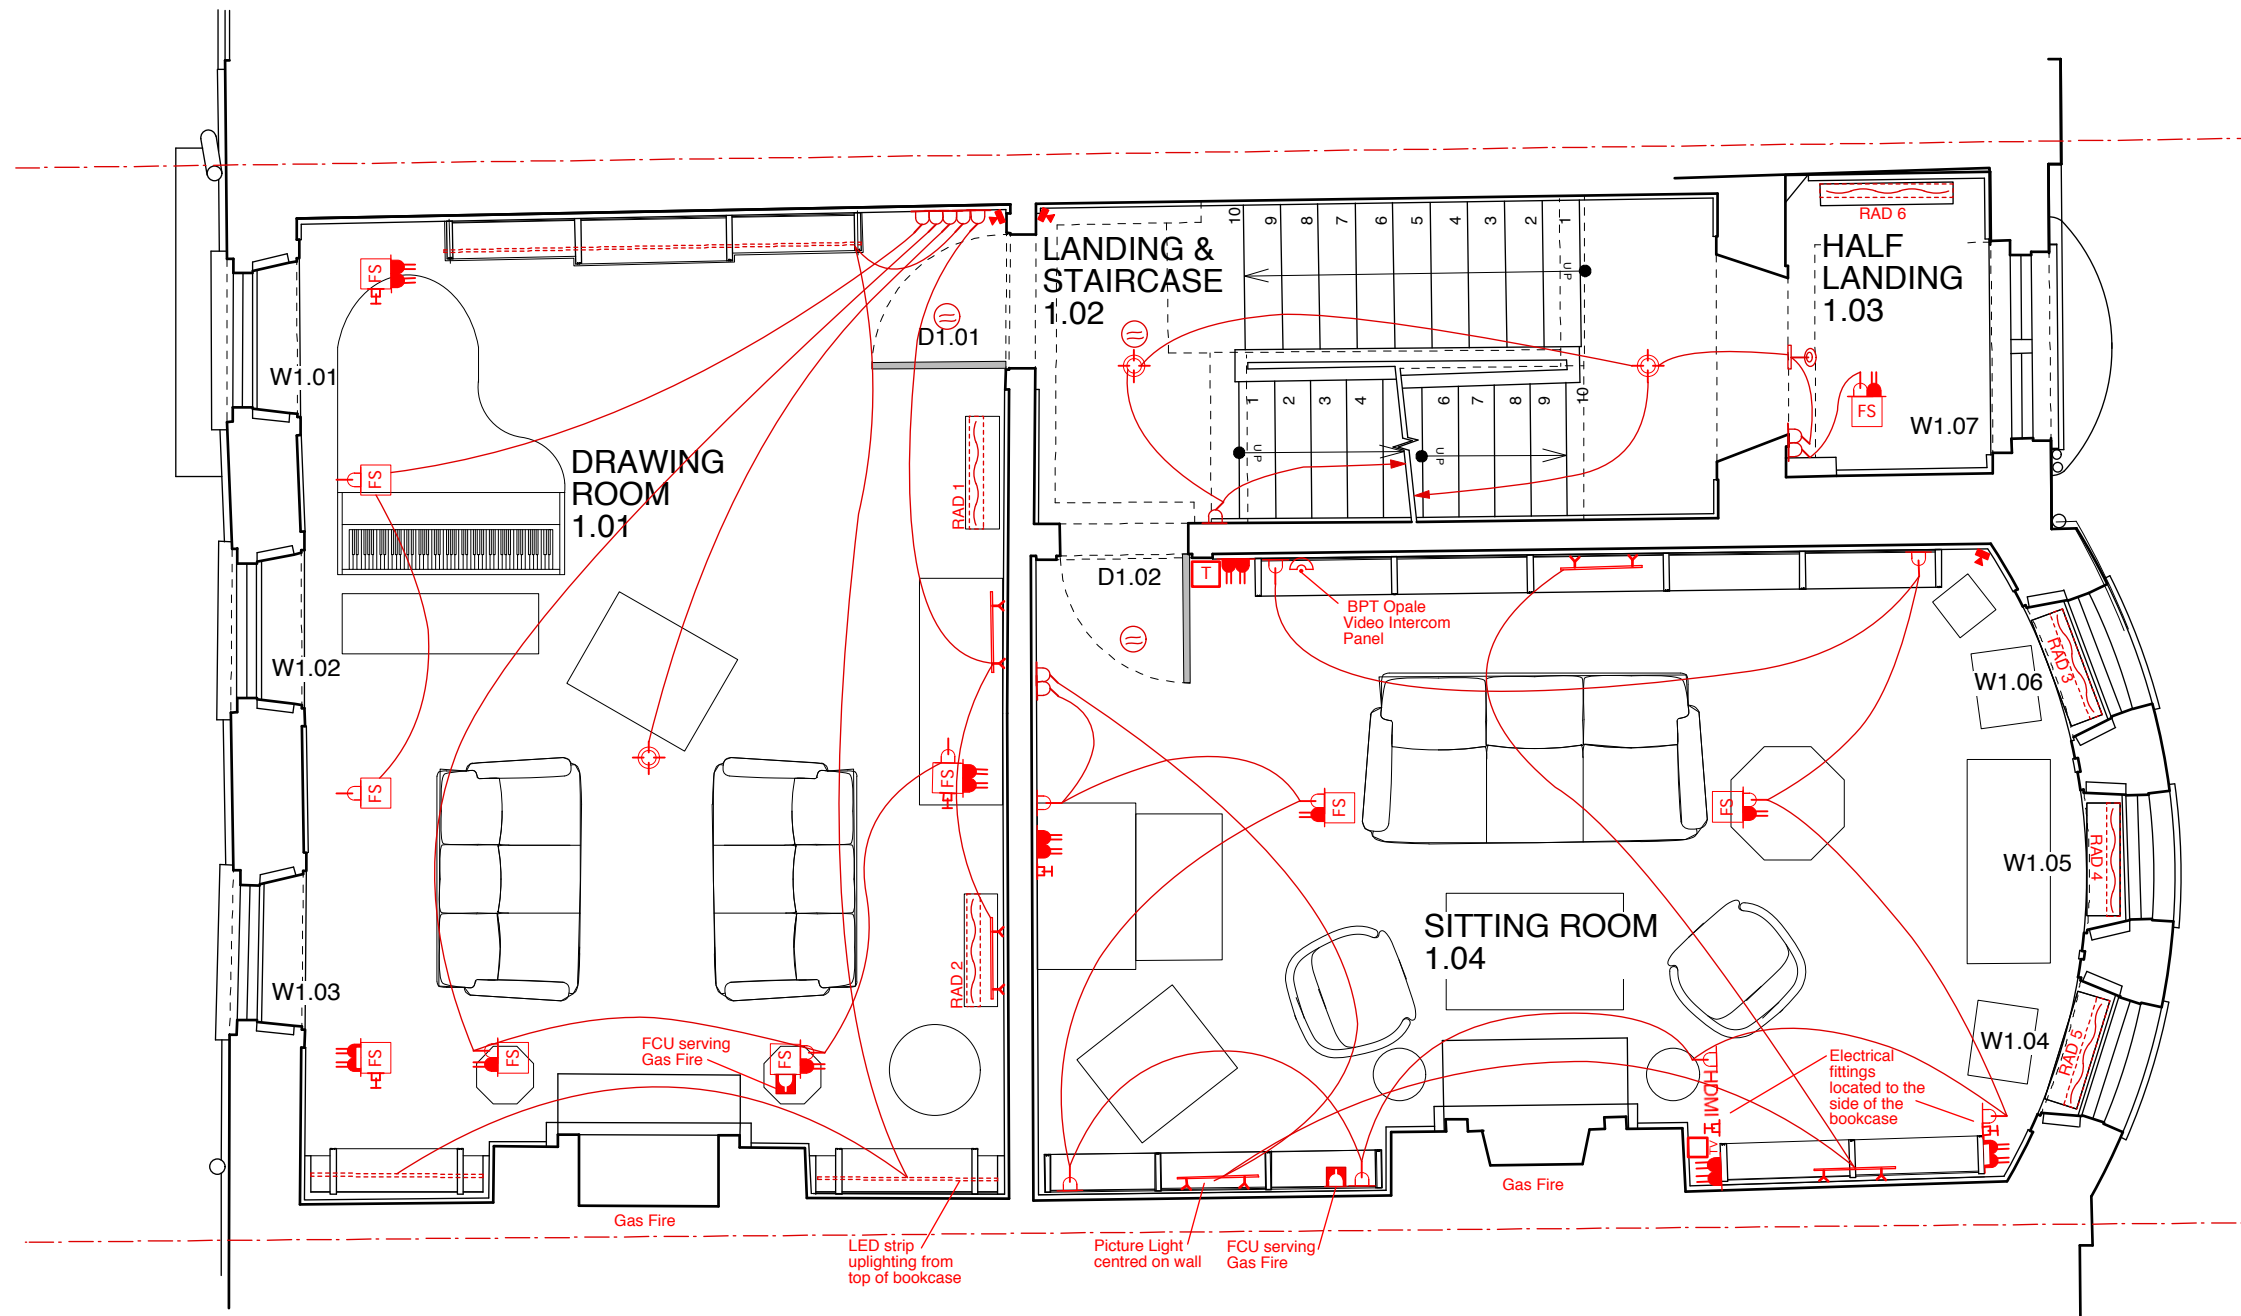










Butler Hegarty Architects
 Unit 208 A2, 159-163 Marlborough Road, London, N19 4NF
 tel: 020 72638933 email: mail@butlerhegartyarchitects.co.uk



Rev A Light fittings omitted from panelling

24 Church Row
 Title: Proposed Ground Floor Services Plan
 Drawing No: 0919317/Sk71A Scale 1: 50 @ A3



-  Switch
-  Pendant Light
-  Wall Light
-  5 Amp Single Socket Outlet
-  13 Amp Single Socket Outlet
-  Fused Spur Socket
-  Double Socket Outlet
-  Double Socket & USB Outlet
-  Radiator
-  Smoke Alarm & Heat Detector
-  Dual Data / Telephone Socket Outlet
-  Floor Socket Outlet
-  TV outlet
-  TV
-  Honeywell IS3016A Dual Tech Motion Detector
-  Track With Picture Lights
-  BPT Opale Door Entry Video/comm Unit.
-  LED Strip Uplighting from Top of Bookcase
-  Thimble Temperature Sensor on Ceiling

DO NOT SCALE check all dimensions on site



1 : 50


FIRST FLOOR PLAN









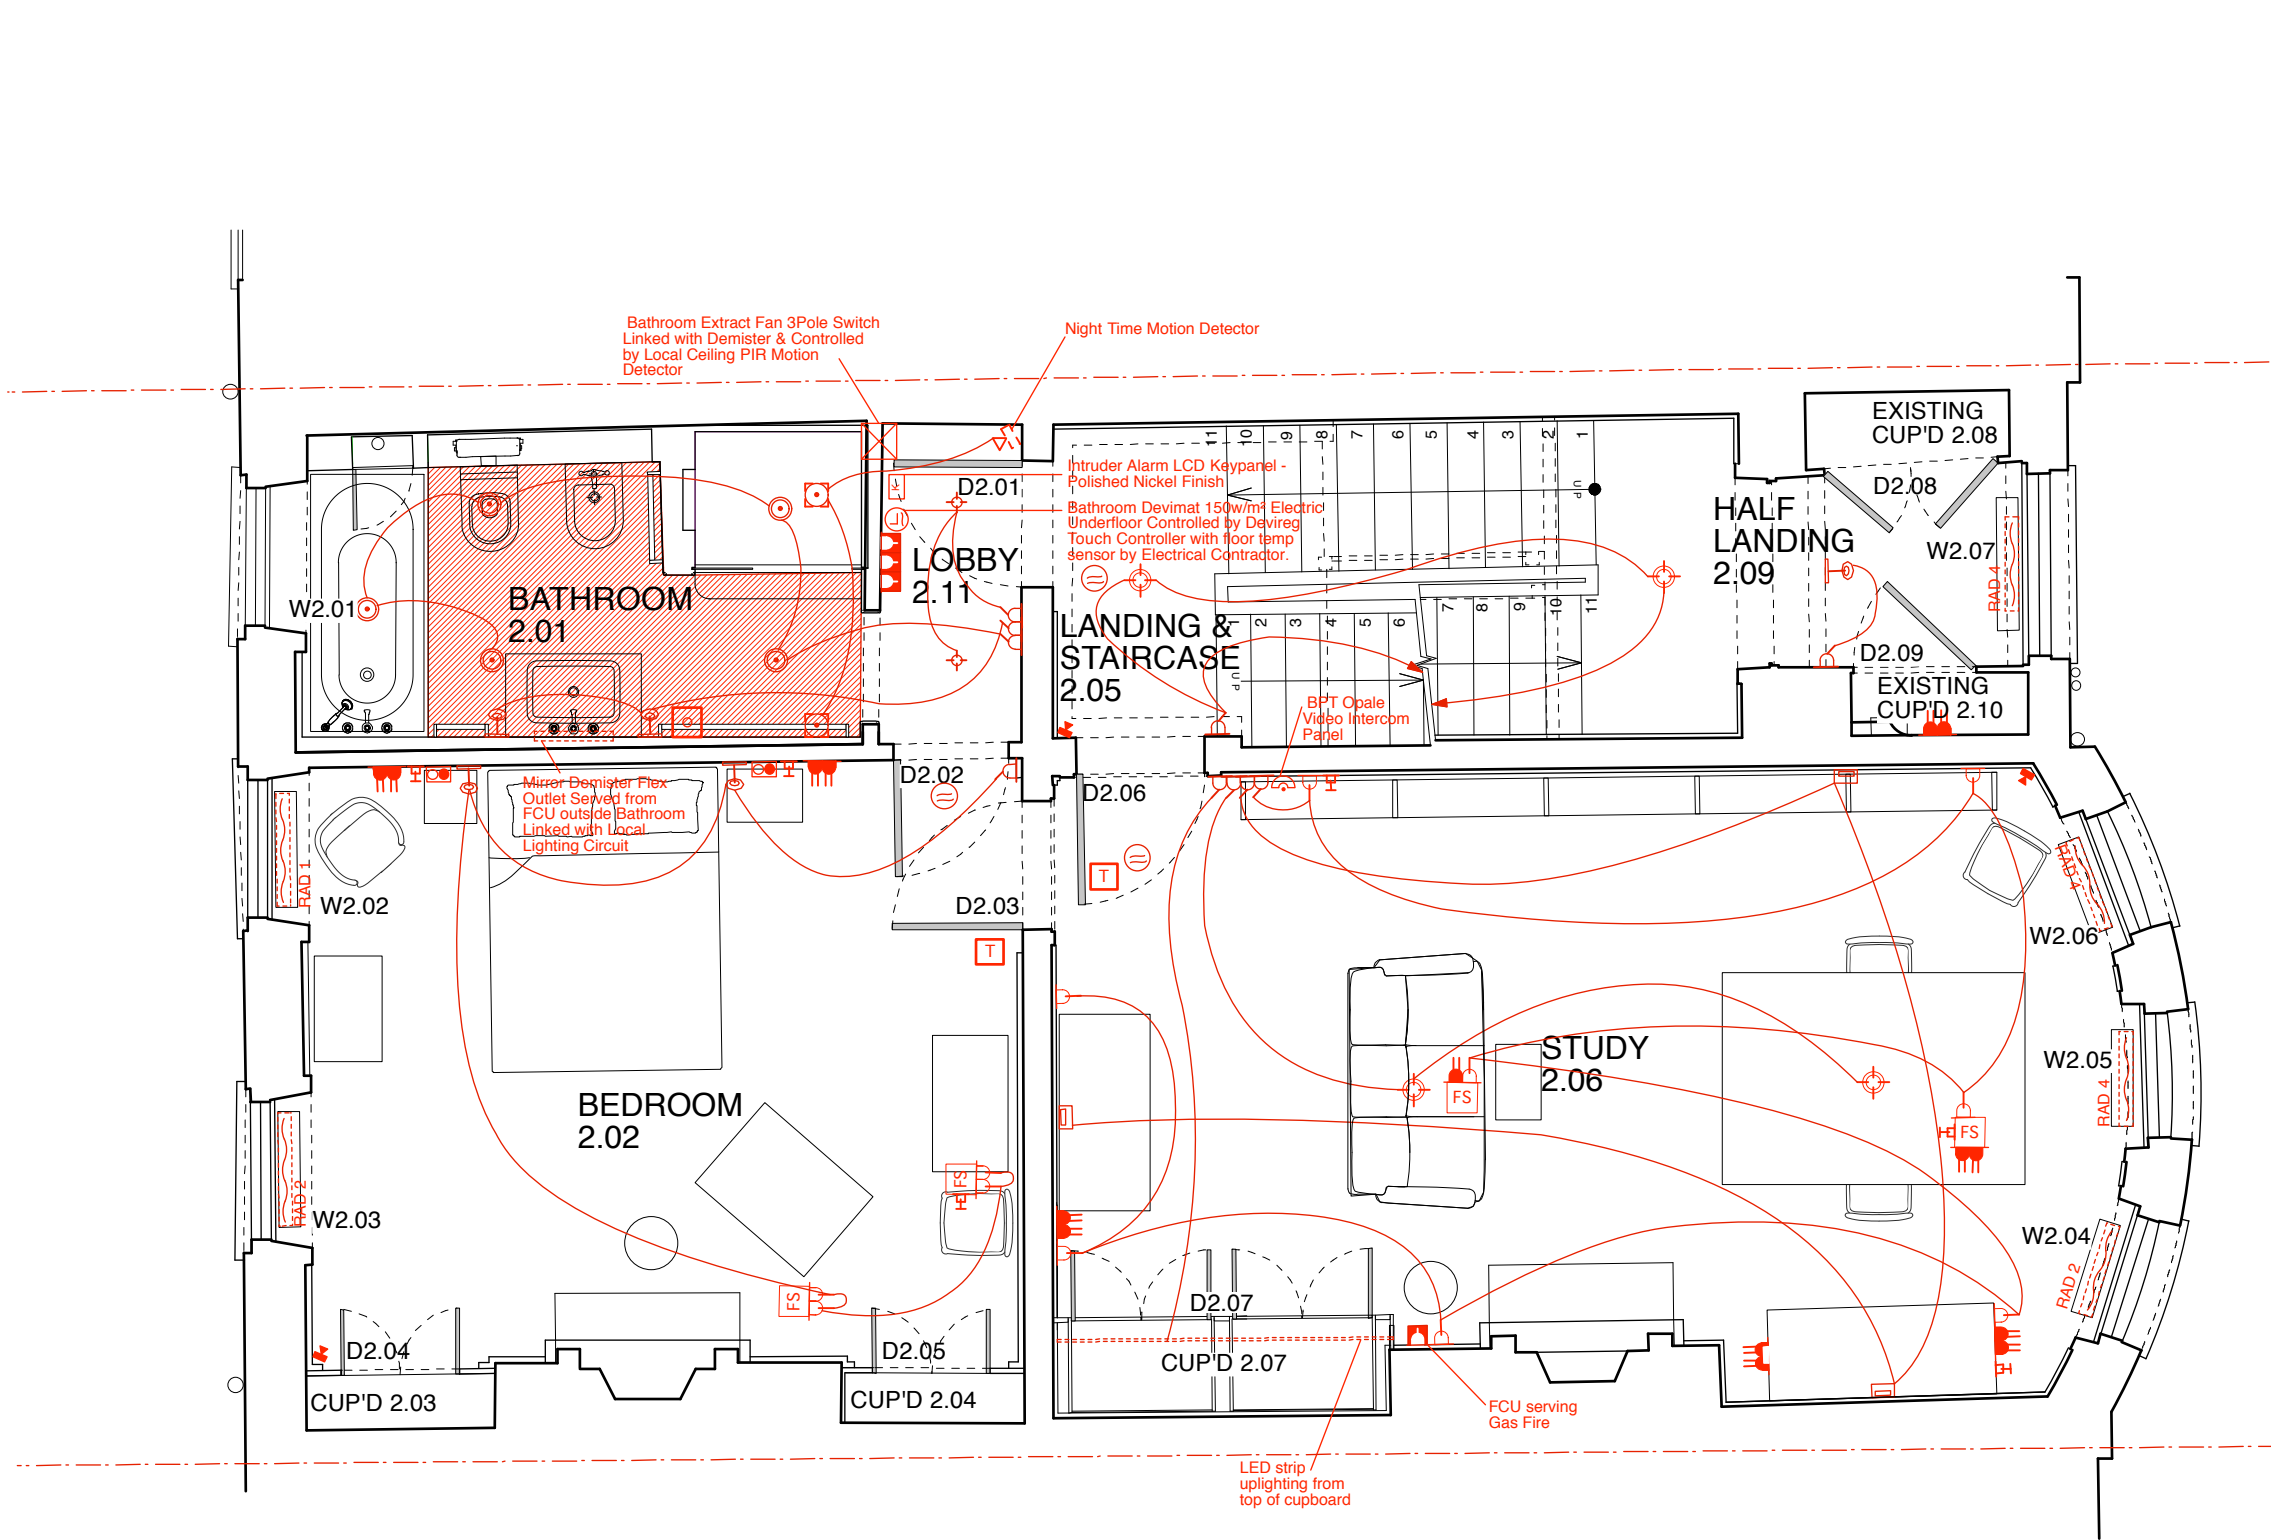







 








Butler Hegarty Architects
 Unit 208 A2, 159-163 Marlborough Road, London, N19 4NF
 tel: 020 72638933 email: mail@butlerhegartyarchitects.co.uk



Rev A Sockets removed from skirting

24 Church Row
 Title: Proposed First Floor Services Plan
 Drawing No: 0919317/Sk72A Scale 1: 50 @ A3



-  Underfloor Heating
-  Switch
-  Surface Mounted Light
-  Recessed Down Light
-  Pendant Light
-  Wall Uplight
-  Wall Light
-  5 Amp Single Socket Outlet
-  13 Amp Single Socket Outlet
-  Fused Spur Socket
-  Double Socket Outlet
-  Double Socket & USB Outlet
-  Night Time Light Connected to Motion Detector
-  Radiator
-  Heated Mirror
-  Smoke Alarm & Heat Detector
-  Dual Data / Telephone Socket Outlet
-  Floor Socket Outlet
-  Honeywell IS3016A Dual Tech Motion Detector
-  Track With Picture Lights
-  BPT Opale Door Entry Video/comm Unit.
-  Thimble Temperature Sensor on Ceiling
-  Intruder Alarm Keypad
-  Intruder Alarm Personnel Alarm Push
-  Towel Rail Flex Outlet Box

DO NOT SCALE check all dimensions on site




1 : 50









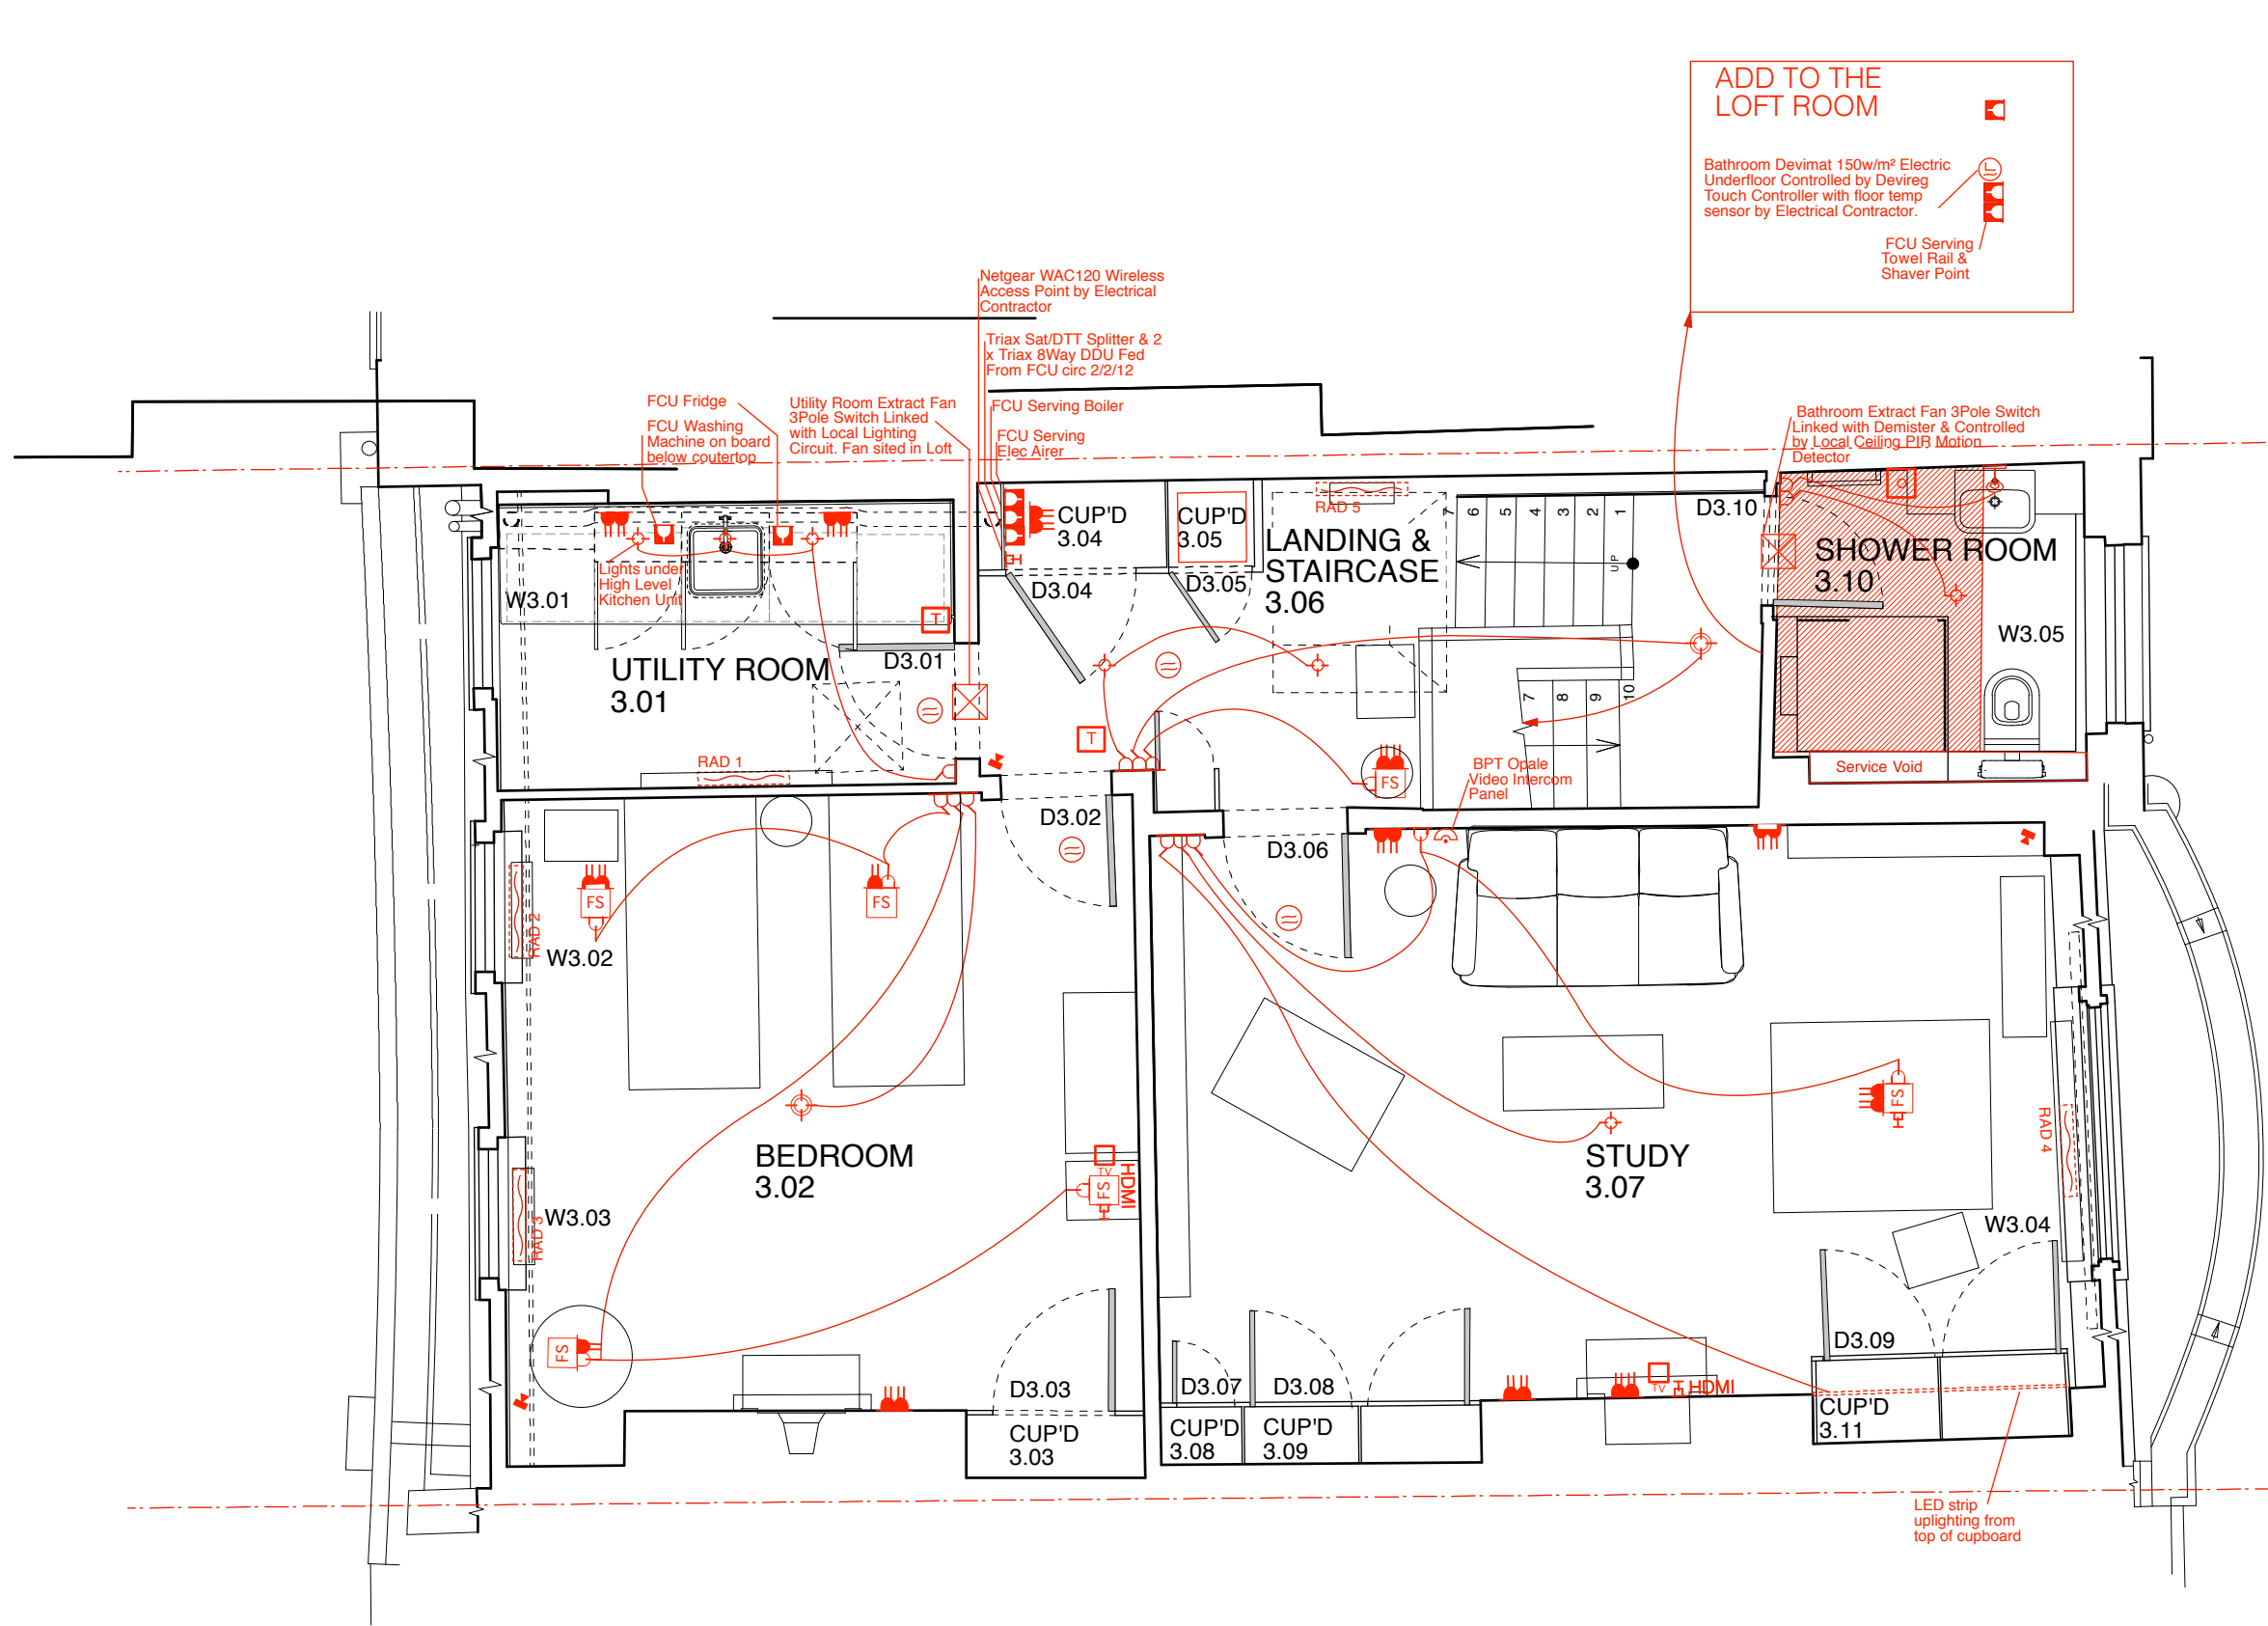














SECOND FLOOR PLAN

Butler Hegarty Architects
 Unit 208 A2, 159-163 Marlborough Road, London, N19 4NF
 tel: 020 72638933 email: mail@butlerhegartyarchitects.co.uk

 


24 Church Row
 Title: Proposed Second Floor Services Plan
 Drawing No: 0919317/Sk73 Scale 1: 50 @ A3



-  Underfloor Heating
-  Switch
-  Surface Mounted Light
-  Wall Uplight
-  Pendant Light
-  Wall Light
-  5 Amp Single Socket Outlet
-  13 Amp Single Socket Outlet
-  Fused Spur Socket
-  Double Socket Outlet
-  Double Socket & USB Outlet
-  Radiator
-  Heated Mirror
-  Smoke Alarm & Heat Detector
-  Dual Data / Telephone Socket Outlet
-  Floor Socket Outlet
-  TV outlet
-  Honeywell IS3016A Dual Tech Motion Detector
-  Concealed Pelmet Lights
-  BPT Opale Door Entry Video/comm Unit.
-  LED Strip Uplighting from Top of Bookcase
-  Thimble Temperature Sensor on Ceiling
-  Towel Rail Flex Outlet Box

DO NOT SCALE check all dimensions on site



1 : 50

THIRD FLOOR PLAN

Butler Hegarty Architects
 Unit 208 A2, 159-163 Marlborough Road, London, N19 4NF
 tel: 020 72638933 email: mail@butlerhegartyarchitects.co.uk



24 Church Row
 Title: Proposed Third Floor Services Plan
 Drawing No: 0919317/Sk74 Scale 1: 50 @ A3