


MEP pro ltd  
17 Parkway  
Woodford Green  
IG8 7RE

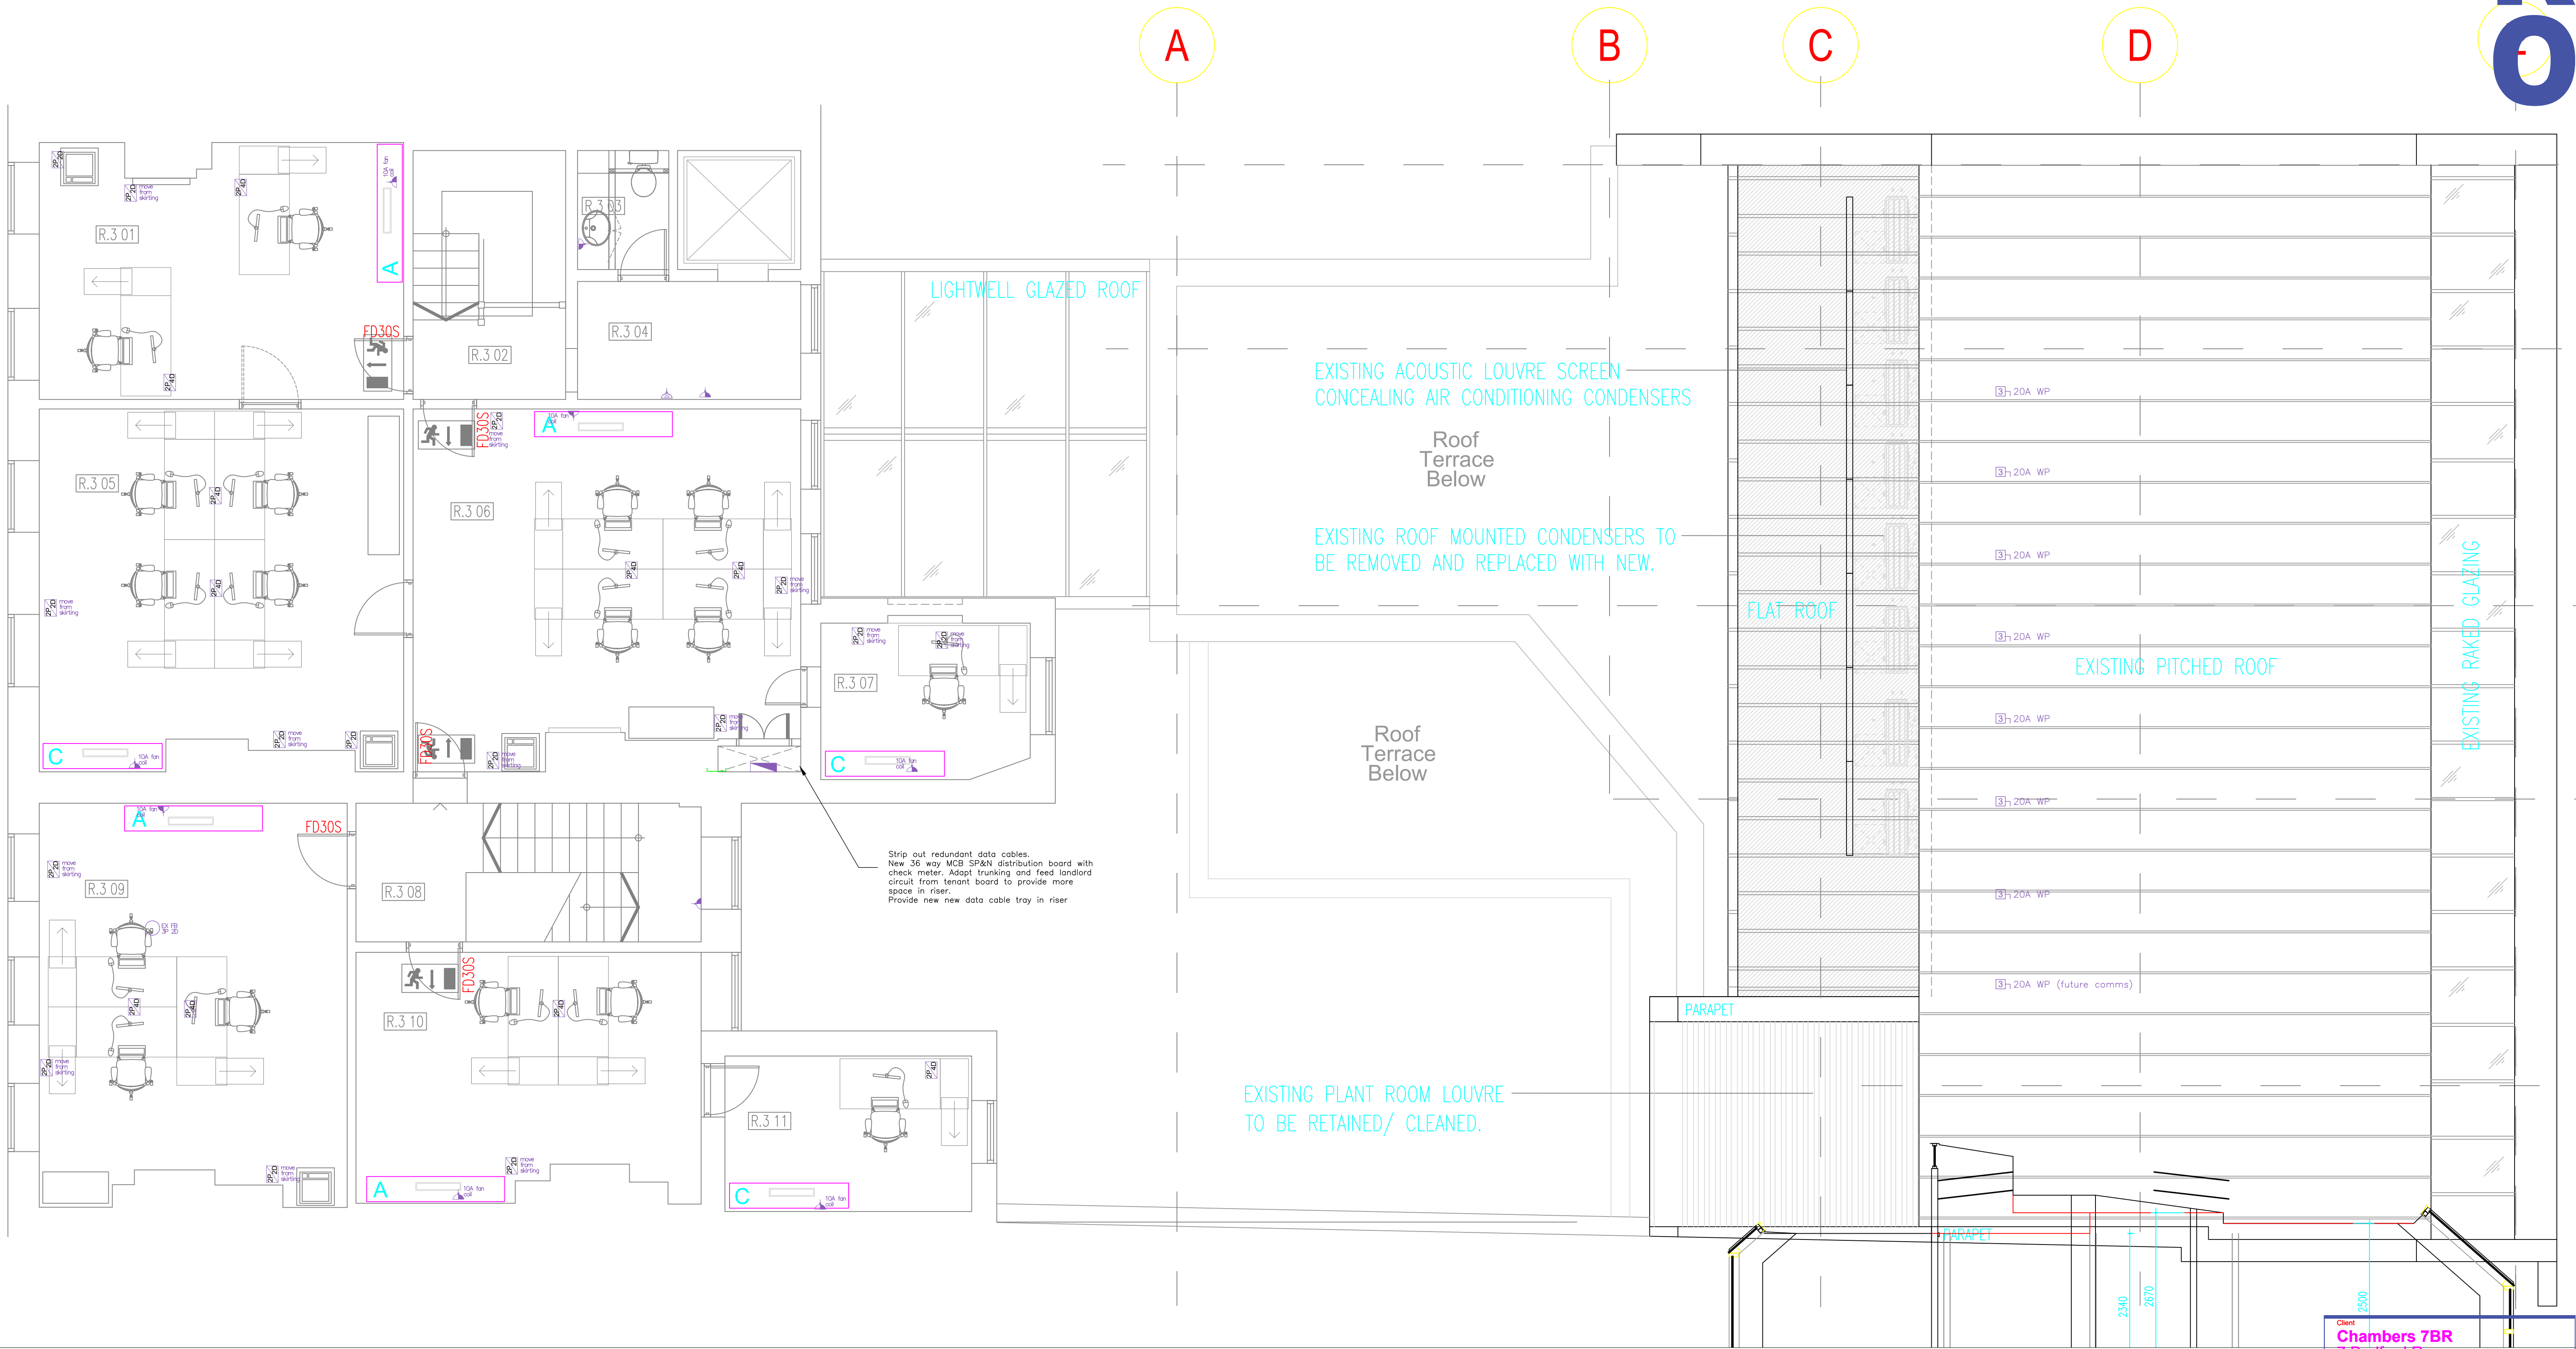

Rev	Date	Description	Aprvd
3.1	Sep18	Issued For Comments	PG
2.1	Sep18	Stage 2 Issued For coord	PG

MEP PRO Building Services  
T +44 (0) 7584 632181  
E Peter@meppro.co.uk

MEP pro Ltd  
17 Parkway  
Woodford Green  
IG8 7RE

Client  
**Chambers 7BR**  
7 Bedford Row  
London  
WC1R 4BS

Project  
**7BR refurbishment**

Drawing Title  
**Stage 3  
Third Floor  
Electrical Services  
Power and containment layout**

Scale  
1:50 at A1

Date  
Aug 18



Author  
PG


Revision  
**2018-3-E1**

3.1

3.1	Sep18	Issued For Comments	PG
2.1	Sep18	Stage 2 Issued For coord	PG
Rev	Date	Description	Aprvrd



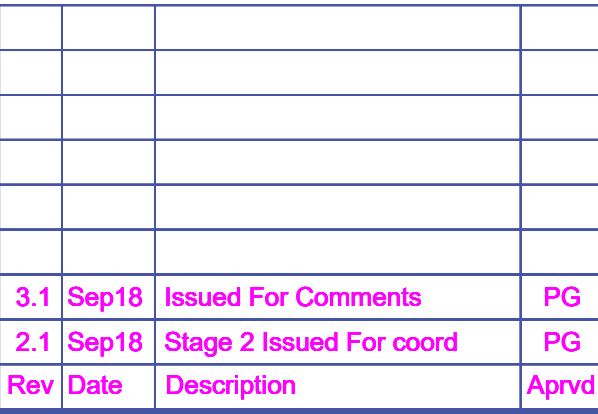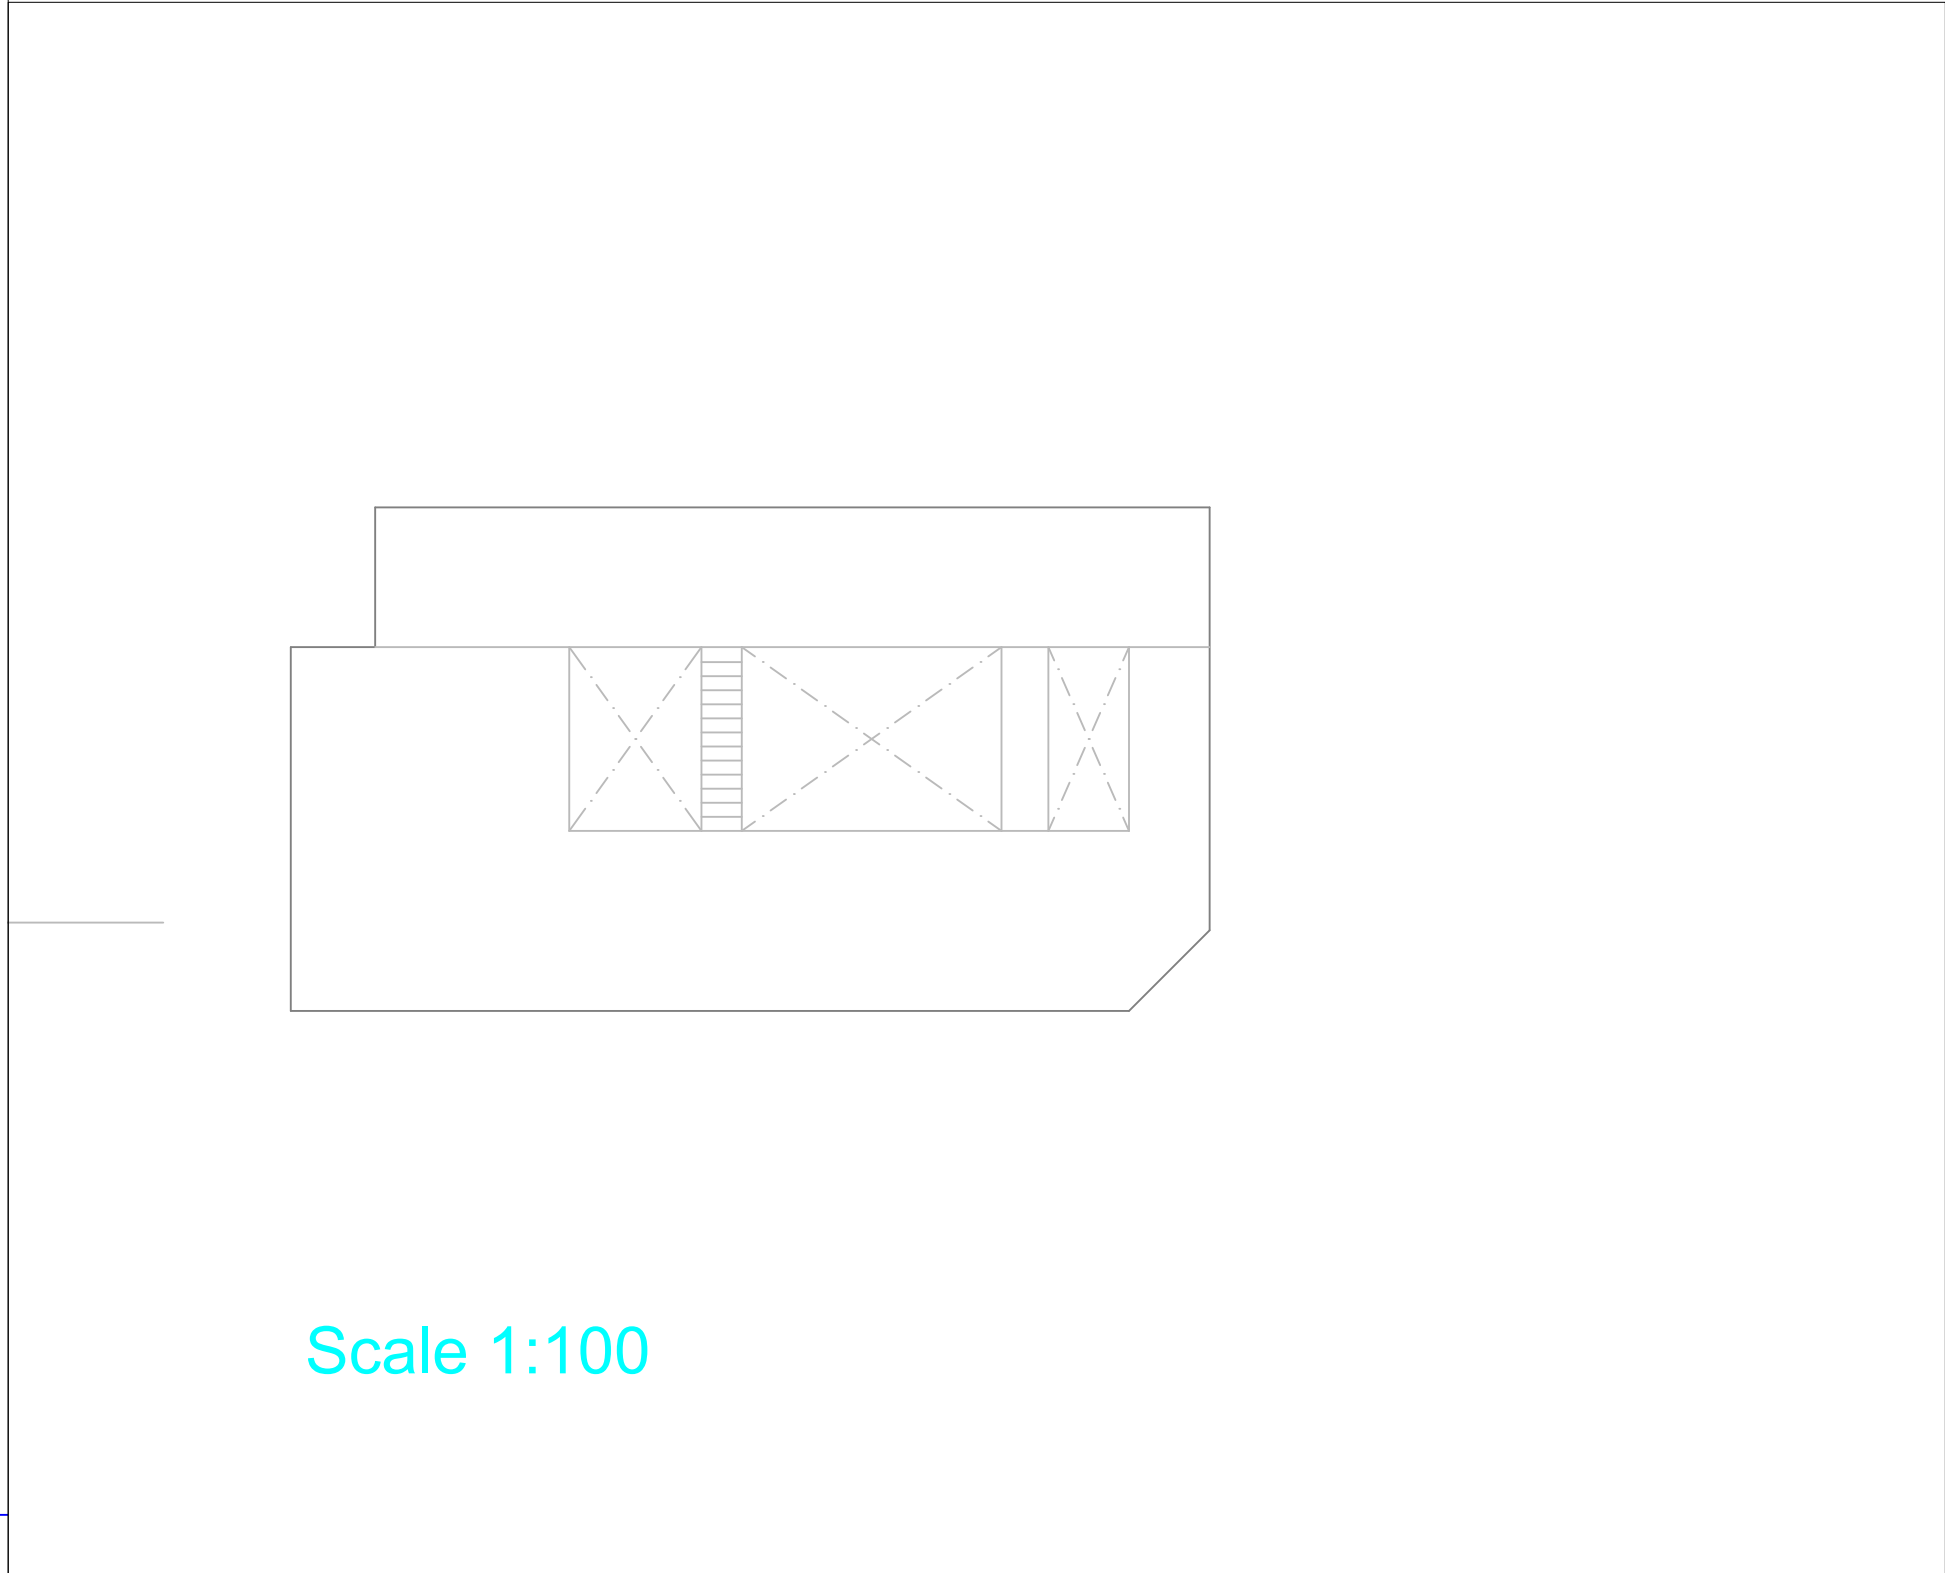

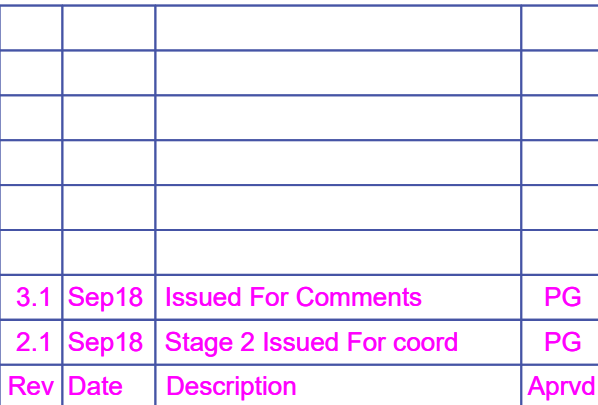


Client		
<b>Chambers 7BR</b> 7 Bedford Row London WC1R 4BS		
Project		
7BR refurbishment		
Drawing Title		
<b>Stage 3</b> Ground floor Electrical Services Lighting layout		
Scale	Date	Author
1:50 at A1	Aug 18	PG
Drawing No.	Revision	
2018-G-E2	3.1	






<p>Client</p> <p><b>Chambers 7BR</b>          7 Bedford Row          London          WC1R 4BS</p>		
<p>Project</p> <p><b>7BR refurbishment</b></p>		
<p>Drawing Title</p> <p><b>Stage 3</b>          First Floor          Electrical Services          Lighting layout</p>		
<p>Scale</p> <p><b>1:50 at A1</b></p>	<p>Date</p> <p><b>Aug 18</b></p>	<p>Author</p> <p><b>PG</b></p>
<p>Drawing No.</p> <p><b>2018-1-E2</b></p>		<p>Revision</p> <p><b>3.1</b></p>

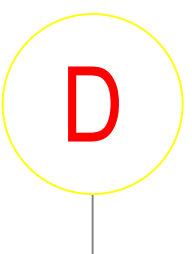

MEP PRO Building Services  
T +44 (0) 7584 632181  
E Peter@meppro.co.uk

MEP pro ltd  
17 Parkway  
Woodford Green  
IG8 7RE

2018-2-E2 3.1

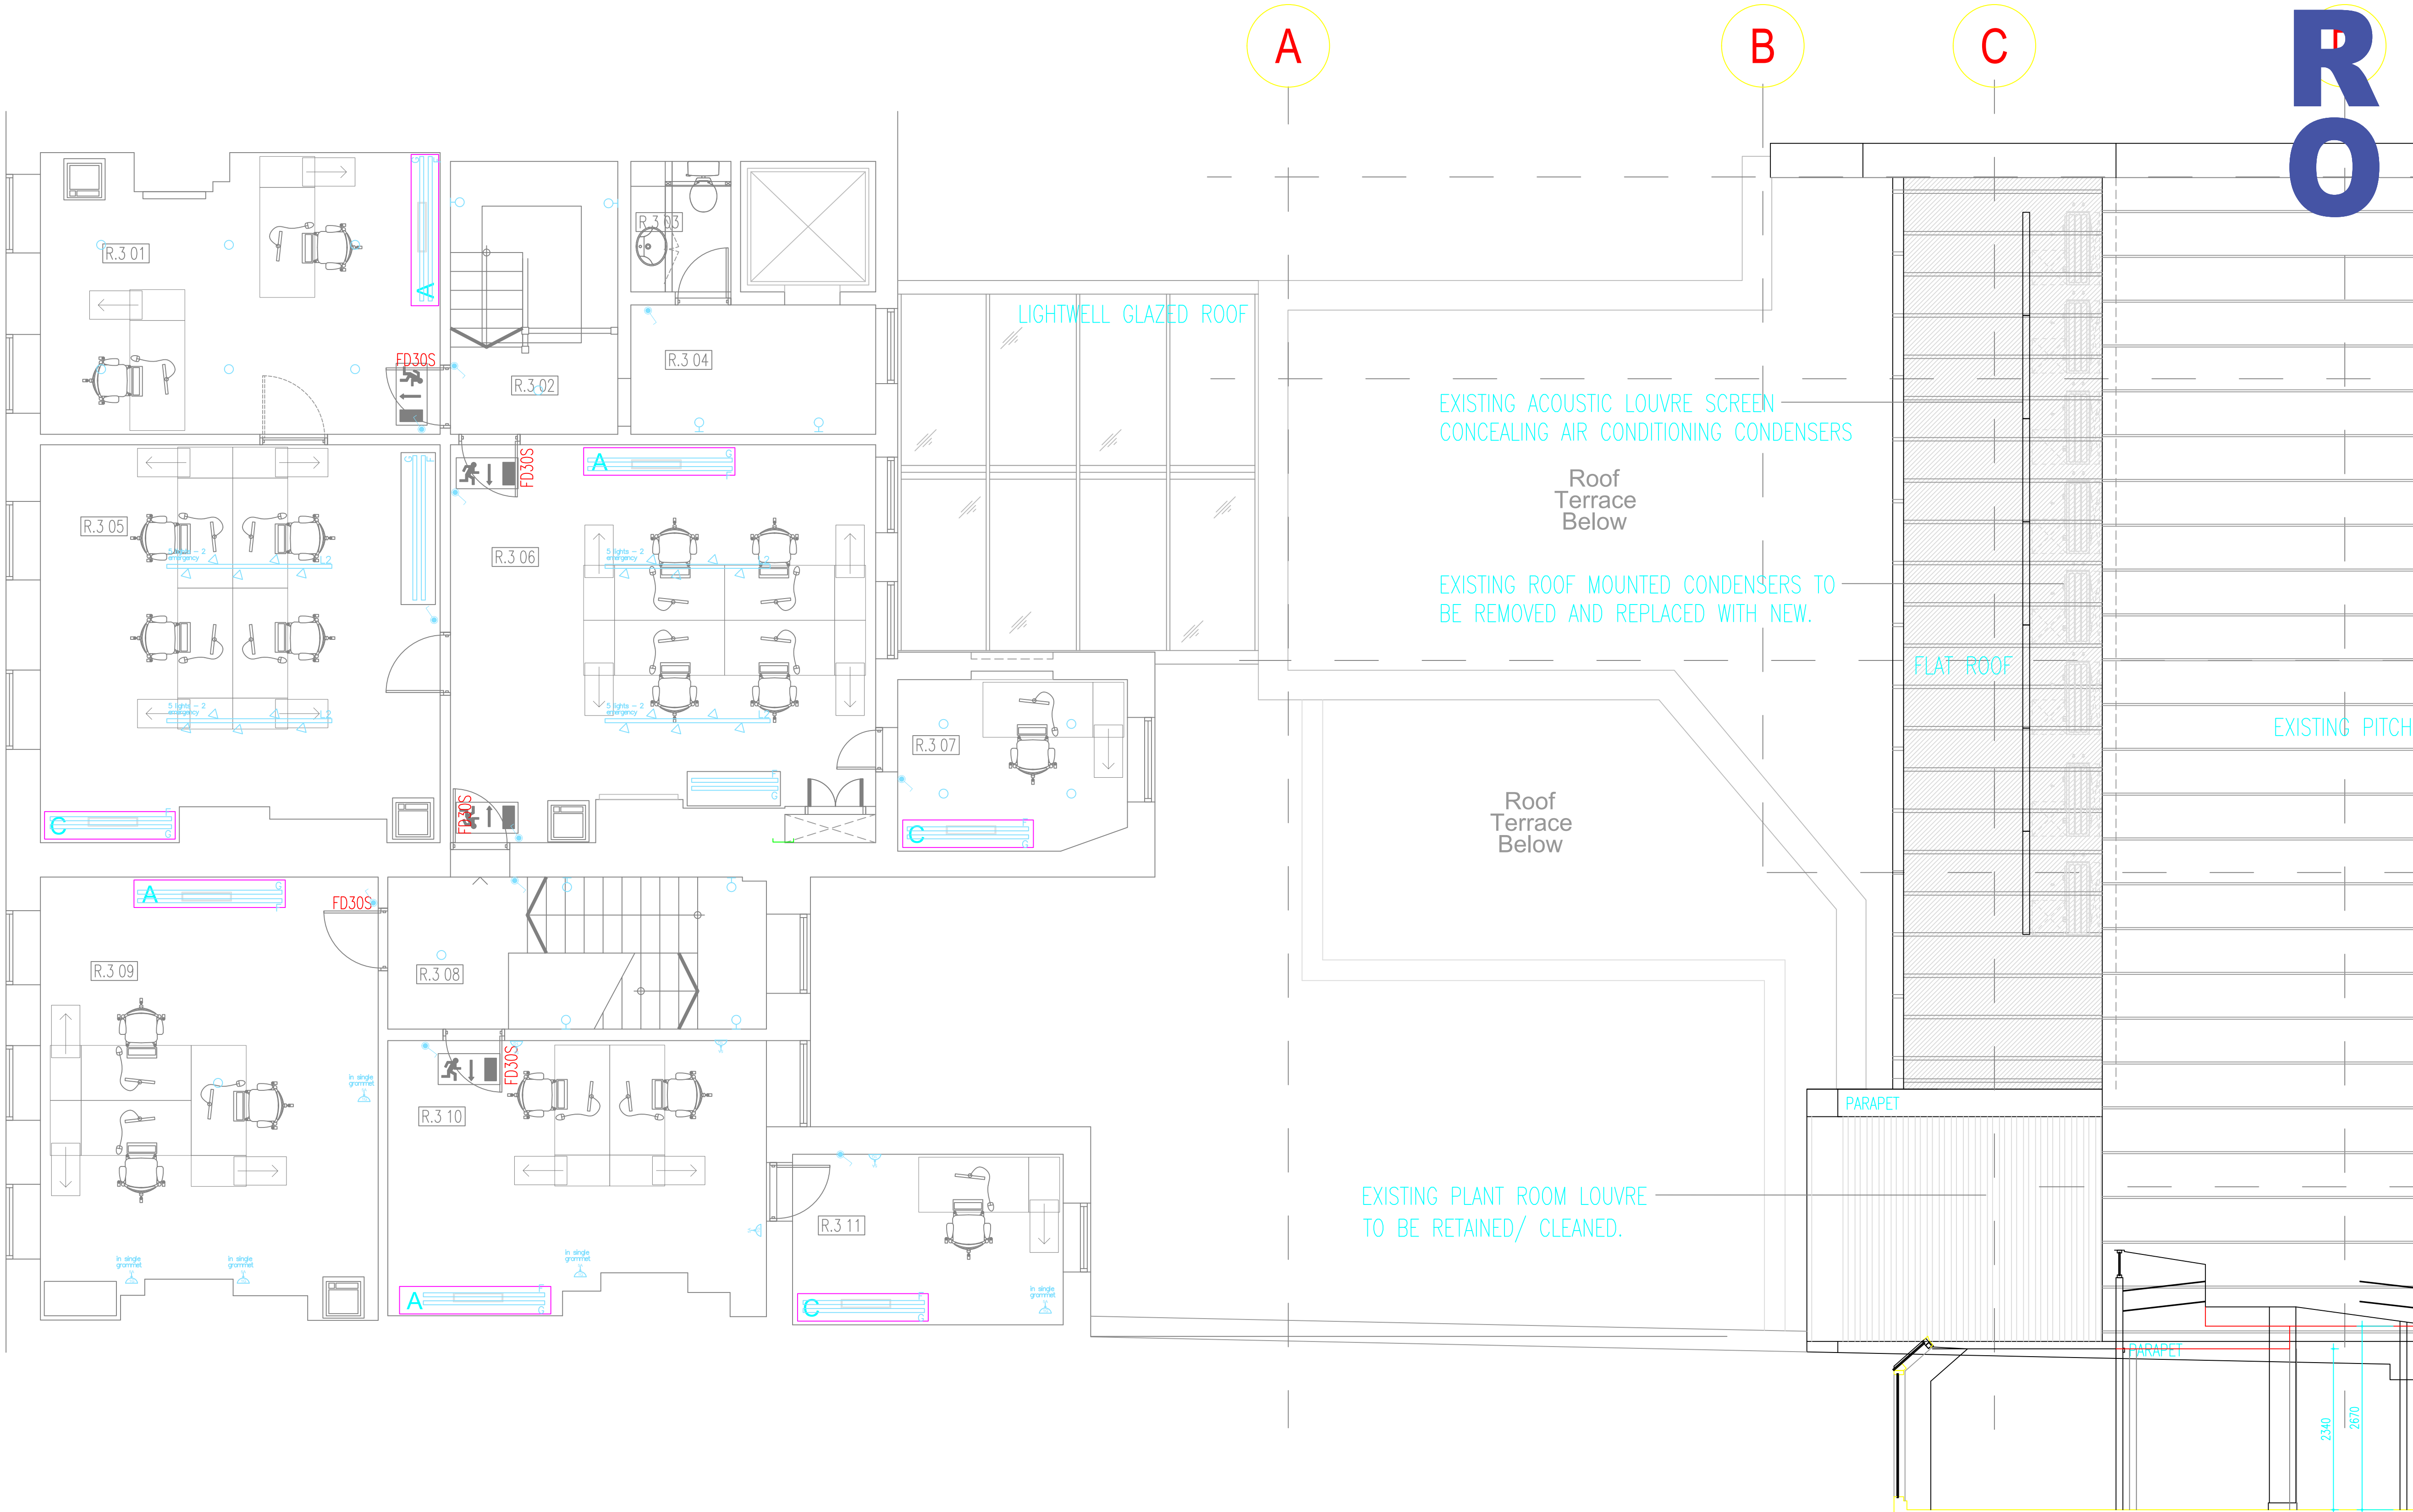


Client <b>Chambers 7BR</b> 7 Bedford Row London WC1R 4BS			
Project <b>7BR refurbishment</b>			
Drawing Title <b>Stage 3 Third Floor Electrical Services Lighting layout</b>			
Scale 1:50 at A1	Date Aug 18	Author PG	Revision
Drawing No. <b>2018-3-E2</b>			3.1

MEP PRO Building Services T +44 (0) 7584 632181 E Peter@meppro.co.uk	MEP pro Ltd 17 Parkway Woodford Green IG8 7RE
--	--



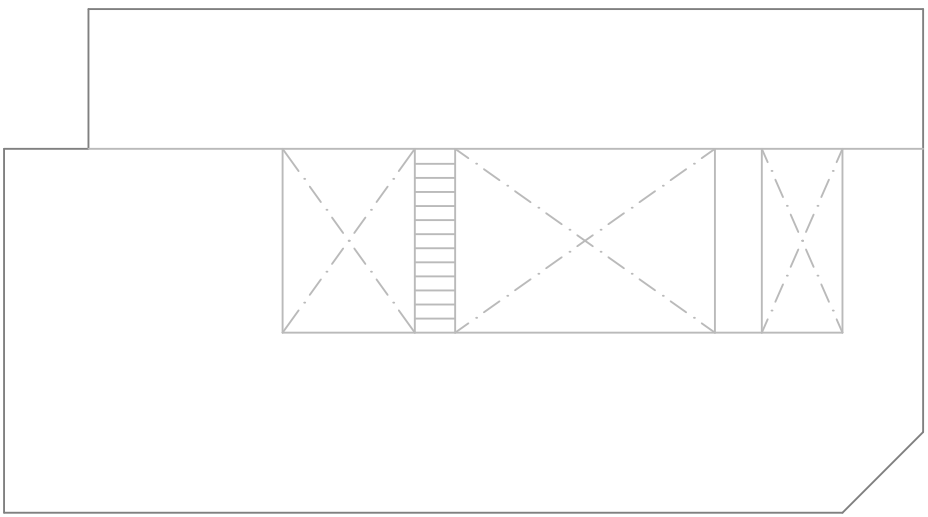

[illegible]

3.1	Sep18	Issued For Comments	PG
2.1	Sep18	Stage 2 Issued For coord	PG
Rev	Date	Description	Aprvd

## Project 7BR refurbishment

Drawing Title

**Stage 3**

Lower Ground East  
Electrical Services  
Fire Alarm Layout


Scale 1:50 at A1	Date Aug 18	Author PG
Drawing No. 2018-LGE-E3		Revision 3.1



MEP pro Ltd  
17 Parkway  
Woodford Green  
IG8 7RE

Scale 1:50 at A1	Date Aug 18	Author PG
Drawing No. 2018-G-E3		Revision 3.1



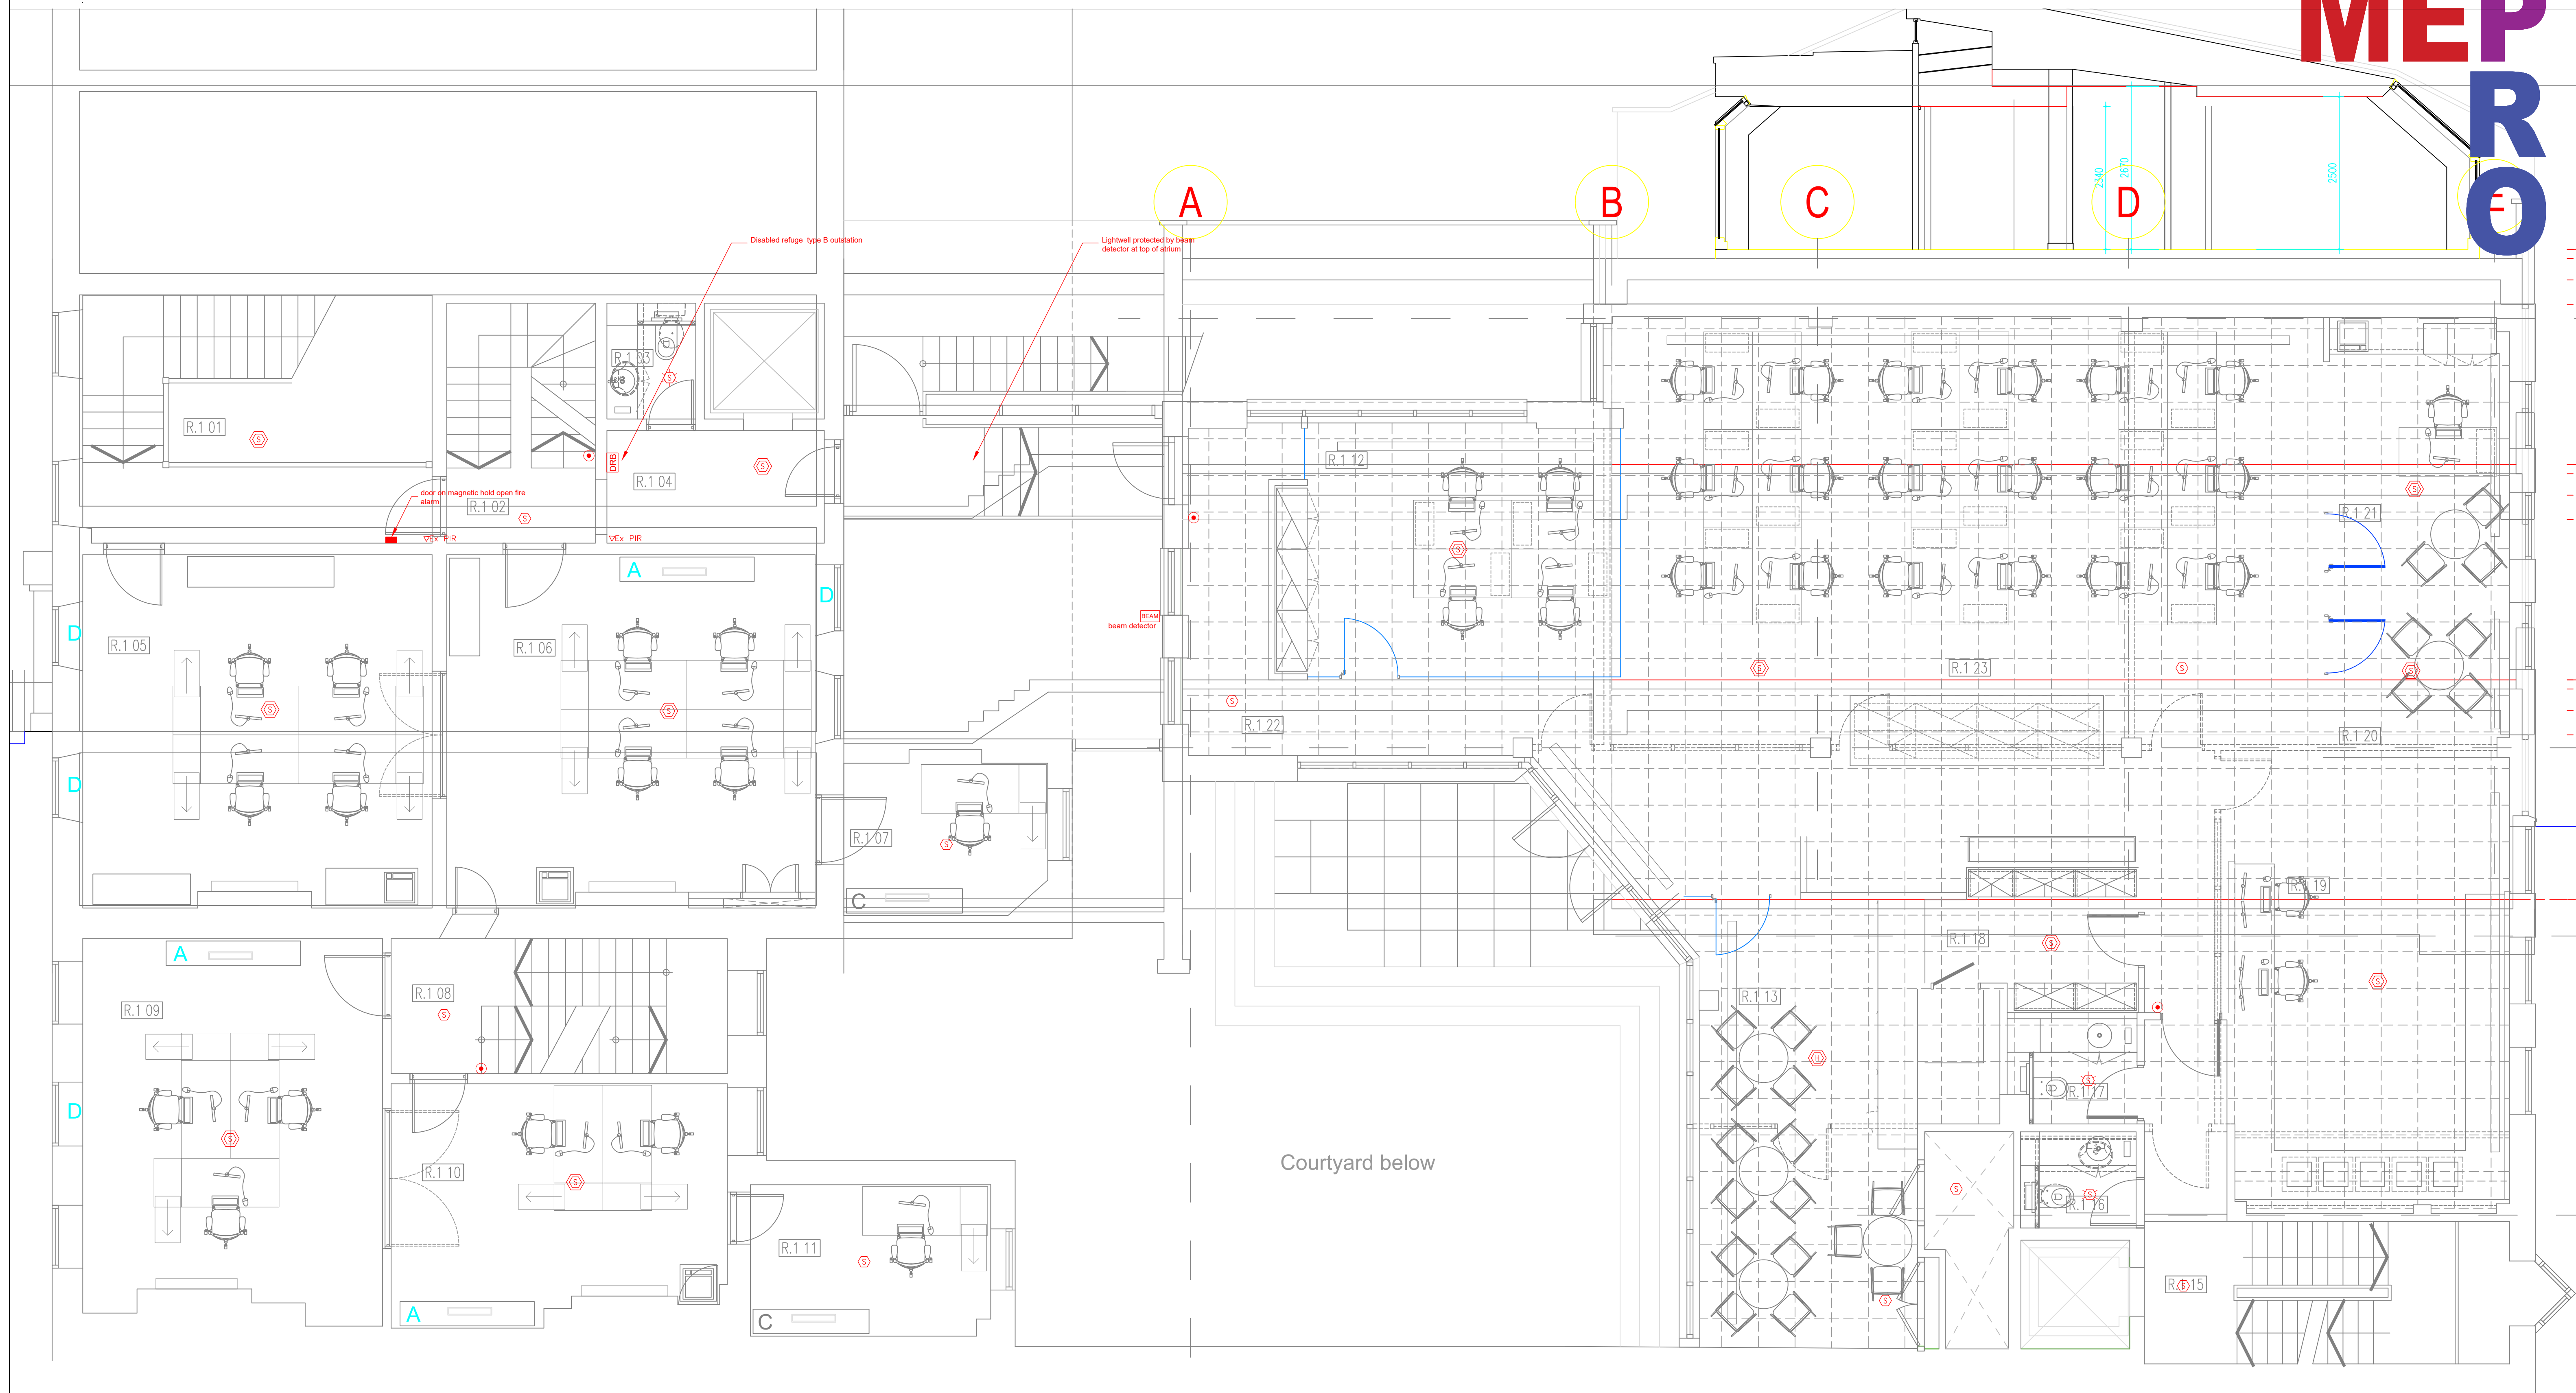

3.1	Sep18	Issued For Comments	PG
2.1	Sep18	Stage 2 Issued For coord	PG
Rev	Date	Description	Aprvd

MEP PRO Building Services  
T +44 (0) 7584 632181  
E [Peter@meppro.co.uk](mailto:Peter@meppro.co.uk)

MEP pro ltd  
17 Parkway  
Woodford Green  
IG8 7RE

**Client**  
**Chambers 7BR**  
7 Bedford Row  
London  
WC1R 4BS

## Project 7BR refurbishment

Drawing Title

Stage 3

First Floor


Electrical Services

Fire Alarm layout

Scale	Date
1:50 at A1	Aug 18
Drawing No.	

2018-1-E3

author  
PG  
revision  
3.1

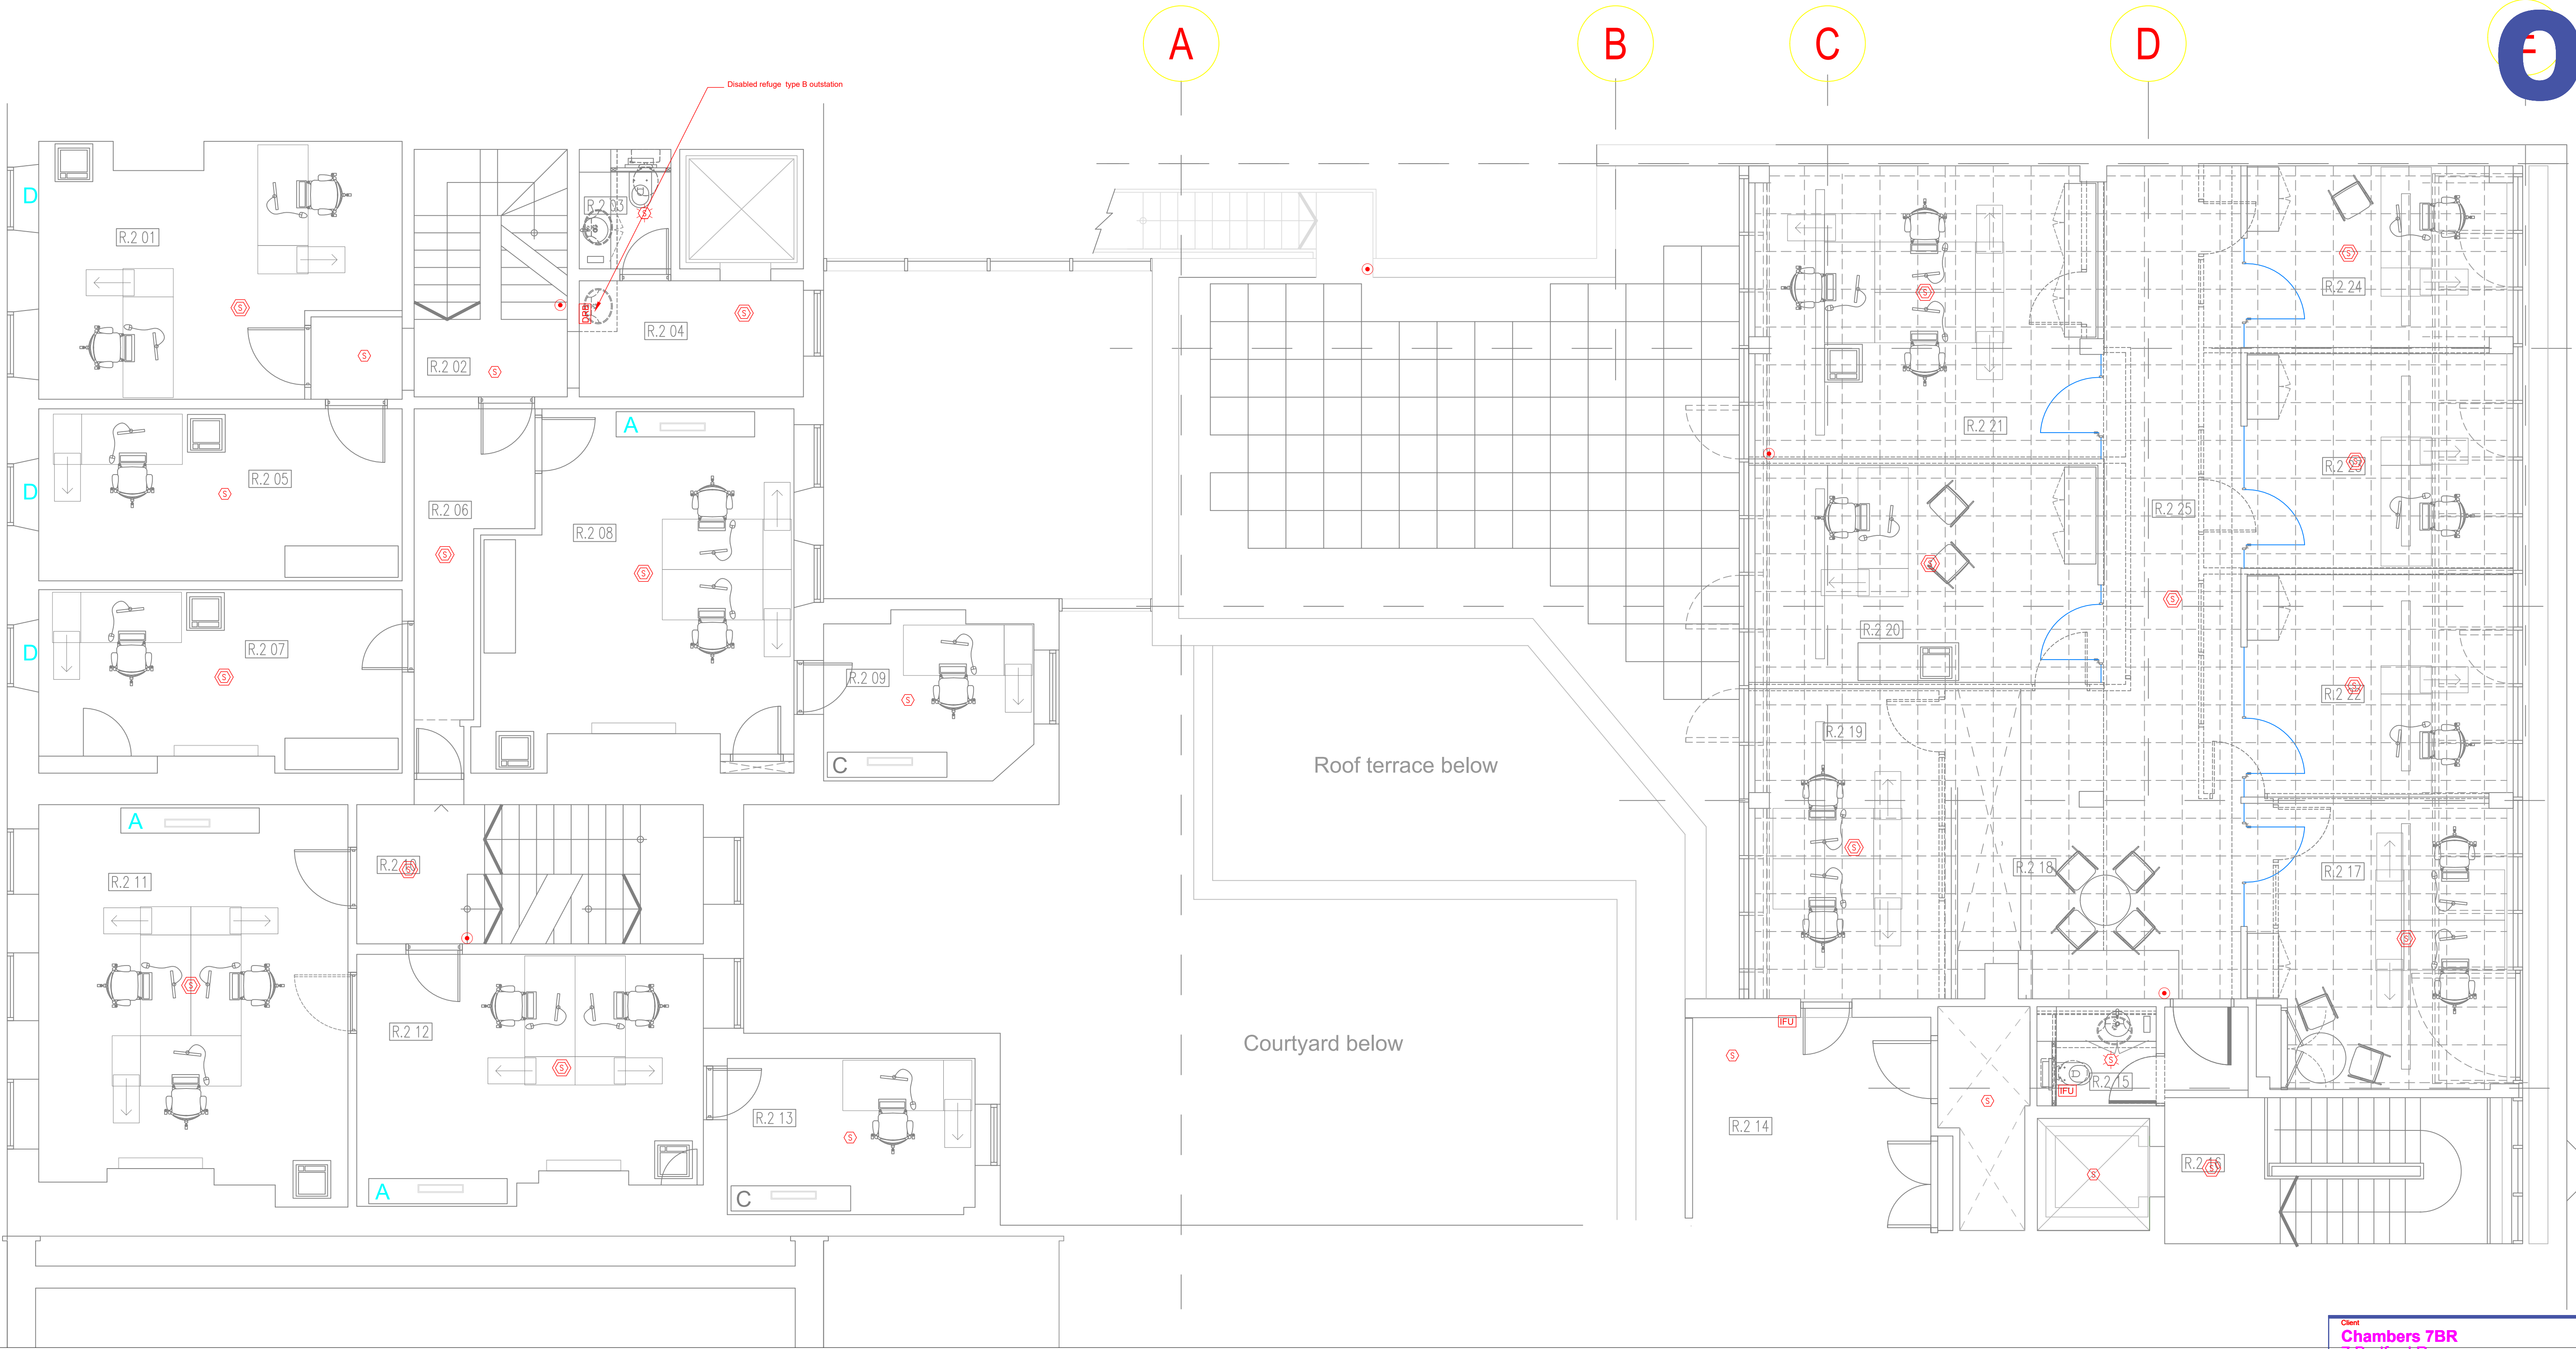

3.1	Sep18	Issued For Comments	PG
2.1	Sep18	Stage 2 Issued For coord	PG
Rev	Date	Description	Aprvd

MEP PRO Building Services  
T +44 (0) 7584 632181  
E Peter@meppro.co.uk

MEP pro Ltd  
17 Parkway  
Woodford Green  
IG8 7RE

Client

Chambers 7BR  
7 Bedford Row  
London  
WC1R 4BS

Project

7BR refurbishment

Drawing Title

Stage 3  
Second Floor  
Electrical Services  
Fire Alarm layout

Scale

1:50 at A1

Date

Aug 18

Author


PG

Drawing No.

2018-2-E3

Revision

3.1

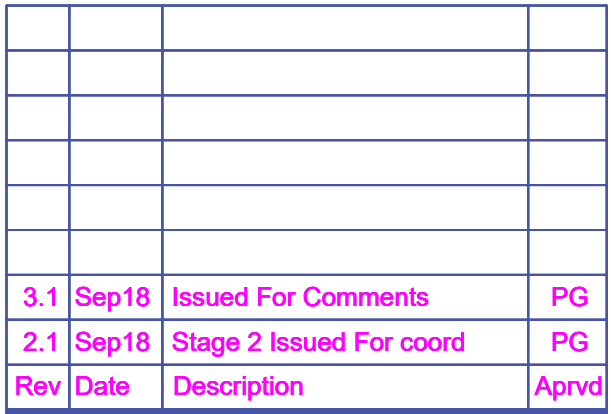






Rev	Date	Description	Aprvd
-----	------	-------------	-------

Rev	Date	Description	Aprvd
-----	------	-------------	-------



MEP PRO Building Services  
T +44 (0) 7584 632181  
E [Peter@meppro.co.uk](mailto:Peter@meppro.co.uk)

Client		
<b>Chambers 7BR</b> 7 Bedford Row London WC1R 4BS		
Project		
<b>7BR refurbishment</b>		
Drawing Title		
<b>Stage 3</b> Lower Ground East Mechanical Services		
Scale	Date	Author
1:50 at A1	Aug 18	PG
Drawing No.	Revision	
2018-LGE-P1	3.1	

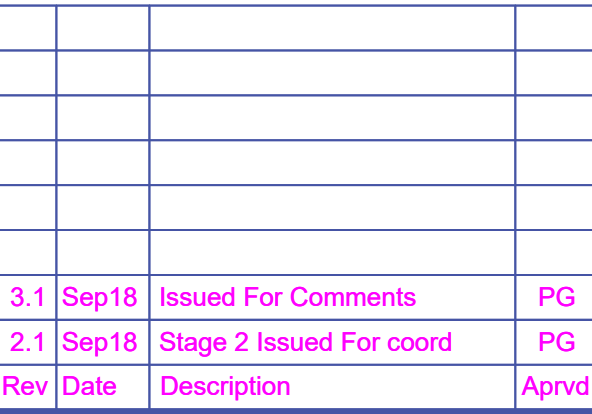


Client		
<b>Chambers 7BR</b> 7 Bedford Row London WC1R 4BS		
Project		
7BR refurbishment		
Drawing Title		
Stage 3 Ground floor Public Health Services		
Scale	Date	Author
1:50 at A1	Aug 18	PG
Drawing No.	Revision	
2018-G-P1	3.1	






<b>Client</b> <b>Chambers 7BR</b> 7 Bedford Row London WC1R 4BS		
<b>Project</b> <b>7BR refurbishment</b>		
<b>Drawing Title</b> <b>Stage 3</b> <b>First Floor</b> <b>Public Health Services</b>		
<b>Scale</b> 1:50 at A1	<b>Date</b> Aug 18	<b>Author</b> PG
<b>Drawing No.</b> 2018-1-P1		<b>Revision</b> 3.1

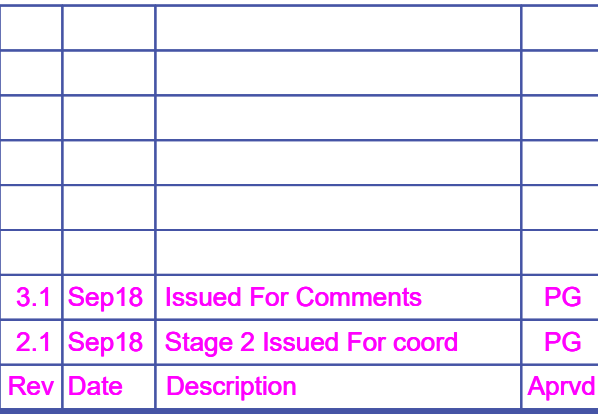

Scale 1:50 at A1	Date Aug 18	Author PG
Drawing No. 2018-2-P1	Revision 3.1	

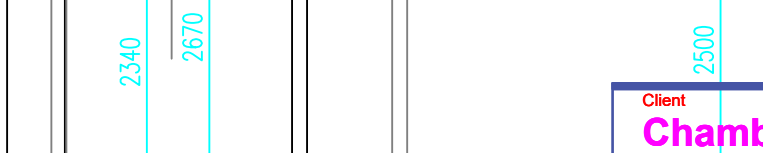

Client	<b>Chambers 7BR</b> 7 Bedford Row London WC1R 4BS	
Project	<b>7BR refurbishment</b>	
Drawing Title	<b>Stage 3</b> Third Floor Public Health Services	
Scale	Date <b>1:50 at A1</b> <b>Aug 18</b>	Author <b>PG</b>
Drawing No.	Revision	
<b>2018-3-P1</b>	<b>3.1</b>	