


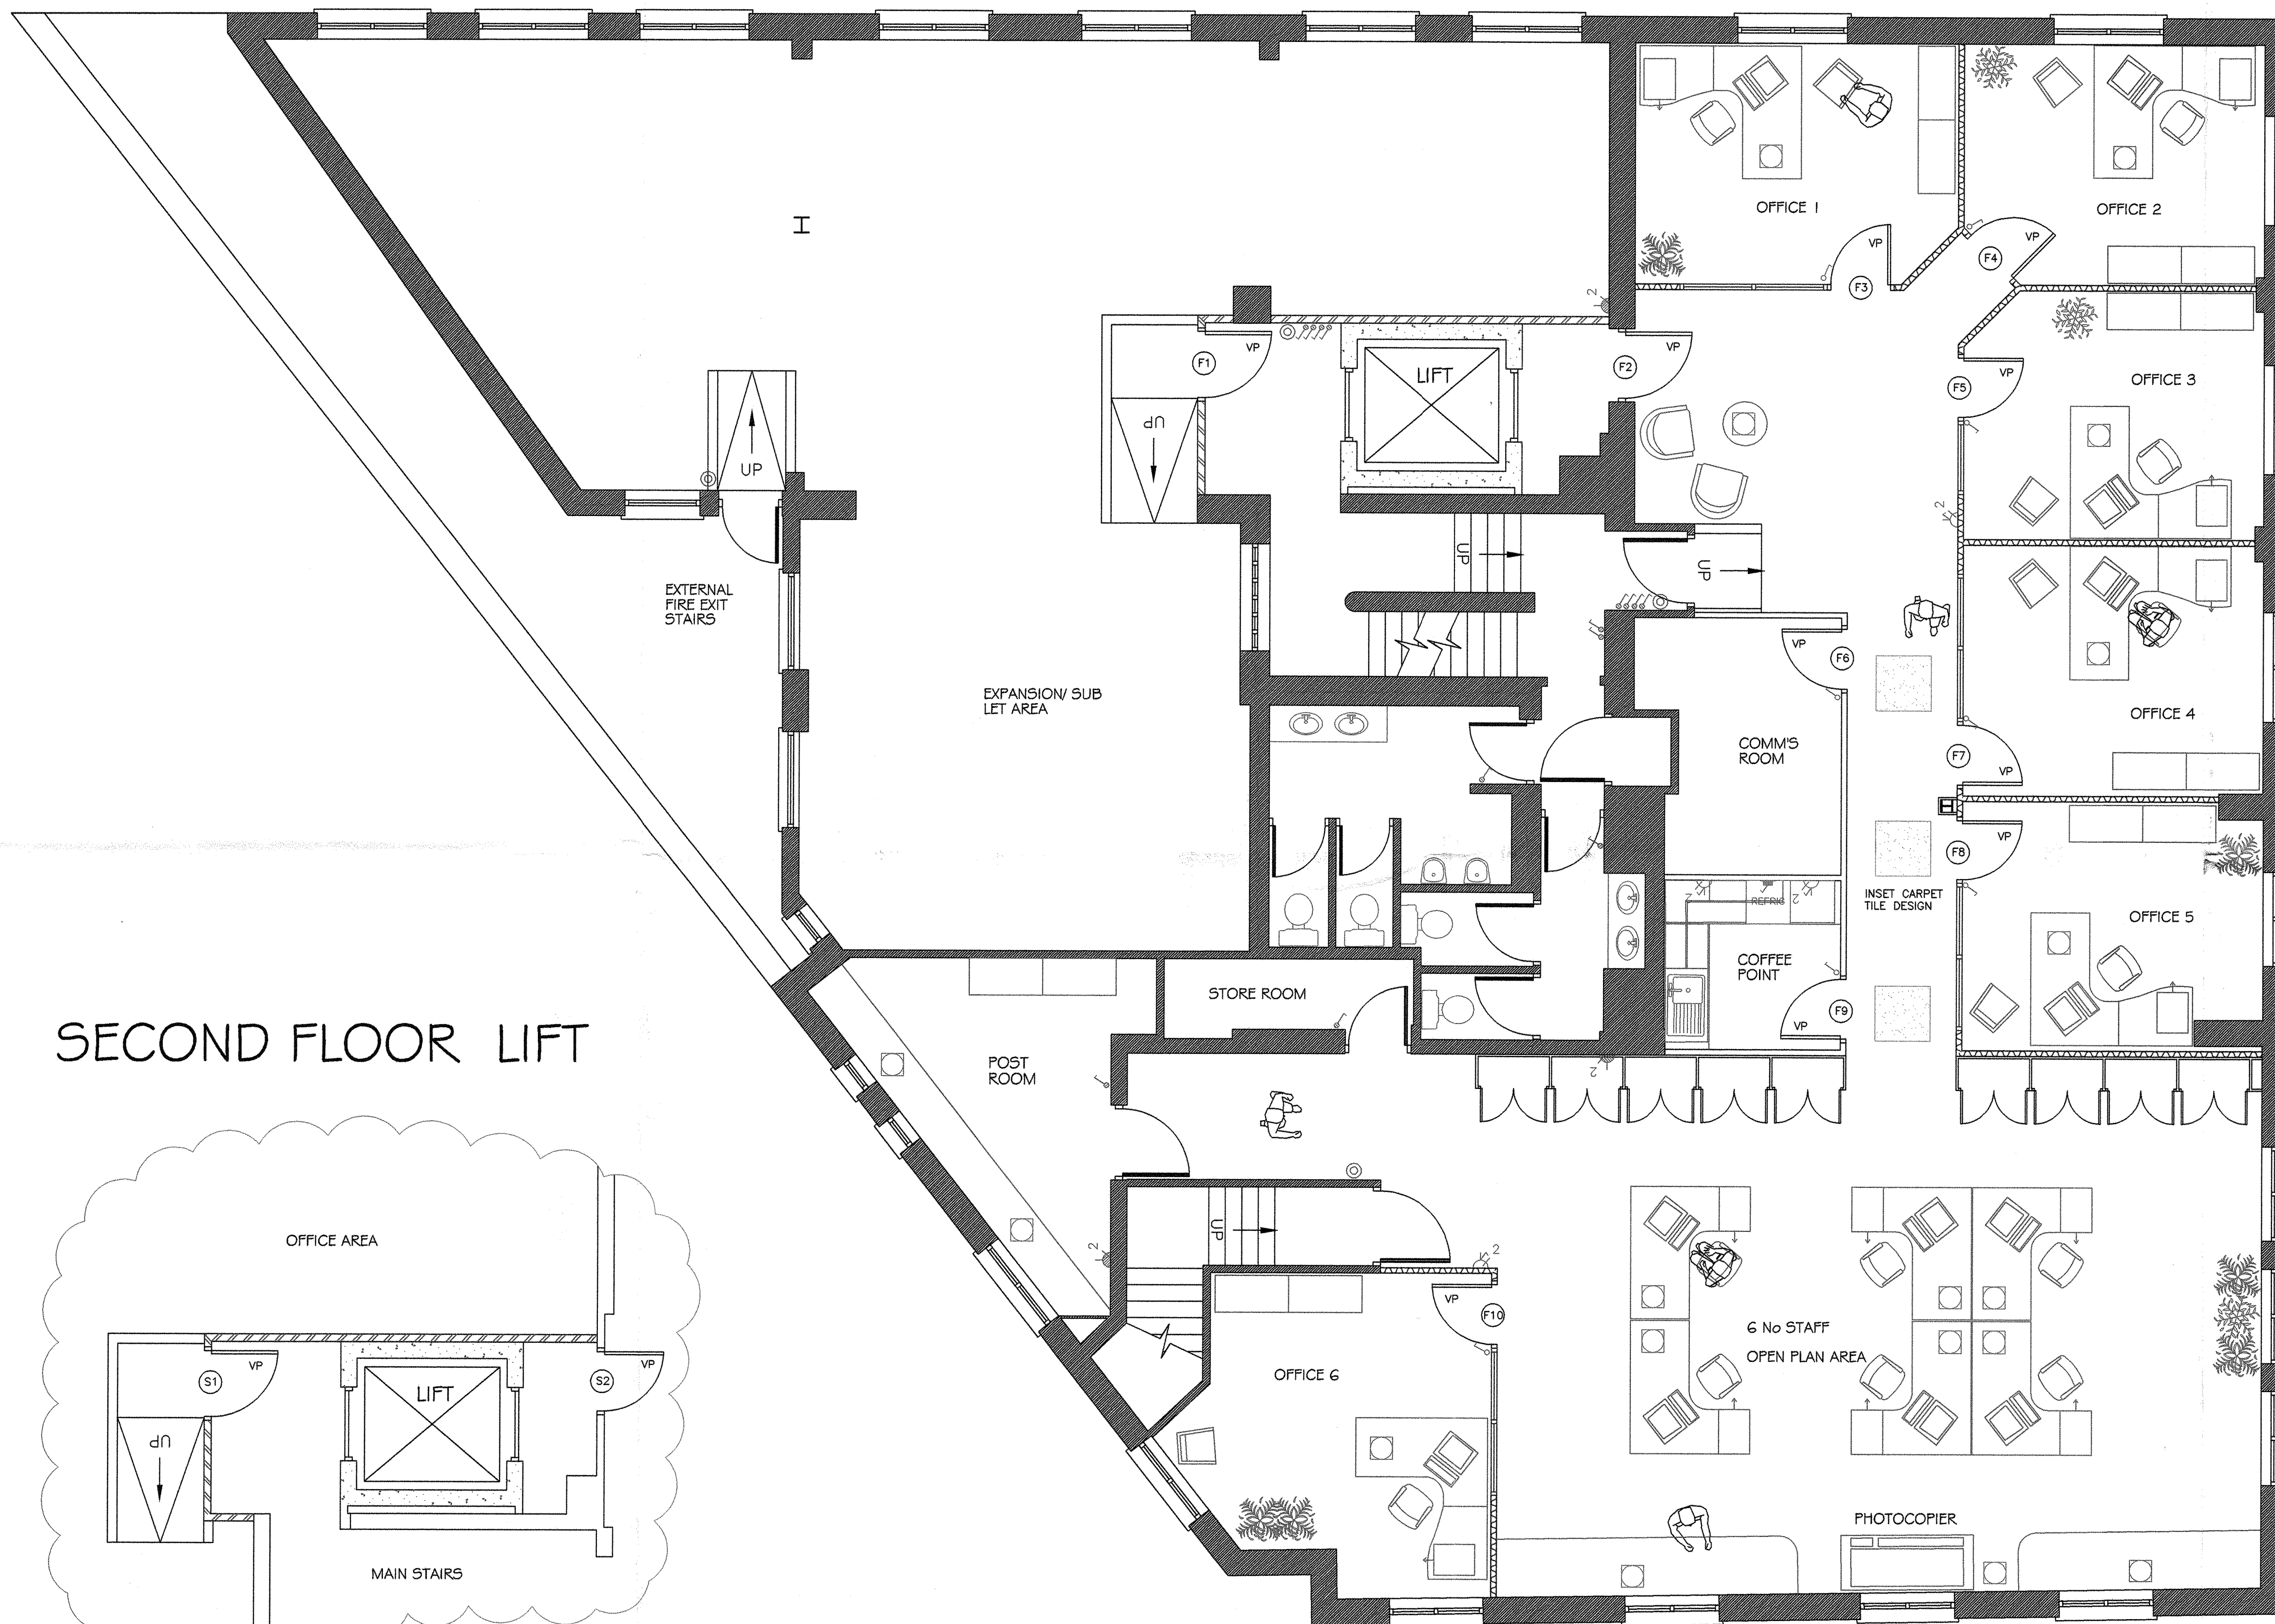

SECOND FLOOR LIFT

FIRST FLOOR

- KEY:
- NEW DOOR HEAD HEIGHT GLAZED PARTITION (KOMFIRE 75)
 - NEW SOLID PARTITION (KOMFIRE 75)
 - NEW SOUND RATED SOLID PARTITION (KOMFIRE 75)
 - NEW HALF HOUR FIRE RATED SOLID PARTITION (KOMFIRE 75)
 - NEW DOOR
 - EXISTING DOOR
 - BEAM DIRECTLY ABOVE CEILING
 - BEAM BELOW CEILING LEVEL
 - NEW 600mm x 600mm VIVID WHITE CEILING GRID WITH LAY-IN MINERAL FIBRE TILES
 - RELOCATED SURFACE MOUNTED SINGLE TUBE LUMINAIRE FITTING
 - NEW 1200mm x 600mm 4 TUBE LUMINAIRE FITTING
 - NEW 1200mm x 600mm 3 TUBE LUMINAIRE FITTING
 - NEW 600mm x 600mm 4 TUBE LUMINAIRE FITTING
 - NEW 600mm x 600mm 3 TUBE LUMINAIRE FITTING
 - LUMINAIRE FITTING INSTALLED WITH EMERGENCY POWER BACKUP
 - NEW 18W COMPACT DOWN LIGHTER
 - NEW RUNNING MAN FIRE EXIT SIGNAGE
 - NEW 3 COMPARTMENT FLOOR BOX
 - NEW TELEPHONE OUTLET
 - EXISTING TELEPHONE OUTLET
 - NEW DOUBLE SWITCHED SOCKET OUTLET
 - EXISTING DOUBLE SWITCHED SOCKET OUTLET
 - NEW SINGLE SWITCHED SOCKET OUTLET
 - EXISTING SINGLE SWITCHED SOCKET OUTLET
 - NEW LIGHT SWITCH
 - EXISTING LIGHT SWITCH
 - NEW SWITCHED SPUR
 - FIRE ALARM BELL
 - SMOKE DETECTOR
 - FIRE ALARM CALL POINT

REV	DESCRIPTION	DATE


This drawing is a copyright and must not be reproduced or copied partially or wholly without written permission.

CLIENT: GCC
 SITE: FIRST FLOOR, 44 WICKLOW STREET, LONDON WC1
 DESCRIPTION: PROPOSED PARTITION LAYOUT

Date: 19/09/02
 Scale: 1:50
 Drg. no. A3442F
 Survey data by Ralco

Ralco Projects Limited
 Fennels Lodge,
 St Peter's Close,
 Loudwater,
 High Wycombe,
 BUCKS. HP11 1JT
 Tel: 01628 529696

ralco
 PROJECTS LIMITED
 Interior Designers and Contractors.

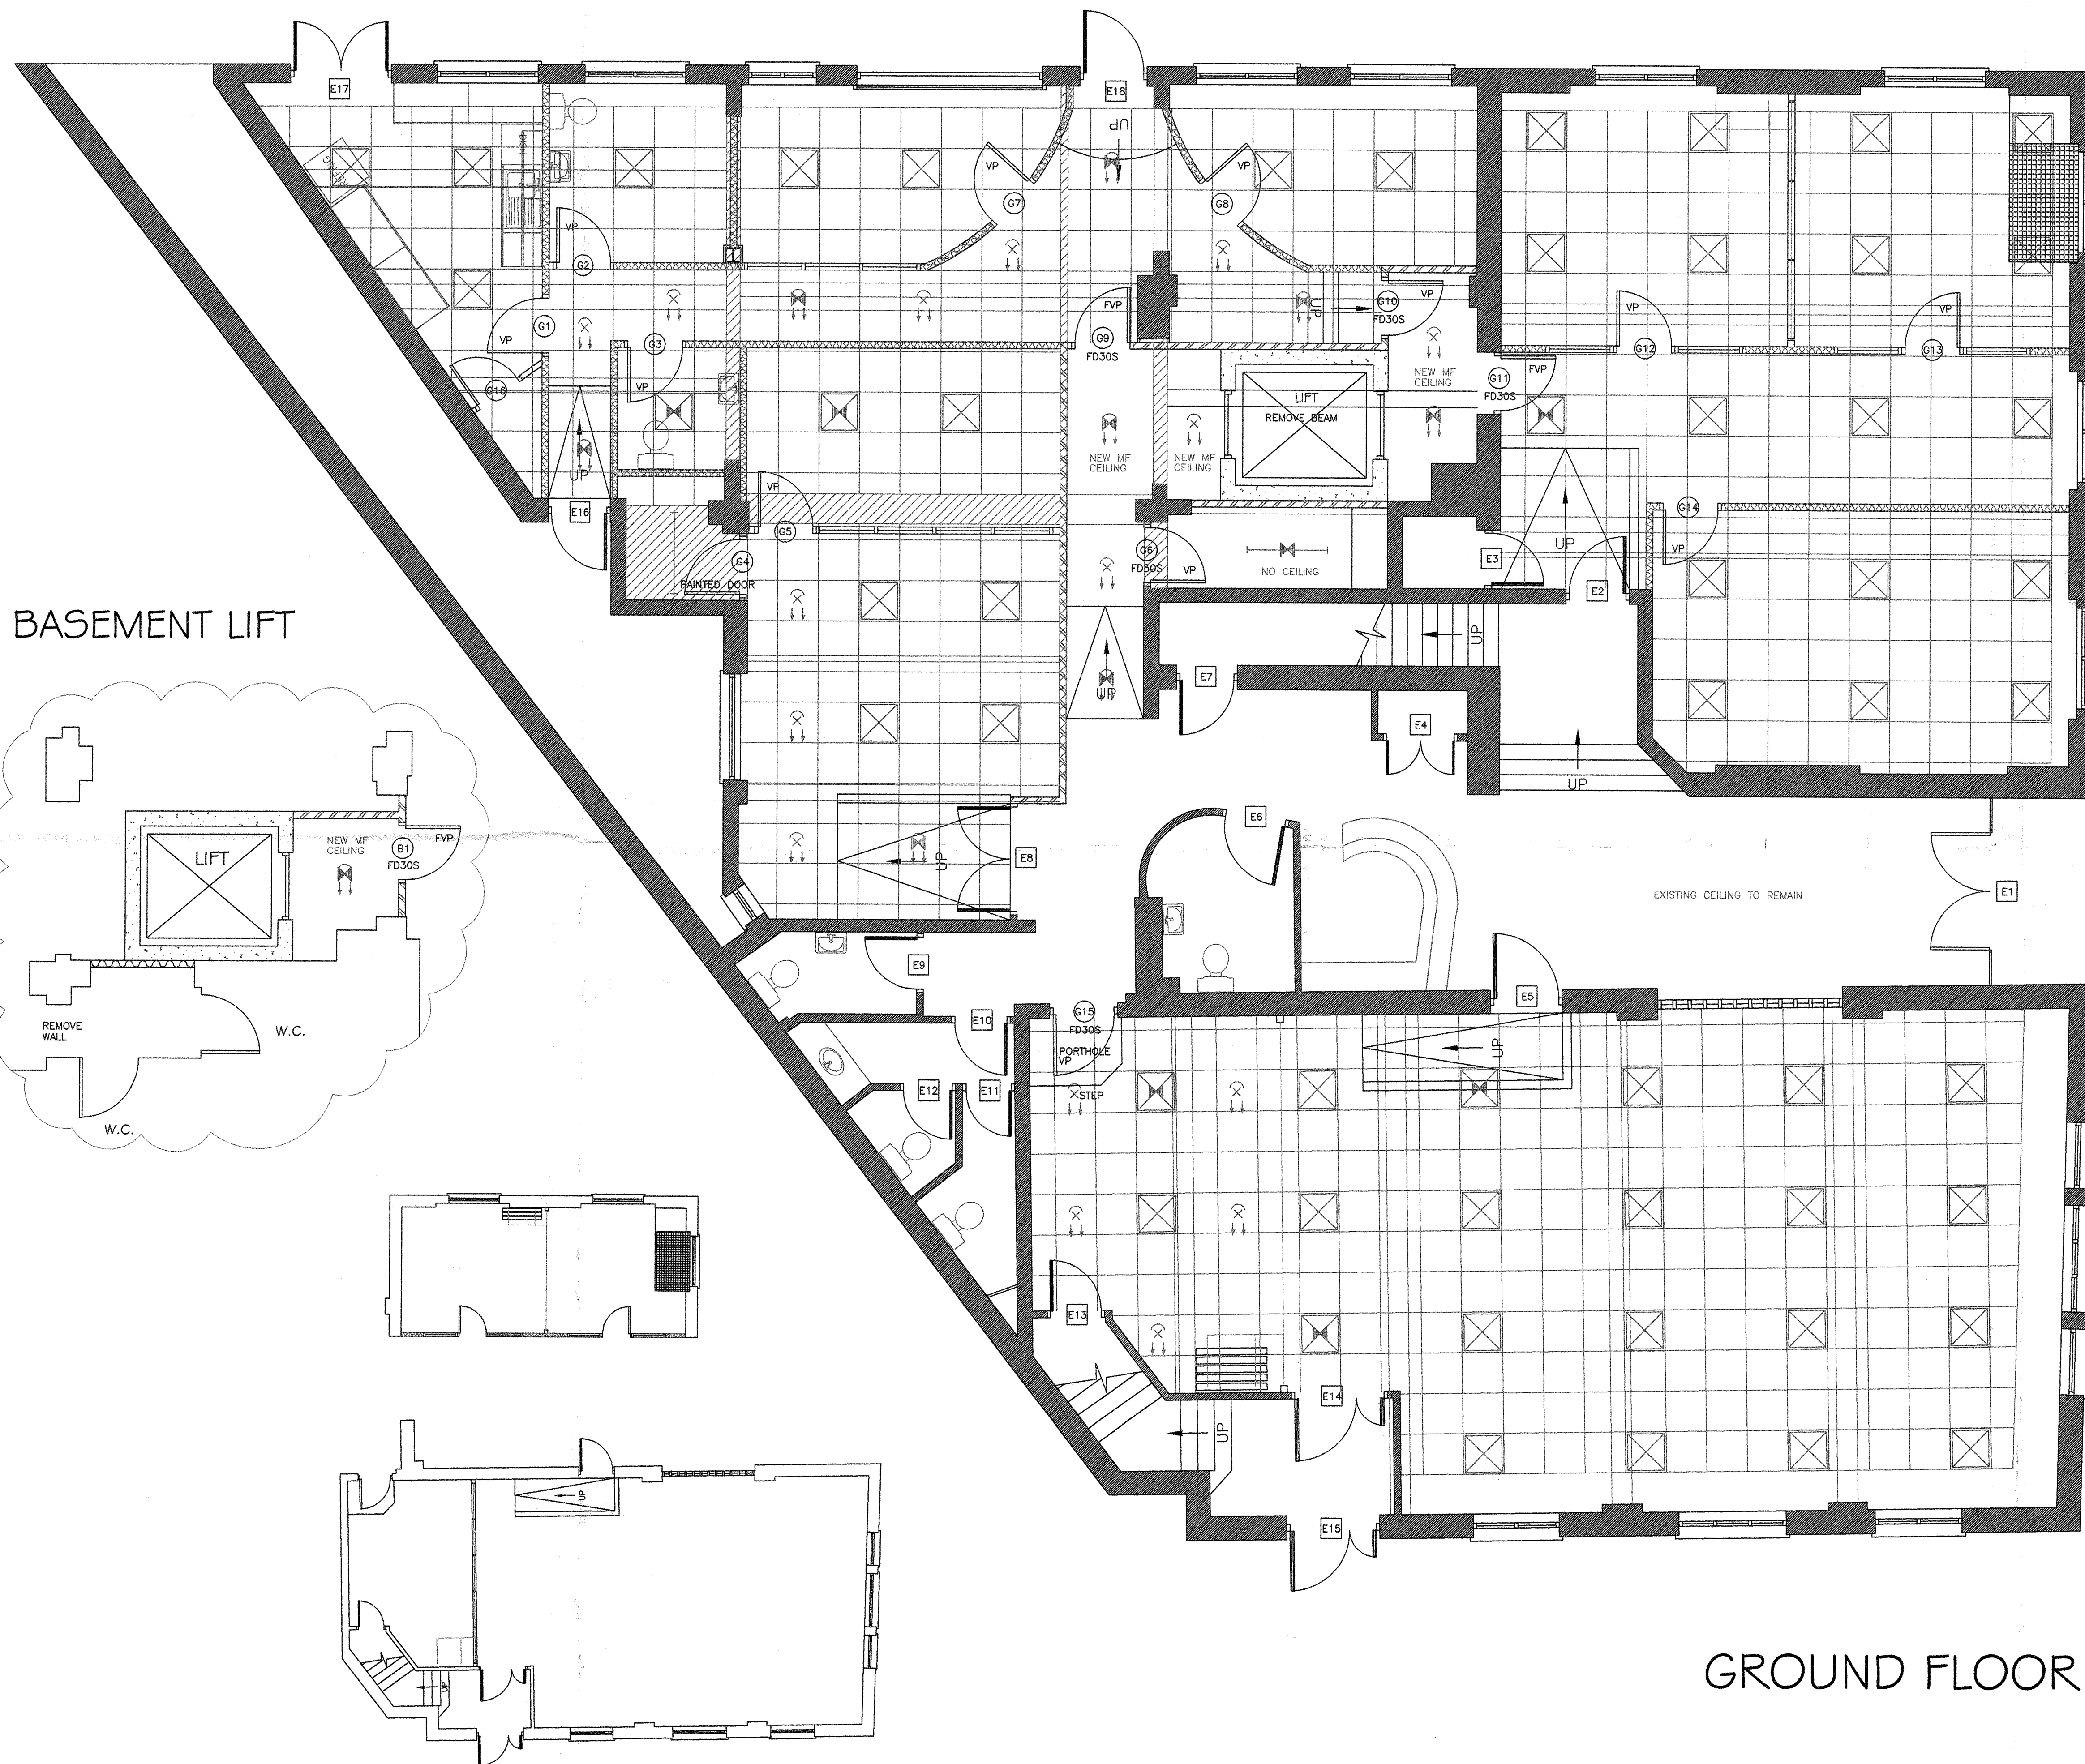

- KEY:**
- NEW DOOR HEAD HEIGHT GLAZED PARTITION (KOMFIRE 100)
 - NEW SOLID PARTITION (KOMFIRE 100)
 - NEW SOUND RATED SOLID PARTITION (KOMFIRE 100)
 - NEW HALF HOUR FIRE RATED SOLID PARTITION (KOMFIRE 100)
 - NEW DOOR
 - EXISTING DOOR
 - BEAM ABOVE CEILING LEVEL
 - BEAM BELOW CEILING LEVEL
 - NEW 600mm x 600mm VIVID WHITE CEILING GRID WITH LAY-IN MINERAL FIBRE TILES
 - RELOCATED SURFACE MOUNTED SINGLE TUBE LUMINAIRE FITTING
 - NEW 1200mm x 600mm 4 TUBE LUMINAIRE FITTING
 - NEW 600mm x 600mm 4 TUBE LUMINAIRE FITTING
 - LUMINAIRE FITTING INSTALLED WITH EMERGENCY POWER BACKUP
 - NEW 18W COMPACT DOWN LIGHTER
 - NEW RUNNING MAN FIRE EXIT SIGNAGE
 - FREE ISSUE 3 COMPARTMENT FLOOR BOX TO CONTAIN 1 DOUBLE SWITCHED SOCKET OUTLET AND 4 NETWORK POINTS
 - FREE ISSUE 3 COMPARTMENT FLOOR BOX TO CONTAIN 2 DOUBLE SWITCHED SOCKET OUTLETS AND 4 NETWORK POINTS
 - NEW TELEPHONE/ DATA NETWORK POINT
 - EXISTING TELEPHONE/ DATA NETWORK POINT
 - NEW DOUBLE SWITCHED SOCKET OUTLET
 - EXISTING DOUBLE SWITCHED SOCKET OUTLET
 - NEW SINGLE SWITCHED SOCKET OUTLET
 - EXISTING SINGLE SWITCHED SOCKET OUTLET
 - NEW LIGHT SWITCH
 - EXISTING LIGHT SWITCH
 - NEW SWITCHED SPUR
 - FIRE ALARM BELL
 - SMOKE DETECTOR
 - FIRE ALARM CALL POINT

REV	DESCRIPTION	DATE
1	ADDITIONAL DOOR INTO CHAMBER ROOM	28/10/02
2	TOTAL REDRAW	17/12/02
3	REVISED POWER LAYOUT/INCLUDED W.C.	14/01/03
4	INCLUDED HIDDEN BEAMS	17/01/03
5	ENLARGED TABLE SIZES/OPTIONAL LAYOUTS	23/01/03
6	INCLUDED DOOR NOTES	27/01/03

This drawing is a copyright and must not be reproduced or copied partially or wholly without written permission.

CLIENT: GCC
 SITE: GROUND FLOOR, 44 WICKLOW STREET, LONDON WC1
 DESCRIPTION: PROPOSED CEILING LAYOUT

Date: 19/09/02

Scale: 1:50

Org. no.A3442GC

Rev 6

Survey data by Ralco

Ralco Projects Limited
 Fennels Lodge,
 St Peter's Close,
 Loudwater,
 High Wycombe,
 BUCKS. HP11 1JT
 Tel: 01628 529696

GROUND FLOOR

ralco

PROJECTS LIMITED

Interior Designers and Contractors.

LEGEND/NOTES

DO NOT SCALE OFF DRAWING
ALL DIMENSIONS TO BE CHECKED ON SITE

- - - - - = ROUTE OF REFRIGERANT PIPEWORK
- - - - - = ROUTE OF CONDENSATE DRAIN
- ☐ = WEATHERPROOF MAINS ISOLATOR
- RC = REMOTE CONTROLLER
- ☐ = AIR HANDLING UNIT
- ▨ = BEAM BELOW FALSE CEILING LINE
- = BEAM IN CEILING VOID
- ☐ = LOSSNAY HEAT RECOVERING DUCT
- = AIR CONDITIONING DUCT WORK
- = FRESH AIR DUCT WORK
- ~~~~~ = 200dia INSULATED FLEXIBLE DUCT
- SA = 4 WAY BLOW SUPPLY AIR DIFFUSERS
- RA = 600 x 600 RETURN EGGCRETE GRILLES

THIS DRAWING TO BE READ INCONJUNCTION
WITH DWG No. H0203/2, /3, /4 & /5

REV	AMENDMENT	DATE
-----	-----------	------

© This design and drawing is the property of HUGGINS & SQUIRE LIMITED
and must not be copied in any form or passed on to any third party
without prior permission in writing from HUGGINS & SQUIRE LIMITED.

**Huggins
& Squire
LIMITED**

incorporating Chiltern Environmental Services
39 Watford Metro Centre, Tolpits Lane, Watford,
Herts WD18 9YE
Tel: 01923 228225 Fax: 01923 227505
Email: info@hugginsandsquire.co.uk

CONTRACT
**44 WICKLOW STREET
LONDON WC1**

TITLE
**BASEMENT
AIR CONDITIONING**


DRWG. NO.	DRAWN	O.L.
H0301/1	DATE	JAN 03
	SCALE	1:50 (A1)

REFRIGERANT PIPEWORK AND
CONDENSATE DRAIN RISES TO ABOVE

DUCTWORK RISES TO ABOVE

WHERE TRAY IS TO BE REMOVED OR RAISED,
THE FIRE ALARM CABLES, ANY MAINS
CABLES OR ANY SERVICES NOT SERVING THE A/C
EQUIPMENT ARE TO BE RE-ROUTED BY OTHERS

WHERE DRAWING SHOWS TRAYS & DUCTING PASSING
UNDER BEAMS (TO BE BOXED IN) IT MAY BE POSSIBLE TO
PASS OVER BEAMS IF HOLES MADE BY OTHERS

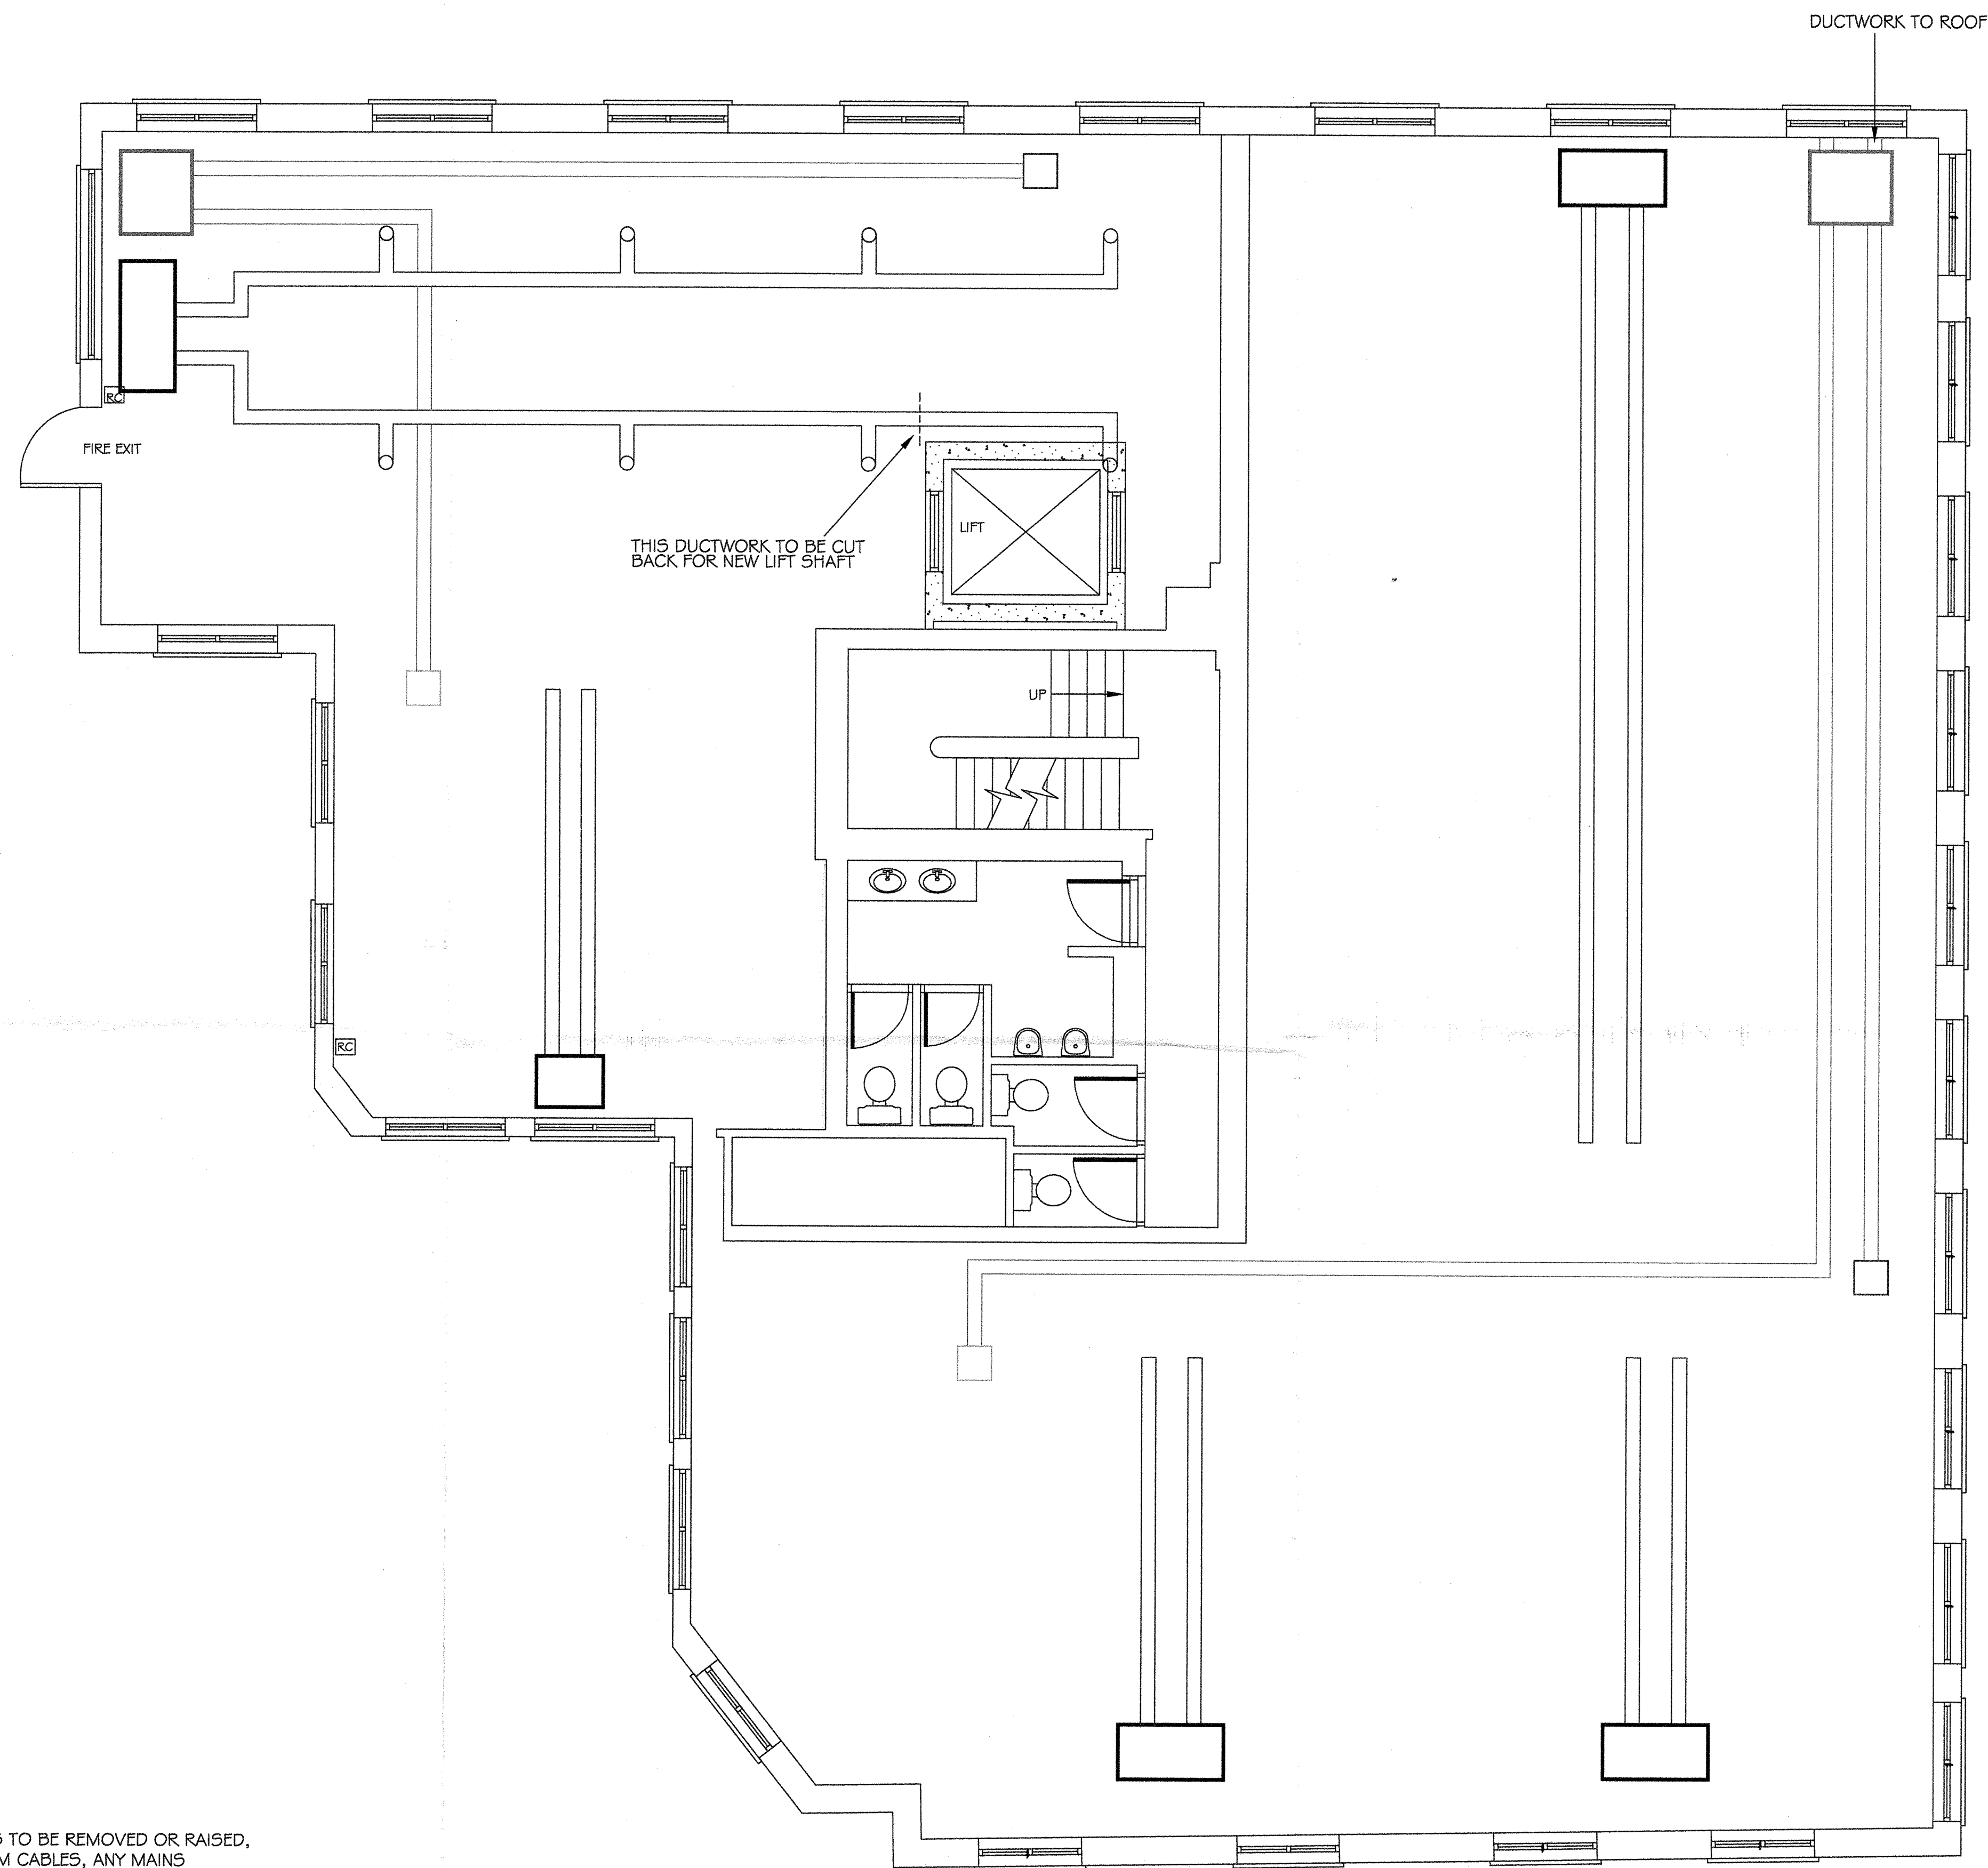

WHERE TRAY IS TO BE REMOVED OR RAISED,
THE FIRE ALARM CABLES, ANY MAINS
CABLES OR ANY SERVICES NOT SERVING THE A/C
EQUIPMENT ARE TO BE RE-ROUTED BY OTHERS

WHERE DRAWING SHOWS TRAYS & DUCTING PASSING
UNDER BEAMS (TO BE BOXED IN) IT MAY BE POSSIBLE TO
PASS OVER BEAMS IF HOLES MADE BY OTHERS

LEGEND/NOTES

DO NOT SCALE OFF DRAWING
ALL DIMENSIONS TO BE CHECKED ON SITE

--- = ROUTE OF REFRIGERANT PIPEWORK

--- = ROUTE OF CONDENSATE DRAIN

□ = WEATHERPROOF MAINS
ISOLATOR

RC = REMOTE CONTROLLER

□ = AIR HANDLING UNIT

/// = BEAM BELOW FALSE CEILING LINE

--- = BEAM IN CEILING VOID

□ = LOSSNAY HEAT RECOVERY
(FRESH AIR) UNIT

--- = AIR CONDITIONING DUCT WORK

--- = FRESH AIR DUCT WORK

~~~~~ = 200dia INSULATED FLEXIBLE DUCT

SA = SUPPLY AIR DIFFUSERS (REUSE  
EXISTING WHERE POSSIBLE)

RA = 600 x 600 RETURN AIR  
EGGCRETE GRILLES (NEW)

□ = SYSTEM REMOVED

THIS DRAWING TO BE READ INCONJUNCTION  
WITH DWG No. H0203/1, /2, /3 & /5

| REV | AMENDMENT | DATE |
|-----|-----------|------|
|-----|-----------|------|

© This design and drawing is the property of HUGGINS & SQUIRE LIMITED  
and must not be copied in any form or passed on to any third party  
without prior permission in writing from HUGGINS & SQUIRE LIMITED.

# Huggins & Squire LIMITED

incorporating Chiltern Environmental Services  
39 Watford Metro Centre, Tolpits Lane, Watford,  
Herts WD18 9YE  
Tel: 01923 228225 Fax: 01923 227505  
Email: info@hugginsandsquire.co.uk

CONTRACT  
44 WICKLOW STREET  
LONDON WC1

TITLE  
SECOND FLOOR  
AIR CONDITIONING

|           |       |           |
|-----------|-------|-----------|
| DRWG. NO. | DRAWN | O.L.      |
| H0301/4   | DATE  | JAN 03    |
|           | SCALE | 1:50 (A1) |