


Important notes for electrical contractor

All directional light fittings to be angled by electrical contractor onto product/ displays/ artwork/ tables/ other in accordance with the lighting drawing/ any designer or client instructions. This must be carried out in advance of the final lighting commissioning/ any programming visit by the lighting consultant/ dimming engineer. Into Lighting do not carry out any works at high level. Where DMX control is shown on the lighting layout the DMX control cabling should be wired in a daisy-chain using Belden 9841 cable, the maximum cable length from the source of the DMX output to the furthest DMX driver is 250m. A maximum of 32 DMX units can be connected to each DMX universe. If you have any questions about how to wire the DMX signal cable please contact Into on 0845 873 7013 or at technical@into.co.uk

Important note for emergency lighting design and specification

Where Into Lighting drawings show layouts for emergency lighting these are provisional layouts to help ensure sympathetic integration into the architecture and general lighting scheme. It is the responsibility of the mechanical and electrical consultant/ contractor to ensure that the emergency lighting scheme and specification meets with BS5266 and any local requirements. Where Into Lighting drawings do not show provisional layouts for emergency lighting it is the responsibility of the mechanical and electrical consultant/ contractor to provide the layout and specification.

It is the responsibility of the installing electrical contractor/ consultant to ensure the appropriate specification, supply and install of fire and/or acoustic hoods / down lights where required. The specification should meet with the specific site requirements, be fully compatible with any down lights specified and be installed in accordance with the manufacturers guidelines.

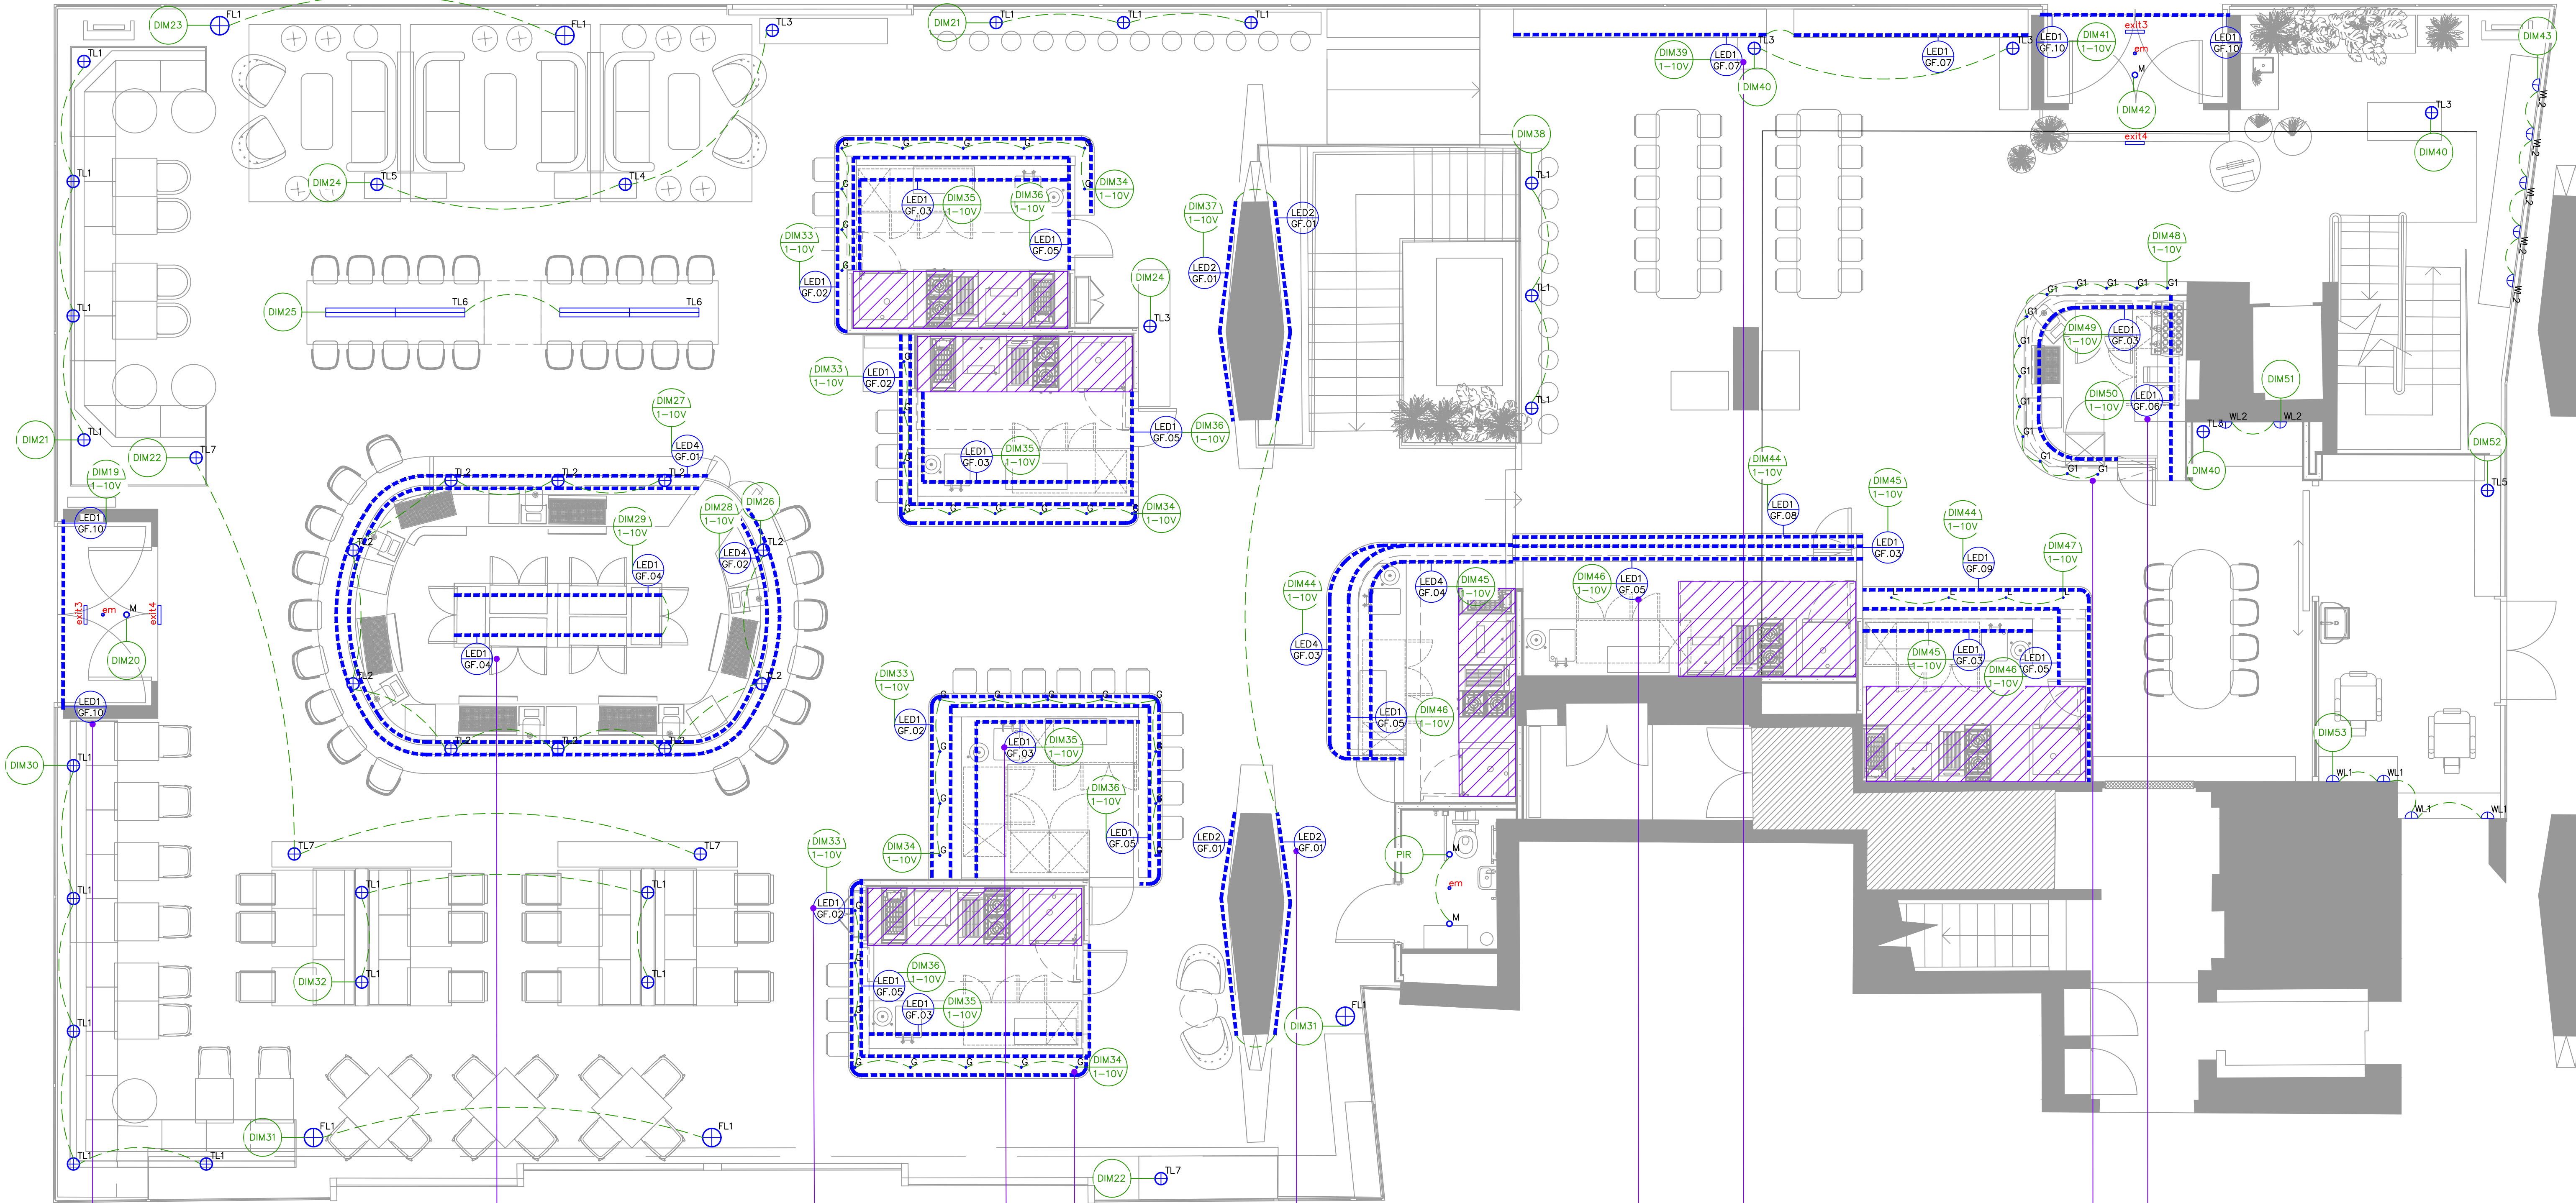

- TYPE: LED1 GF.10
SURFACE MOUNTED LINEAR LUMINAIRE
- SINGLE RUN IN A GOAL POST DESIGN
AROUND ENTRANCE DOOR. EXACT
LOCATION / DETAIL SHOWN FOR
PLANNING.
- TYPE: LED1 GF.04
SURFACE MOUNTED LINEAR LUMINAIRE
CONCEALED WITHIN THE DISPLAY IN
THE CENTRAL BAR. EXACT LOCATION /
DETAIL SHOWN FOR PLANNING.
- TYPE: LED1 GF.02
SURFACE MOUNTED LINEAR LUMINAIRE
CONCEALED WITHIN BAR NOSING
WASHING DOWN. EXACT LOCATION /
DETAIL SHOWN FOR PLANNING.
- TYPE: LED1 GF.03
SURFACE MOUNTED LINEAR LUMINAIRE
CONCEALED TO THE WORKING SIDE OF
THE BAR. EXACT LOCATION / DETAIL
SHOWN FOR PLANNING.
- TYPE: G
RECESSED FIXED DOWNLIGHT TO THE
UNDERSIDE OF THE GANTRY WASHING
DOWN. EXACT LOCATION / DETAIL
SHOWN FOR PLANNING.
- TYPE: LED2 GF.01
SURFACE MOUNTED LINEAR LUMINAIRE
MOUNTED AT THE BASE OF THE
COLUMNS WASHING UP. EXACT
LOCATION / DETAIL SHOWN FOR
PLANNING.
- TYPE: LED1 GF.05
SURFACE MOUNTED LINEAR LUMINAIRE
CONCEALED WITHIN GANTRY SHELVING,
1 NO SHELF IN TOTAL. EXACT
LOCATION / DETAIL SHOWN FOR
PLANNING.
- TYPE: LED1 GF.07
SURFACE MOUNTED LINEAR LUMINAIRE
CONCEALED WITHIN WINDOW DISPLAY.
EXACT LOCATION / DETAIL SHOWN FOR
PLANNING.
- TYPE: G1
RECESSED FIXED DOWNLIGHT TO BAR
NOSING WASHING DOWN. EXACT
LOCATION / DETAIL SHOWN FOR
PLANNING.
- TYPE: LED1 GF.06
SURFACE MOUNTED LINEAR LUMINAIRE
CONCEALED WITHIN BACK BAR
SHELVING. EXACT LOCATION / DETAIL
SHOWN FOR PLANNING.

NOTE:
ALL LOCATIONS OF NON-FIXED FURNISHINGS SHOWN ARE
INDICATIVE ONLY. DMX CABLING TO BE RUN TO CENTRAL
PILOTI'S TO ENABLE FUTURE RGB ADDITIONS.

INTO LIGHTING LEGEND									
⊕	RECESSED FIXED DOWNLIGHT C/W 500MA 1.7W LED	⊕	RECESSED ADJUSTABLE DOWNLIGHT C/W 250MA 12W LED	LED1 GF.07	SURFACE MOUNTED LINEAR LUMINAIRE C/W 24V 13.2W LED	LED2 GF.01	SURFACE MOUNTED LINEAR LUMINAIRE C/W 500MA 1.7W LED PER LED	LED4 GF.01	SURFACE MOUNTED LINEAR LUMINAIRE C/W 24V 13.2W LED
⊕1	RECESSED FIXED DOWNLIGHT C/W 500MA 1.7W LED	LED1 GF.02	SURFACE MOUNTED LINEAR LUMINAIRE C/W 24V 13.2W LED	LED1 GF.09	SURFACE MOUNTED LINEAR LUMINAIRE C/W 24V 13.2W LED	LED4 GF.02	SURFACE MOUNTED LINEAR LUMINAIRE C/W 24V 13.2W LED	LED4 GF.03	SURFACE MOUNTED LINEAR LUMINAIRE C/W 24V 13.2W LED
⊕	SEMI-RECESSED ADJUSTABLE SPOTLIGHT C/W 700MA 2.4W LED	LED1 GF.03	SURFACE MOUNTED LINEAR LUMINAIRE C/W 24V 13.2W LED	LED1 GF.04	SURFACE MOUNTED LINEAR LUMINAIRE C/W 24V 13.2W LED	LED4 GF.04	SURFACE MOUNTED LINEAR LUMINAIRE C/W 24V 13.2W LED	LED4 GF.04	SURFACE MOUNTED LINEAR LUMINAIRE C/W 24V 13.2W LED
⊕1	SURFACE MOUNTED FEATURE TABLE LAMP - FITTING TO BE CONFIRMED	⊕4	SURFACE MOUNTED FEATURE TABLE LAMP C/W 230V 1.5W LED	⊕7	SURFACE MOUNTED FEATURE TABLE LAMP C/W 230V 6W LED	⊕2	SURFACE MOUNTED FEATURE WALL LIGHT - FITTING TO BE CONFIRMED	⊕3	SURFACE MOUNTED FEATURE WALL LIGHT C/W 3W LED 3HOUR EMERGENCY BATTERY PACK
⊕2	SURFACE MOUNTED FEATURE TABLE LAMP - FITTING TO BE CONFIRMED	⊕5	SURFACE MOUNTED FEATURE TABLE LAMP - FITTING TO BE CONFIRMED	⊕1	FREESTANDING FEATURE FLOOR LAMP C/W 2 X 230V 1.5W LED	⊕1	SURFACE MOUNTED FEATURE WALL LIGHT - FITTING TO BE CONFIRMED	⊕3	SEMI-RECESSED EMERGENCY EXIT SIGN C/W LED 3HOUR EMERGENCY BATTERY PACK - ARROW DOWN
⊕3	SURFACE MOUNTED FEATURE TABLE LAMP C/W 230V 6W LED	⊕6	SURFACE MOUNTED FEATURE TABLE LAMP - FITTING TO BE CONFIRMED	⊕1	SURFACE MOUNTED FEATURE WALL LIGHT - FITTING TO BE CONFIRMED	⊕3	SEMI-RECESSED EMERGENCY EXIT SIGN C/W LED 3HOUR EMERGENCY BATTERY PACK - ARROW DOWN	⊕3	SEMI-RECESSED EMERGENCY EXIT SIGN C/W LED 3HOUR EMERGENCY BATTERY PACK - ARROW DOWN

Symbols in key are not to scale

PROPOSED FOR PLANNING

Rev E NEW GA / GENERAL REVISION

Rev D REVISIONS BUBBLED IN RED

Rev C REVISIONS BUBBLED IN RED

Project Title STREET MARKETS LTD, CENTRE POINT, LINK BUILDING, W1		
Drawing Title PROPOSED LIGHTING LAYOUT FOR PLANNING - GROUND FLOOR FLOOR POWER		
Date 25.10.18	Drawn CM	Scale 1:50 @ A1
Project 12561	Number P01	Revision E

into Lighting Ltd
4 O'Neara Street
London
SE1 1TE
T: +44 (0) 845 873 7013
F: +44 (0) 845 873 7018
E: email@into.co.uk

This drawing and all associated documents issued for the purposes of design information remain the intellectual property of into Lighting Limited.
The drawing and all associated documents or information developed from their contents may not be reproduced or transmitted in any form or by any means electronic, mechanical, photocopying, recording, or by any information storage or retrieval system, without prior written permission from into Lighting Limited. In the event that this occurs, into Lighting Limited reserves the right to remove a design from the drawing and/or to take legal action against the user. Any queries should be checked with the design team.

All dimensions must be checked on site
Do not scale from this drawing