
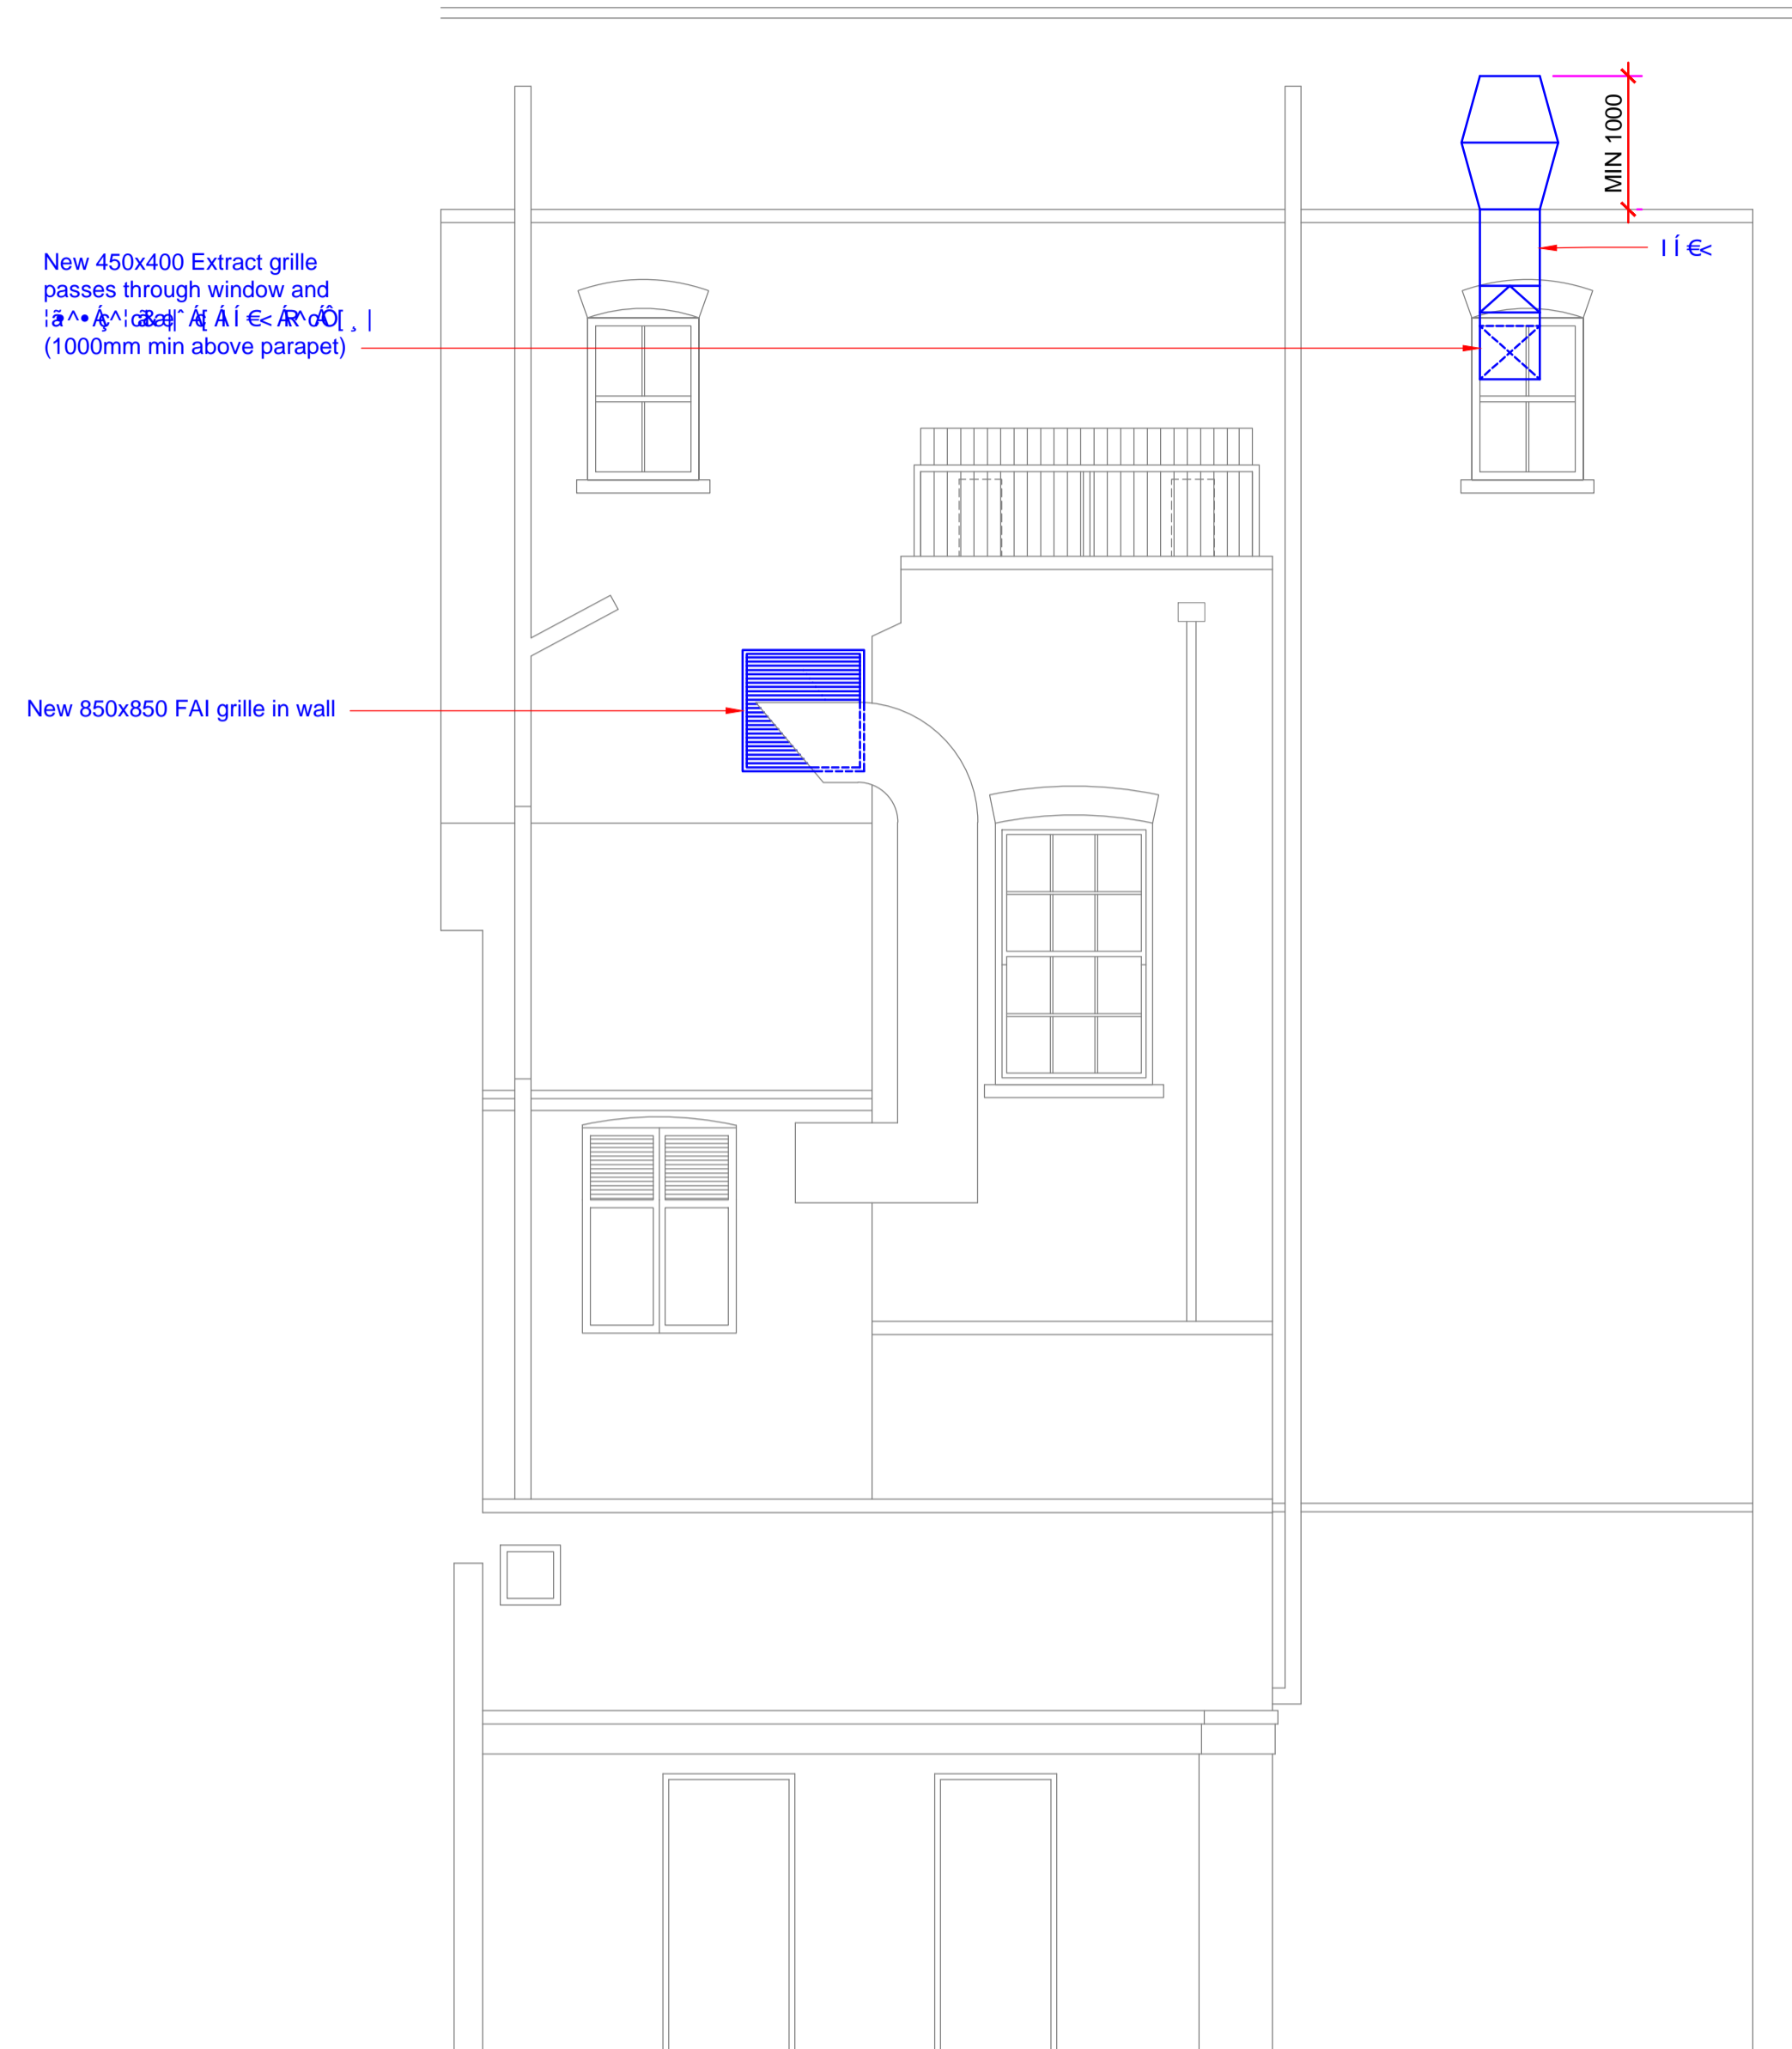
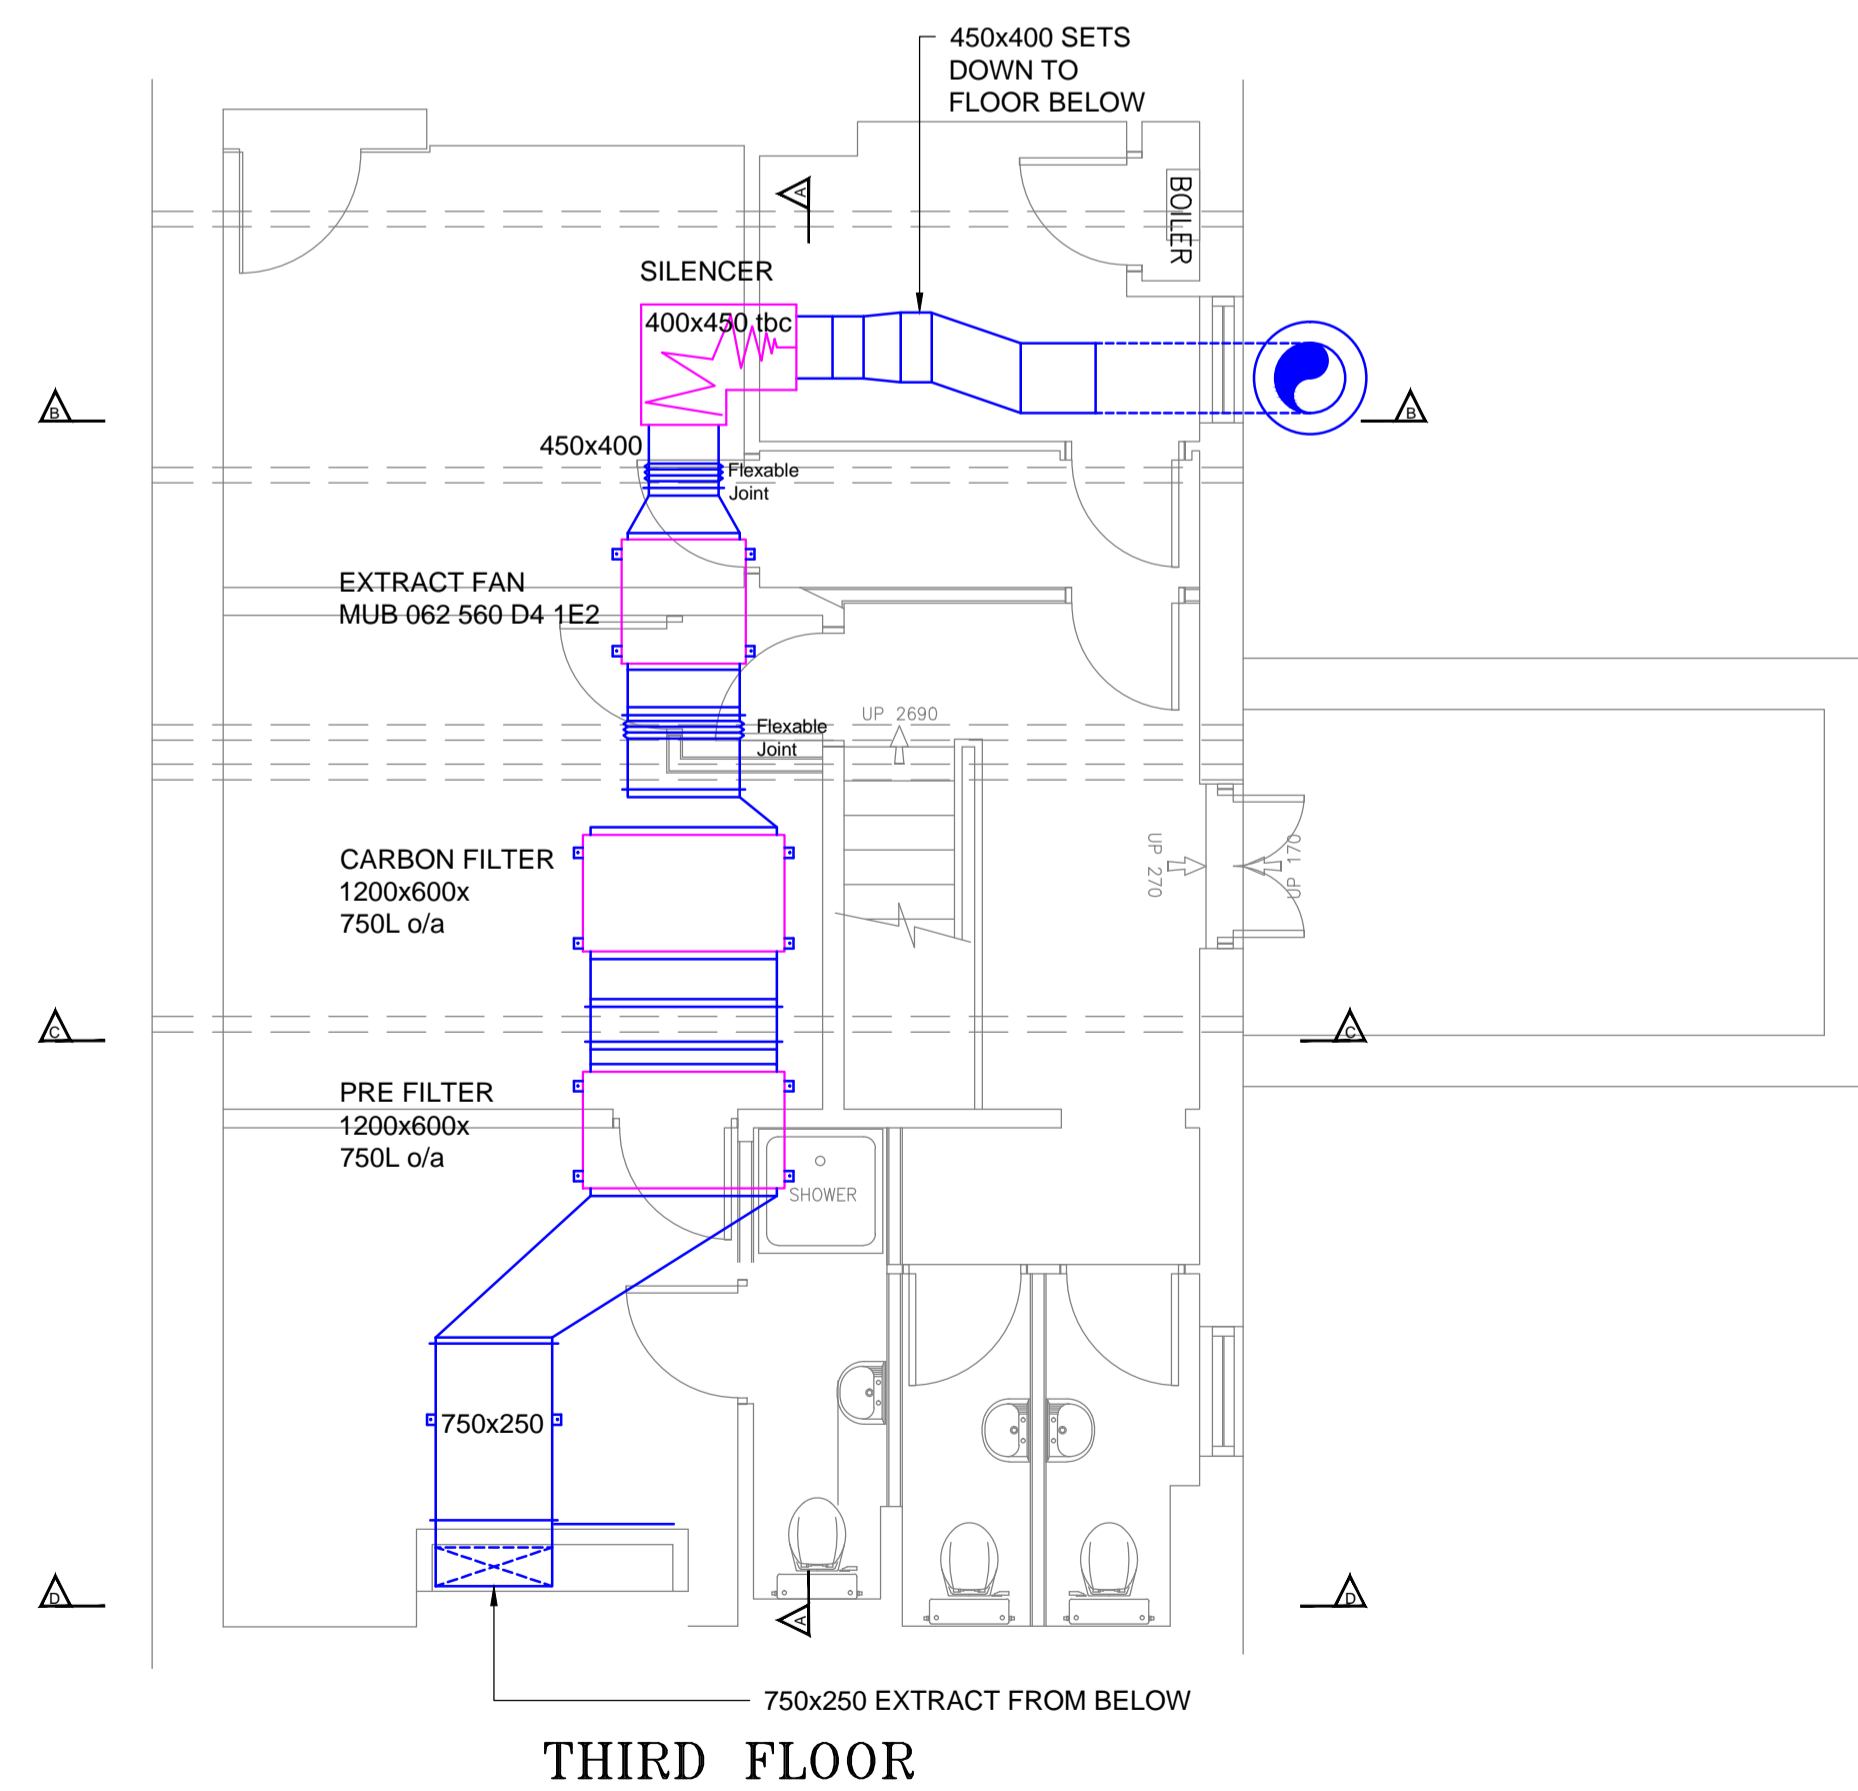
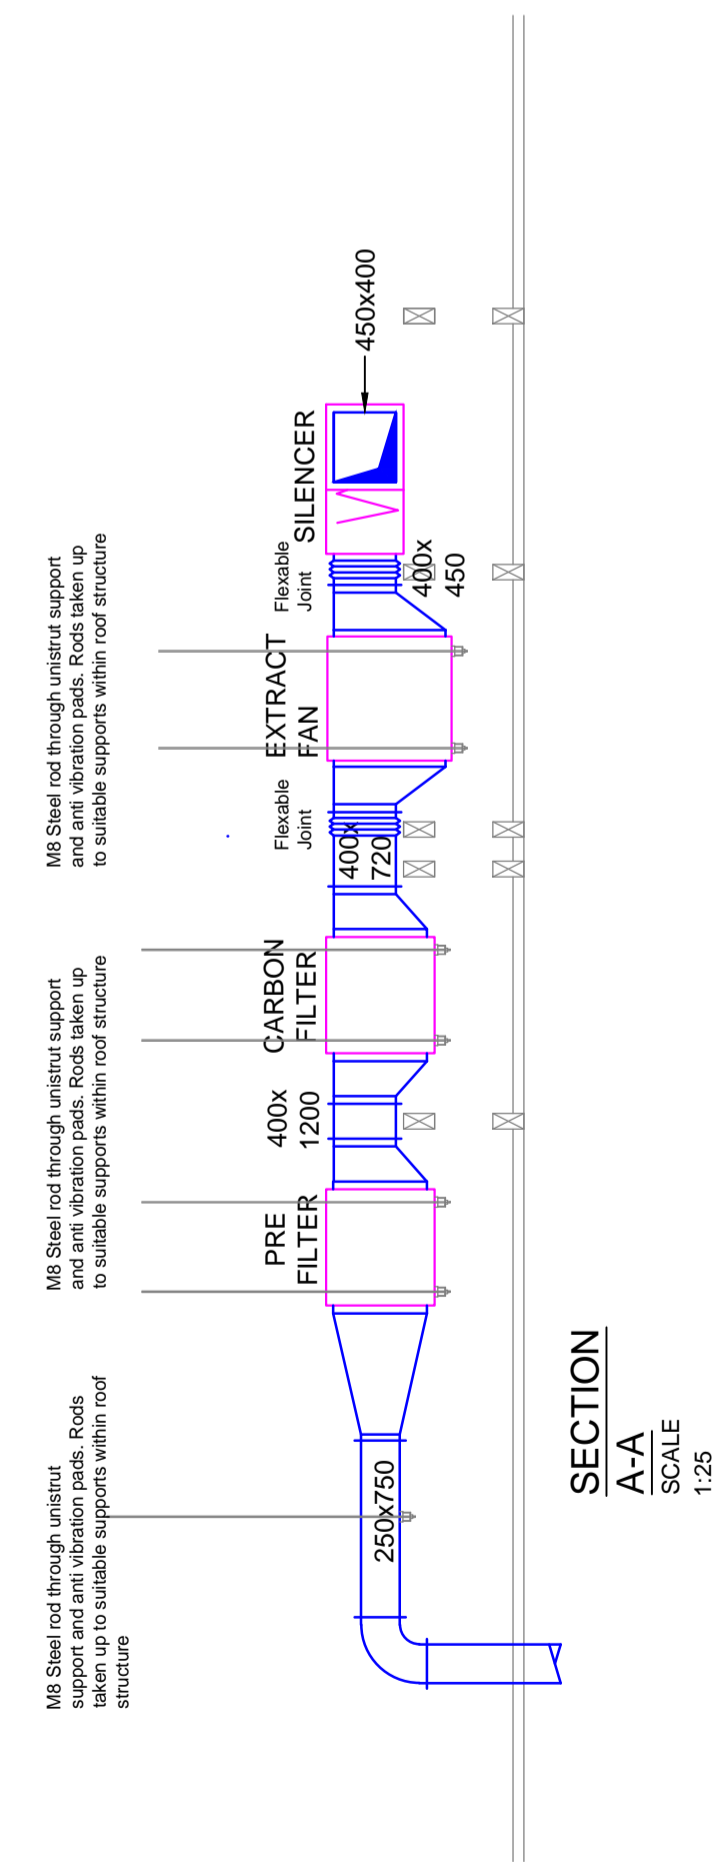
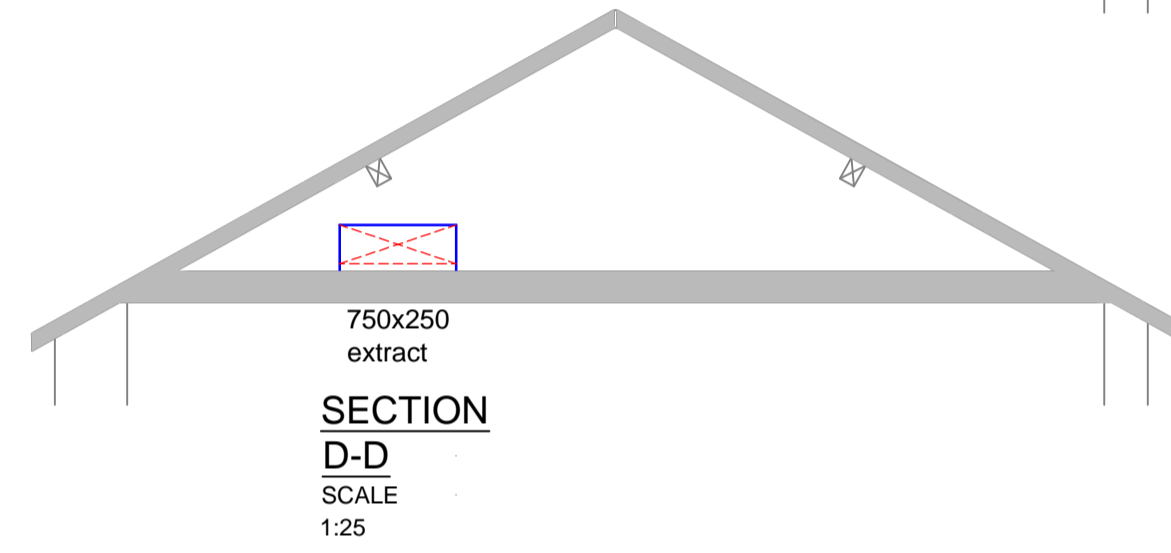
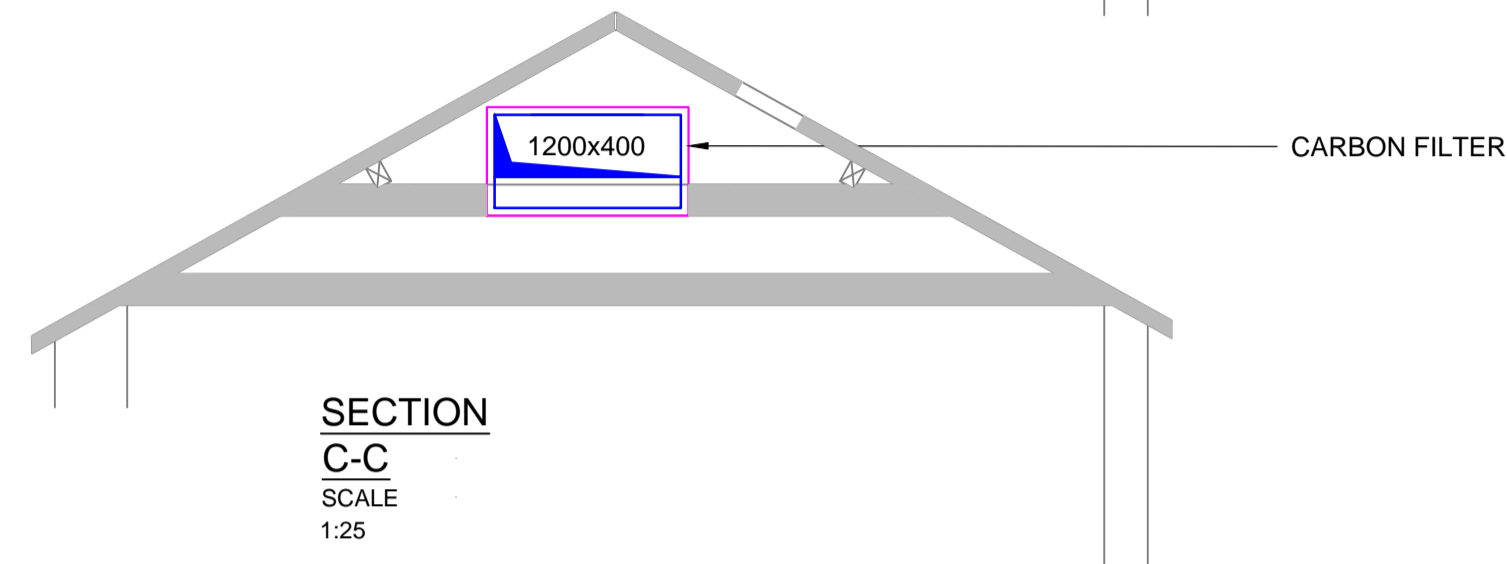
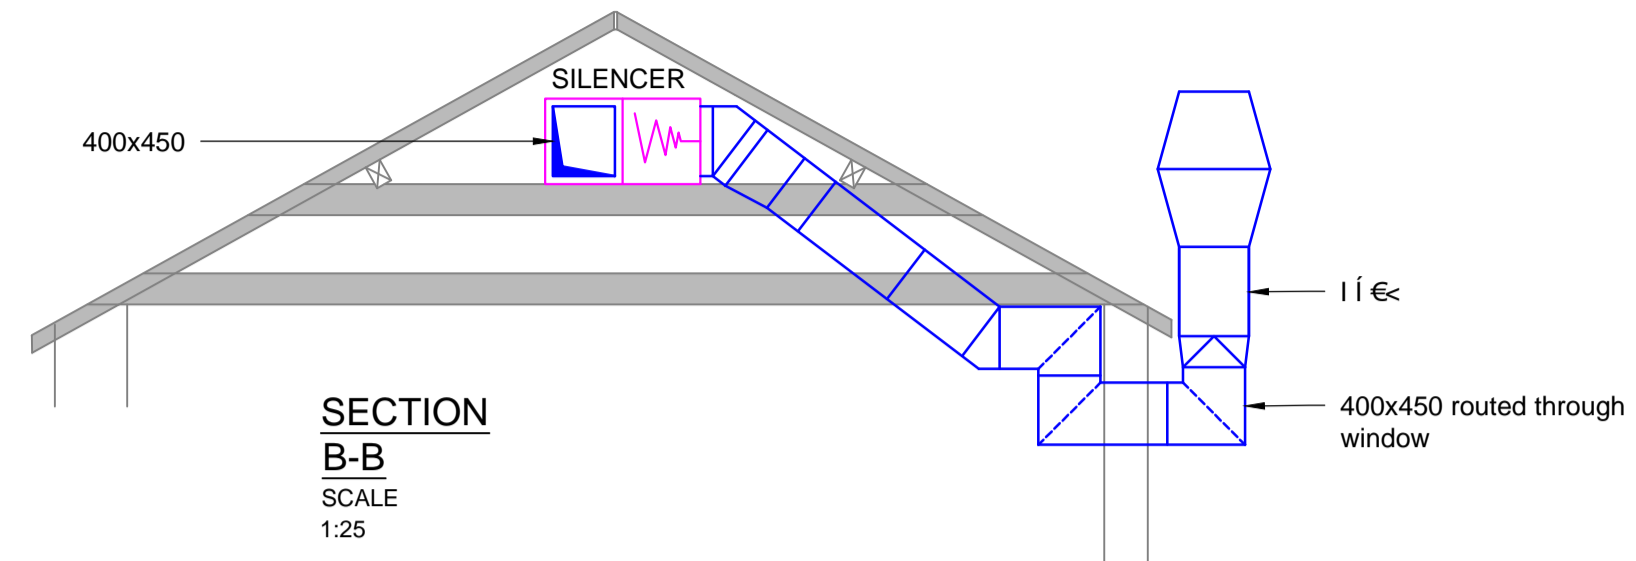


Acoustic Mount

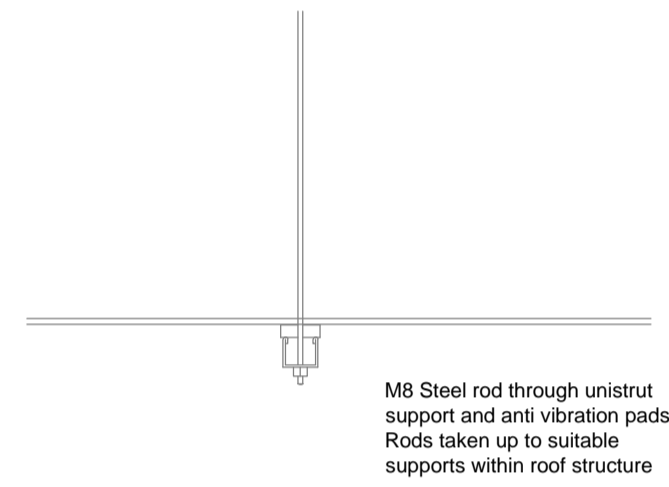

Rev.	Date	Details	Drawn	Checked
E	06.11.18	Silencer and Extract Fan Enclosure omitted from existing extract	TAM	
D	25.10.18	Acoustic mount positions and detail added.	TAM	
C	02.10.18	Silencer and Extract Fan Enclosure added to existing extract	TAM	
B	07.09.18	Ducts reworked for planning	CD	JM
A	31.08.18	Supply & Extract Roof terminal positions corrected	CD	JM

Client: **The Fat Boy Pub Co.**

Issued for: **FOR APPROVAL**

Project: **THE LORE OF THE LAND
4 CONWAY STREET
FITZROVIA,
LONDON
W1T 6BB**

Project No:

Draw No:
V 001

Rev:
E

Drawing: **VENTILATION DUCTWORK
3RD FLOOR LAYOUT &
SECTIONS
REAR ELEVATION**

Scale:
1:50@A1

Drawn By: **CD** Date: **JUNE '18**

Checked By: Date: