




REFER TO DRAWING 2714-901 FOR NOTES

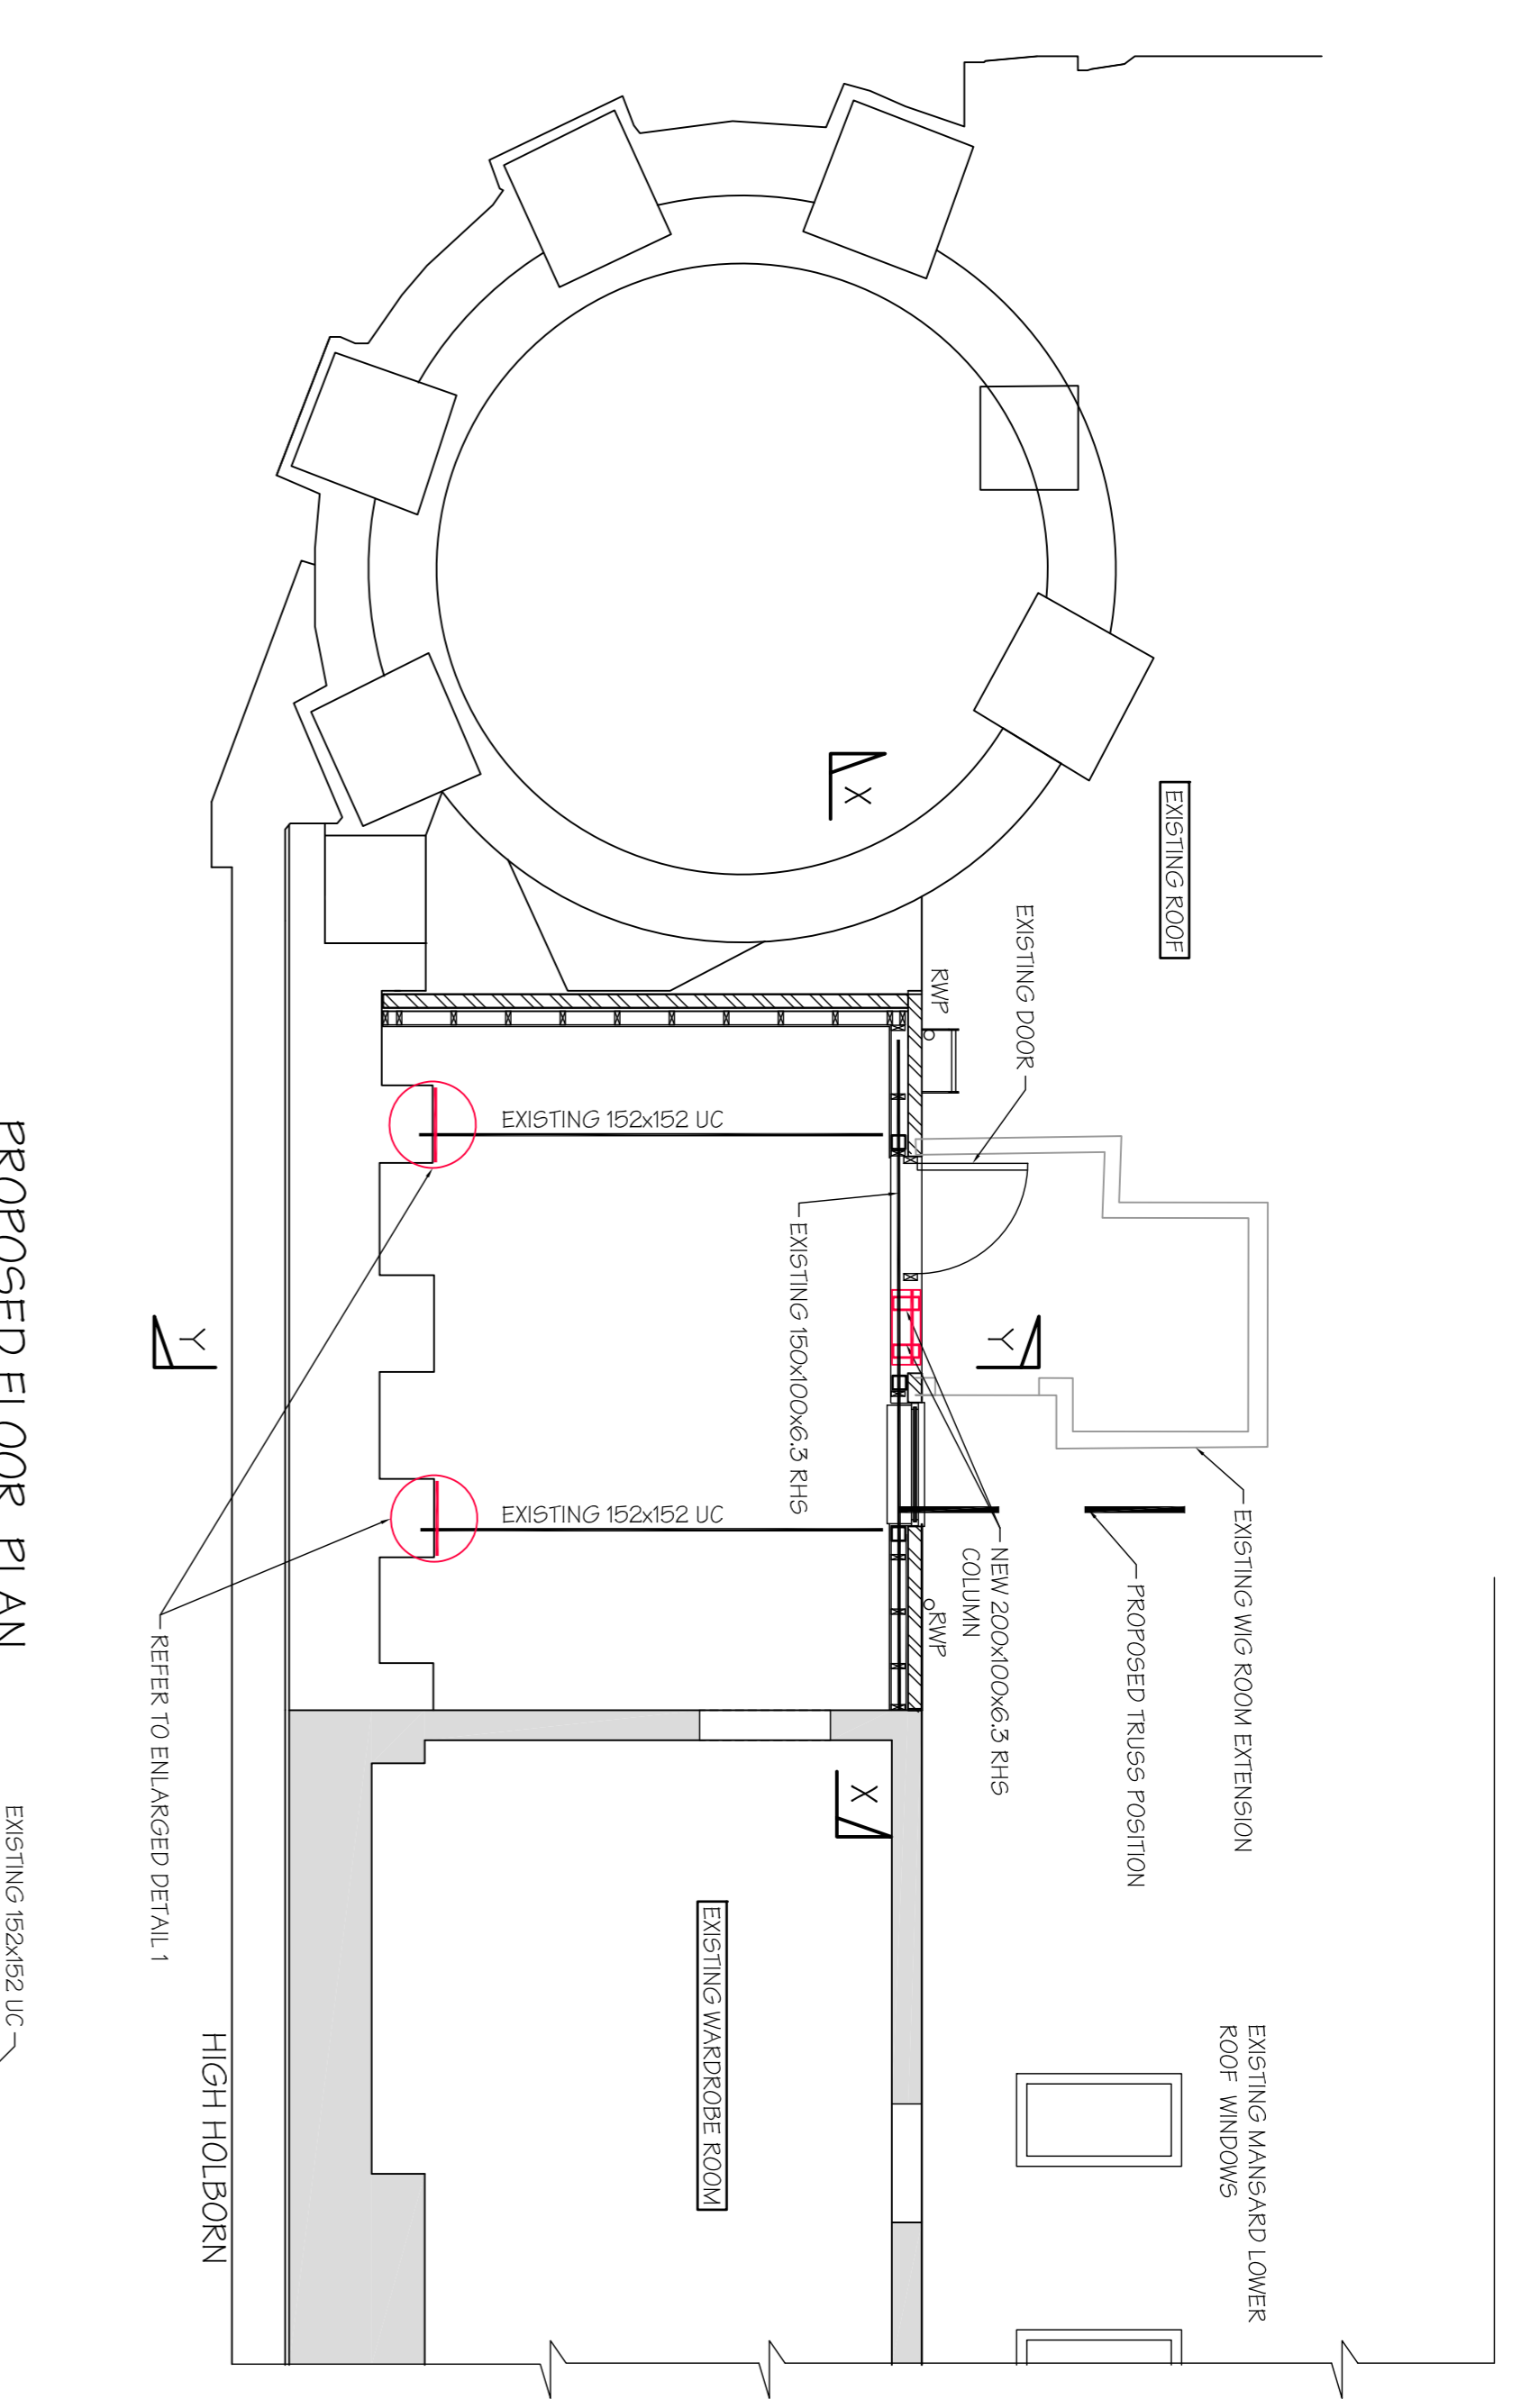


PROPOSED FLOOR PLAN
(SCALE 1:50 AT A1)

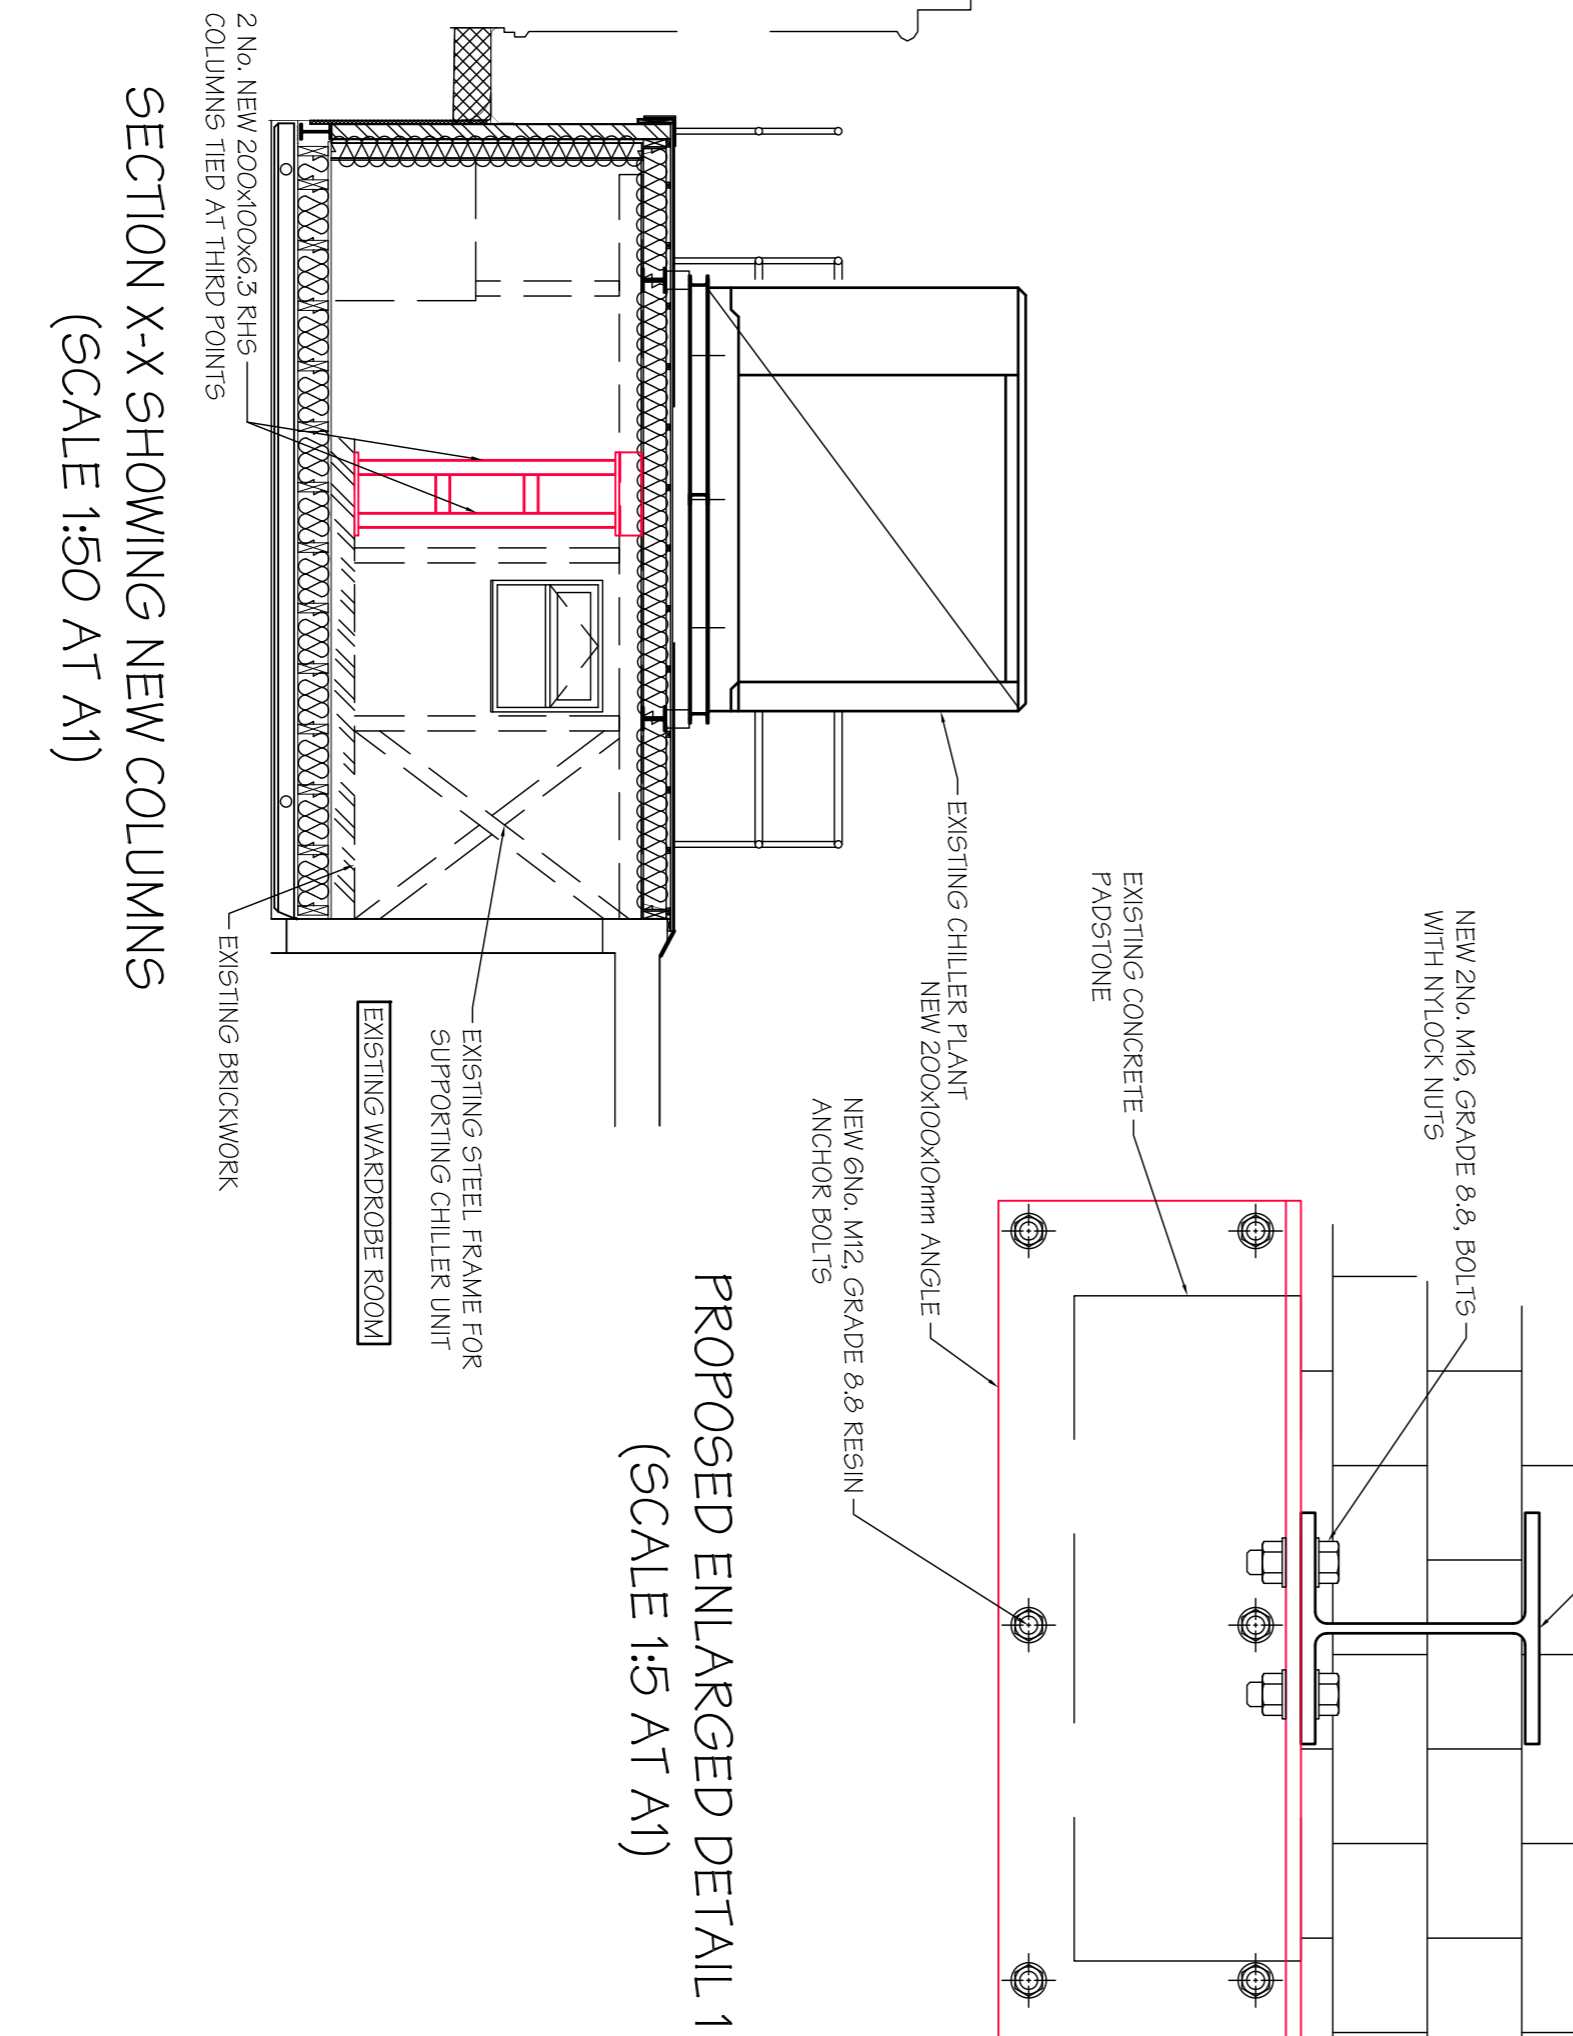

SECTION X-X SHOWING NEW COLUMNS
(SCALE 1:50 AT A1)

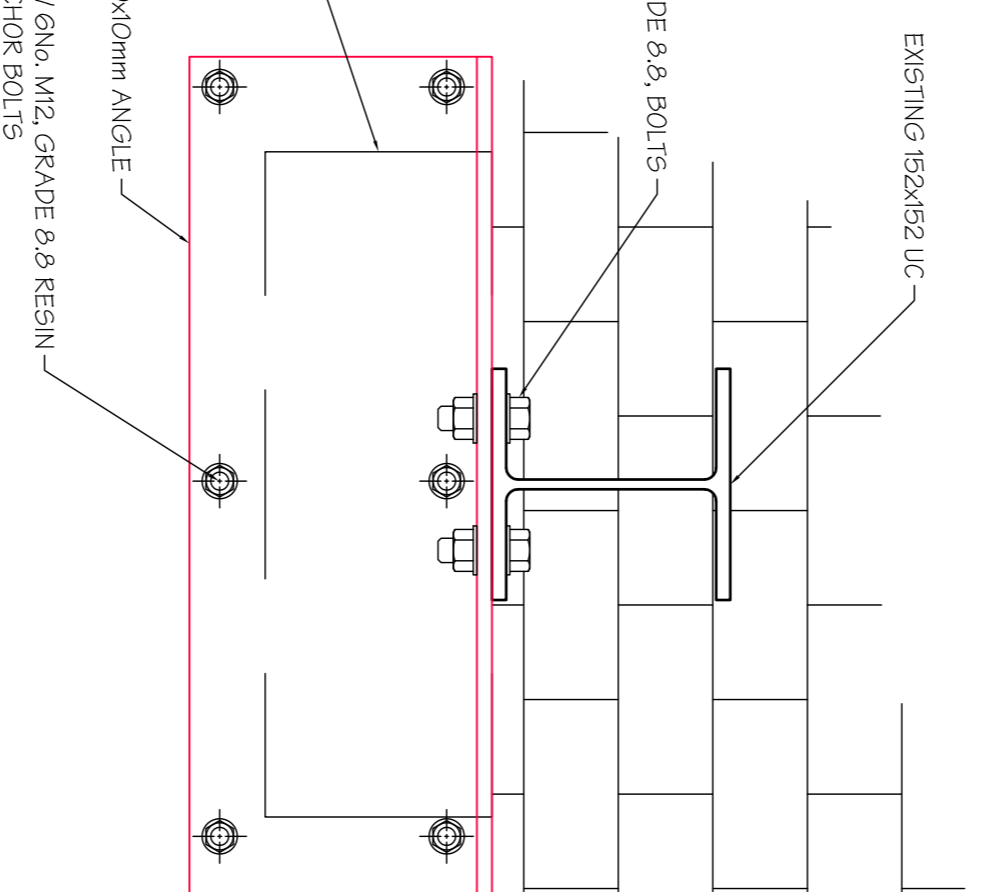


PROPOSED ENLARGED DETAIL 1
(SCALE 1:5 AT A1)

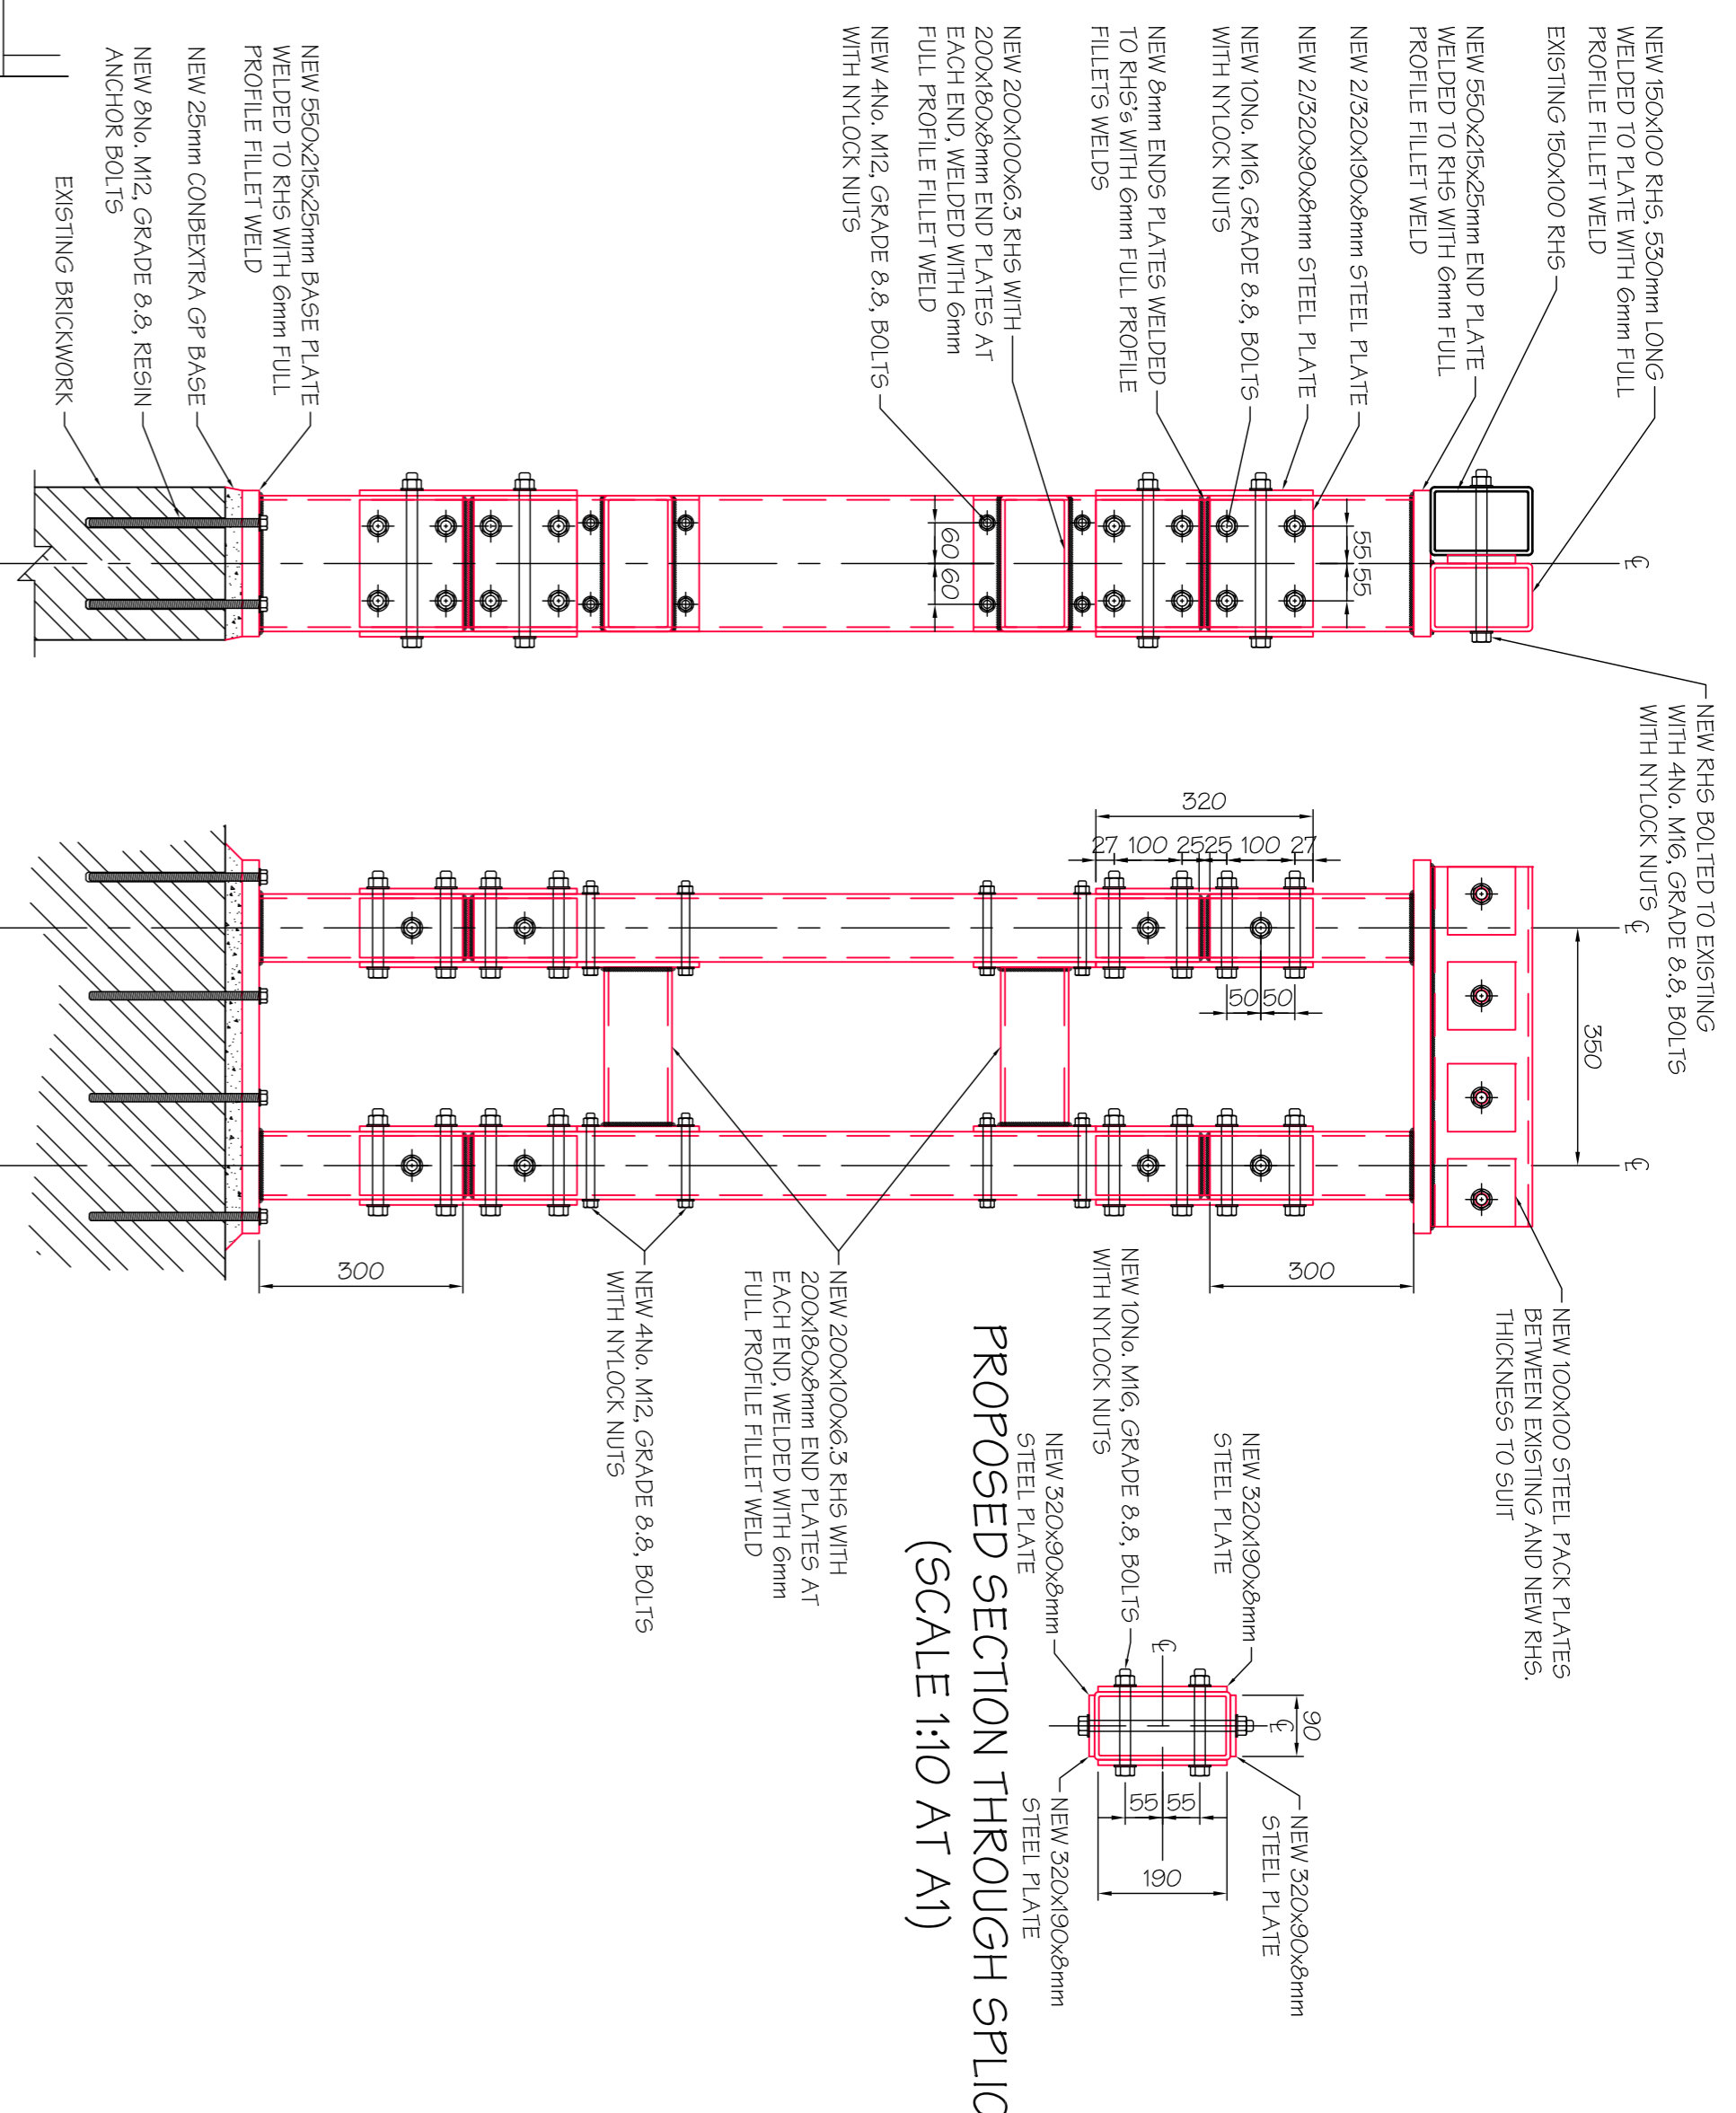

PROPOSED SECTION Y-Y
NEW COLUMN
(SCALE 1:50 AT A1)

PROPOSED SECTION Y-Y
NEW COLUMN
(SCALE 1:50 AT A1)

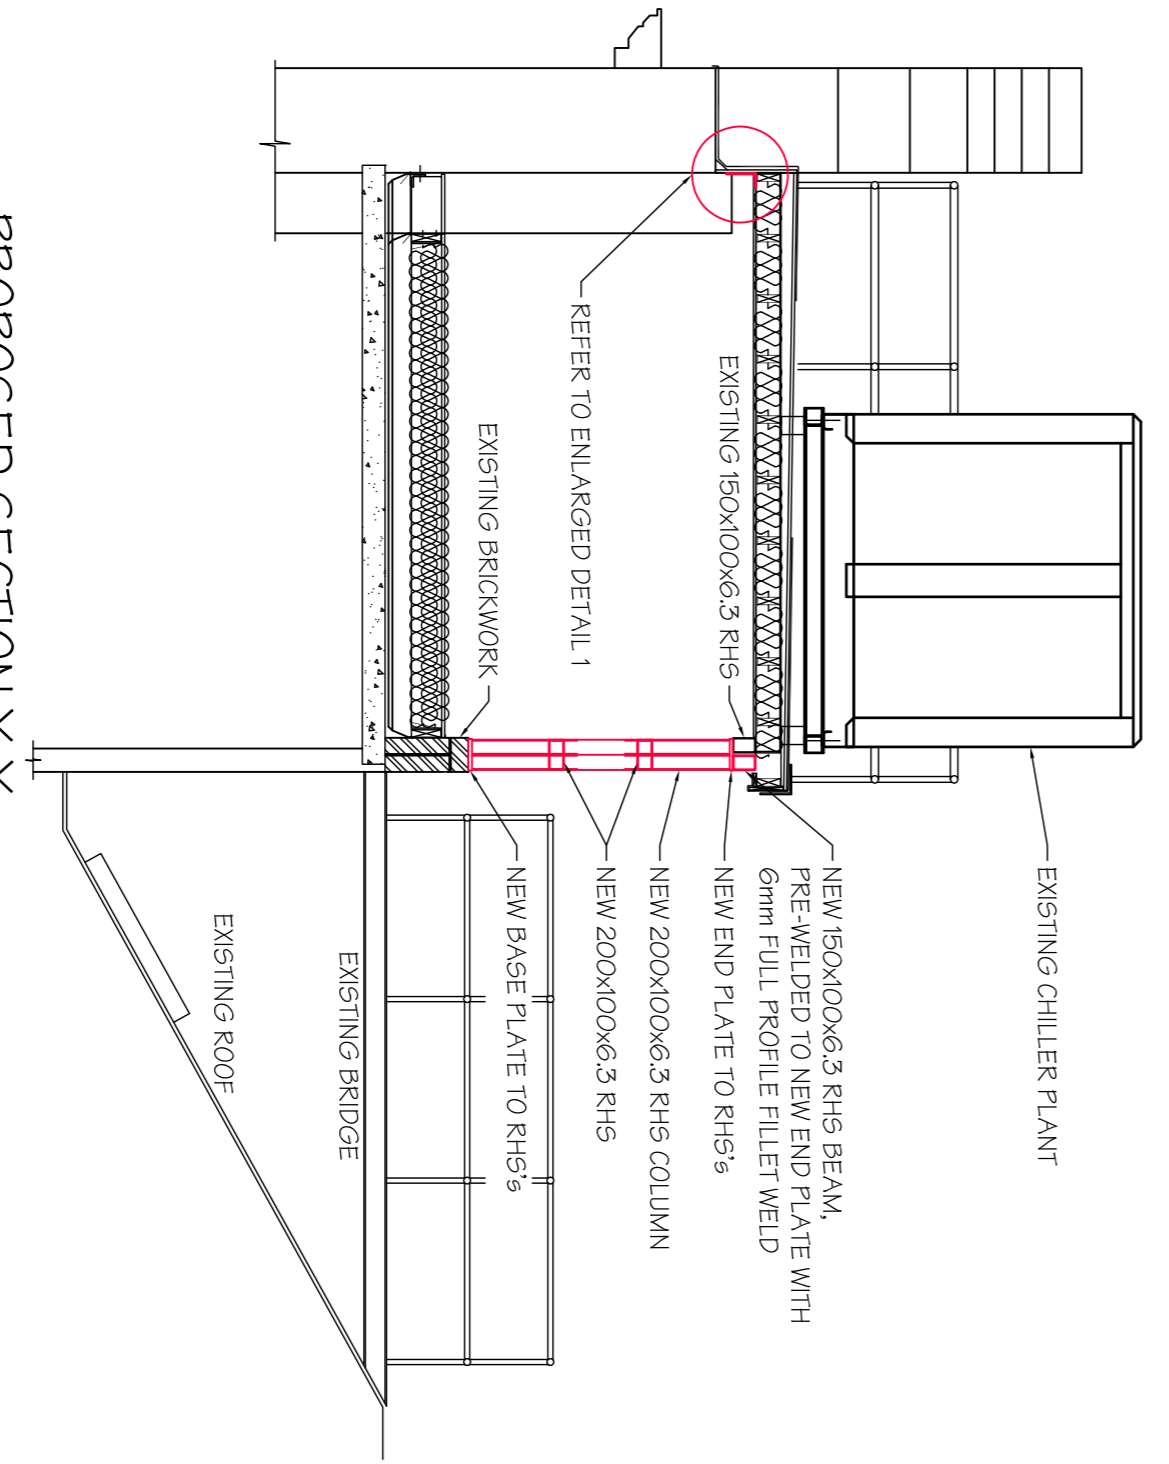

<p>Michael Jackson Consulting Engineers Limited (MACE LIMITED), THIS DRAWING MAY THEREFORE NOT BE REPRODUCED IN ANY FORM OR BY ANY MEANS WITHOUT THE WRITTEN CONSENT OF MACE LIMITED.</p>				
<h3>DRAFT ONLY FOR DISCUSSION</h3>				
<p>Client: Theatre of London Shaftesbury Theatre</p>				
<p>Venue: SHAFTESBURY THEATRE, LONDON</p>				
<p>Project: WIGS ROOM ALTERATIONS</p>				
<p>Drawing Title: PROPOSED COLUMN DETAILS</p>				
<p>Date: 27/14-902</p>				
<p>Scale: AS SHOWN</p>				
<p>Drawn: DS</p>				
<p>Checked: FOS</p>				
<p>Date: OCT 18</p>				
<p>Scale: AS SHOWN</p>				
<p>Drawn: DS</p>				
<p>Checked: FOS</p>				
<p>Date: OCT 18</p>				

Rev	Date	Description	By

<p>Revisions</p>				

<p>Client: Michael Jackson Consulting Engineers 204 BOXTON ROAD MANCHESTER, M20 9JN Tel: 0161 290 4404 Fax: 0161 290 4405</p>				
---	--	--	--	--