 



REVISION A: RAINWATER PIPES & SVP
ADDED 19 08 2018

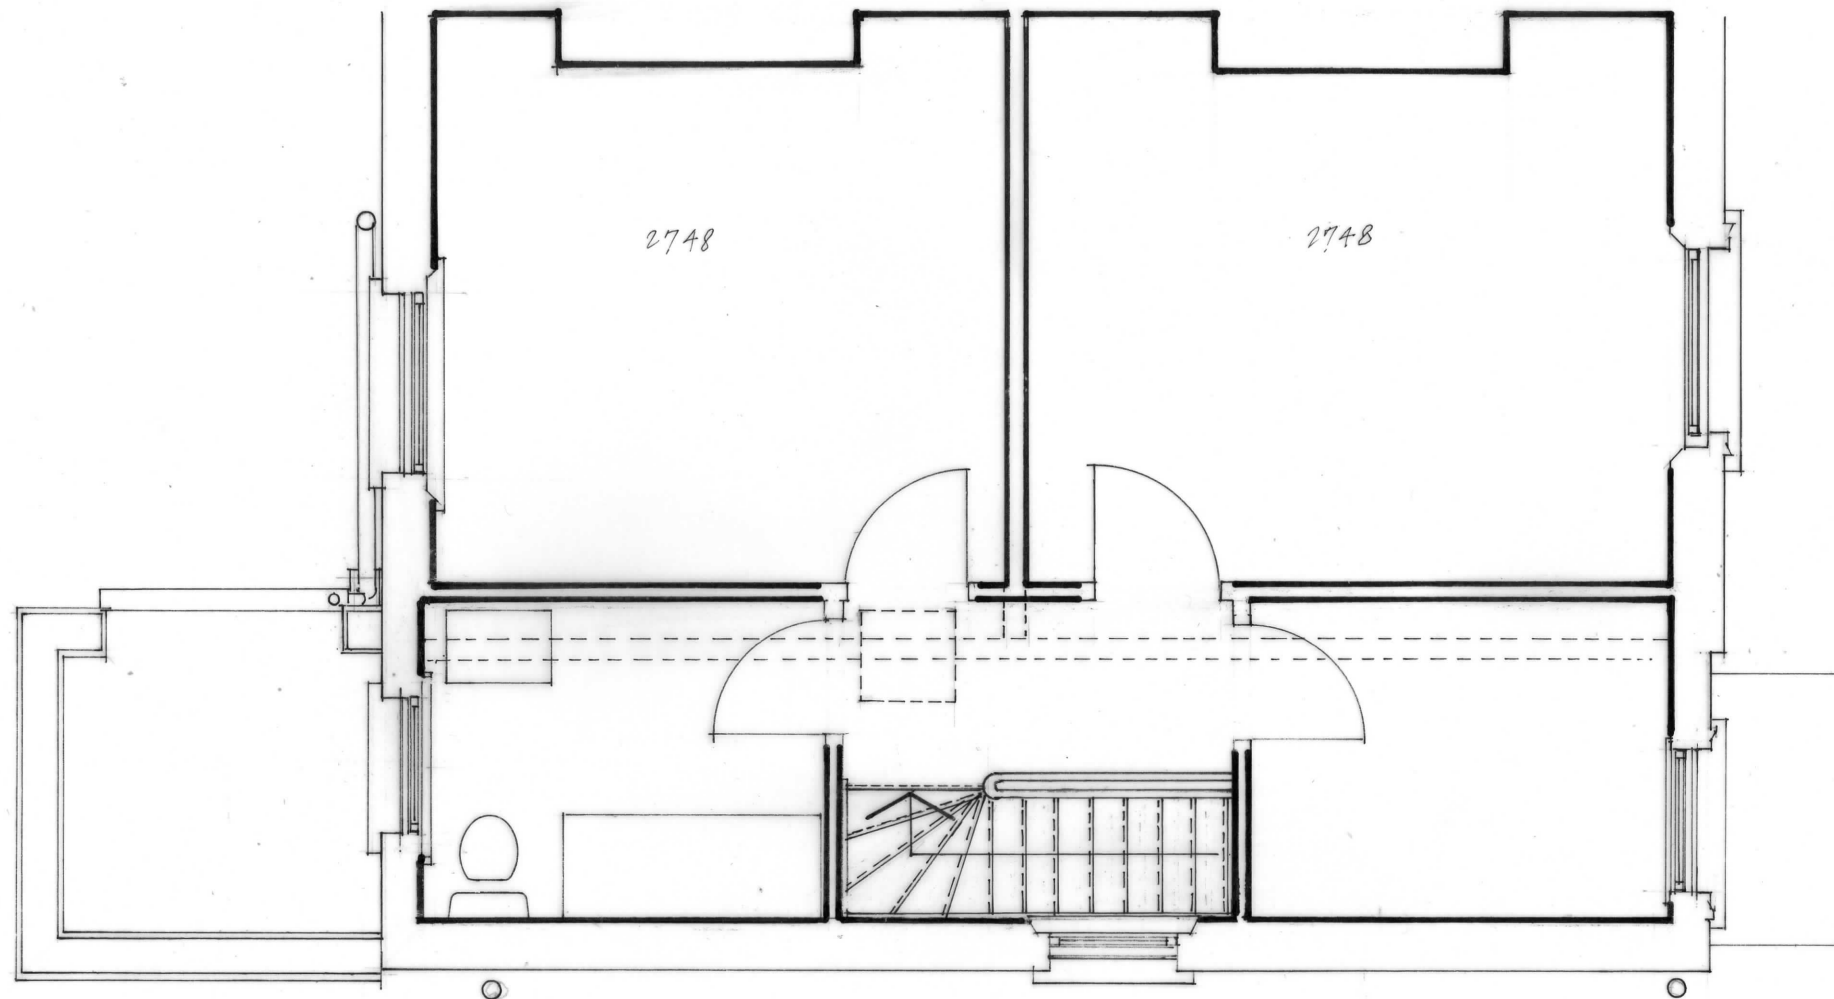

15 ROCHESTER ROAD LONDON NW1 9JH

FIRST FLOOR PLAN -EXISTING

Scale: 1:50 at A3

Date: March 2018

Christopher M Phillips Architect christo.phillips@btconnect.com
31 Grafton Road London NW5 3DX ☎ 020 7485 3578 & 07743 498738

DRAWING NO. 822.3

REVISION A