
 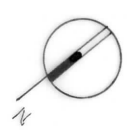



REVISION A: RAIN WATER PIPES & SKP
ADDED 19.09.2018

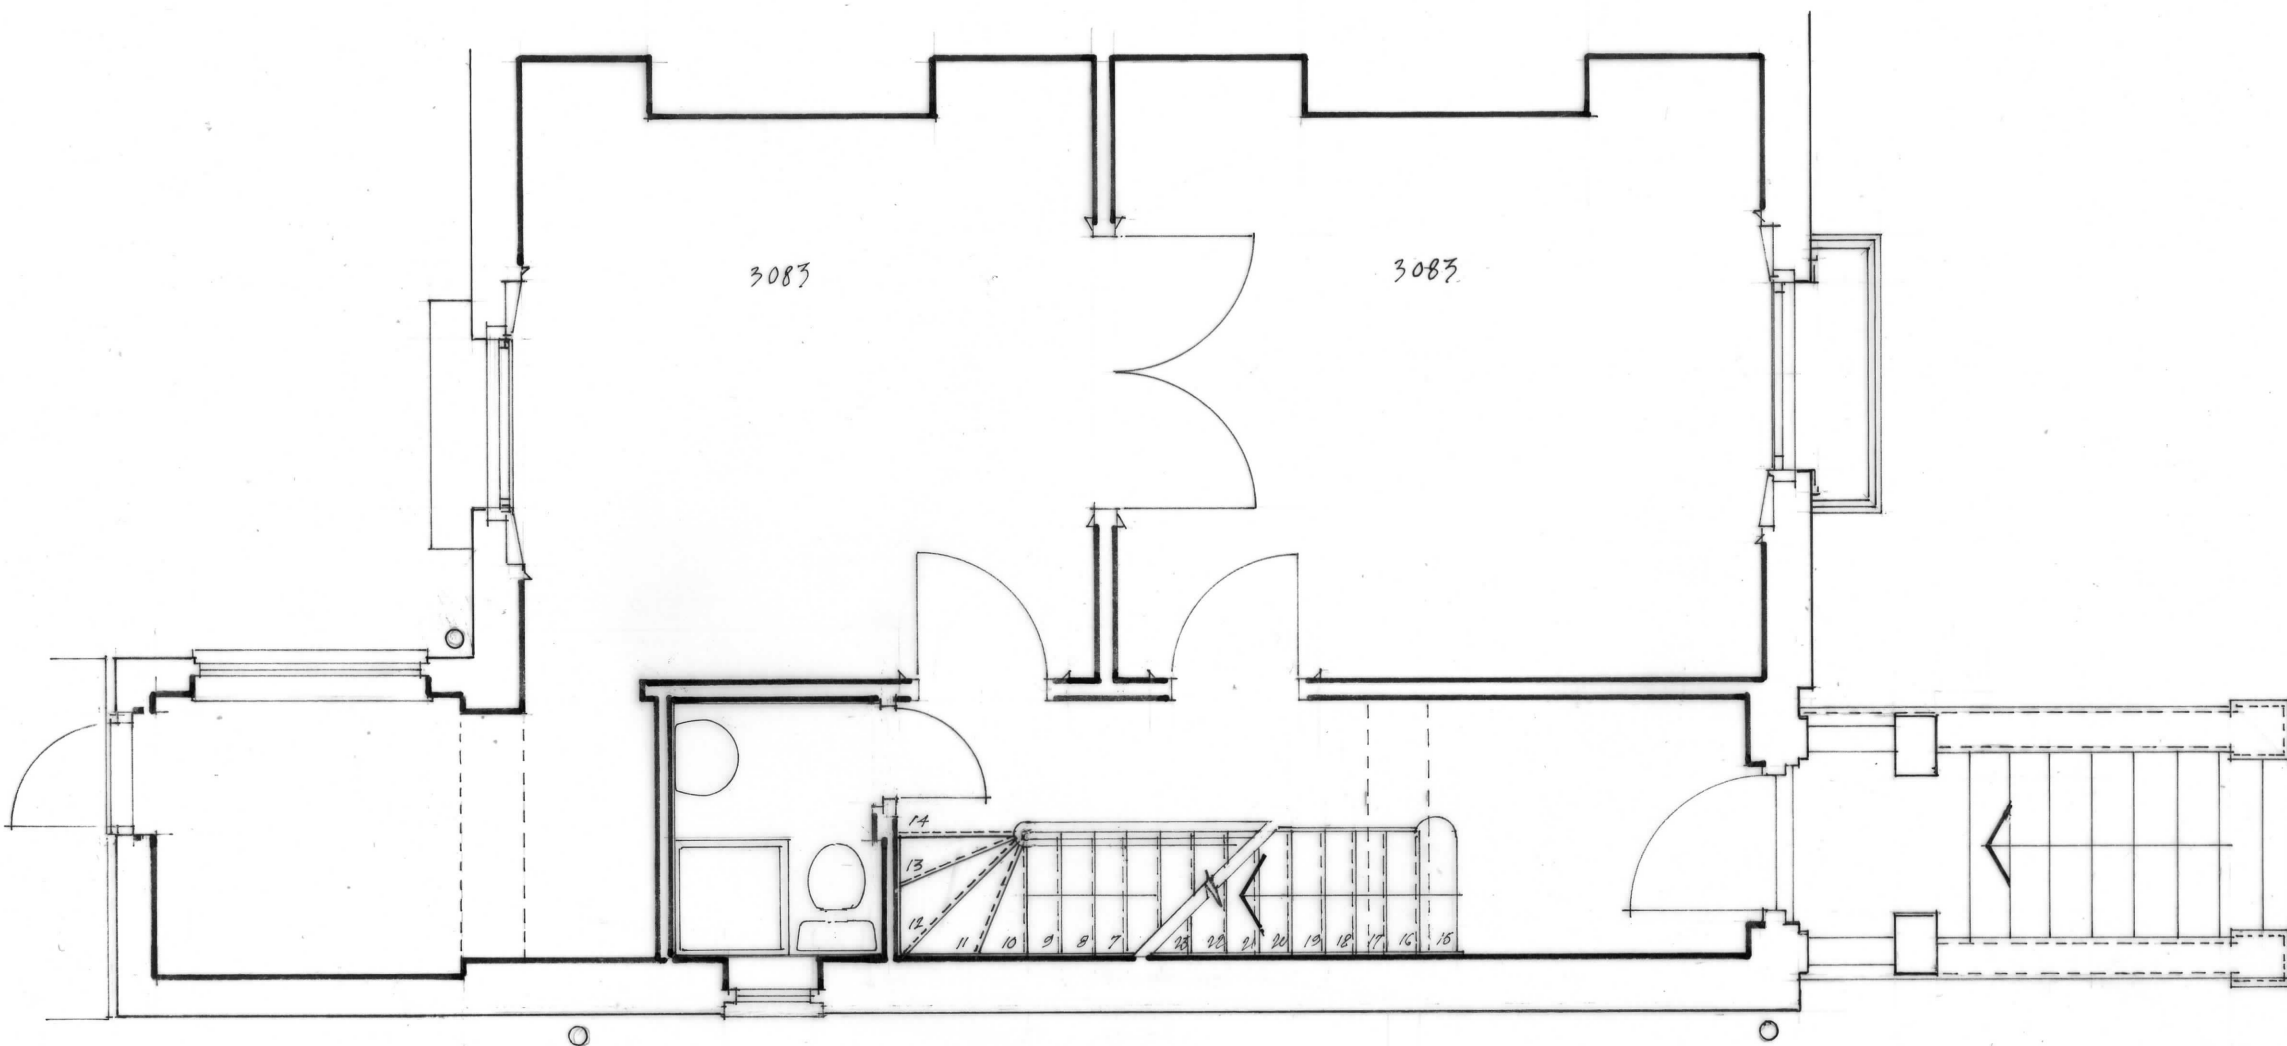

15 ROCHESTER ROAD LONDON NW1 9JH
UPPER GROUND FLOOR PLAN -EXISTING
 Scale: 1:50 at A3 Date: March 2018
 Christopher M Phillips Architect christo.phillips@brconnect.com
 31 Grafton Road London NW5 3DX ☎ 020 7485 3578 & 07743 498738

DRAWING NO. 822.2 REVISION **A**