



KEY	
	FLOOR BOX INCL: 2 X DOUBLE SOCKET, 1 X 5A, 2 X C5 DATA, 2 X USB, PHONE
	TV POINT INCL: VIRGIN, C5, COAX
	TELEPHONE POINT
	ENTRYPHONE POINT
	CAT6 DATA PORT X 2
	DISTRIBUTION BOARD
	UNDERFLOOR HEATING CONTROLS
	ROOF VENT ACTIVATOR SWITCH
	FIRE ALARM CONTROL PANEL
	INTRUDER ALARM PANEL
	13 AMP DOUBLE SOCKET
	SPUR
	SHAVER SOCKET
	SWITCH
	SWITCH WITH TIMER
	2-WAY SWITCH
	5A SWITCH
	SWITCH WITH DIMER
	EXTRACTOR FAN ISOLATION SWITCH
	HEAT DETECTOR
	SMOKE DETECTOR
	EXTRACTOR FAN
	SPOTLIGHT WITH ACOUSTIC & FIRE HOOD
	PENDANT FITTING
	WALL MOUNTED INTERNAL LIGHT
	NON-CORROSIVE LIGHT
	WALL MOUNTED EXTERNAL LIGHT
	LED STRIP LIGHT
	LIGHT WITH EMERGENCY PACK
	LIGHT SWITCH PATHS
	EXTRACT SWITCH PATHS
	SERVICE ROUTES HORIZONTAL
	SERVICE ROUTES VERTICAL (SVP / OTHER)

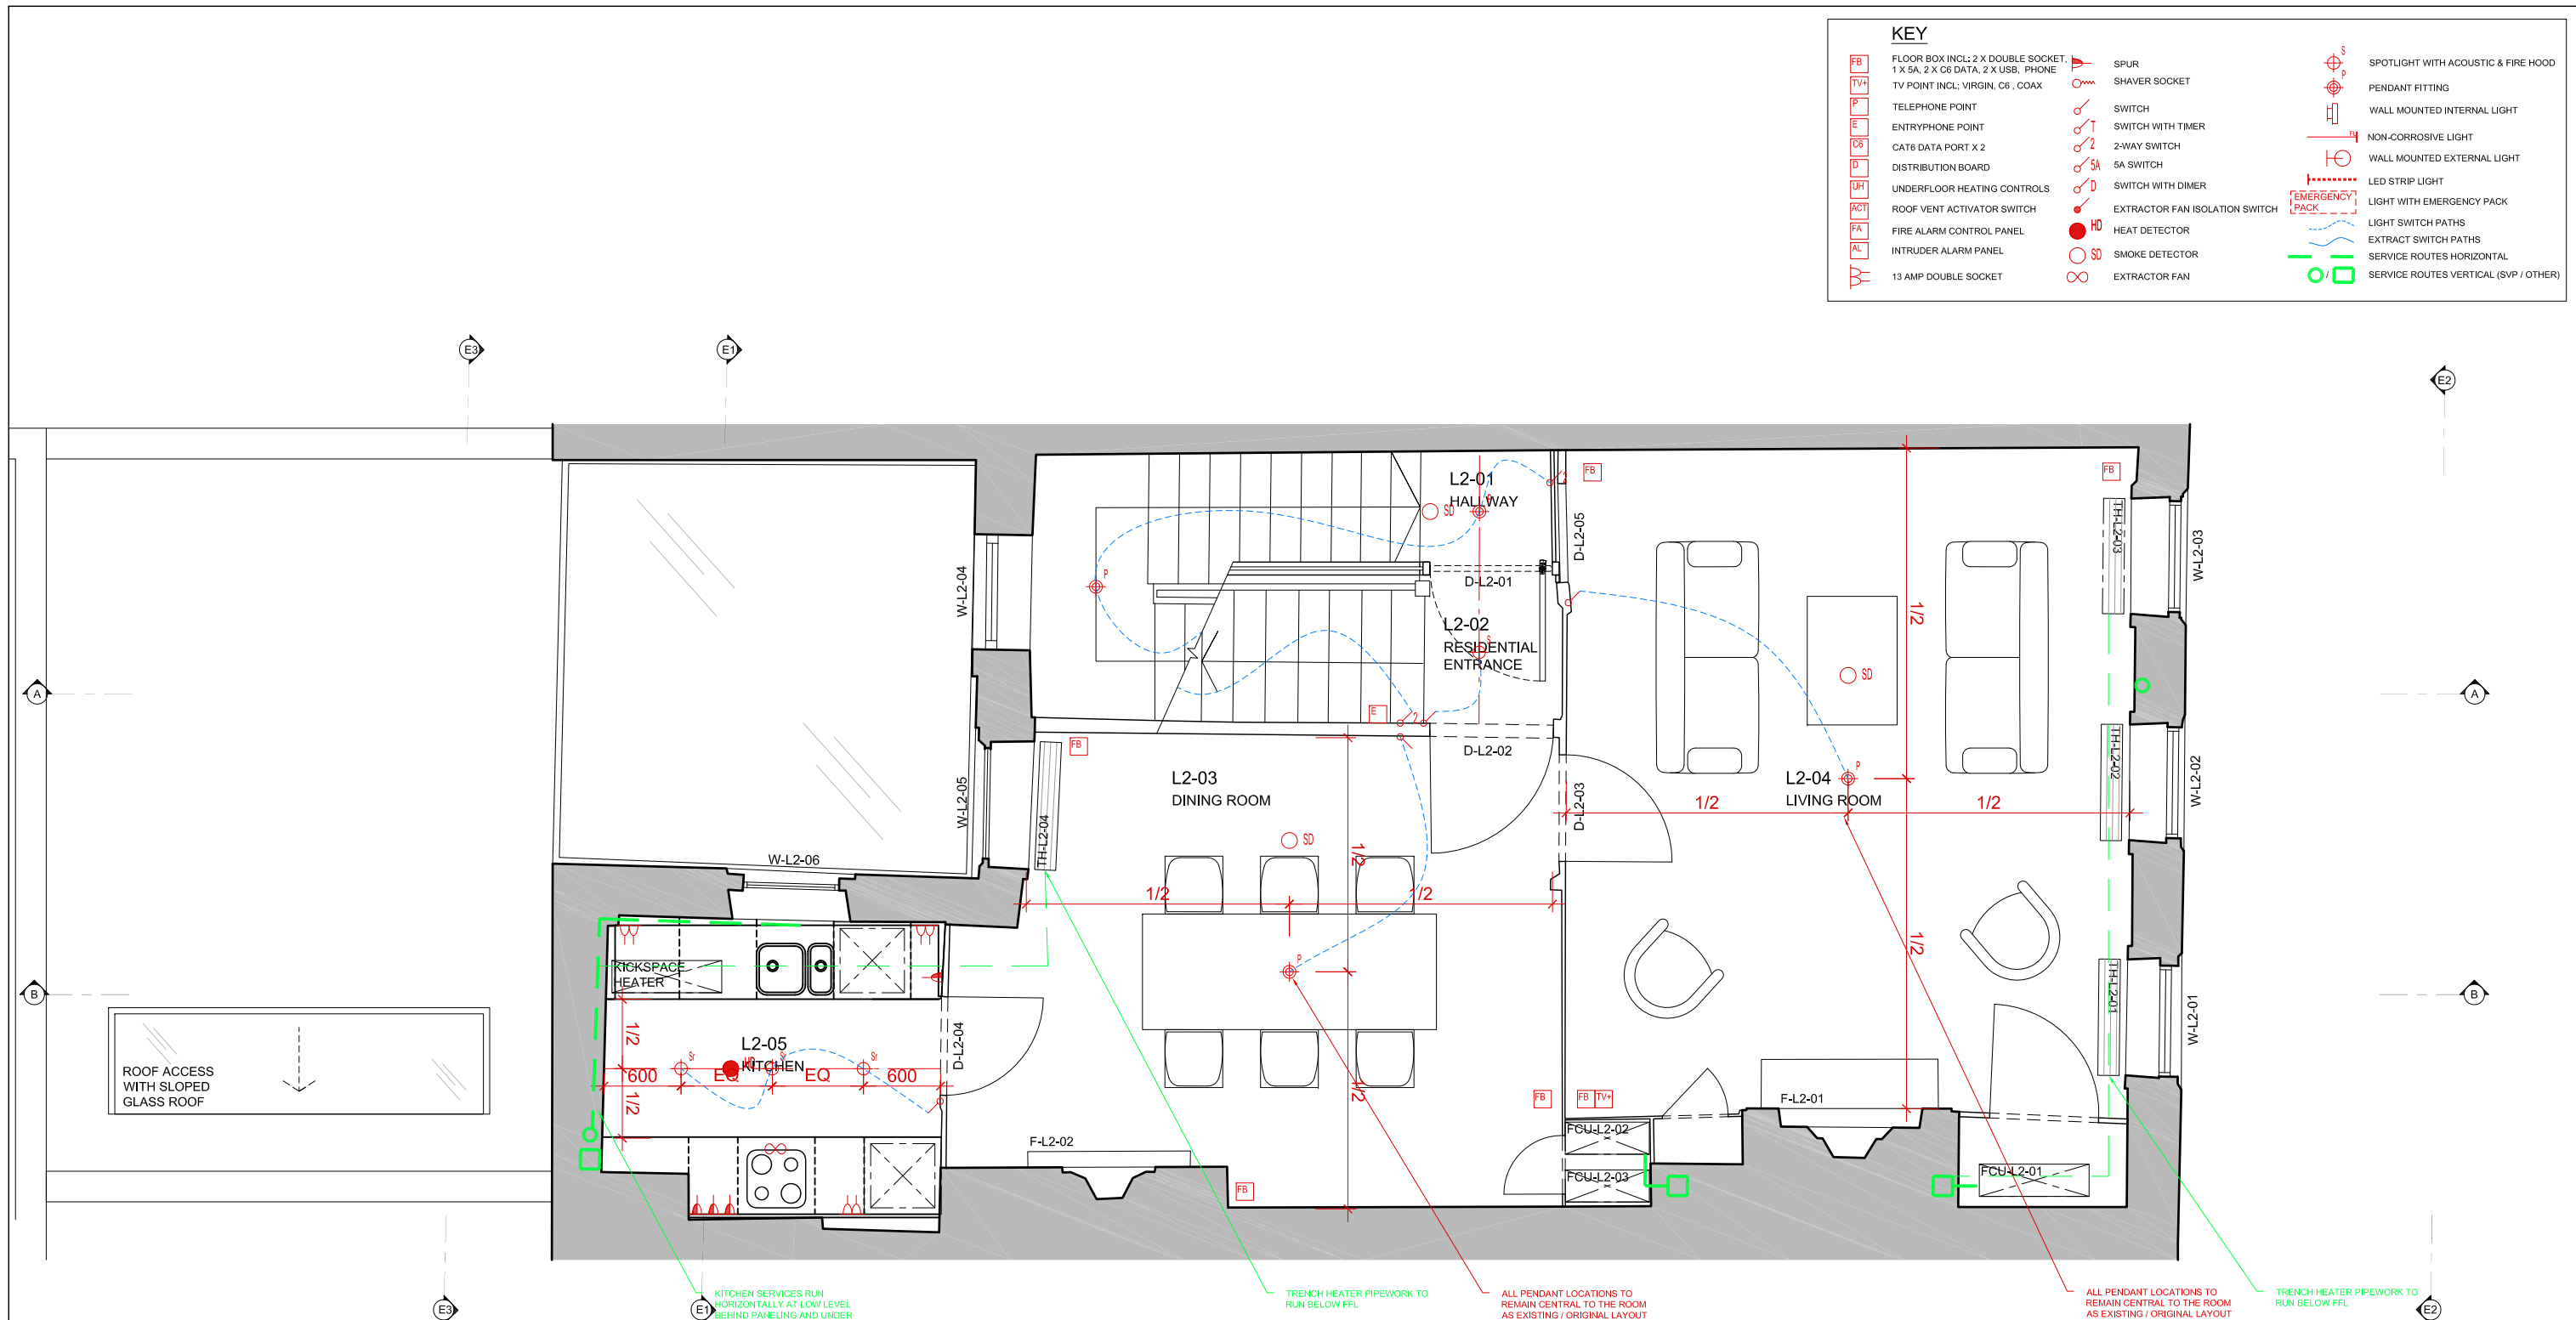

NOTES:

- Drawing based upon the formal survey information issued by Warner Land Surveys Ltd Dated 29.09.14
- Information to read in conjunction with Structural Engineer and MEP Engineer package information
- All levels indicated as height above Ordinance Survey Datum taken from survey. To be confirmed.
- All dimensions subject to a tolerance of +/-5mm.
- All details are indicative and should be reviewed against contractors selected supplier / manufacture / system. Any variations are to be advised to and approved by the Contract Administrator prior to commencement on site.
- Refer to CDM Risk Schedule 1618-0000-CDM-001
- Refer to Design Risk Schedule 1618-0000-DRS-001

DATE	REVISIONS
13.11.2018	PL02 PLANNING CONDITIONS
26.06.2018	PL01 PLANNING CONDITIONS

 

Do not scale from this drawing
 All dimensions to be confirmed on site
 Information contained within this drawing is the sole copyright of EMRYS Architects Ltd and is not to be reproduced without permission
 EMRYS Architects are to be notified immediately of any discrepancies

EMRYS
 CAP House | 9-12 Long Lane | London | EC1A 9HA
 mail@emrysarchitects.com
 www.emrysarchitects.com T: 020 7726 5060

JOB NO.	1618	CLIENT	KAY GEORGIU	
TITLE	40 GREAT JAMES STREET WC1N 3HB			
DWG	MECHANICAL & ELECTRICAL LAYOUTS SECOND FLOOR PLAN (PLANNING CONDITIONS)			
DRAWN	EB	DATE	26.06.2018	
CHECKED	GE	STATUS	PLANNING	
DWG NO.	1618-0600-AP-104		SCALE	1/50
		REV	PL02	