
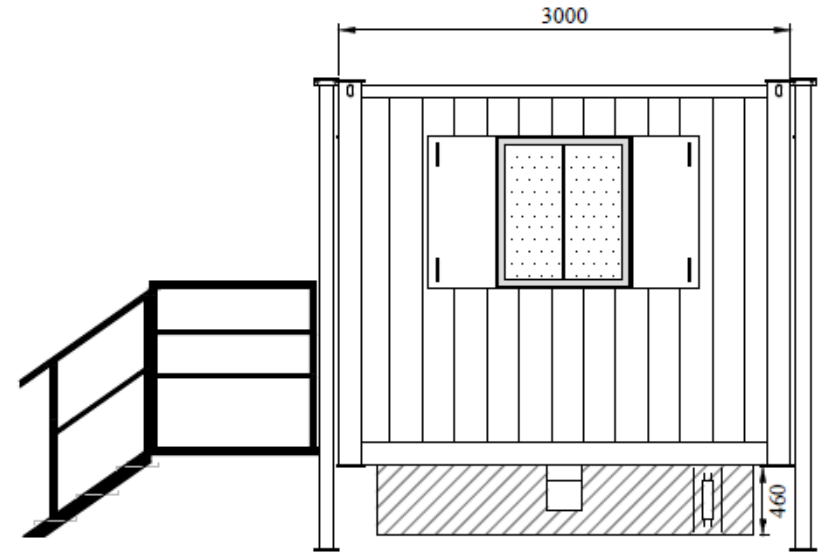
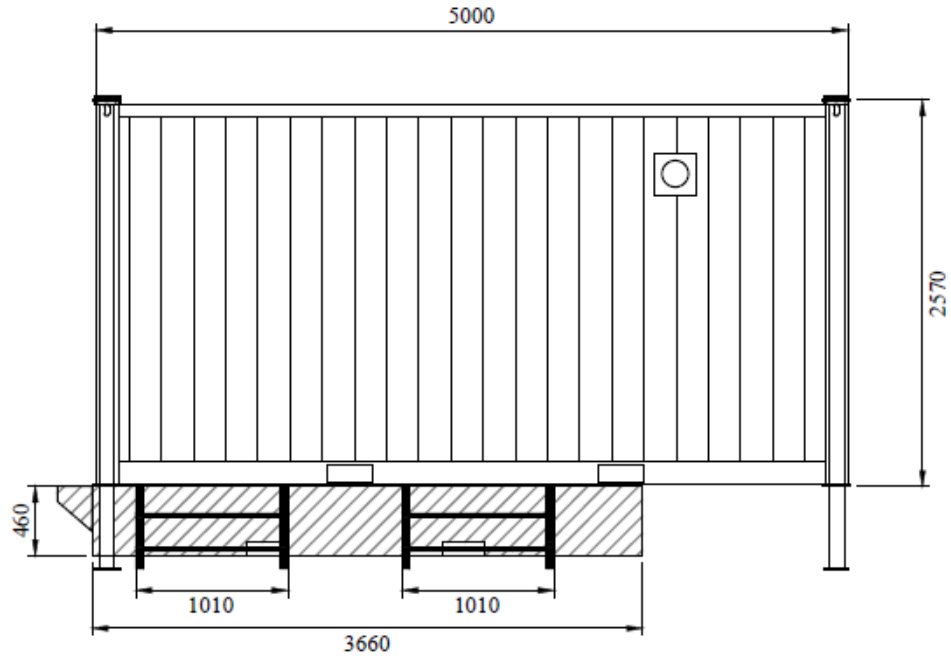



Fittings	Yes	No	General Specifications:		Amendments/Additions to Specifications:	+/- 5mm TOLERANCE						
Fork pockets:	X		Wall boards:	6MM COTTON 'E'								
Wiring System: H07RN-F to BS 50525 & 6242YH to BS 6004			Flooring:	POLYFLOOR- BLACK								
Checked and Signed			Cabin Profile:	PROFILE - 1								
Customer:			Insulation:	ECO-C RATED 100mm					1	08.06.18	FIRST ISSUE	RB
Sales:			Kitchen:	WHITE BASE					Issue	Date	Amendments	Drawn
Production:			Drawing No:	STACK - 10141					 <p>The Storage &amp; Office Solution Specialists</p>			
			Job No:		5000mm x 3000mm WC CANTEEN - ELEVATIONS							



Fittings	Yes	No	General Specifications:		Amendments/Additions to Specifications:	+/- 5mm TOLERANCE						
Fork pockets:	X		Wall boards:	6MM COTTON 'E'								
Wiring System: H07RN-F to BS 50525 & 6242YH to BS 6004			Flooring:	POLYFLOOR- BLACK								
Checked and Signed			Cabin Profile:	PROFILE - 1								
Customer:			Insulation:	ECO-C RATED 100mm					1	08.06.18	FIRST ISSUE	RB
Sales:			Kitchen:	WHITE BASE					Issue	Date	Amendments	Drawn
Production:			Drawing No:	STACK - 10141	5000mm x 3000mm WC CANTEEN - ELEVATIONS							
			Job No:									

<ul style="list-style-type: none"> <li>5' LED LIGHT</li> <li>TIMEGUARD SLW360 PIR SENSORS</li> <li>LIGHT SWITCH</li> <li>LL DOUBLE SOCKET @300 CL FFL</li> <li>HL DOUBLE SOCKET @1200 CL FFL</li> <li>2kw CONSORT WIRELESS HEATER UNDERSIDE OF HEATER @ 300MM FROM FFL (CODE: 704855)</li> </ul>	<ul style="list-style-type: none"> <li>10 WAY CONSUMER UNIT (HAGER VML410H)</li> <li>EXTERNAL 63AMP ISOLATOR GEWISS 60437 32AMP IP67 EXTERNAL INLET IN RECESSED ISOLATOR HOUSING</li> <li>2KW CONSORT WIRELESS DOWN FLOW HEATER (CODE: 704860) (ABOVE EARTH CONNECTION)</li> <li>CONSORT 704850 WIRELESS SLPB CONTROLLER TO BE @ 1335 CL FFL IN LINE WITH LIGHT SWITCH</li> </ul>	<ul style="list-style-type: none"> <li>CANTEEN SINK cw STANDARD TAPS</li> <li>LL DOUBLE SOCKET @300 CL FFL</li> <li>HL DOUBLE SOCKET @1200 CL FFL</li> <li>COAT HOOKS</li> <li>4" EXTRACTOR FAN cw HUMIDISTAT</li> </ul>	<ul style="list-style-type: none"> <li>DUAL FLUSH CISTERN - LEVER TYPE</li> <li>SMALL WHB cw MISTING TAPS, SUPPORT LEGS &amp; MIRRORS ABOVE</li> <li>15LTR UNDERSINK WATER HEATER (ALSO TO FEED WHB)</li> </ul>	<ul style="list-style-type: none"> <li>JACKLEGS FITTED ON CORNER POSTS</li> <li>HIGH/LOW LEVEL VENTS</li> <li>ROOF VENTS</li> <li>BOTTOM LIFT</li> <li>FEED &amp; WASTE</li> </ul>
--	---	--	---	--

SCALE 1:50 @ A4

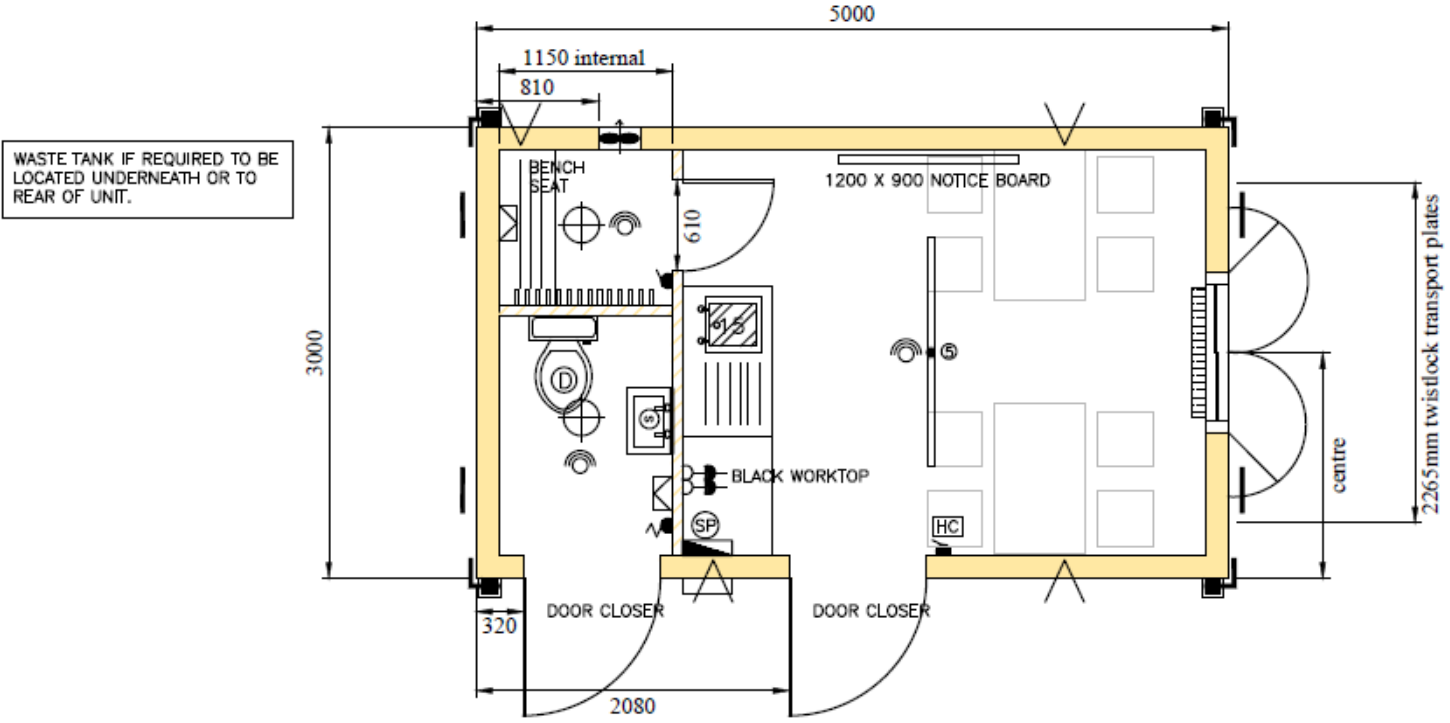

WASTE TANK IF REQUIRED TO BE LOCATED UNDERNEATH OR TO REAR OF UNIT.


**ECO SANDWICH FLOOR - SEE SPEC**

JOB No. ID	T _ _ _ _ E
*FIRE RESISTANT CABLE TRUNKING CLIPS TO BE FITTED - SEE WORK INSTRUCTION MM TB006*	
WALL TRIM	WHITE
WINDOWS/DRS	DK.BROWN
BOTTOM SKIRT	DK BROWN
CORNER ANGLE	DK.BROWN

Fittings	Yes	No	General Specifications:	Amendments/Additions to Specifications:	+/- 5mm TOLERANCE				
Fork pockets:	X		Wall boards: 6MM COTTON 'E'	ELECTRICS TO BE SURFACE MOUNTED	160MM X 80MM BOTTOM RAIL				
Wiring System: H07RN-F to BS 50525 & 6242YH to BS 6004			Flooring: POLYFLOOR- BLACK	LIFTING EYES @1800 FROM CORNER POST	PITCHED EZ PLATED ROOF				
Checked and Signed			Cabin Profile: PROFILE - 1	FORK POCKETS @ 1800 CENTRES	4MM CORNER POSTS				
Customer:			Insulation: ECO-C RATED 100mm			1	08.06.18	FIRST ISSUE	RB
Sales:			Kitchen: WHITE BASE	75 X 50 BOX SECTION BEARERS DROPPED 34MM FOR ECO SANDWICH FLOOR		Issue	Date	Amendments	Drawn
Production:			Drawing No: STACK - 10141			<p style="text-align: center;"><b>5000mm x 3000mm WC CANTEEN - ELEVATIONS</b></p>			
			Job No:						




# Site Plan

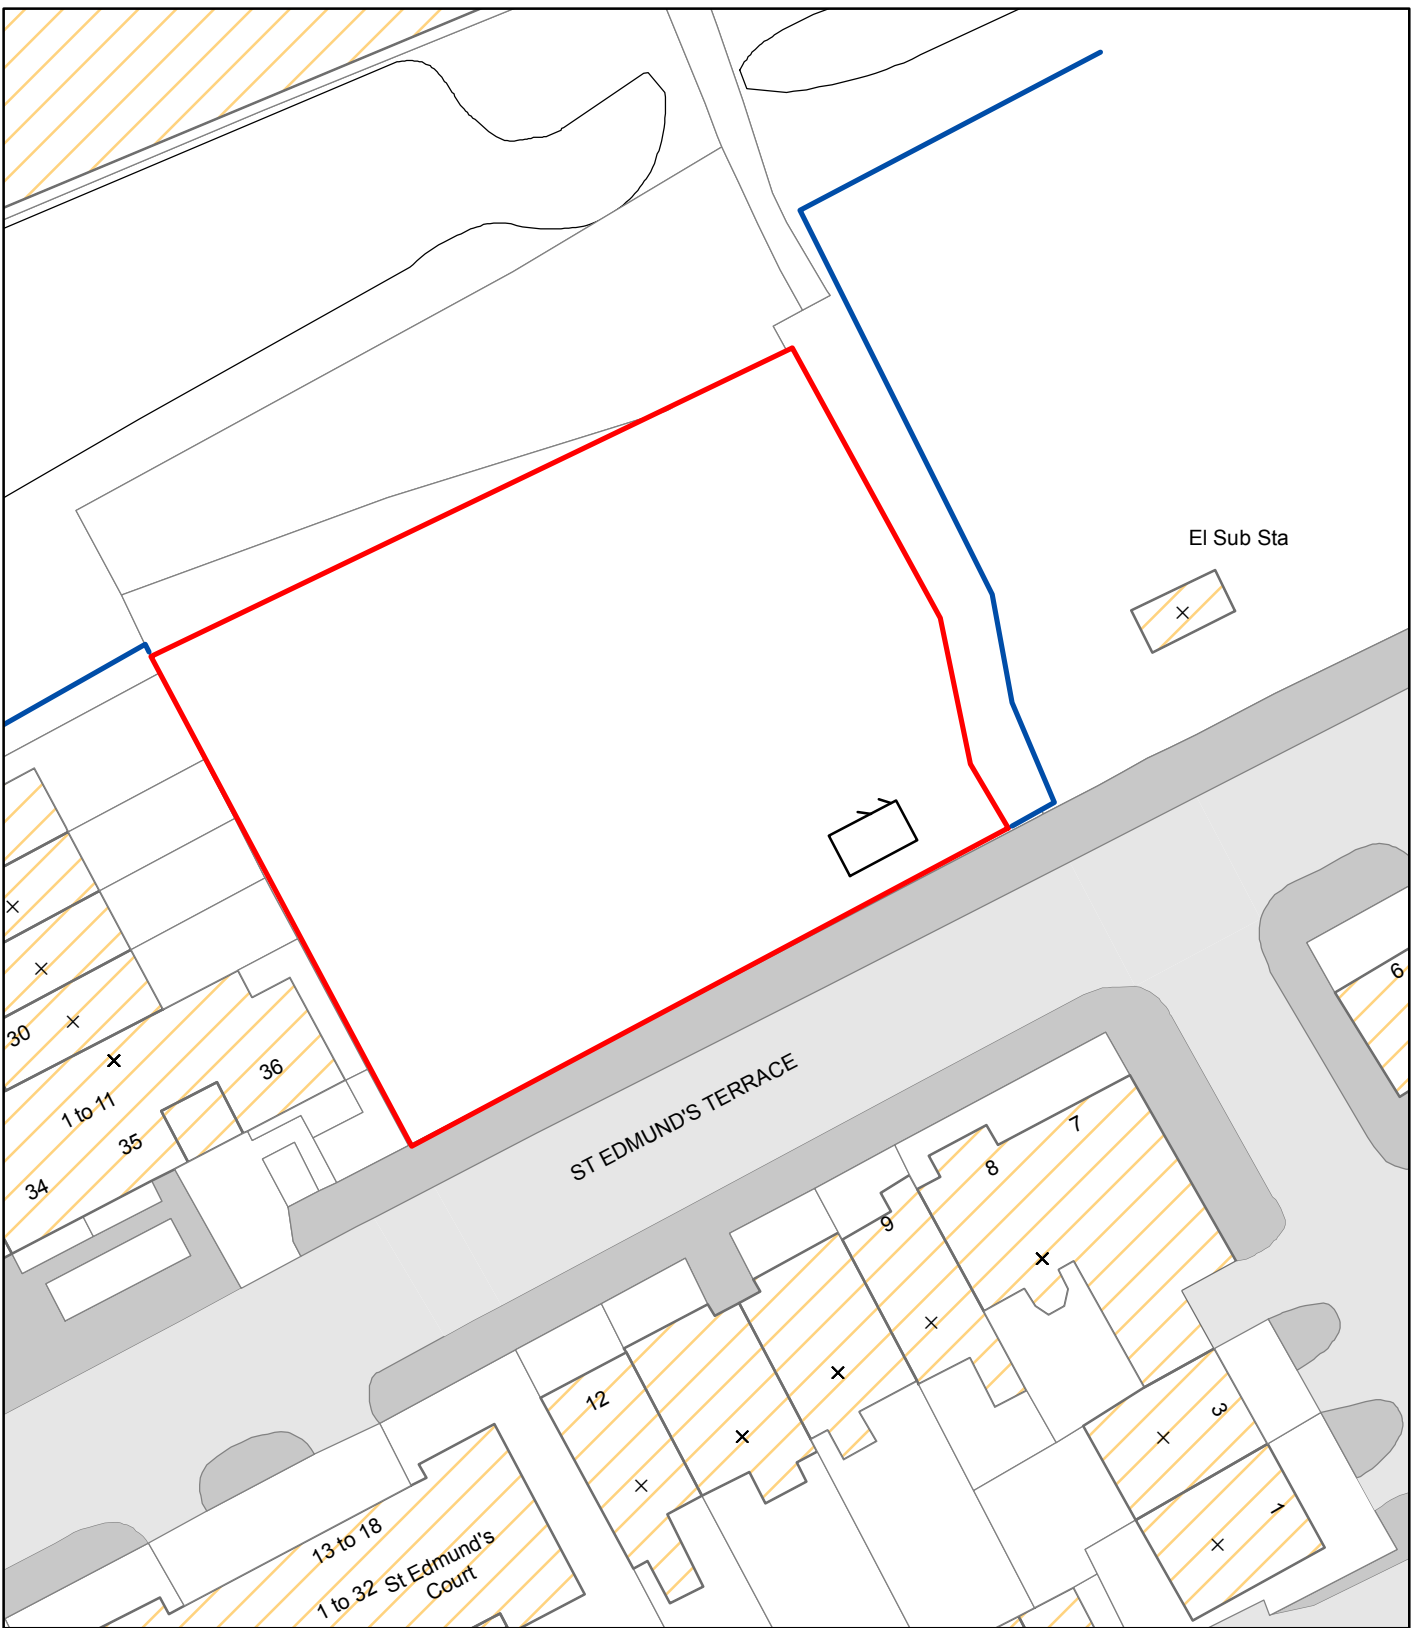

**Thames Water Map**



 Printed By : mhazeldi  
 Print Date : 10/12/2018  
 Map Tile Name: 1991



**Comments:**

Scale 1:500 @ A4  
 Dwg. No. SP1 rev B


 
**Disclaimer:** Based on the Ordnance Survey Map with the Sanction of the Controller of H.M Stationery Office License Number:- 100019345

The position of any boundary or apparatus shown on this plan is given without obligation and warranty, and the accuracy cannot be guaranteed.




Service pipes are not shown but their presence should be anticipated. No liability of any kind whatsoever is accepted by Thames Water for any error or omission. The actual position of mains and services must be verified on site before any works are undertaken.

**Copyrights:** Unauthorised reproduction prohibited. Crown Copyright Reserved.



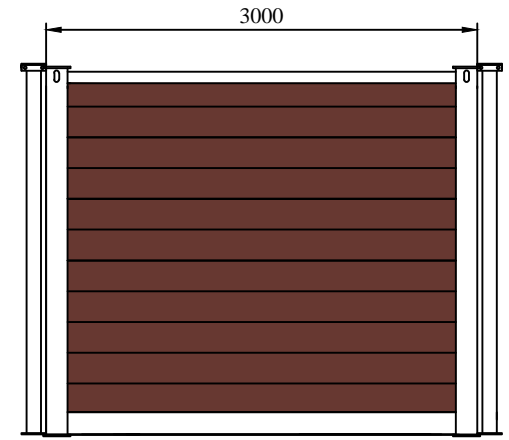

EXAMPLE OF CLADDING

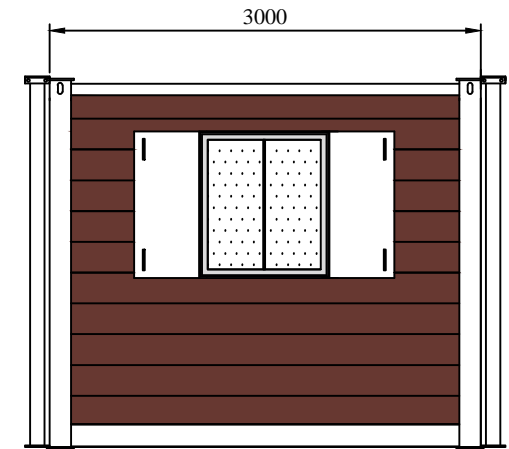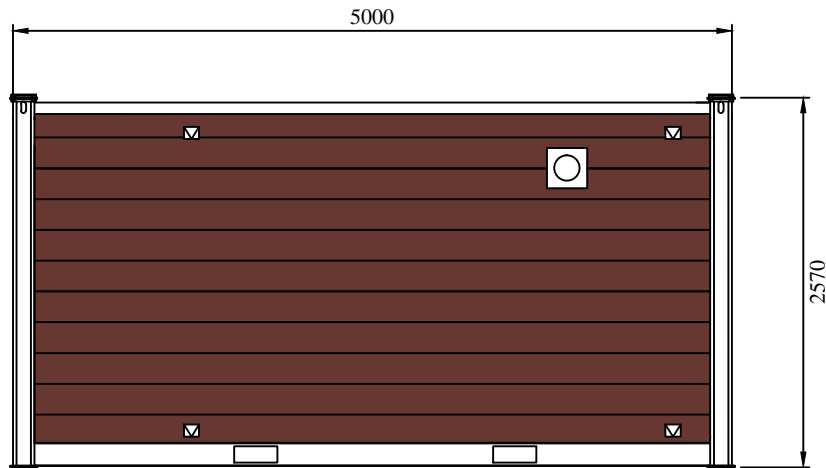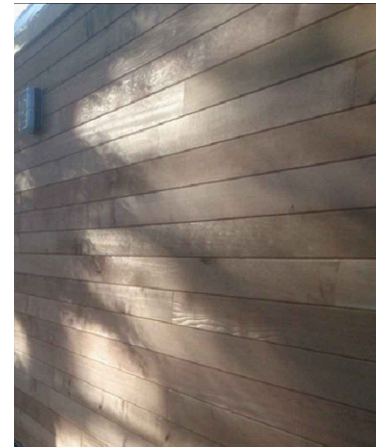

Fittings	Yes	No	General Specifications:		Amendments/Additions to Specifications:	+/- 5mm TOLERANCE							
Fork pockets:	X		Wall boards:	6MM COTTON 'E'									
Wiring System: H07RN-F to BS 50525 & 6242YH to BS 6004			Flooring:	POLYFLOOR- BLACK									
Checked and Signed			Cabin Profile:	PROFILE - 1									
Customer:			Insulation:	ECO-C RATED 100mm									
Sales:			Kitchen:	WHITE BASE									
Production:			Drawing No:	STACK - 10141	5000mm x 3000mm WC CANTEEN - ELEVATIONS					1	02.11.18	FIRST ISSUE	RB
			Job No:							Issue	Date	Amendments	Drawn