 





PROPOSED ROOF PLAN  
1:100@A3



<b>Ben Pentreath</b> <small>3 Lamp Office Court Lamb Conduit Street London WC1N 3NF T +44 (0) 20 7430 2424 benpentreath.com</small>	
PROJECT:	4 LAMP OFFICE COURT
TITLE:	PROPOSED ROOF PLAN
DRAWING NO: A-100	REV. NO: A
SCALE: 1:100 @ A3	DRAWN BY: PWD
DATE: 12/12/2018	CHECKED BY: MU
<small>All dimensions to be checked on site. All designs © Ben Pentreath Ltd 2018. Not to be reproduced without permission</small>	

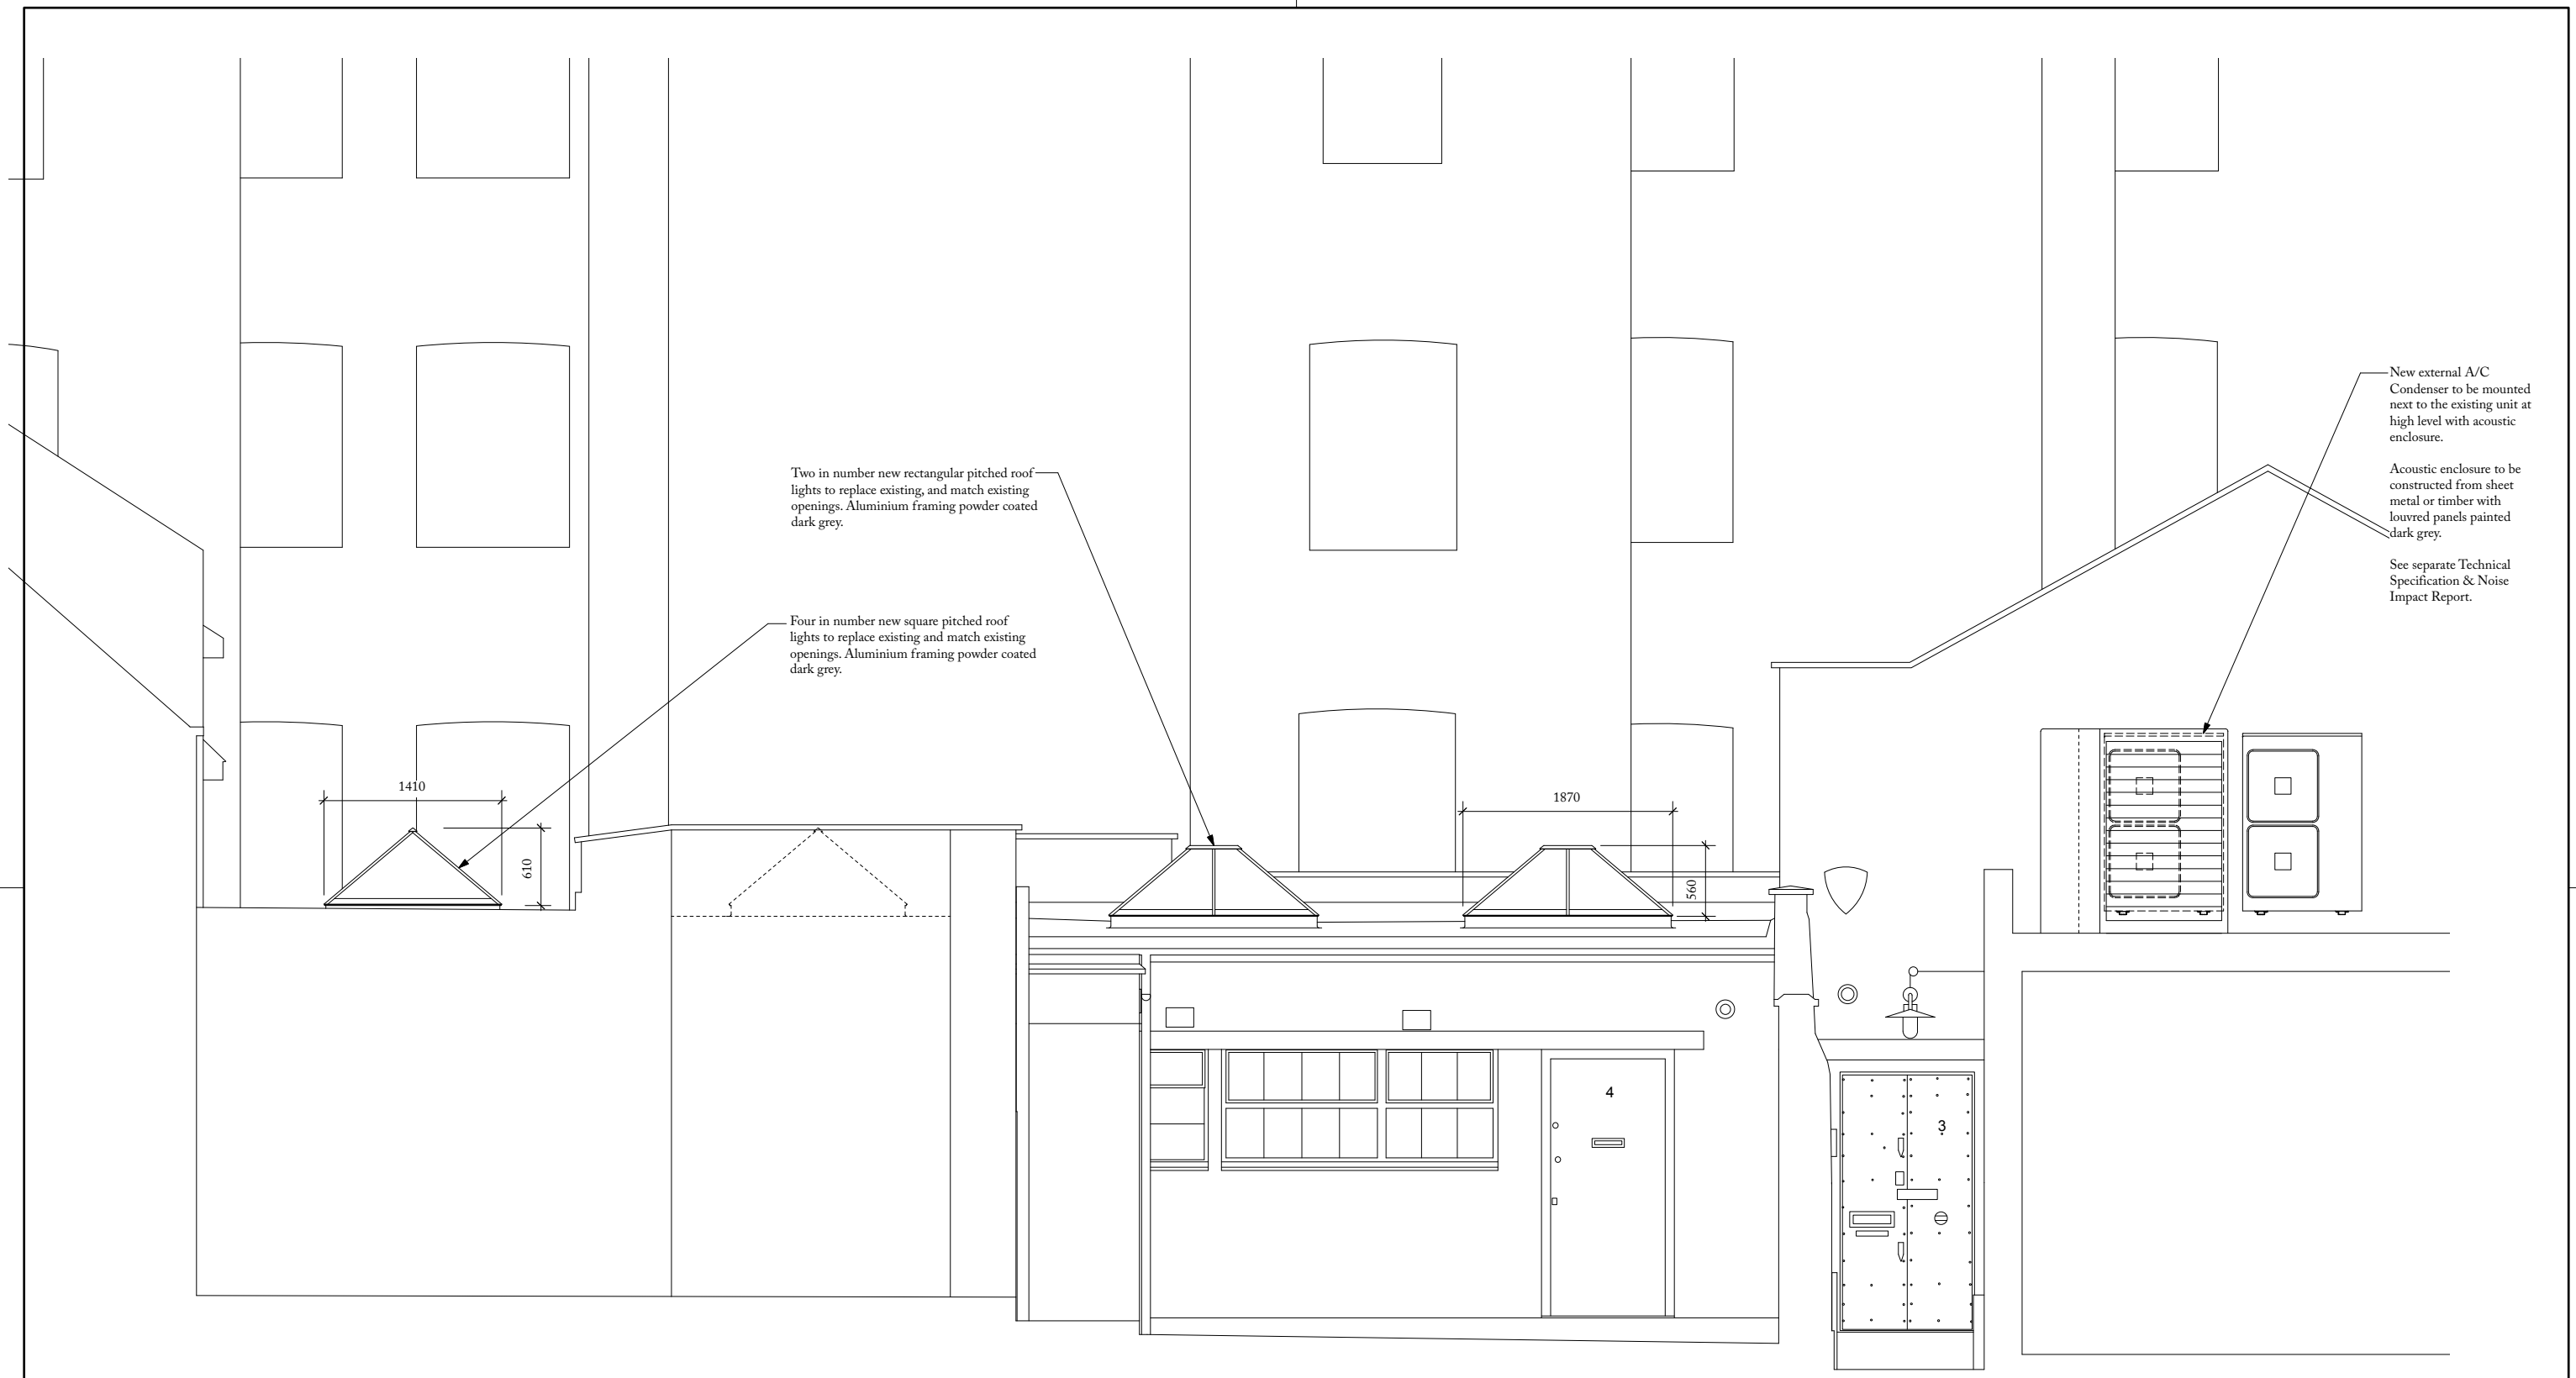

 ① PROPOSED ELEVATION AA  
1:50@A3

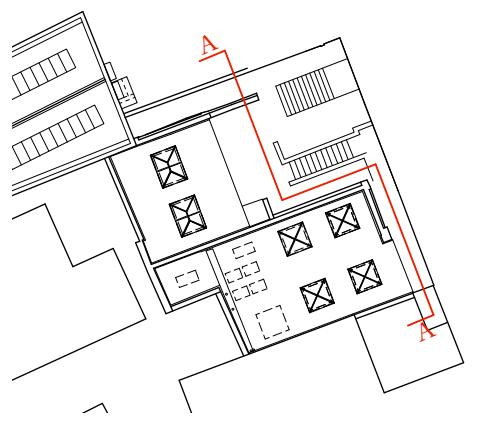

<b>Ben Pentreath</b> <small>3 Lamp Office Court Lamb Conduit Street London WC1N 3NF T +44 (0) 20 7430 2424 benpentreath.com</small>	
PROJECT:	4 LAMP OFFICE COURT
TITLE:	PROPOSED ELEVATION AA
DRAWING NO: A-200	REV. NO: B
SCALE: 1:50 @ A3	DRAWN BY: PWD
DATE: 12/12/2018	CHECKED BY: MU
<small>All dimensions to be checked on site. All designs © Ben Pentreath Ltd 2018. Not to be reproduced without permission</small>	