



0m 1m 2m 3m 4m 5m
1:50 scale

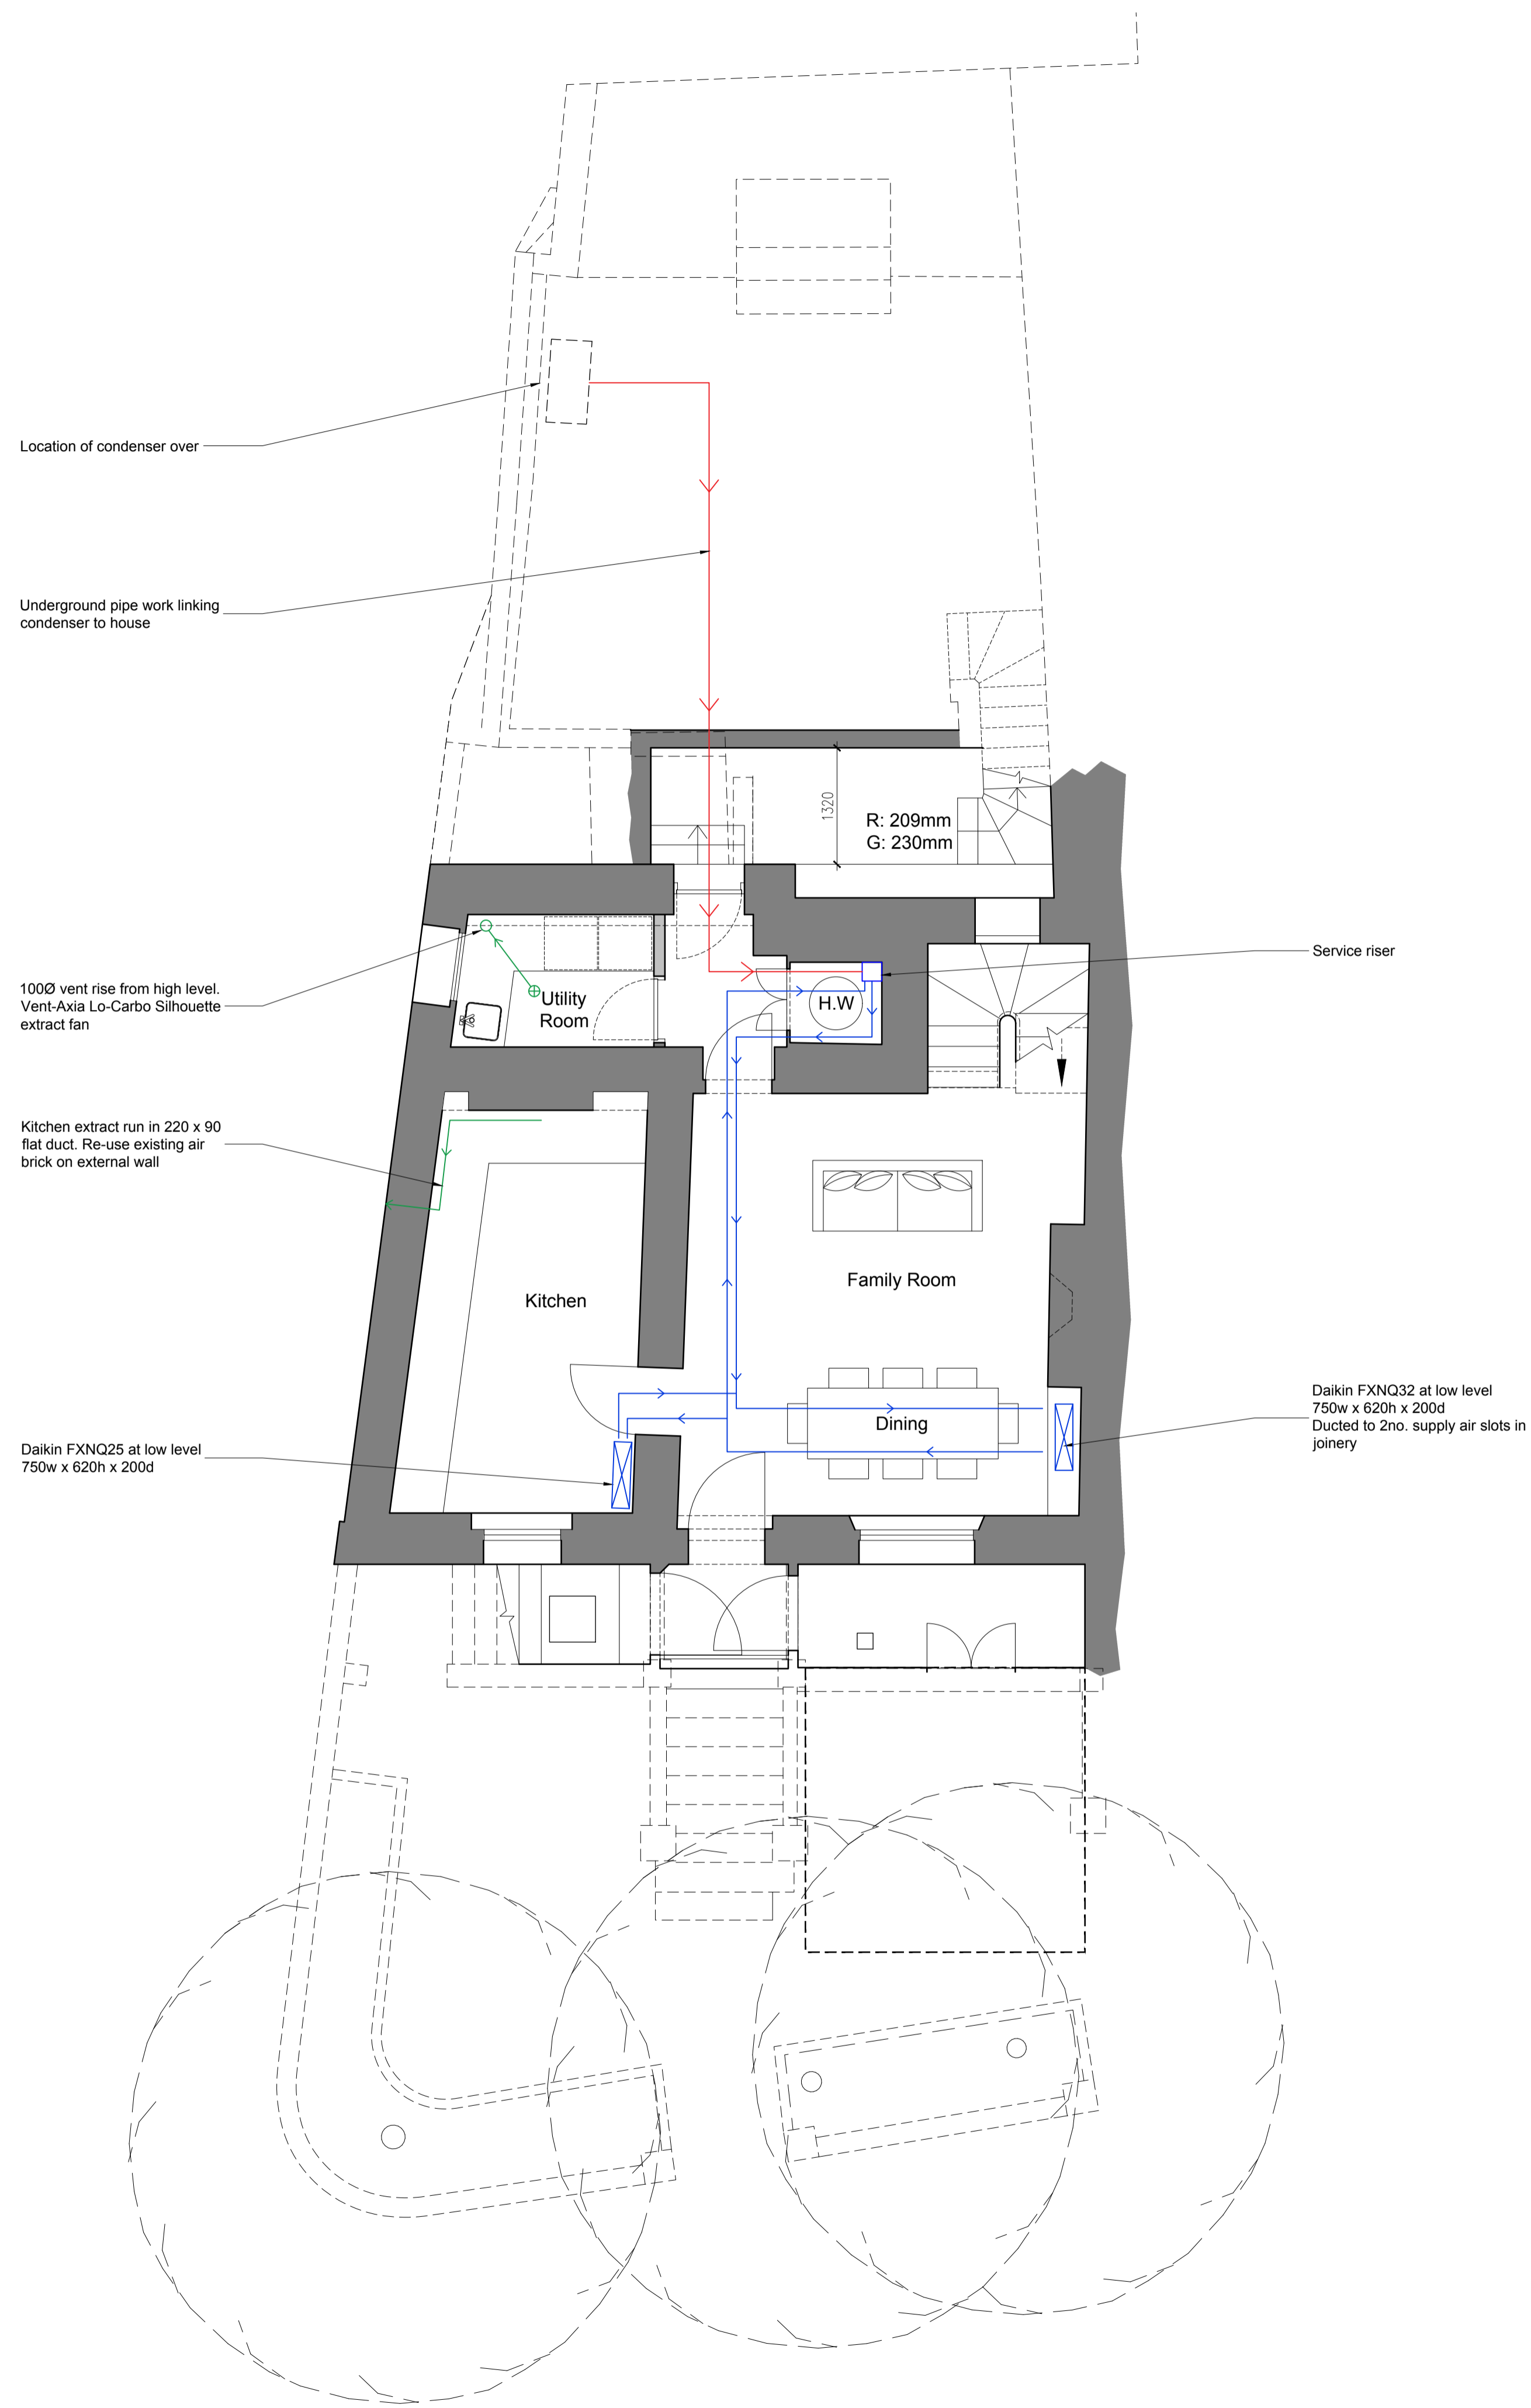

KEY

- Overhead flow and return pipework
- Underground pipework externally
- Extract ductwork leading to external air brick
- FCU
- Service Riser

Alterations to room layouts already approved under 2018/1897/P and 2018/2525/L

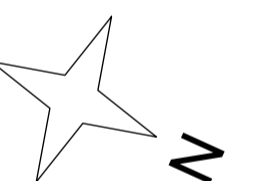

ALL DIMENSIONS APPROXIMATE

SCHEME DESIGN SUBJECT TO STRUCTURAL ENGINEER / SERVICES ENGINEER, & PLANNERS COMMENT

FOR PLANNING

Client | Description | By

BB PARTNERSHIP LTD

CHARTERED ARCHITECTS

Studios 33-34, 10 Hornsey St, London, N7 8EL
Tel 020 7336 8555 - e-mail - architect@bbpartnership.co.uk

client
Andrew and Michaela Saffrin

project
1 The Mount
Hampstead
NW3 6SZ

drawing
Proposed Lower Ground Floor Plan

date	scale	drawn by
Dec 18	1:50@A1/1:100@A3	MC

drg.no.	revision
FWG_1019	-

© 2018 BB PARTNERSHIP LIMITED - ALL RIGHTS RESERVED
DO NOT SCALE - CHECK ALL DIMENSIONS ON SITE

Proposed Lower Ground Floor Plan

1:50