


**NOTE**  
 Refer to M&E drawings for Utility cupboard, kitchen and electrical layouts.  
 For further Entry Equipment Please Refer to M&E Drawings.  
**Pendant Lights & Pendant Wiring position shown on RCP Plans.** Wired connection point for possible future pendant with associated puttyring. Separate switch for each Pendant.  
**All Pendants to have Winding Gear**  
 Structural requirements for patress TBC by SE.  
 Wiring for speaker system in Living, Dining, kitchen and Master Bedroom, for future installation of speakers by customer.  
 Wiring and connection point to All glazing for electrical Curtains/ Blind System.  
**Dimable Lights** - In Living/dining and Master Bedroom.  
**Automated Lights** - In Utility/Coat cupboards. LED Lights to all wardrobes.  
**Kitchen Manufacture** to provide setting out of all sockets and fittings within cabinets as required. Pop up sockets in kitchens Refer to Detailed Bathroom Layouts drawings.  
**Bathroom layouts** shown indicatively only. Refer to Detailed Bathroom Layouts drawings.  
**Level 02 Light Fittings** - allow for shallow fittings due to limited joist depth / buildup

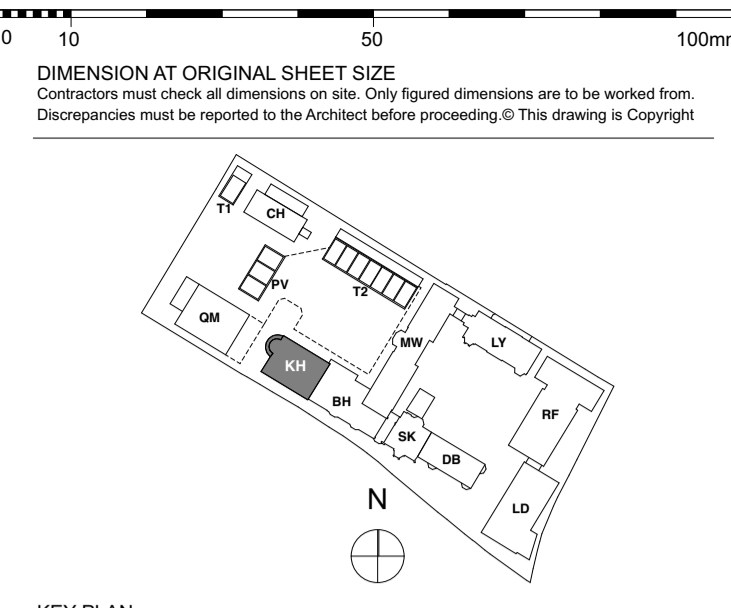

**LEGEND**

	Switch		Heat detector
	2 way switch		Extractor
	3 way switch		Air supply in
	Switch dimmer		Linear air diffuser for supply & extract air
	Pendant light		Emergency Light
	Pendant Wiring		Fire Detector
	Modular Luminare		Fire Detector Sounder base & flashing beacon
	Single downlights		Manual Fire alarm call point
	Double directional downlights		Thermostatic Sensor
	Wall light, internal		Access Panel
	Recessed low energy LED downlighter		Surface Mounted LED Circular Luminare
	LED strip lighting to wardrobes & under wall units		Fob Access
	Wall light, external		Speakers
	Recessed wall lights at floor level		Recessed uplighter
	Wall light		Deck Mounted Light
	Single socket		FCU Isolator
	Double socket		
	Famp switch sockets for lamp circuit		
	Lockable single cleaners socket		
	PIR Passive Infrared Sensor		
	Shaver socket		
	Video entryphone and intercom		
	TV media plate. Refer to M&E specification		
	BT phone & data point		
	Floor recessed outlet Power, Data		
	Smoke detector		

**Ceiling Info.**

	Ceiling Recess
	Existing Cornice
	Proposed Cornice to match existing
	New Cornice
	Dropped Ceiling

**FOR CONSTRUCTION**

REVISION	DRN	CHKD	DATE	
C1	Issued for Construction	NV	TW	17/01/2017
C2	RCPs reviewed following client's comments in workshop coordination 17.04.17	GC	TW	12/04/2017
C3	Update to Single Dwelling	K/C	K/C	20/12/2016



CLIENT  
 MOUNT ANVIL LTD

PROJECT  
 KIDDERPORE AVENUE

DRAWING  
 Kidderpore Hall  
 Level 02 RCP

SCALE: 1:50 @ A1      DATE: December 2018  
 DRAWING No. 15 230      DRAWN BY: K/C  
 9000-DRG-23KH-02030      REV: c3

A & Q PARTNERSHIP ( LONDON ) LTD  
 THE LUX BUILDING, 2-4 HOXTON SQUARE, LONDON N1 6 NU  
 Tel: 020 7613 2244 Fax: 020 7613 2642 Email: london@aqp.co.uk  
 ARCHITECTURE DESIGN MASTERPLANNING INTERIORS