

NOTE
 Refer to M&E drawings for Utility cupboard, kitchen and electrical layouts.
 For further Entry Equipment Please Refer to M&E Drawings.
Pendant Lights & Pendant Wiring position shown on RCP Plans. Wired connection point for possible future pendant with associated purlin. Separate switch for each Pendant.
All Pendants to have Winding Gear
 Structural requirements for pendants TBC by SE.
 Wiring for speaker system in Living, Dining, Kitchen and Master Bedroom, for future installation of speakers by customer.
 Wiring and connection point to All glazing for electrical Curtains/ Blind System.
Dimable Lights - In Living/dining and Master Bedroom.
Automated Lights - In Utility/Coat cupboards. LED Lights to all wardrobes.
Kitchen Manufacture to provide setting out of all sockets and fittings within cabinets as required. Pop up sockets in kitchens.
Bathroom layouts shown indicatively only. Refer to Detailed Bathroom Layouts drawings.
Level 02 Light Fittings - allow for shallow fittings due to limited joist depth / buildup

KEY PLAN


LEGEND

Lighting & Fire Alarm

- Switch
- 2 way switch
- 3 way switch
- Switch dimmer
- Pendant light
- Pendant Wiring
- Modular Luminare
- Linear Luminare
- Single downlights
- Double directional downlights
- Wall light, internal
- Recessed low energy LED downlight
- LED strip lighting to wardrobes & under wall units
- Wall light, external
- Recessed wall lights at floor level
- Wall light
- Single socket
- Double socket
- Switch sockets for lamp circuit
- Lockable single cleaners socket
- Passive Infrared Sensor
- Shaver socket
- Video entryphone and intercom
- TV media plate. Refer to M&E specification
- BT phone & data point
- Floor recessed outlet
- Power, Data
- Smoke detector
- Heat detector
- Extractor
- Air supply in
- Linear air diffuser for supply & extract air
- Emergency Light
- Fire Detector
- Fire Detector Sounder base & flashing beacon
- Manual Fire alarm call point
- Thermostatic Sensor
- Access Panel
- Surface Mounted LED Circular Luminare
- Fib Access
- Speakers
- Recessed uplighter
- Deck Mounted Light
- FCU Isolator

Ceiling Info.

- Ceiling Recess
- Existing Cornice
- Proposed Cornice to match existing
- New Cornice
- Dropped Ceiling

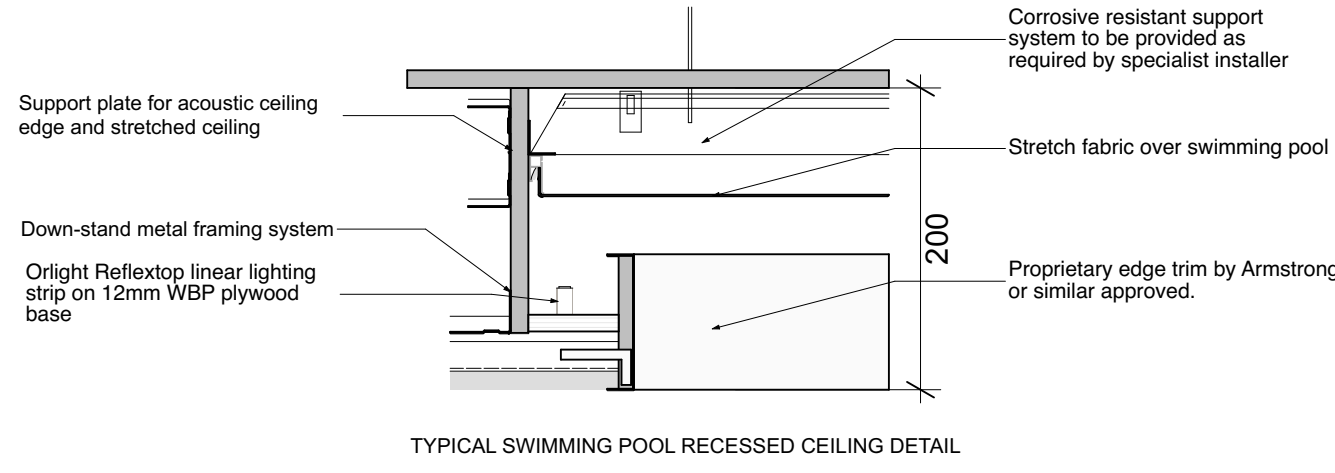

FOR CONSTRUCTION

REVISION	DRN	CHKD	DATE	
C1	Issued for Construction	NV	TW	17/01/2017
C2	Amended as Clouded	NV	KC	03/02/2017
C3	RCAs revised following client's comments in workshop coordination 17.04.07	GC	TW	12/04/2017
C4	Update to single dwelling	KrC	KC	20/12/2018



PROJECT
 KIDDERPORE AVENUE

DRAWING
 Kidderpore Hall
 Level LG RCP

SCALE 1:50, 1:5 @ A1 DATE December 2018

DRAWING No. 15 230 DRAWN BY KrC
 9000-DRG-23KH-LG030 REV C4

A & Q PARTNERSHIP (LONDON) LTD
 THE LUX BUILDING, 2-4 HOXTON SQUARE, LONDON N1 6 NU
 Tel: 020 7613 2244 Fax: 020 7613 2642 Email: london@aqp.co.uk
 ARCHITECTURE DESIGN MASTERPLANNING INTERIORS