



GROUND FLOOR

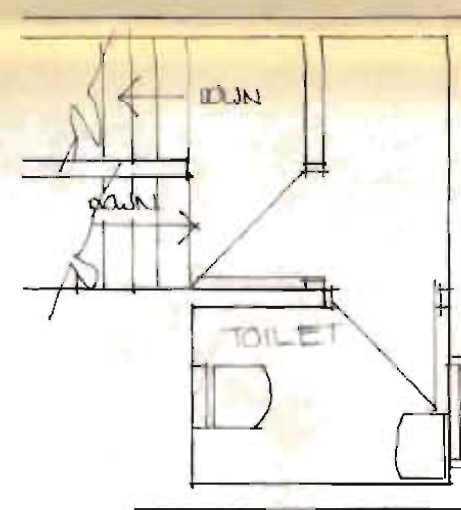

SEMI BASEMENT

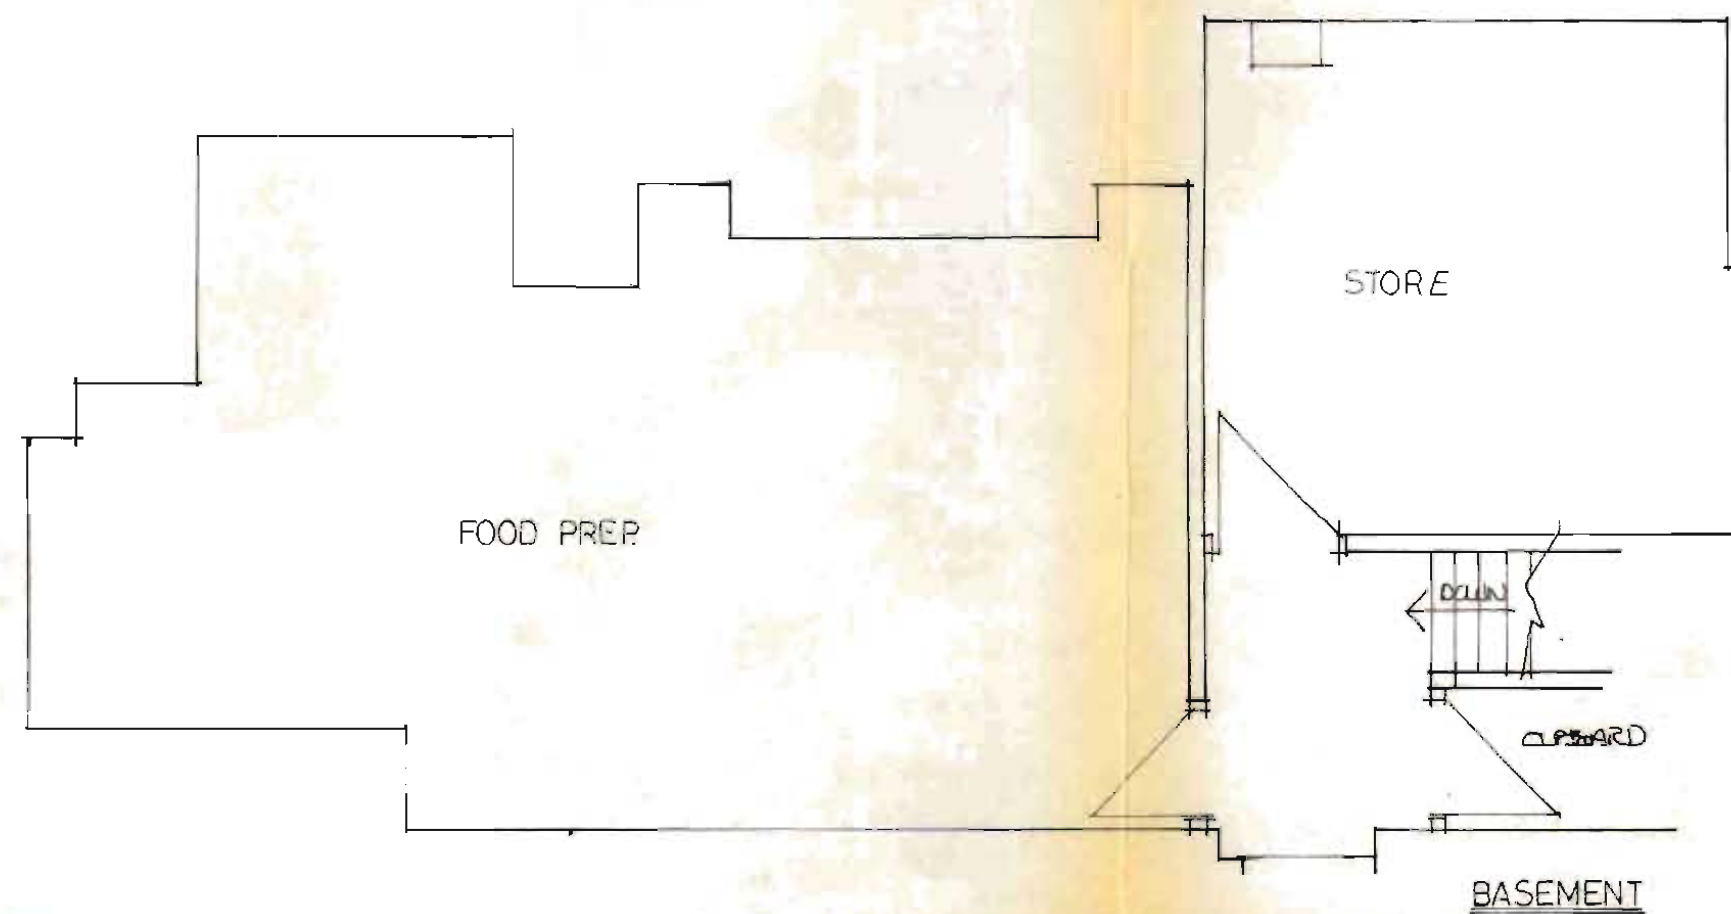


BASEMENT

REVISION A STAIRS OMITTED .
EATING SHELVES REVISED

IP 8903024


LONDON BOROUGH OF CAMDEN
TOWN AND COUNTRY PLANNING ACT 1968
10 JUL 1989
PLANS ~~NOT APPROVED~~ APPROVED
ON BEHALF OF THE COUNCIL

PROJECT	CAPTAIN TONY'S PIZZA 105 HAMPSTEAD RD LONDON NW1
TITLE	LAYOUT PLAN
SCALE	1:50
DATE	28 8 88
DRAWN BY	D FRANKS
DRWG. NO	DF/100/01 A

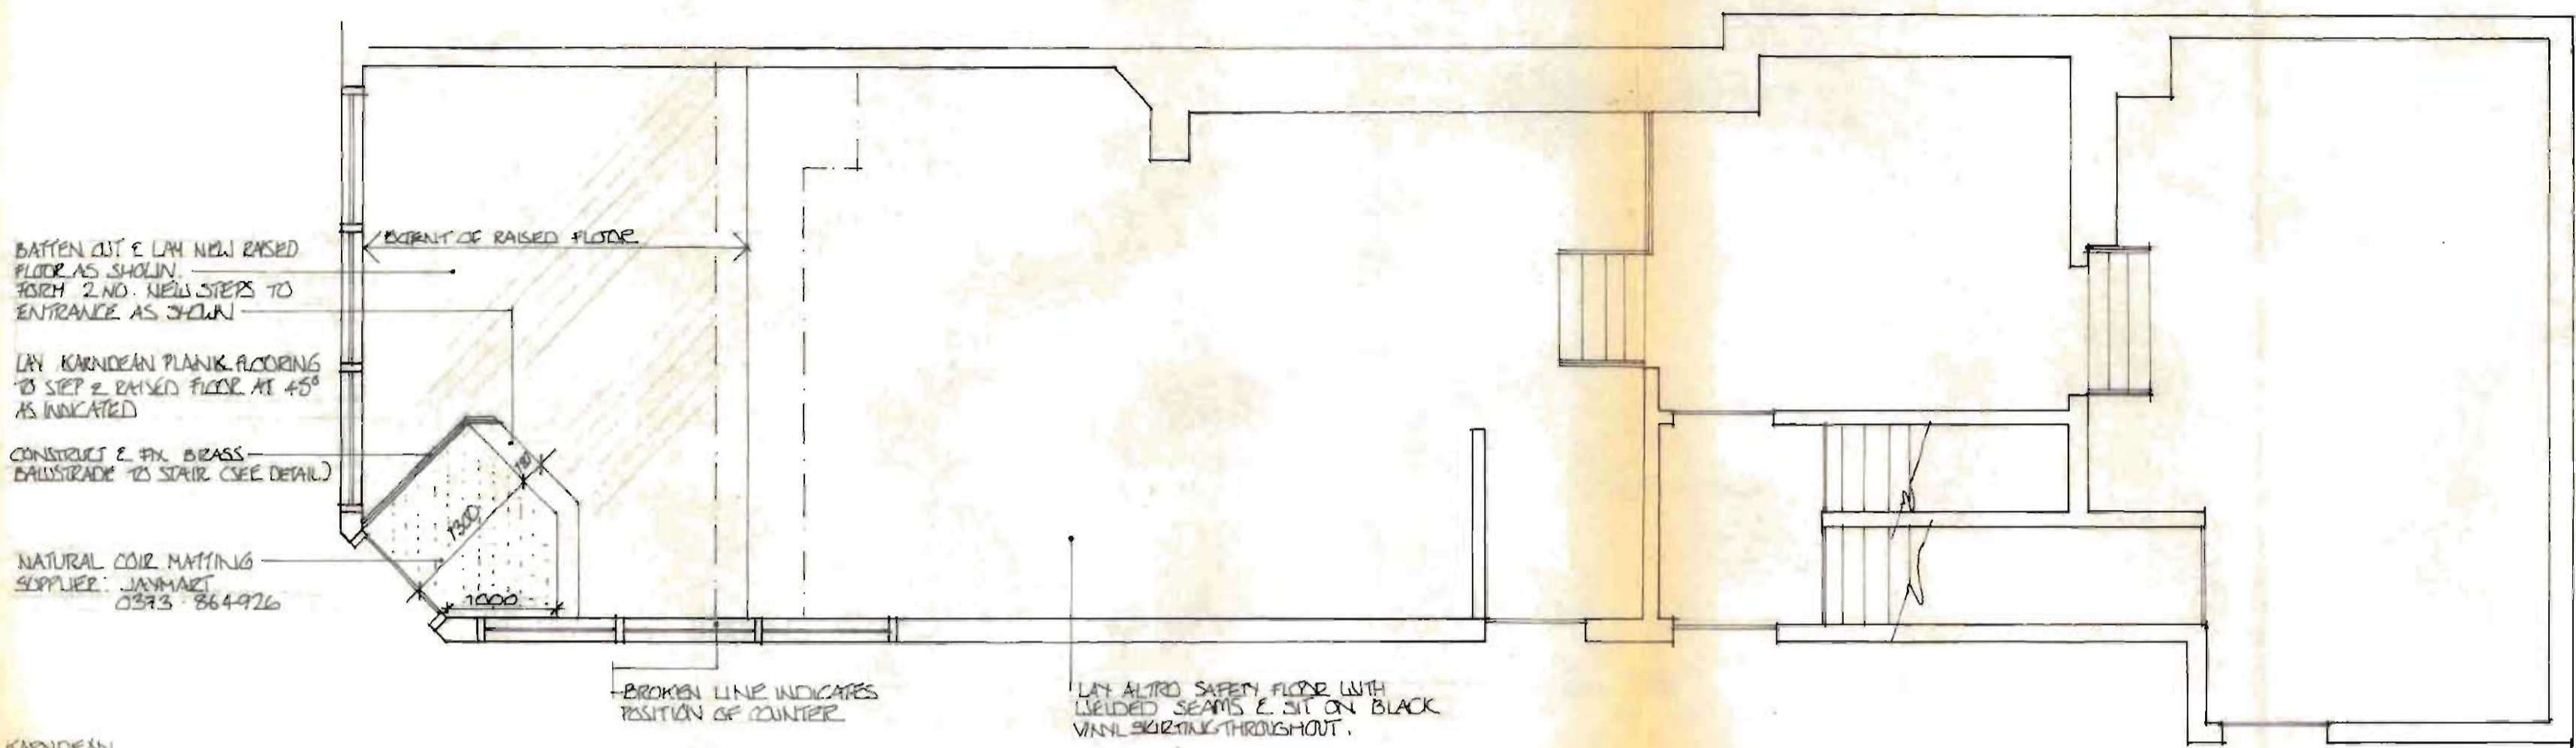


KARNDIEN UNIT 4 MUCKLOW TRADING ESTATE HALLS LANE W MIDLANDS TEL 021 550 9131

GROUND FLOOR

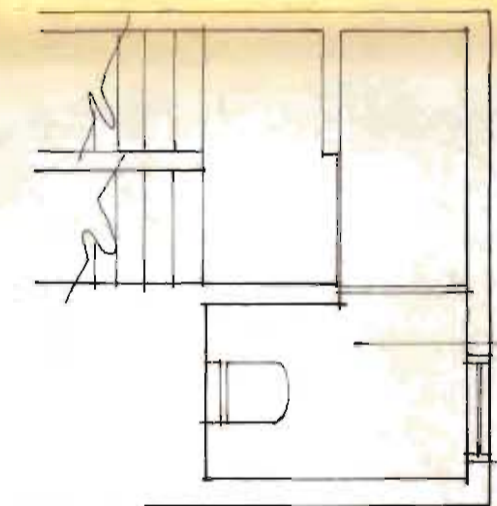

SEMI BASEMENT

LAY ALTRID SAFETY FLOOR THROUGHOUT WITH WELDED SEAMS & SIT ON VINYL SKIRTING

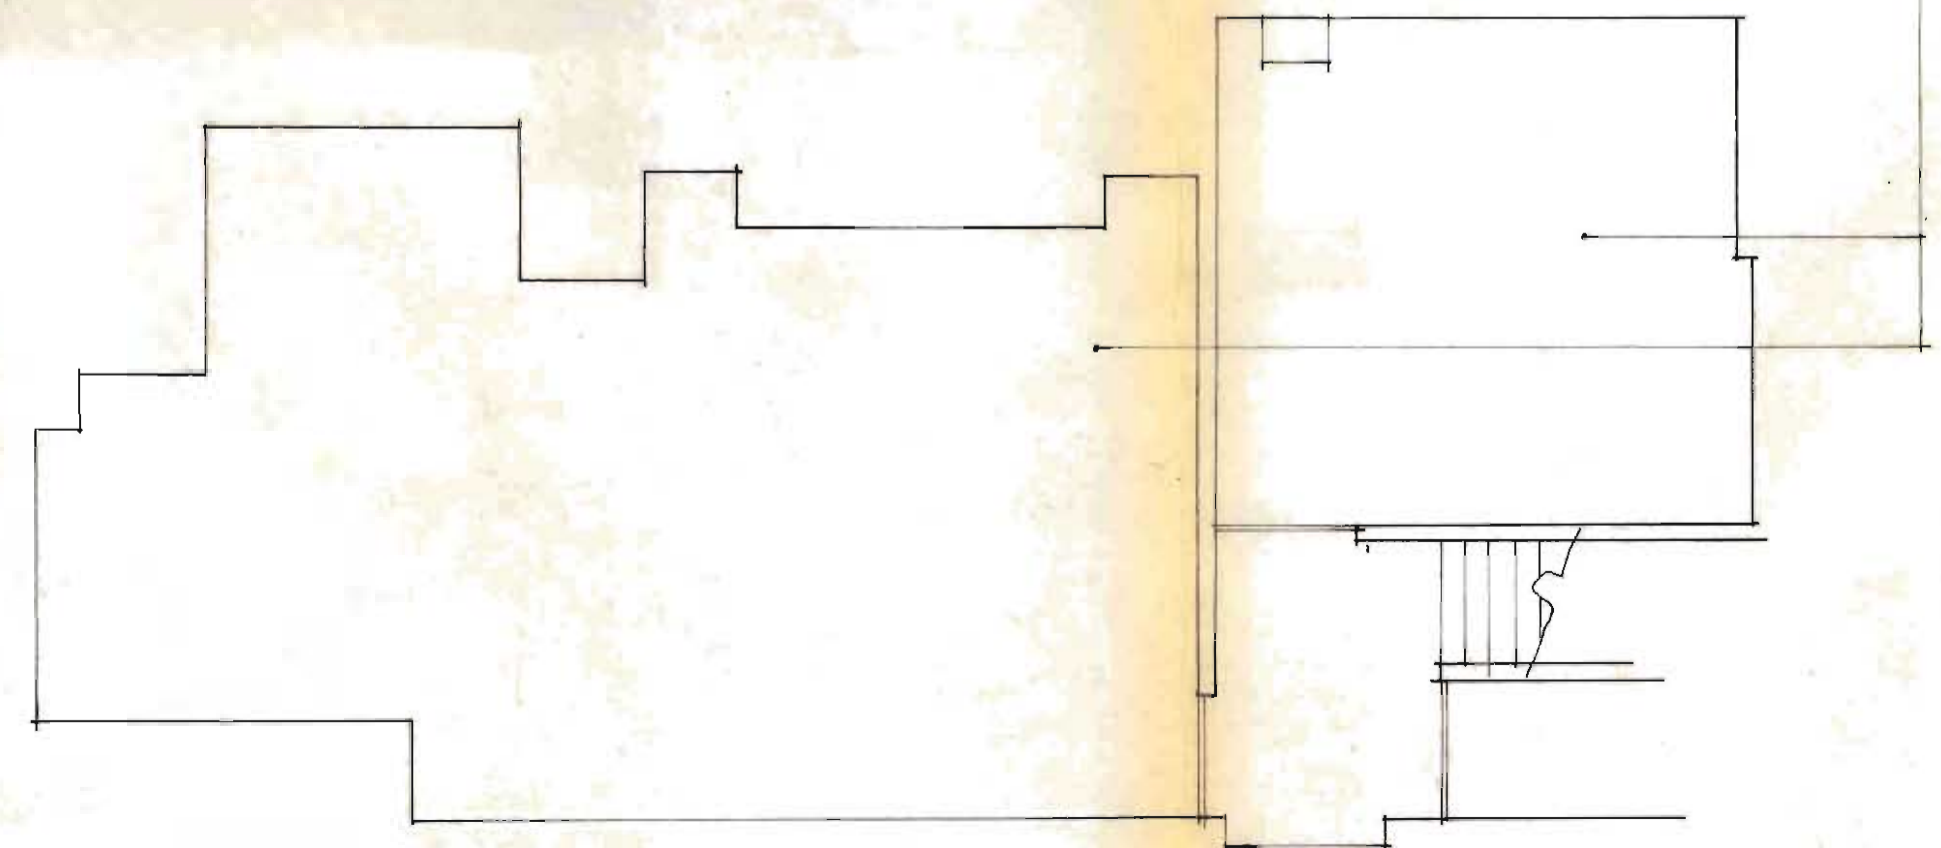

BASEMENT


LONDON BOROUGH OF CAMDEN
TOWN AND COUNTRY PLANNING ACTS
10 JUL 1989
PLANS ~~NOT APPROVED~~ APPROVED
ON BEHALF OF THE COUNCIL

CTP/8903024


REVISION A FLOORING SPEC. (GRINDER VINYL) REVISED

PROJECT	CAPTAIN TONY'S PIZZA 105 HAMPSTEAD RD LONDON NW1
TITLE	FLOOR FINISHES
SCALE	1:50
DATE	28.8.88
DRAWN BY	D FRANKS
DRWG NO.	DF/100/03A

ORIGINAL VENTS AS EXISTING

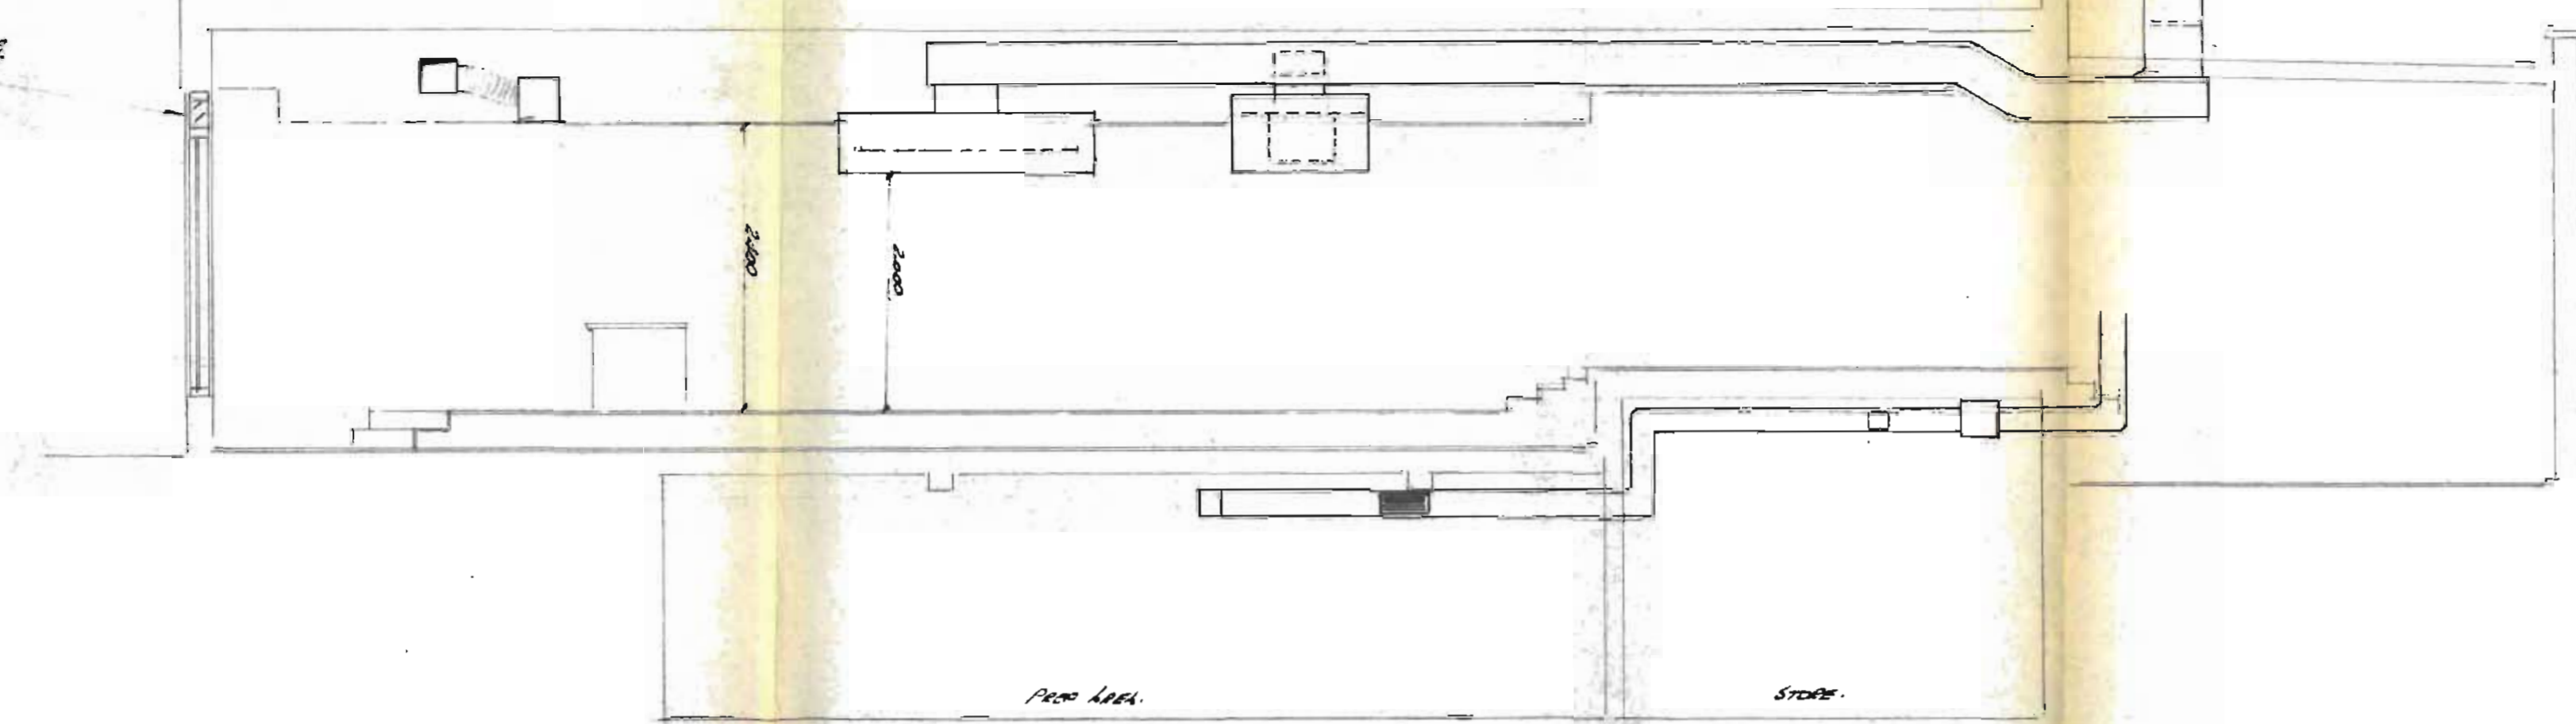

SECTION ON A-A

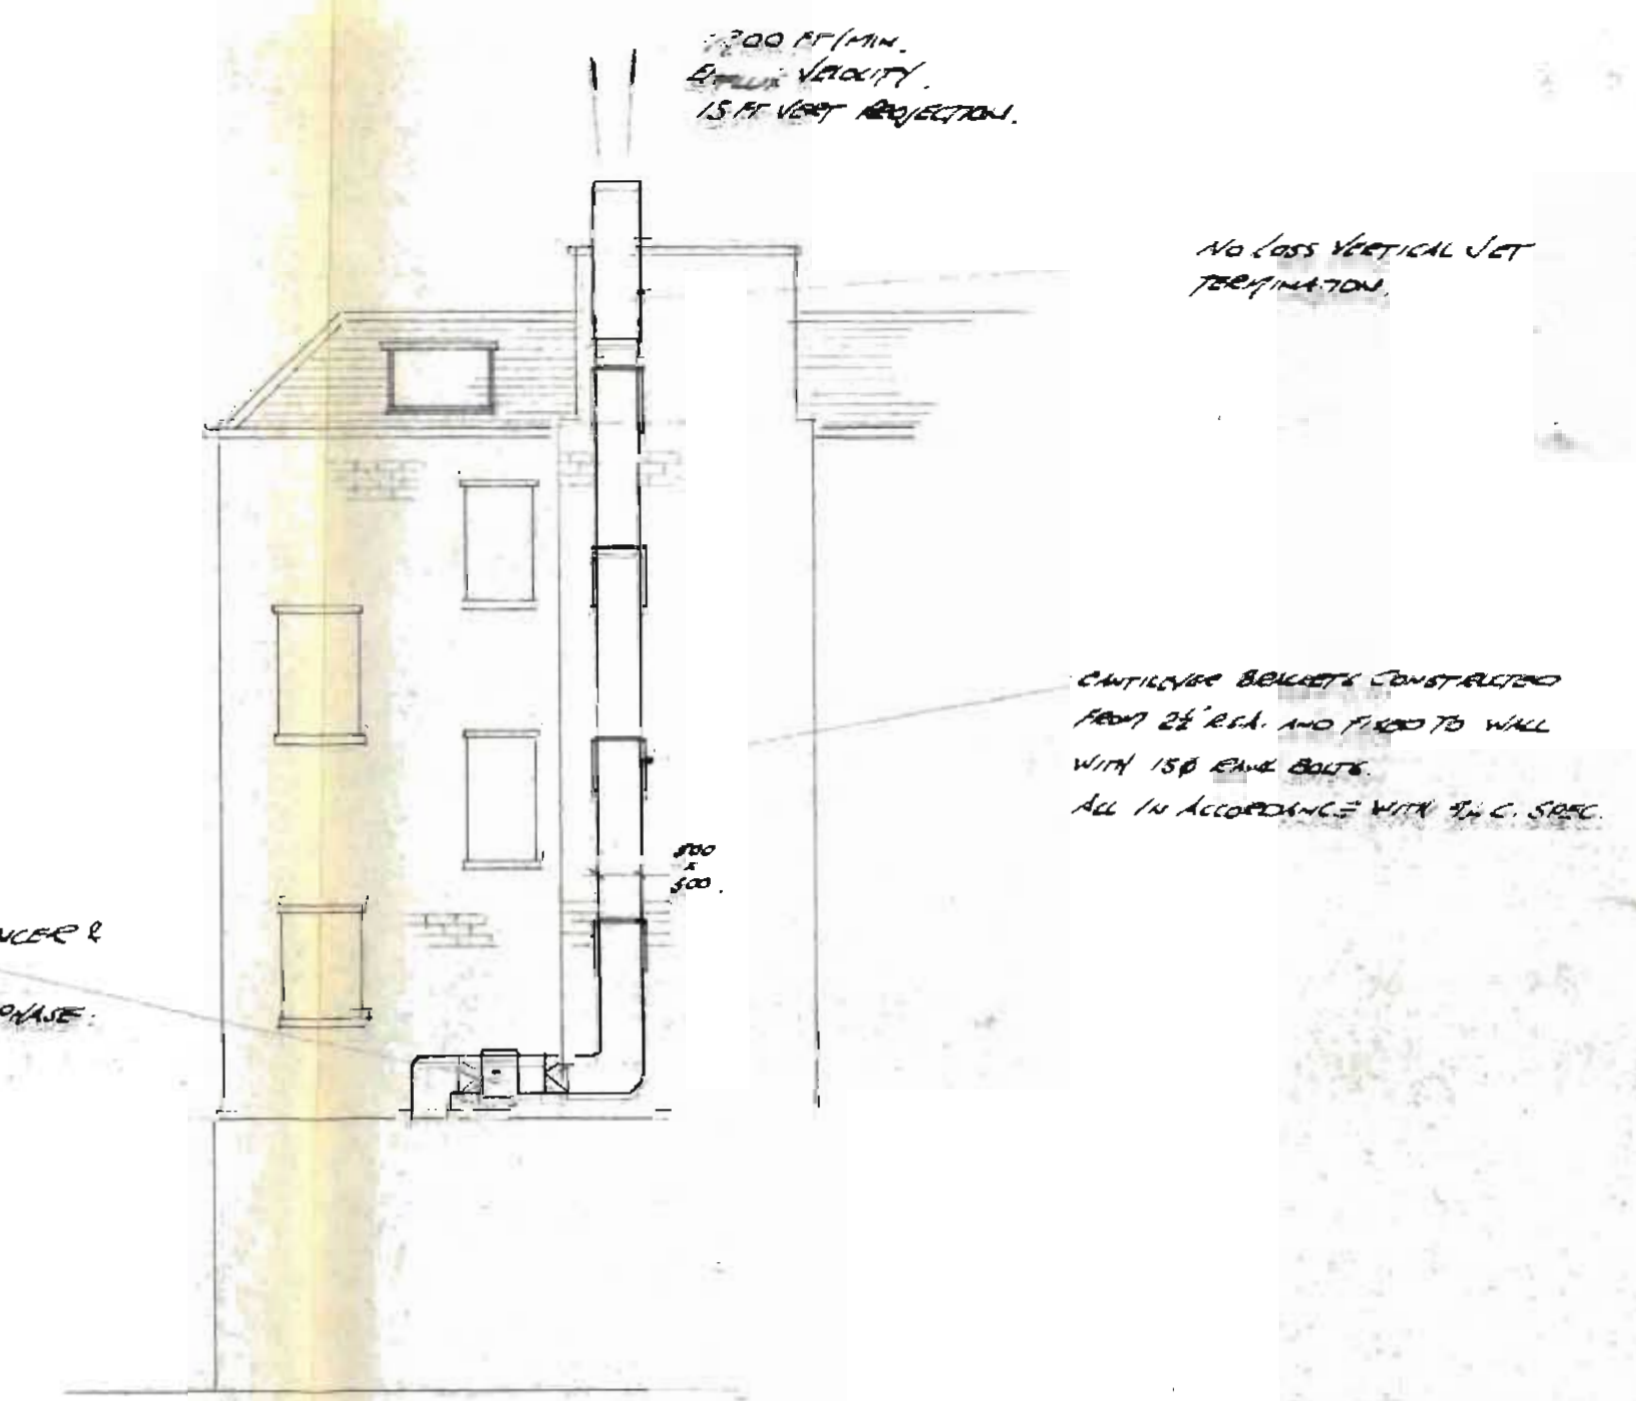

SECOND VIEW ON ARROW B

S-STEEL CANOPY BY HORNWOODS TO VENT ENGINEERS OFFICE

6.5 COND. WITH CONDENSE FILTER (BY HORNWOODS)

200 KW HEATER BATTERY


250 SQ FEET AIR DUCT FROM ROOF OVER OFFICE TO BATHROOM

150 SQ FEET DUCT FROM BATHROOM TO OFFICE

AXIAL FLOW FAN WITH SLOTTED AX MOUNTINGS, 19" DIA X 140 RPM, SINGLE PHASE WITH SPEED CONTROLLER

8 KW HEATER BATTERY 2 x 4 KW STAGES, MANUALLY SWITCHED, 4°C TO 22°C

400 x 200 ALUMINIUM LOUVER

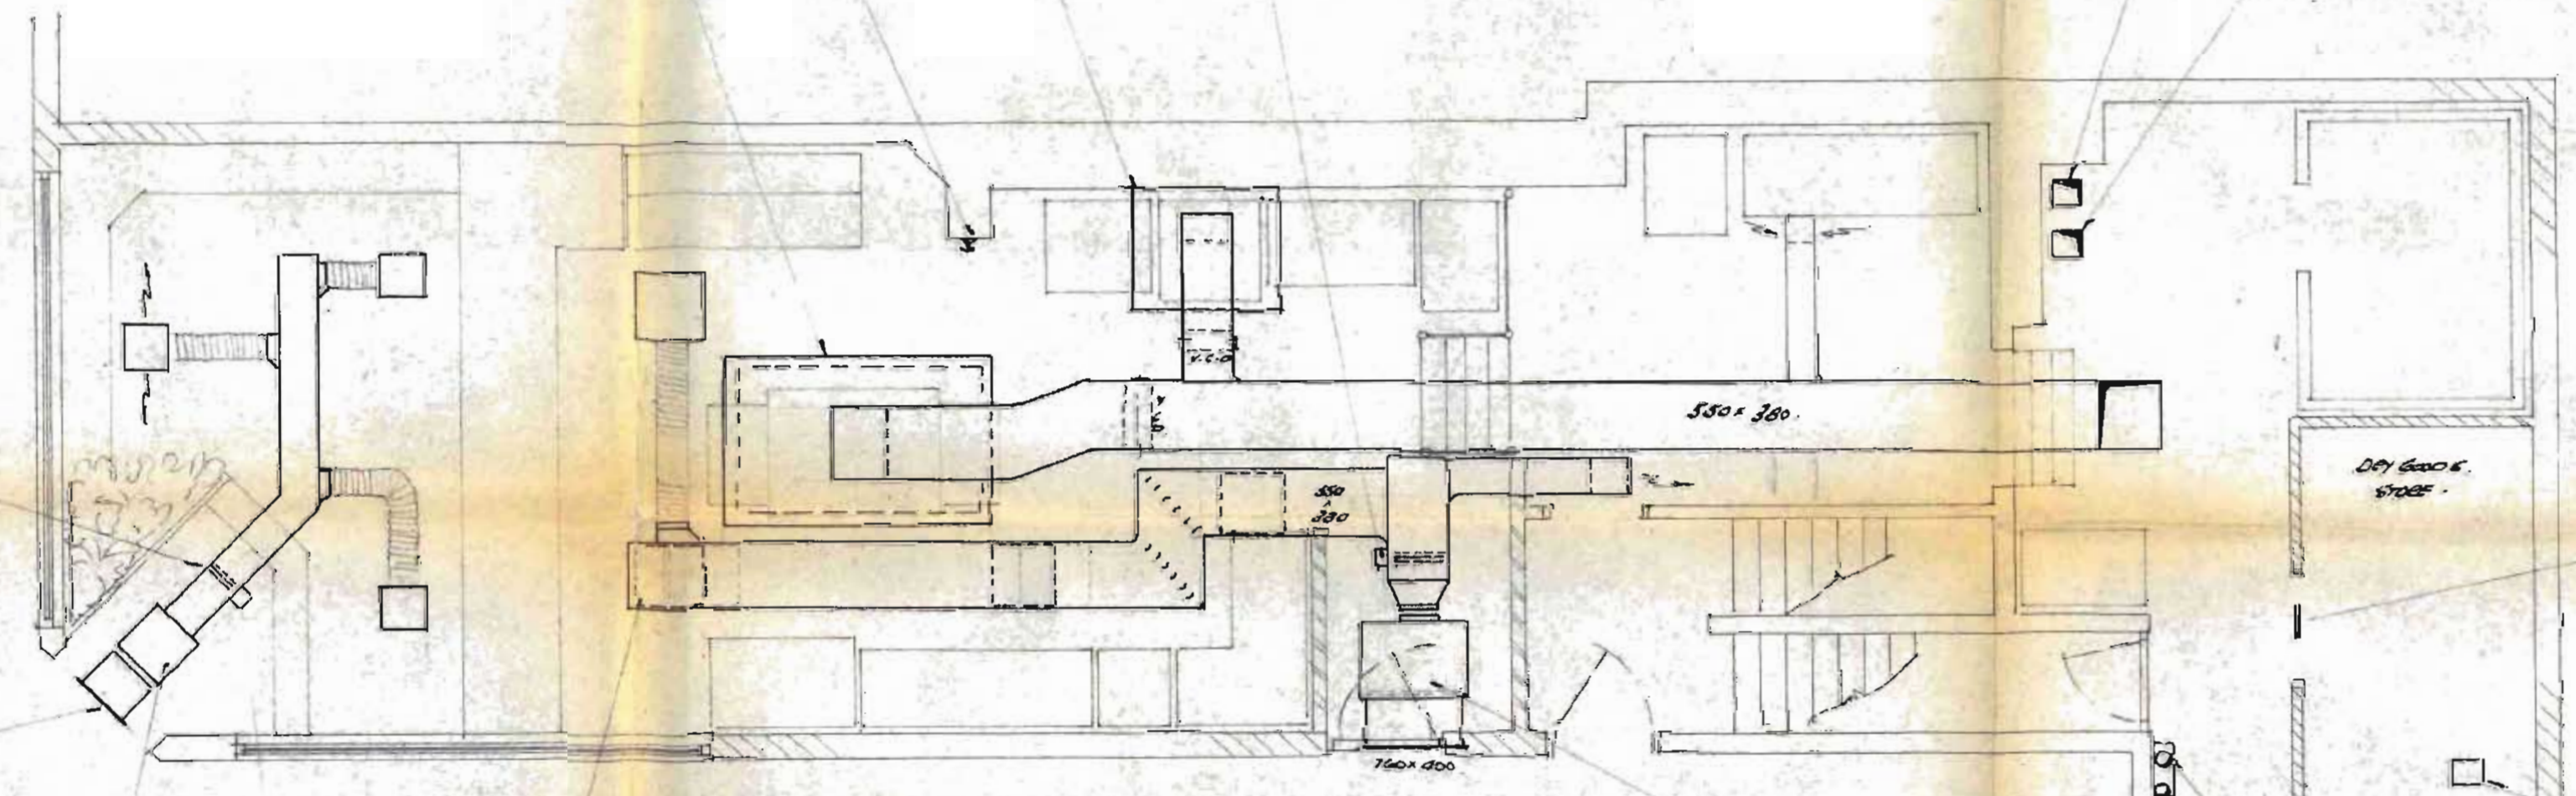

PLAN AT GROUND FLOOR LEVEL

500 SQ FEET ALUMINIUM DIVIDERS

FAN INPUT UNIT WITH FILTERS, DUCT 800 CFM

WATER AIR UNIT WITH FILTERS, DUCT 1800 CFM

3000 THERMOSTAT COIL


9 1/2" ROOF FAN

TWO 1/2" DUCT RISE TO ROOF OVER (TO BE PER CASE)

100 SQ FEET FRESH AIR TO LOBBY


LOBBY EXTRACT UNIT

PLAN AT MEZZAINE LEVEL

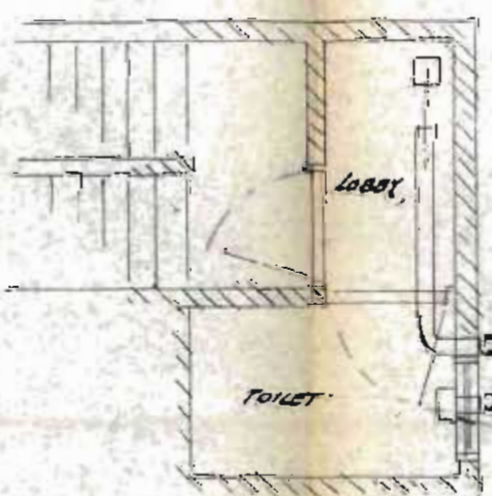

AIR CHANGE RATES

- GROUND FLOOR AREA:
 - MINUTE: 30 PER HOUR
 - SURFACE: 50 PER HOUR
- DRY GOODS STORE: 12 PER HOUR
- TOILET: 4 PER HOUR
- STORE BASEMENT: 6 PER HOUR
- ROOF AREA: 8 PER HOUR

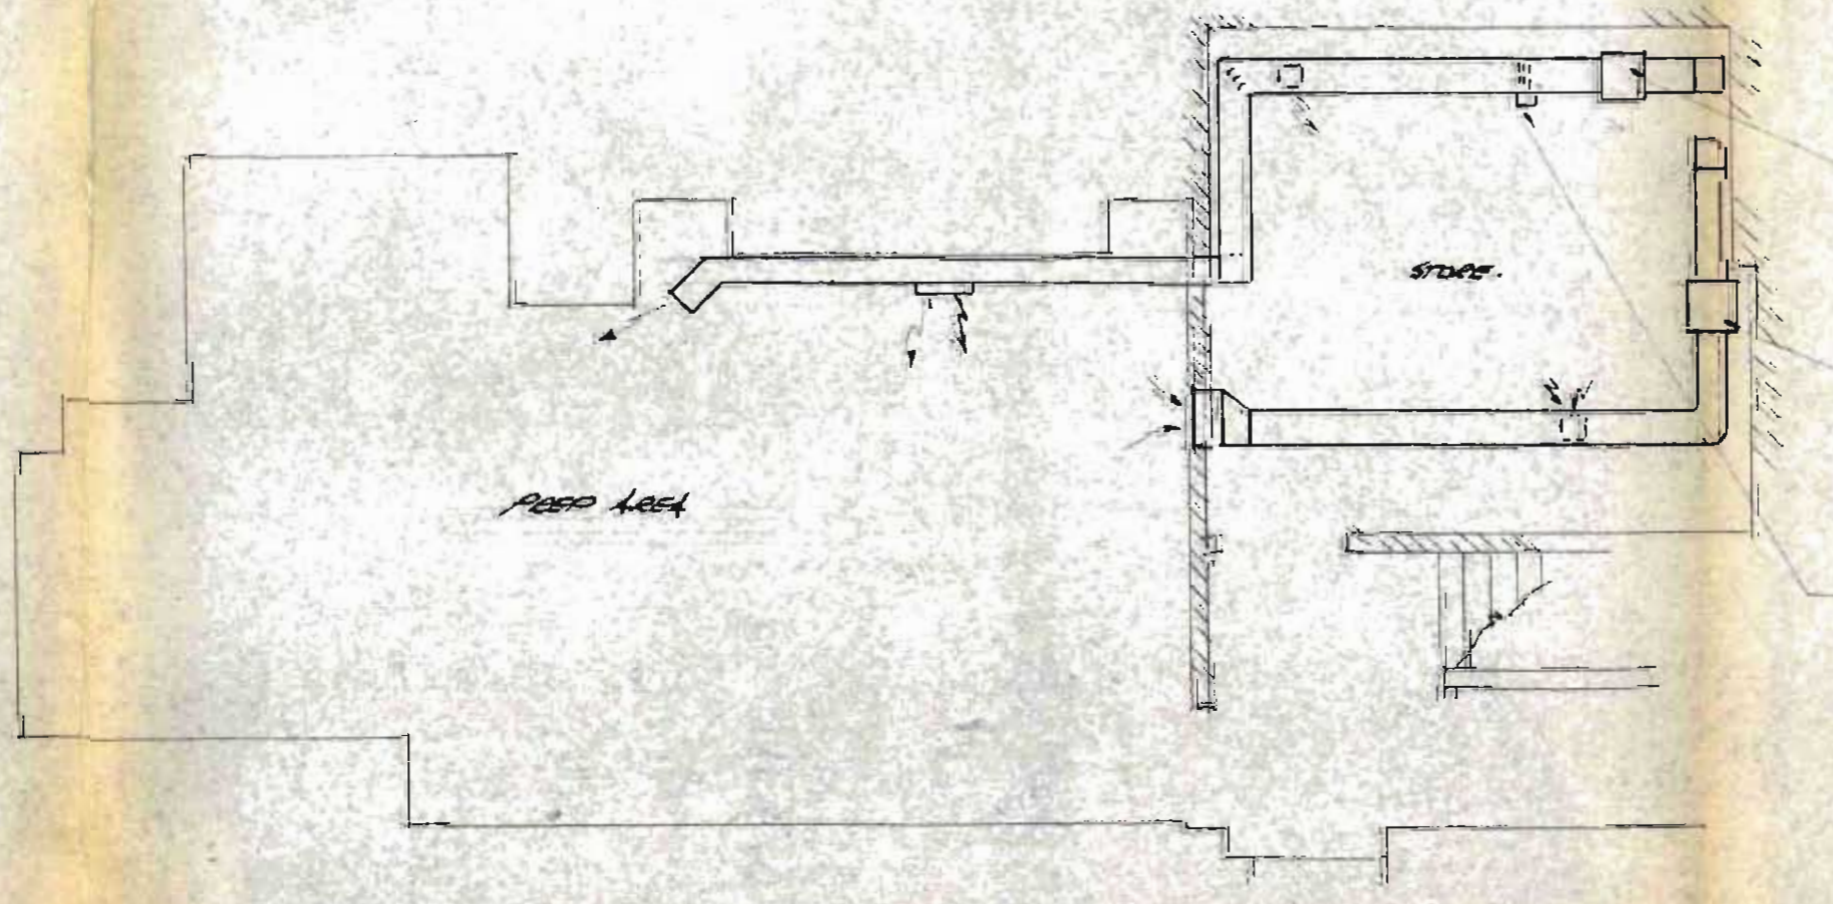

PLAN AT BASEMENT LEVEL

AIR INPUT UNIT WITH FILTERS, 300 CFM

EXTRACT UNIT

4 KW HEATER BATTERY TO FURNACE INCLUDING 2 x 2 KW STAGES, MANUALLY SWITCHED, 20°C - 4°C TO 20°C

ALL OUTSIDE TO BE IN ACCORDANCE WITH EN 142 KVA 4. SPEC.
 ALL WIRING TO BE IN ACCORDANCE WITH IEE REG. 15 EDITION.
 ALL APPROVALS FOR SYSTEM TO BE GRANTED BY SUPERVISING OFFICER.
 ALL BUILDERS WORK & SCHEMATA TO BE CHECKED OFF BY SUPERVISOR.

TABLE OF ELECTRICAL LOADINGS

EQUIPMENT	A	Y	B
INPUT UNIT FAN, FRESH AREA	1	-	-
INPUT UNIT FAN, KITCHEN AREA	3	-	-
INPUT UNIT BASEMENT AREA	-	-	1
KITCHEN EXTRACT FAN	5	-	-
BASEMENT EXTRACT FAN	-	-	1
HEATER BATTERY	8 KW	11	11
HEATER BATTERY	26 KW	36	36
HEATER BATTERY	4 KW	5.5	5.5
LOUVER	-	-	1
ROOF FAN	-	-	1
TOTAL ALL HEATERS ON	57.5	66.5	66.5
TOTAL HEATERS OFF	5	4	4

TP 8903024

Davies Ductwork Designs 0922 37617

LONDON BOROUGH OF CAMDEN
 TOWN AND COUNTRY PLANNING ACT 1968
 10 JUL 1989
 PLANS NOT FOR CONSTRUCTION
 ON BEHALF OF THE CLIENT

SITE: CAPTAIN TONY'S PIZZA, 105 HARLESDEN RD, LONDON N11

REPROPOSE VENTILATION SYSTEM

DATE: 10.7.89 SCALE: 1:50 DRAWN: B.S.1/00

SUSPENDED CEILING AT 2800MM AFFL.
ARMSTRONGS CERAMQUARD
TRAPEZOIDAL TILE IN
EXPOSED GRID (WHITE)
TILE 600x600 REF. 601M
ARMSTRONGS LTD. 01-607 7681

ILLUMINATED MENU BOX SUSPENDED
FROM CEILING, TIMBER FRAME DETAIL
SUPPLIER: SHUICARD SYSTEMS

SYS VENT CANOPY - SUPPLIED
BY HOLWOOD LTD

RECESSED DOWNLIGHTER
CONCORD LYTECASTER
REF. 11711 SATIN GAD Baffle
SUPPLIER: CONCORD 01-253 1200

RECESSED MODULAR LUMINAIRE
MODEL 606 SIZE 600x600
PRISMATIC LAM IN PANEL
SUPPLIER: CONCORD 01-253 1200

GROUND FLOOR

SEMI BASEMENT

CEILING - MAKE GOOD AS
NECESSARY & PAINT 2 COATS EMULSION
LIGHTING - TO REMAIN AS
EXISTING

1200MM SURFACE MOUNTED
TWIN FLUORESCENT FITTINGS


BASEMENT

REVISION A LIGHTING ADDED TO BASEMENT &
PUBLIC AREAS.


TP 89 03024

LONDON BOROUGH OF CAMDEN
TOWN AND COUNTRY PLANNING AUTHORITY
10 JUL 1989
PLANS APPROVED
ON BEHALF OF THE COUNCIL


PROJECT	CAPTAIN TONY'S PIZZA 105 HAMPSTEAD ROAD LONDON NW1
TITLE	CEILING / LIGHTING PLAN
SCALE	1:50
DATE	28.8.88
DRAWN BY	D FRANKS
DRWG NO.	DF/100/04

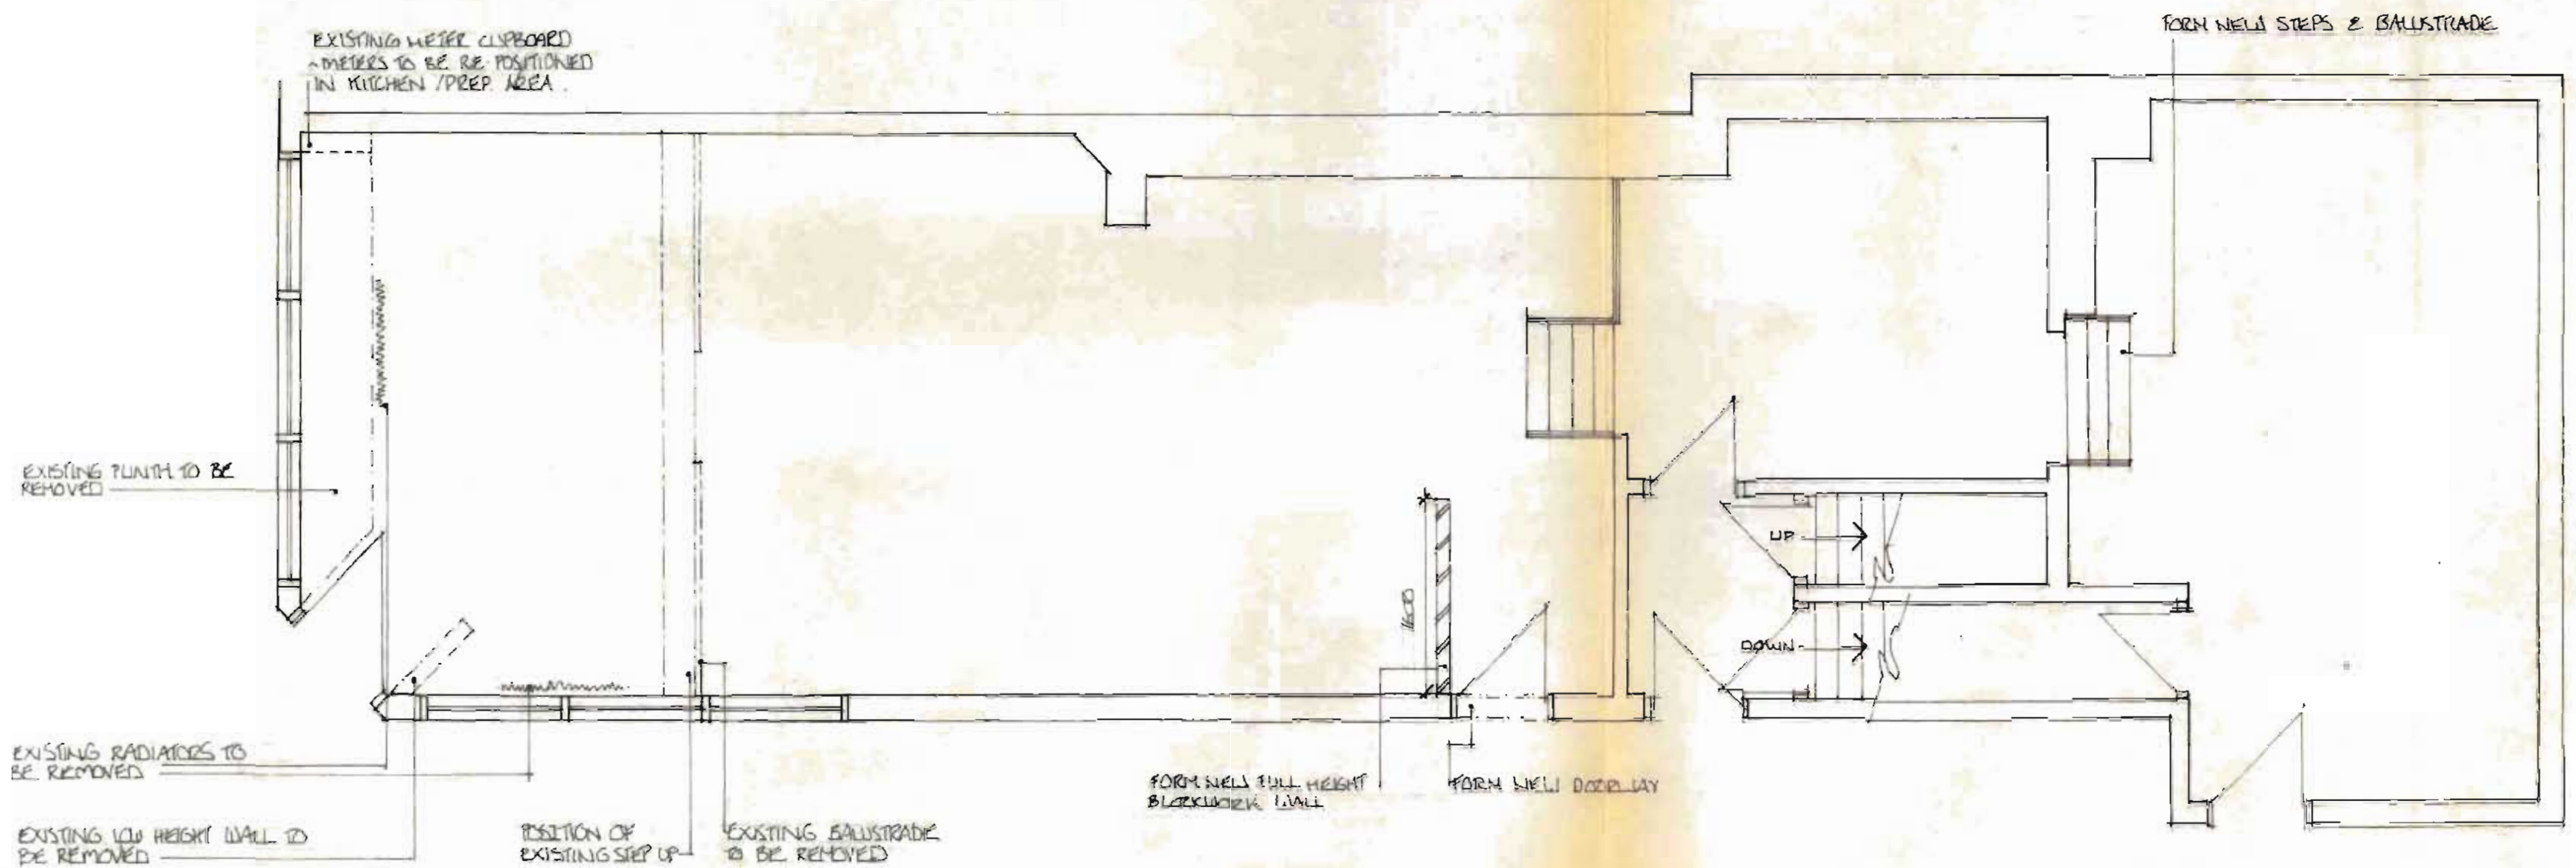

GROUND FLOOR

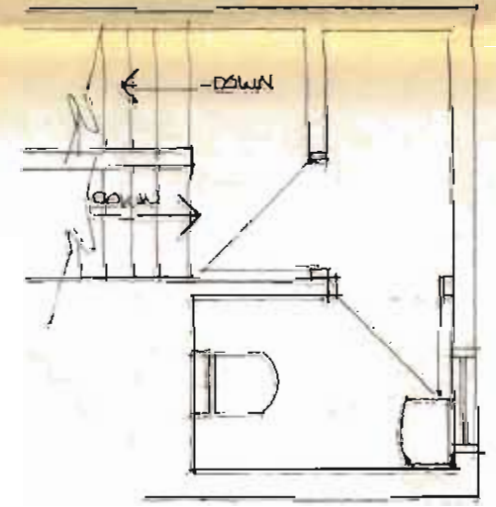

SEMI BASEMENT

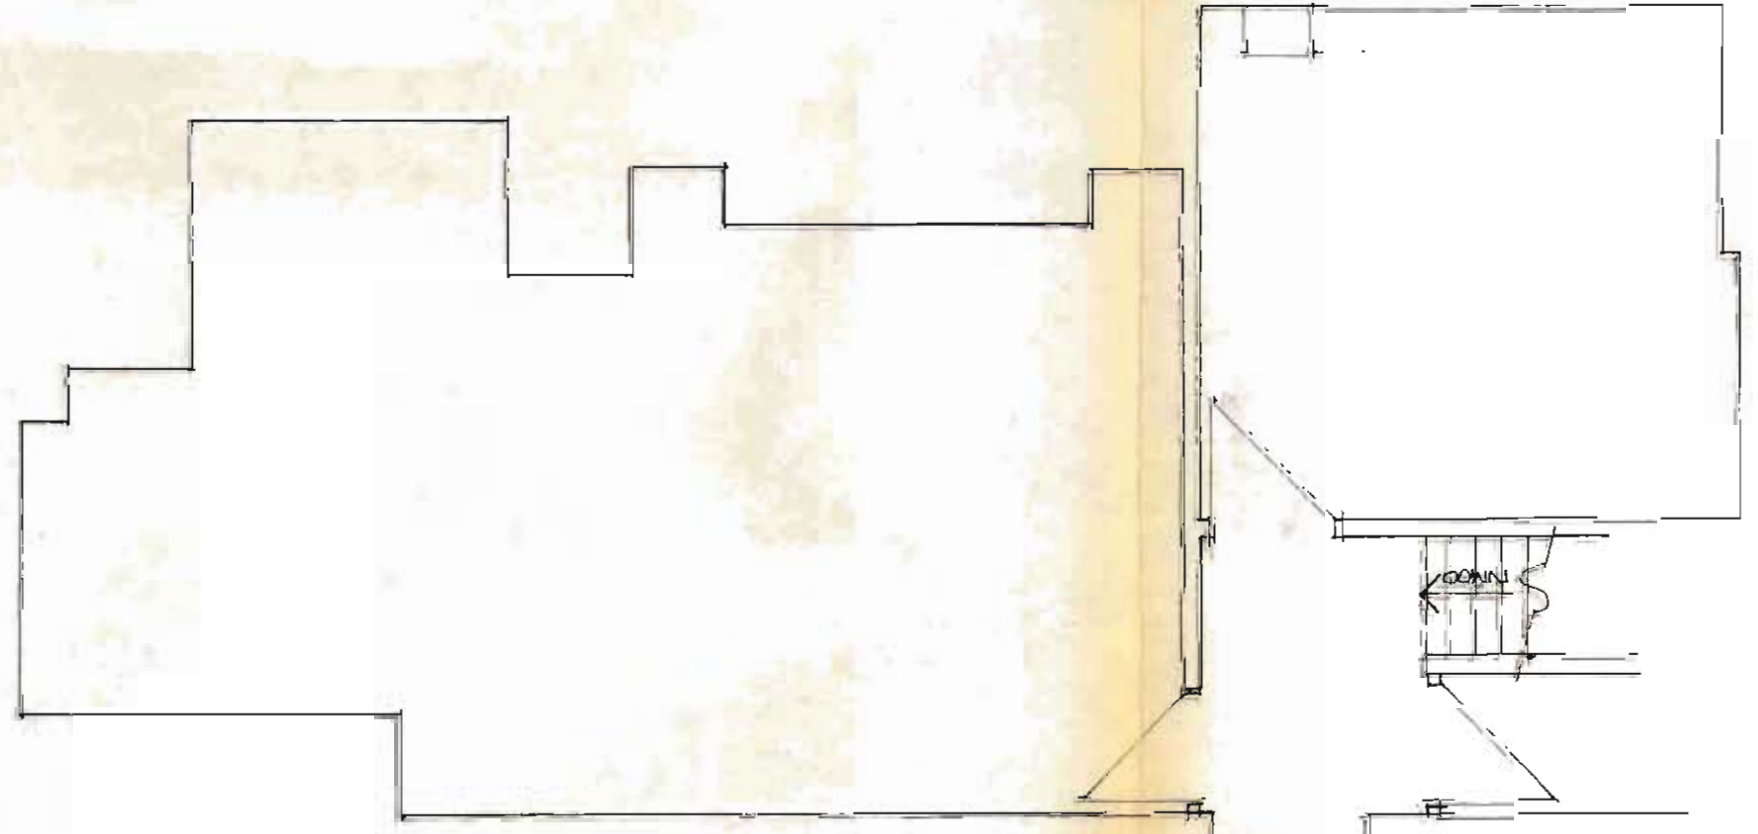

BASEMENT

LONDON BOROUGH OF CAMDEN
TOWN AND COUNTRY PLANNING ACT
10 JUL 1989
PLANS APPROVED
ON BEHALF OF THE COUNCIL

AP 89 03024

PROJECT	CAPTAIN TONY'S PIZZA 105 HAMPSTEAD RD. LONDON NW1
TITLE	BUILDING WORKS
SCALE	1:50
DATE	28.8.88
DRAWN BY	D FRANKS
DRWG NO.	DF/100/02