


KEY

	Double 13amp socket, low level
	Double 13amp socket, worktop level
	Shaver socket
	Fused spur
	Telephone socket
	CAT5E network socket
	One circuit light switch
	Two circuit light switch
	One circuit dimmer switch
	Two circuit dimmer switch
	Extractor fan
	Ceiling recessed LED downlighter
	Ceiling recessed LED downlighter, DIMLESS LED
	Ceiling recessed LED downlighter, IP44 rated
	Floor recessed LED downlighter, IP67 rated
	Floor recessed LED downlighter, LOGIC 60 R WALLWASH
	Wall recessed LED luminaire
	Pendant luminaire
	DELTAUGHT ULTRA C D LED
	LED strip luminaire
	Smoke detector
	Heat detector
	Carbon monoxide detector
	Thermostat

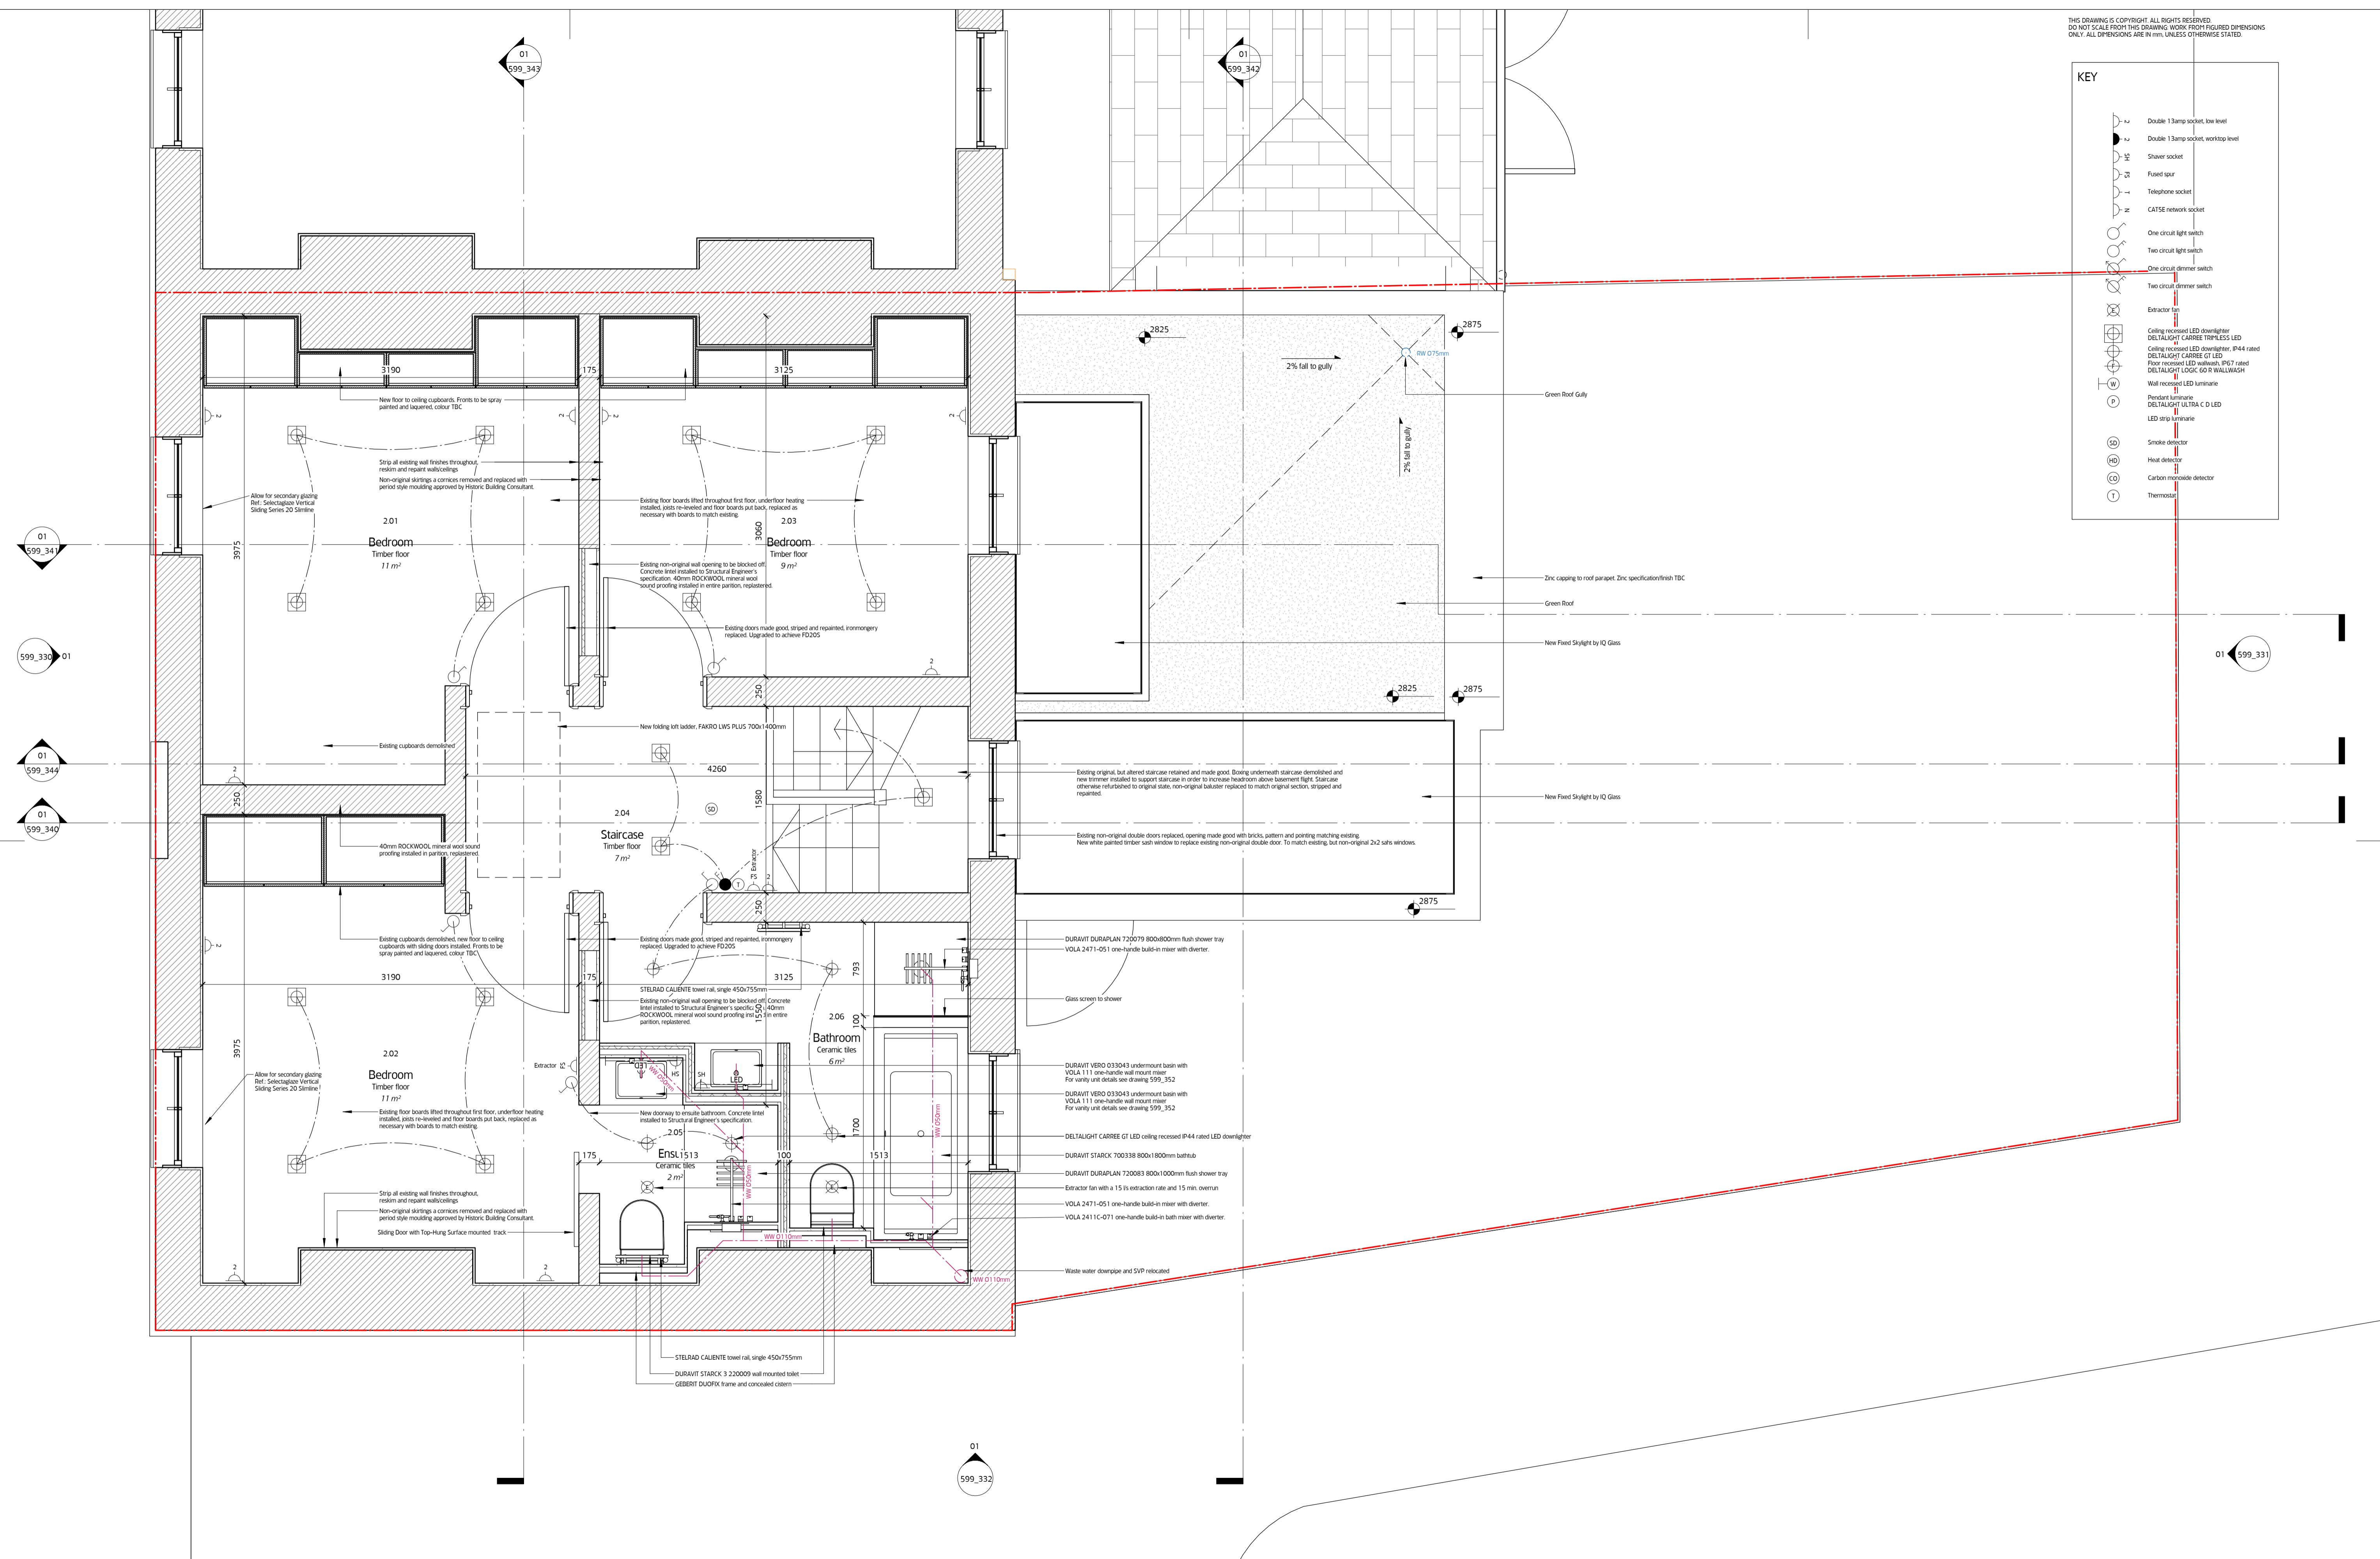

01 Proposed First Floor Plan
1:25

MOXON
LONDON
Great Western Studios, 65 Alfred Road, London W2 5EU
1 0207 034 0088 | 1 0207 034 0099
SCOTLAND
Architect, Creative, Aberdeenshire AD35 5UN
1 01339 742047 | 1 0207 034 0099
mail@moxonarchitects.com | www.moxonarchitects.com

Project		9 St-Martin's Almshouse	
Drawing Title		Proposed First Floor Plan	
Status		Tender	
Drawn by	AM	Checked by	TJM
Project No	959	Scale	AS SHOWN
Date	12.06.18	Date	01.11.18
REV	DATE	DESCRIPTION	DRW
Drawing No			599_322
			Rev 01