


Key to trees:

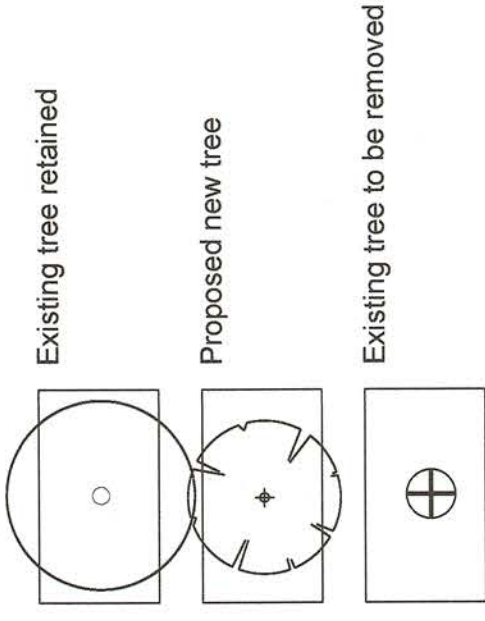

Proposed Trees

- T1 Magnolia 'Gallisonensis' Standard Tree (1.8m clear stem) 3.5m high (2)
- T2 Liquidambar styraciflua 'Worplesdon' Standard Tree, 3.0m high (1)
- T3 Acer palmatum 'Bloodgood' Feathered, 3.0m specimens (2)
- T4 Amelanchier 'Ballerina' Feathered Multi-stem specimens, 3.0m high (2)
- T5 Prunus avium 'Feathered' 3m (2)
- T6 Carpinus betulus 'Fastigiata' 3m (1)
- T7 Acer palmatum 'Dissectum Atropurpureum', 1.0m high specimens (4 in containers)


Key to plan

- 1 Bin store
- 2 New hedge
- 3 Bike store
- 4 Trellis screen
- 5 Sliding gates
- 6 Custom fence
- 7 Retaining wall
- 8 Stone arrival area
- 9 Gate, 760mm wide
- 10 Resin path
- 11 Sloping path, access route
- 12 Upper terrace
- 13 Sculpture
- 14 Low table
- 15 Seating
- 16 Outdoor fireplace
- 17 Wall, 1.8m high
- 18 Box hedge (H2)
- 19 Compacted gravel path (Breedon Gravel)
- 20 Tiered planters
- 21 Bay hedge (H3) 2.5m high
- 22 Hidden storage shed, partly built into bank
- 23 Seat on compacted Breedon Gravel
- 24 Planting (PL1)
- 25 Timber retaining wall to support existing bank, 600mm high, refer to detail
- 26 Raised timber tree playhouse with ladder access
- 27 Existing fences replaced with new 1.8m high close boarded fences (all boundaries)
- 28 2m high trellis screened (hidden) compost area
- 29 Formal lawn
- 30 Herb garden
- 31 Concrete retaining wall
- 32 Sofa with storage box
- 33 Feature wall
- 34 Sofa
- 35 Table
- 36 Stone terrace
- 37 Bin
- 38 Resin drive
- 39 Setts
- 40 Jasmine hedge
- 41 Feature wall
- 42 Box hedge edged ornamental vegetable production beds

A = FOR VEHICLE/PEDESTRIAN ACCESS
B = FOR PEDESTRIAN ACCESS ONLY

REFER TO SPECIFICATION SHEET

FOR LIGHTING UNIT TYPE:

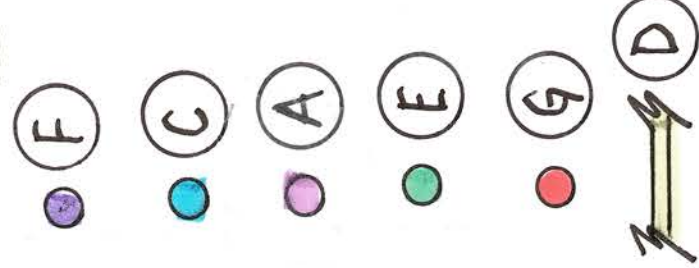

H = POACH
PEDESTRIAN
(SELECTED
BY CLIENT)

Cowley White

Landscape Architecture
208 Empire Square West
Empire Square
LONDON
SE1 4NL
0207-378-8831
07765 237711
email: cowley@cowleywhite.com
www.cowleywhite.com



NORTH



Project: 24 Heath Drive, Hampstead, London NW3
Client: Sarah Bard
CONCEPTUAL EXTERNAL LIGHTING PLAN:
REV: C 25/11/18 Date: 18.12.17
REV: D 20/11/18 Scale: 1:100 @ A1
REV: E 20/11/18 Drawing No. 003
REV: E: 7/1/18 REVISION A: 12/1/2018

