


New Velux rooflight
not to project more
than 150mm
beyond roof plane.
Dark grey powder
coated finish.

FRONT

REAR

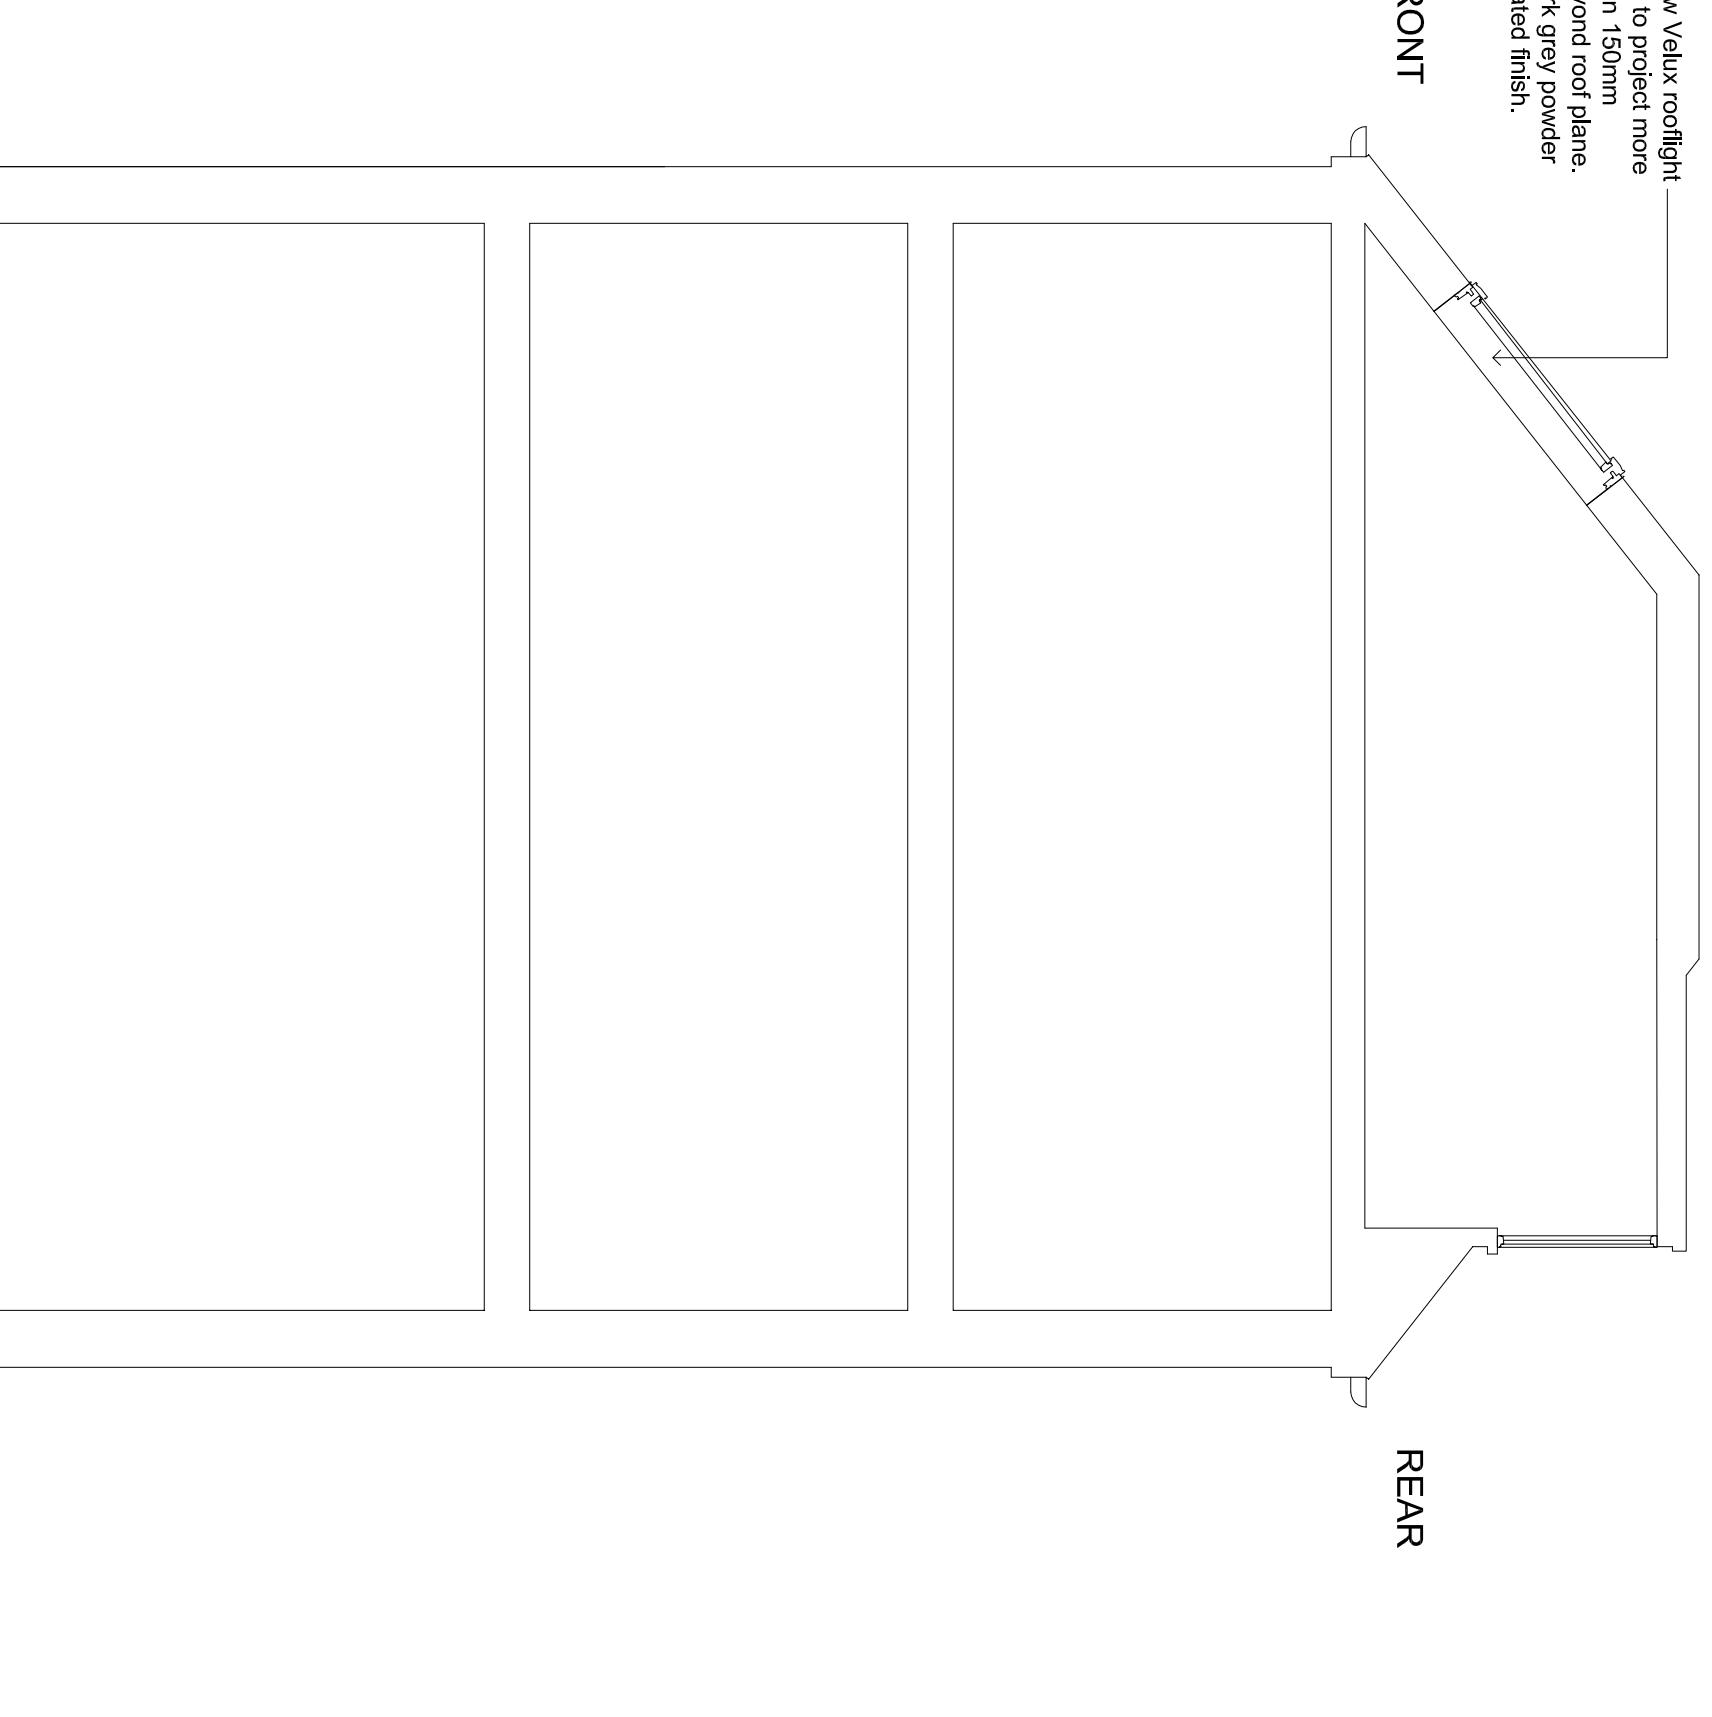

Proposed Section

scale 1:50 @ A3

MIRILAN DESIGN LTD
Unit 3, London Business Park, London, NW2 7AH
Tel: 0208 452 8400 Email: info@mirilan.com

Project
70 PATSHULL ROAD

Drawing Title
PROPOSED SECTION

Scale	Drawn	Checked	Authorised	Rev
1:50 @ A3	-	-	-	-
13 February 2018				
Drawing Number				
SK_70 PATSHULL_08				