


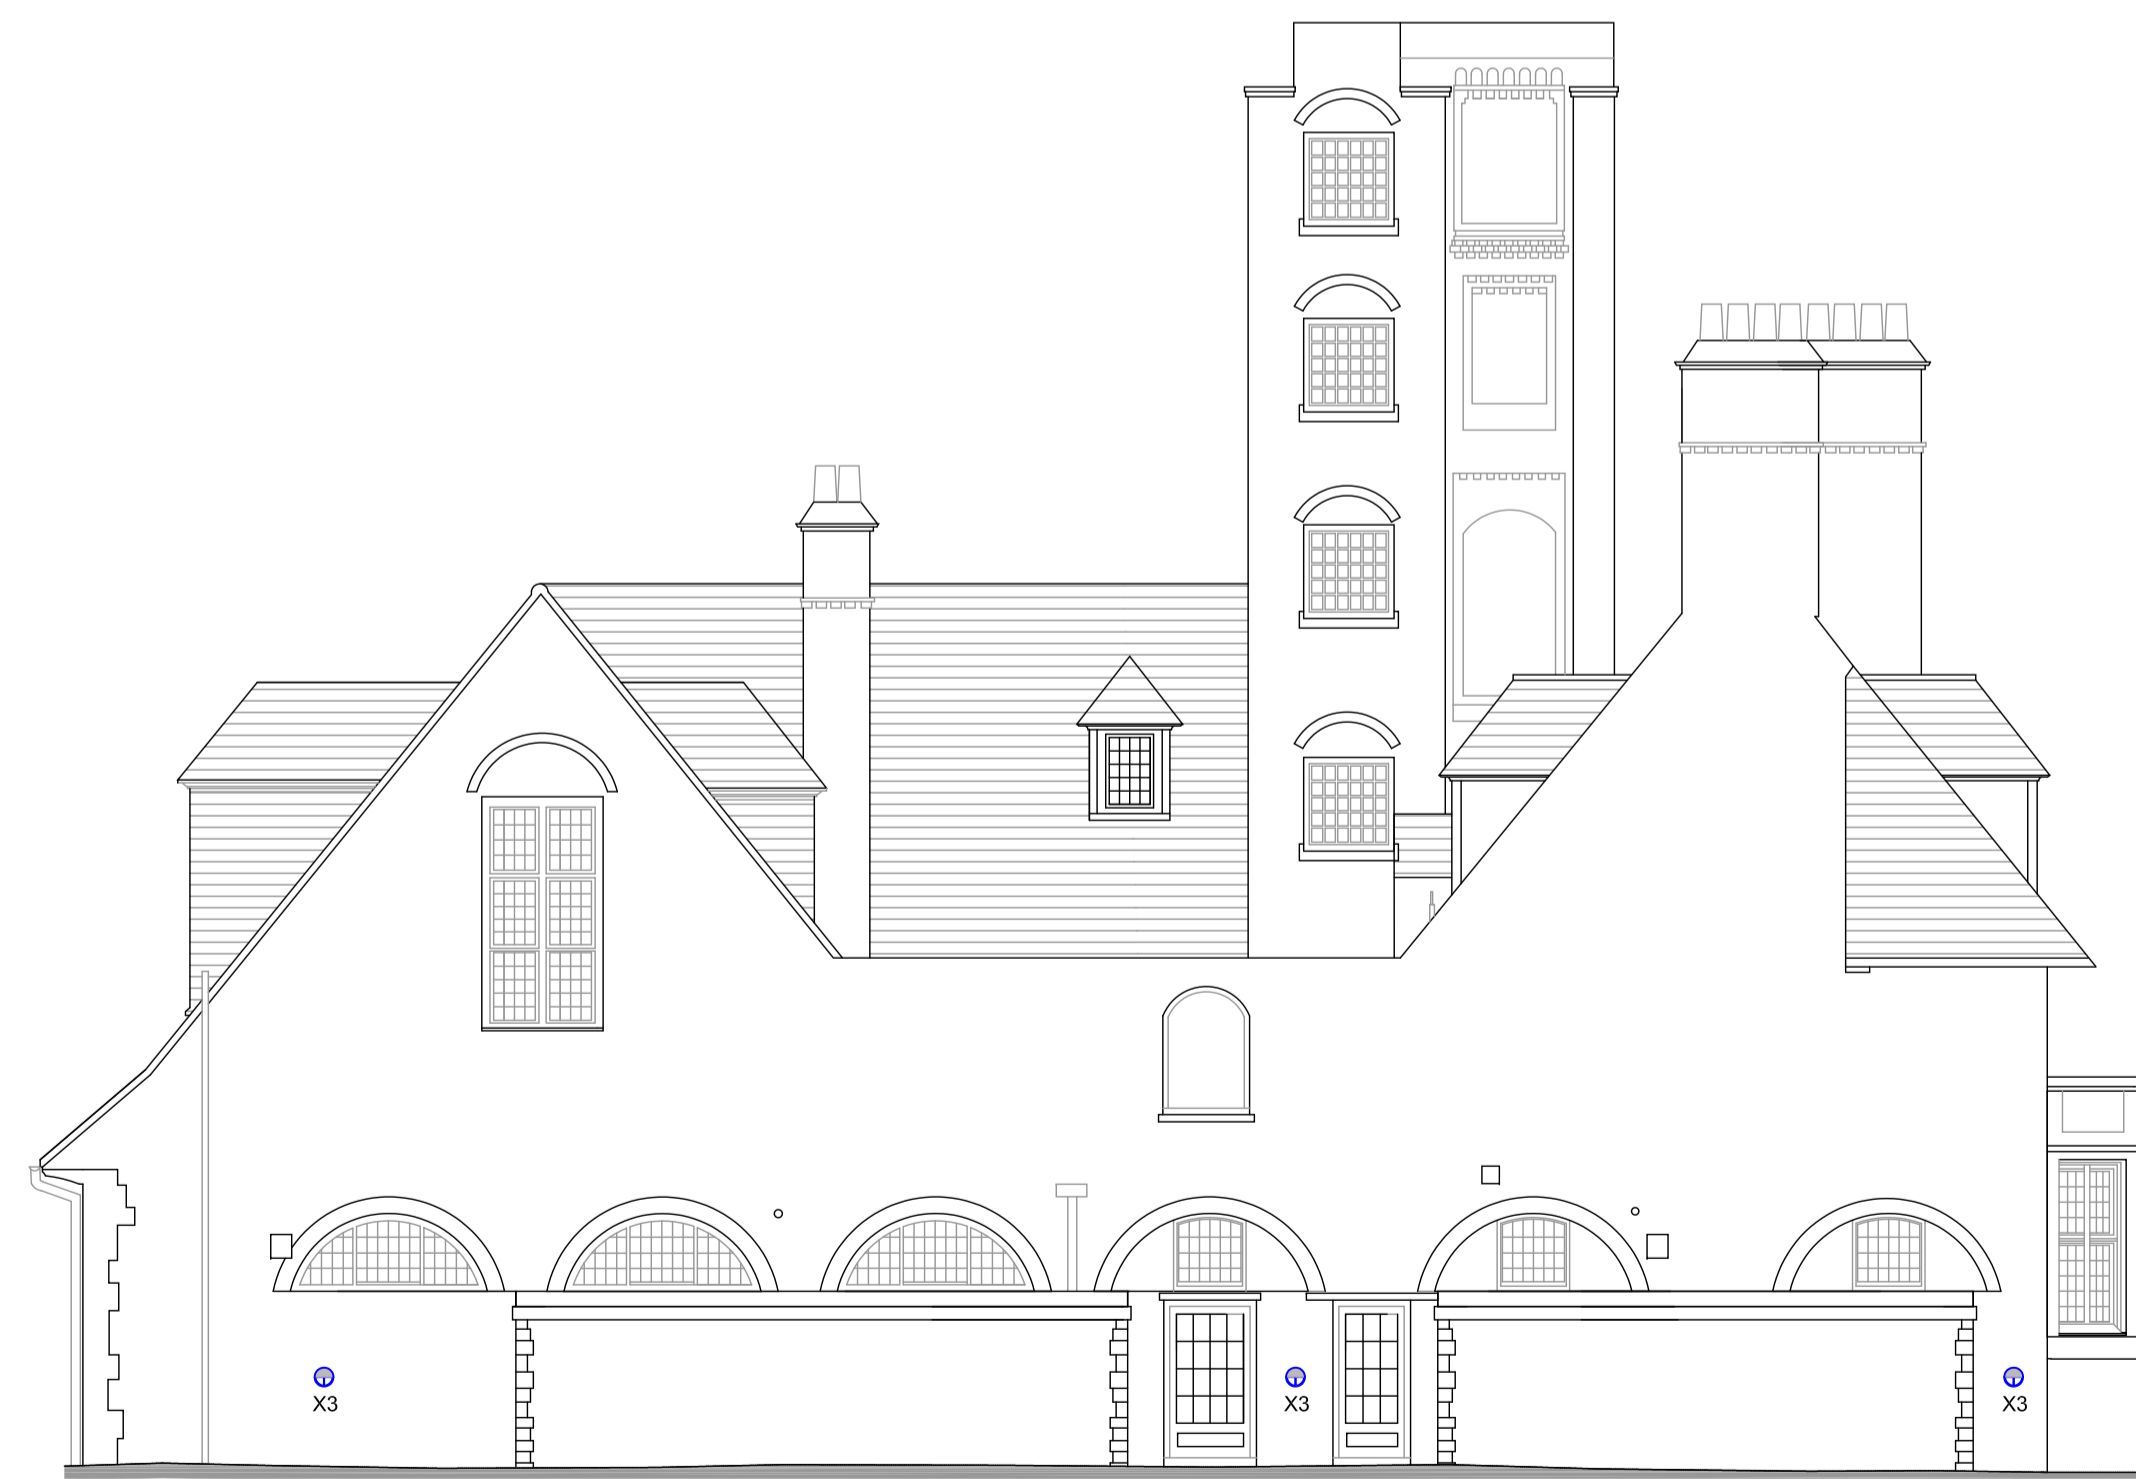

SOUTH ELEVATION
SCALE 1:100@A1



WEST ELEVATION
SCALE 1:100@A1

KEYPLAN

NOTES

1.00 ALL EXTERNAL LIGHTING TO BE CONTROLLED BY PHOTOCELL AND TIME CONTROL.
2.00 ALL EXTERNAL ELECTRICAL FIXTURES SHALL HAVE MINIMUM RATING OF IP65.


SCHEDULE OF SYMBOLS

□ X2 LUMINAIRE IP65 WALL MOUNTED LED LUMINAIRE
⊕ X3 LUMINAIRE IP65 WALL MOUNTED LED LUMINAIRE

REF 'X2' LUMINAIRE
EXTERNAL WALL MOUNTED LED 16W
4000K 1644 LUMENS CRI80 256DIA 225H



REF 'X3' LUMINAIRE
EXTERNAL WALL MOUNTED LED 11W
4000K11 LUMENS CRI80 260DIA 150D

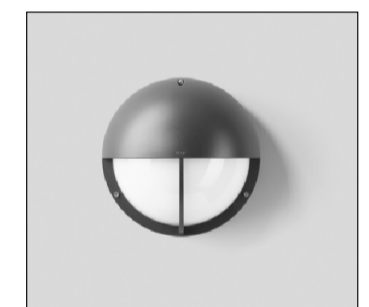

NOTE: ARCHITECTURAL DRAWING USED FOR COMPILATION OF IN2 DRAWING. ARCHITECTURAL DRAWING REVISION : P1 DATE RECEIVED : 12.01.2018

STATUS	DATE	DESCRIPTION	DRN	ENG	APP	REV
S3	17.08.2018	PRELIMINARY ISSUE	JDT	JW	BF	P3
S3	01.03.2018	PRELIMINARY ISSUE	JDT	JW	BF	P2
S3	08.02.2018	PRELIMINARY ISSUE	KO	JW	BF	P1



IN2
ENGINEERING DESIGN PARTNERSHIP
DUBLIN . ATHLONE . BELFAST . LONDON



PROJECT
BELSIZE PARK FIRESTATION

CLIENT
PLATINUM LAND

DRAWING TITLE
ELECTRICAL SERVICES INSTALLATION
SOUTH AND WEST EXTERNAL ELEVATIONS
EXTERNAL LIGHTING LAYOUT

SCALE 1:100 @ A1
1:200 @ A3

SIZE **A1**

PROJECT REF: **L18051**

DRAWING No. **L18051-IN2-00-XX-DR-E-0101**

STATUS
S3

REVISION
P3