


# PLANT AREA

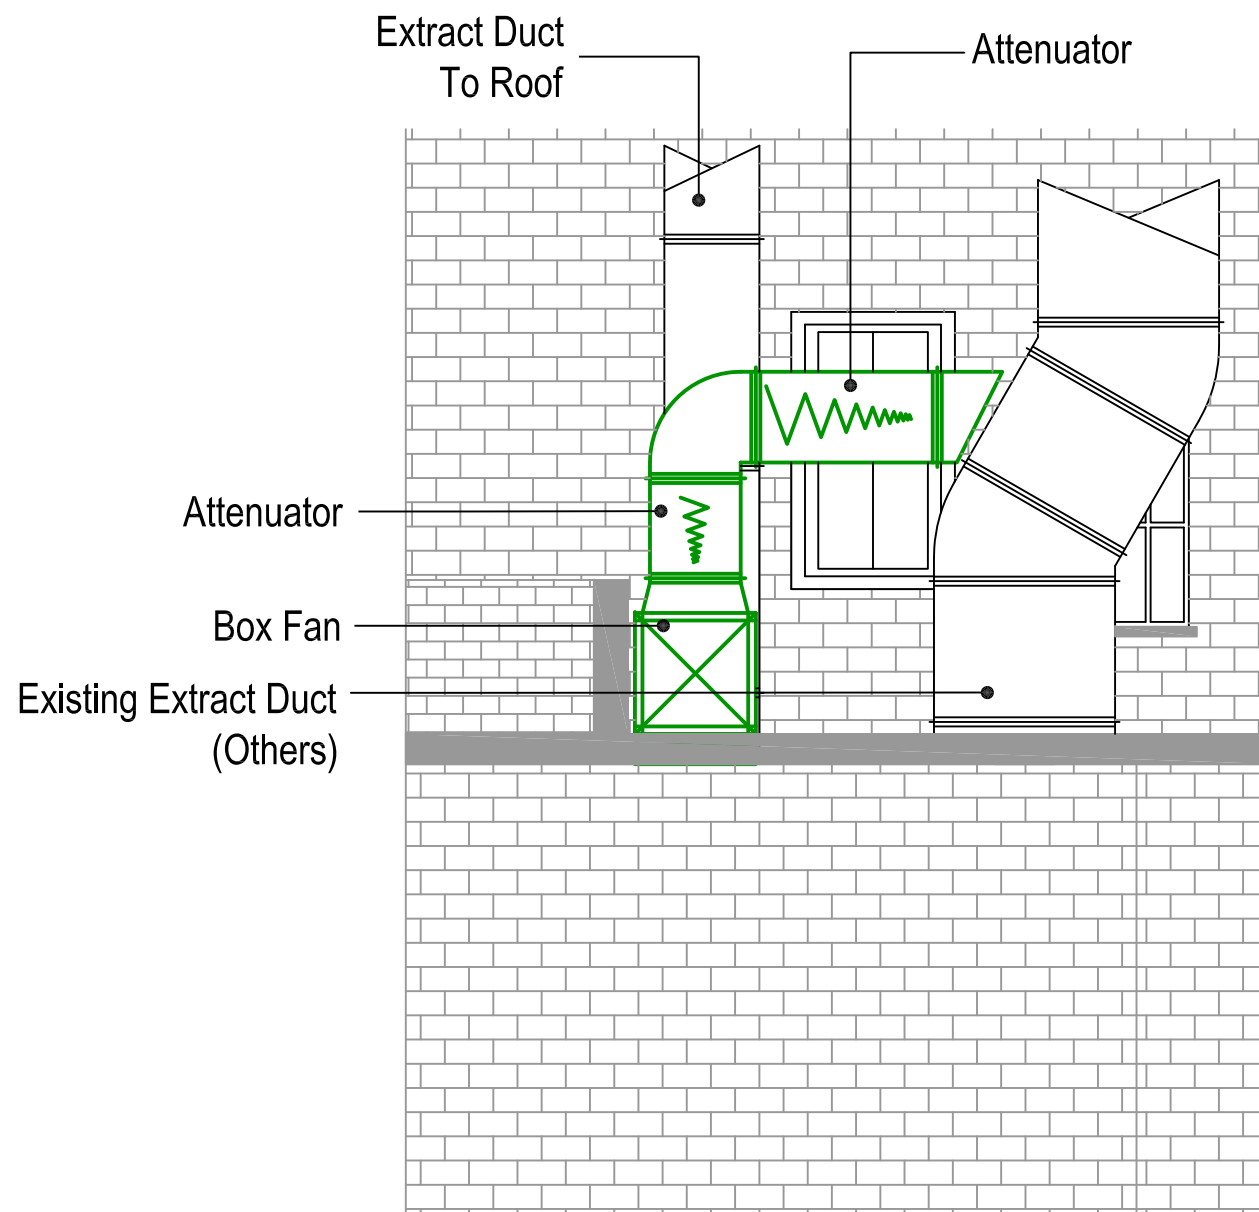

# REAR ELEVATION

No.	Date	Rev. By	Revision Description
A	27/02/19	JJ	Extract duct repositioned

Client:

**ROSA'S  
THAI CAFE**

Project :

Rosa's Thai Cafe  
Earlham Street  
London

Drawing Title :

Ventilation Layout  
Plant Deck & Elevation

Drawing No.:	Rev:
001-612-01	A

Scale: 1:50 @ A3

Drawn By: JJ Date: 26/02/19

**chapman  
ventilation**

15-20 Woodfield Road, Welwyn Garden City  
Hertfordshire AL7 1JQ  
Tel: 01707 372858 Fax: 01707 325001  
E-mail: info@chapmanventilation.co.uk  
Web: www.chapmanventilation.co.uk

Copyright of this drawing resides  
with Chapman Ventilation Limited ©

