


PLANT AREA

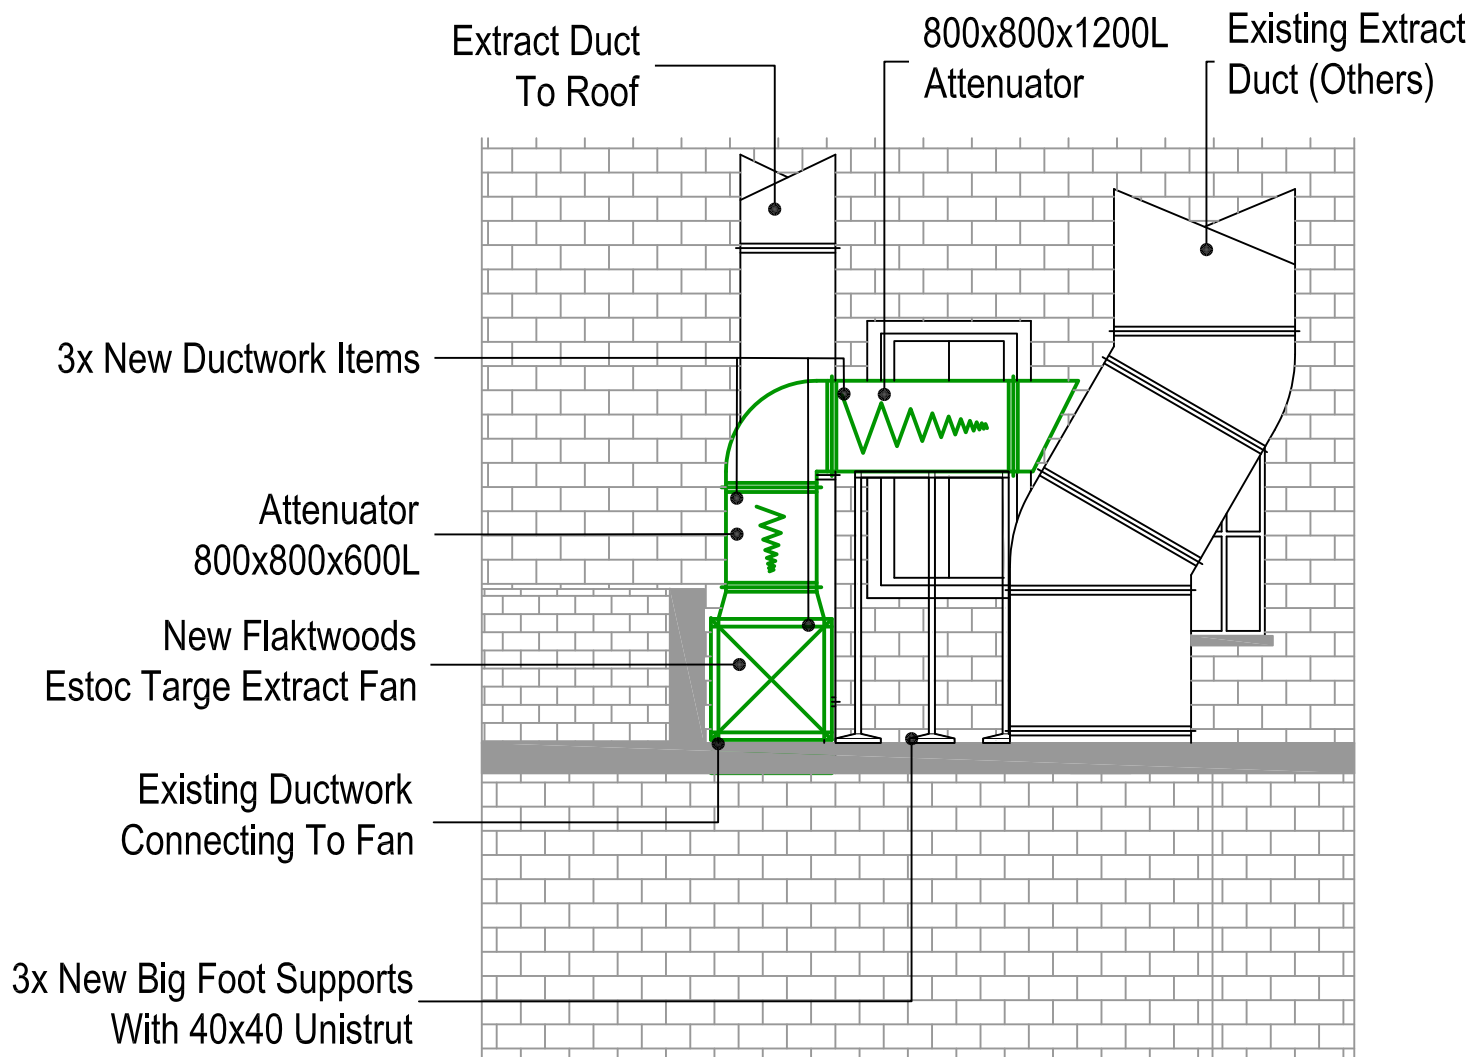

REAR ELEVATION

No.	Date	Rev. By	Revision Description
B	19/03/19	JJ	Revised Notation, Big Foot System Added
A	27/02/19	JJ	Extract duct repositioned

Client:

ROSA'S THAI CAFE

Project :

Rosa's Thai Cafe
Earlham Street
London

Drawing Title :

Proposed Ventilation Layout Plant Deck & Elevation

Drawing No.:	Rev:
001-612-01	B

Scale: 1:50 @ A3

Drawn By: JJ Date: 26/02/19

chapman ventilation

15-20 Woodfield Road, Welwyn Garden City
Hertfordshire AL7 1JQ
Tel: 01707 372858 Fax: 01707 325001
E-mail: info@chapmanventilation.co.uk
Web: www.chapmanventilation.co.uk

Copyright of this drawing resides with Chapman Ventilation Limited ©

