


| Ground Floor to Second Floor Lighting  |   |
|--|---|
|  | Wall Luminaire                                    |
|  | Pendant   |
|  | Single Point Source Luminaire (Downlight)         |
|  | Decorative Striplight above dados/to the wardrobe |
|  | Linear Fluorescent Luminaire                      |
|  | Small Floor Uplight                               |
| Fire Alarm   |   |
|  | Fire Alarm  |
|  | Heat Detector                                     |
| <p>Note: Indicative lighting design layout. MEP Engineer's to confirm lighting levels and quantities of fittings. Refer to MEP layouts for full electrical layouts</p>   |   |
| <p>General Notes:</p> <ul style="list-style-type: none"> <li>D1, D2, D3, D4, D5 and D9 electrical symbol indicates recessed spotlights.</li> <li>D7 electrical symbol indicates surface mounted spotlights.</li> </ul> |   |

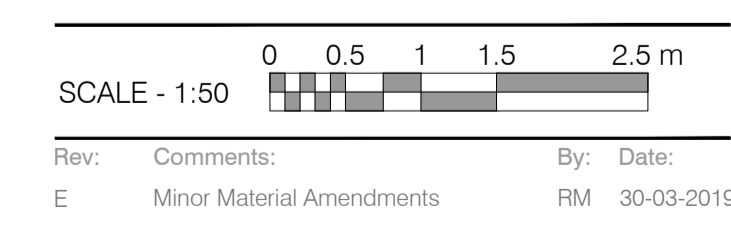

| Rev: | Comments:                 | By: | Date:      |
|------|---------------------------|-----|------------|
| E    | Minor Material Amendments | RM  | 30-03-2019 |

**PLANNING**

Client:  
-

Project Title:  
24 Heath Drive, London, NW3 7SB

Drawing Title:  
Reflected Ceiling Plan  
Second Floor

Scale: 1:50@A1    Date: JAN 18    Drawn: ST    Checked: HV

**kyson**  
Studio

28 Scrutton Street  
London  
UK  
EC2A 4RP

T: +44(0) 20 7247 2462  
E: enquiries@kyson.co.uk  
W: www.kyson.co.uk

Do not scale this drawing. All dimensions must be checked on site. All rights reserved. No reproduction in any material form is permitted without consent.

| Project No.: | Drawing No.: | Revision: |
|--------------|--------------|-----------|
| 508-16       | 2102         | E         |