




SECOND FLOOR

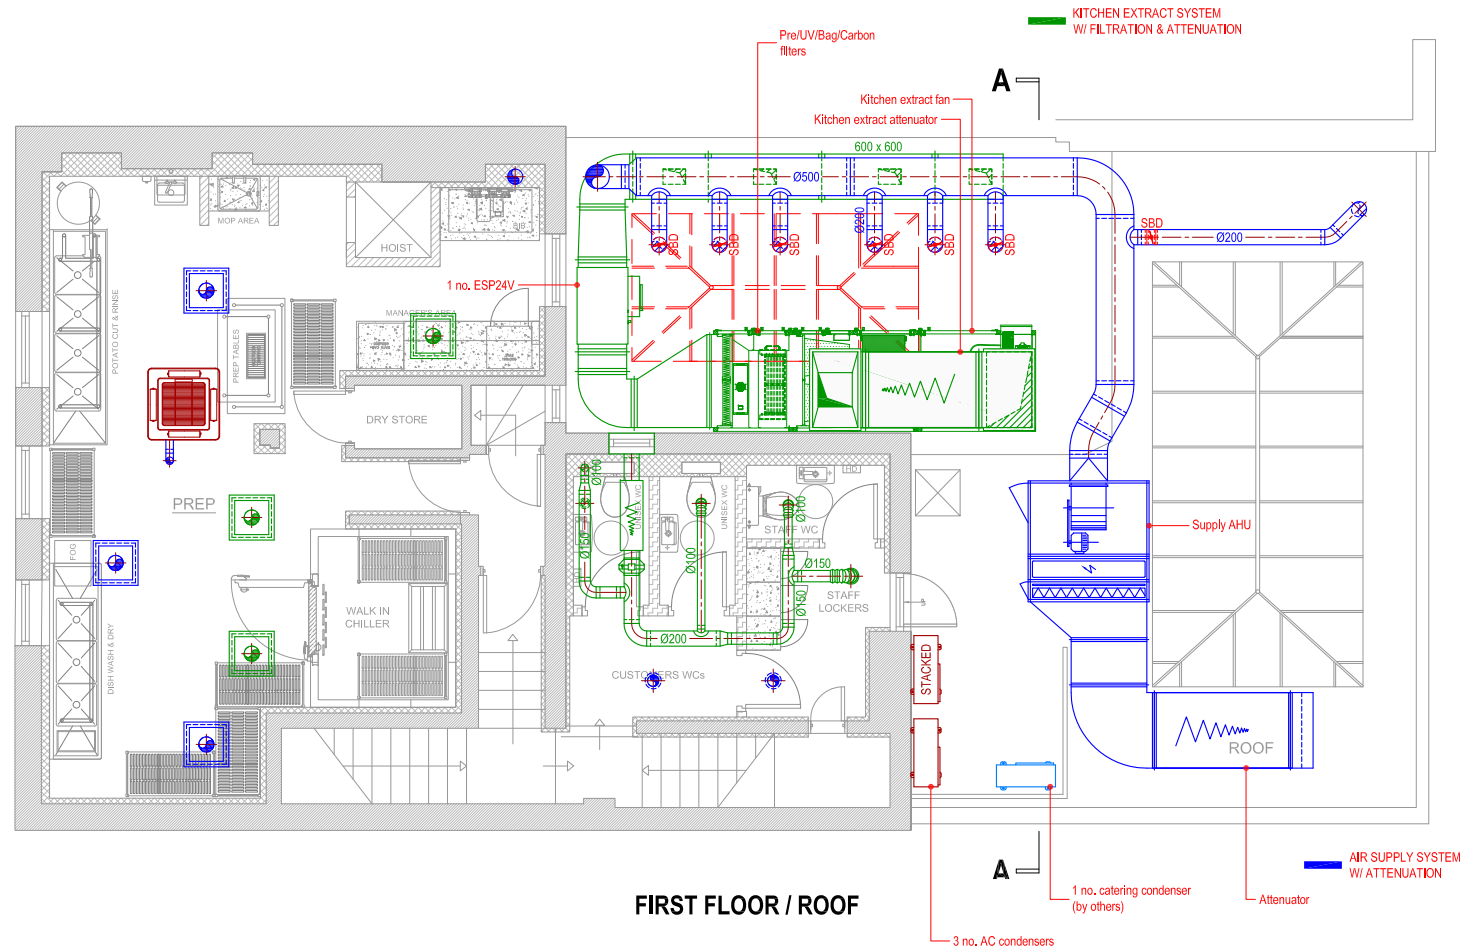

FIRST FLOOR / ROOF

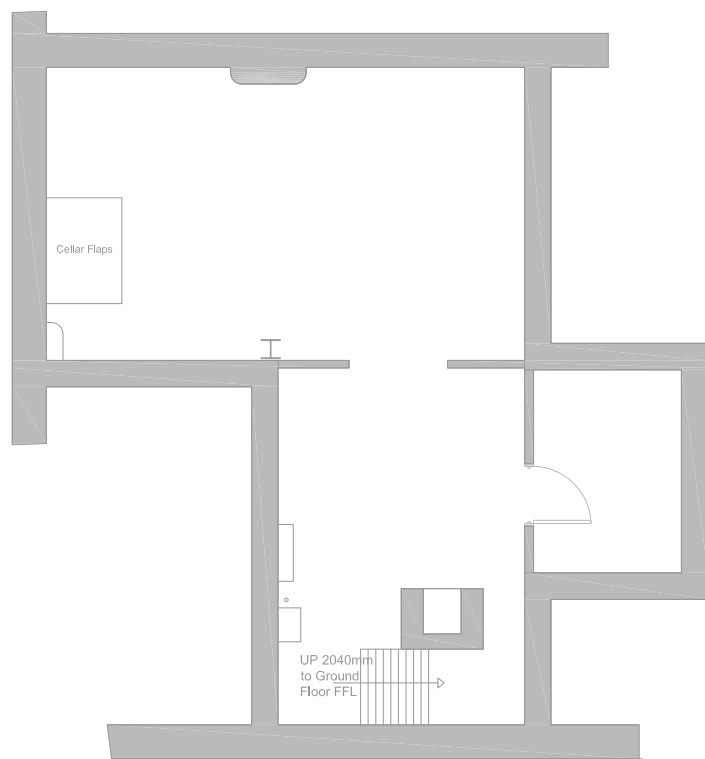

BASEMENT

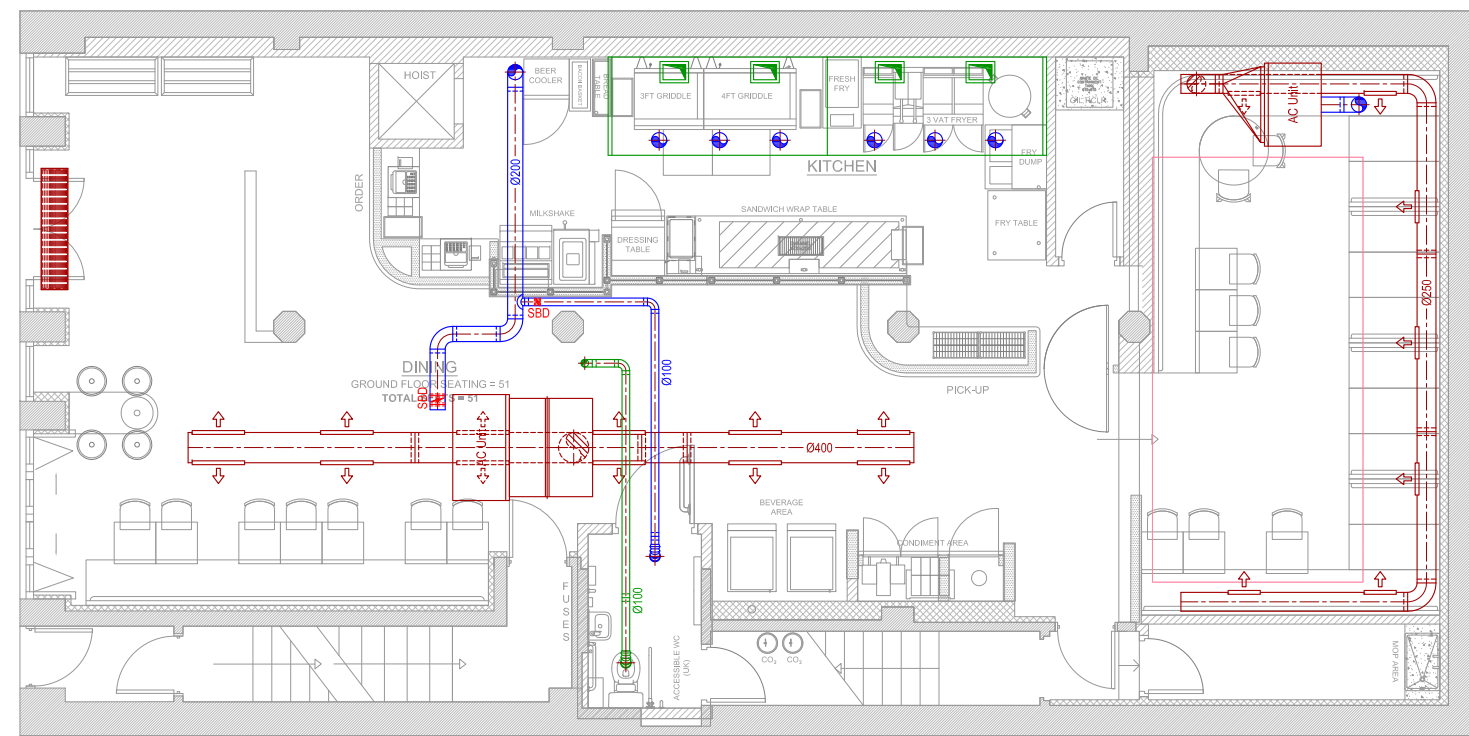

GROUND FLOOR

C	22-01-19	RL	Amendments to ducts.
B	21-01-19	RL	Amendments to plant.
A	12-12-18	RL	Amendments to plant.

No.	Date	Rev. By	Revision Description
-----	------	---------	----------------------

Project :

32 Parkway
Camden Town
London
NW1 7AH

Drawing Title :
Proposed Ventilation Layout
Basement, Ground, First
& Second Floor

Drawing No:	Rev:
016-166-11	C

Scale: 1:50 @ A1 1:100 @ A3

Drawn By: RL Date: 05-12-18

chapman ventilation

15-20 Woodfield Road, Welwyn Garden City
Hertfordshire AL7 1JQ
Tel: 01707 372658 Fax: 01707 325001
E-mail: info@chapmanventilation.co.uk
Web: www.chapmanventilation.co.uk

Copyright of this drawing resides with Chapman Ventilation Limited ©

