


FOR CONTINUATION REFER TO DRAWING No. P5-DES-001-00-DR-E-1003

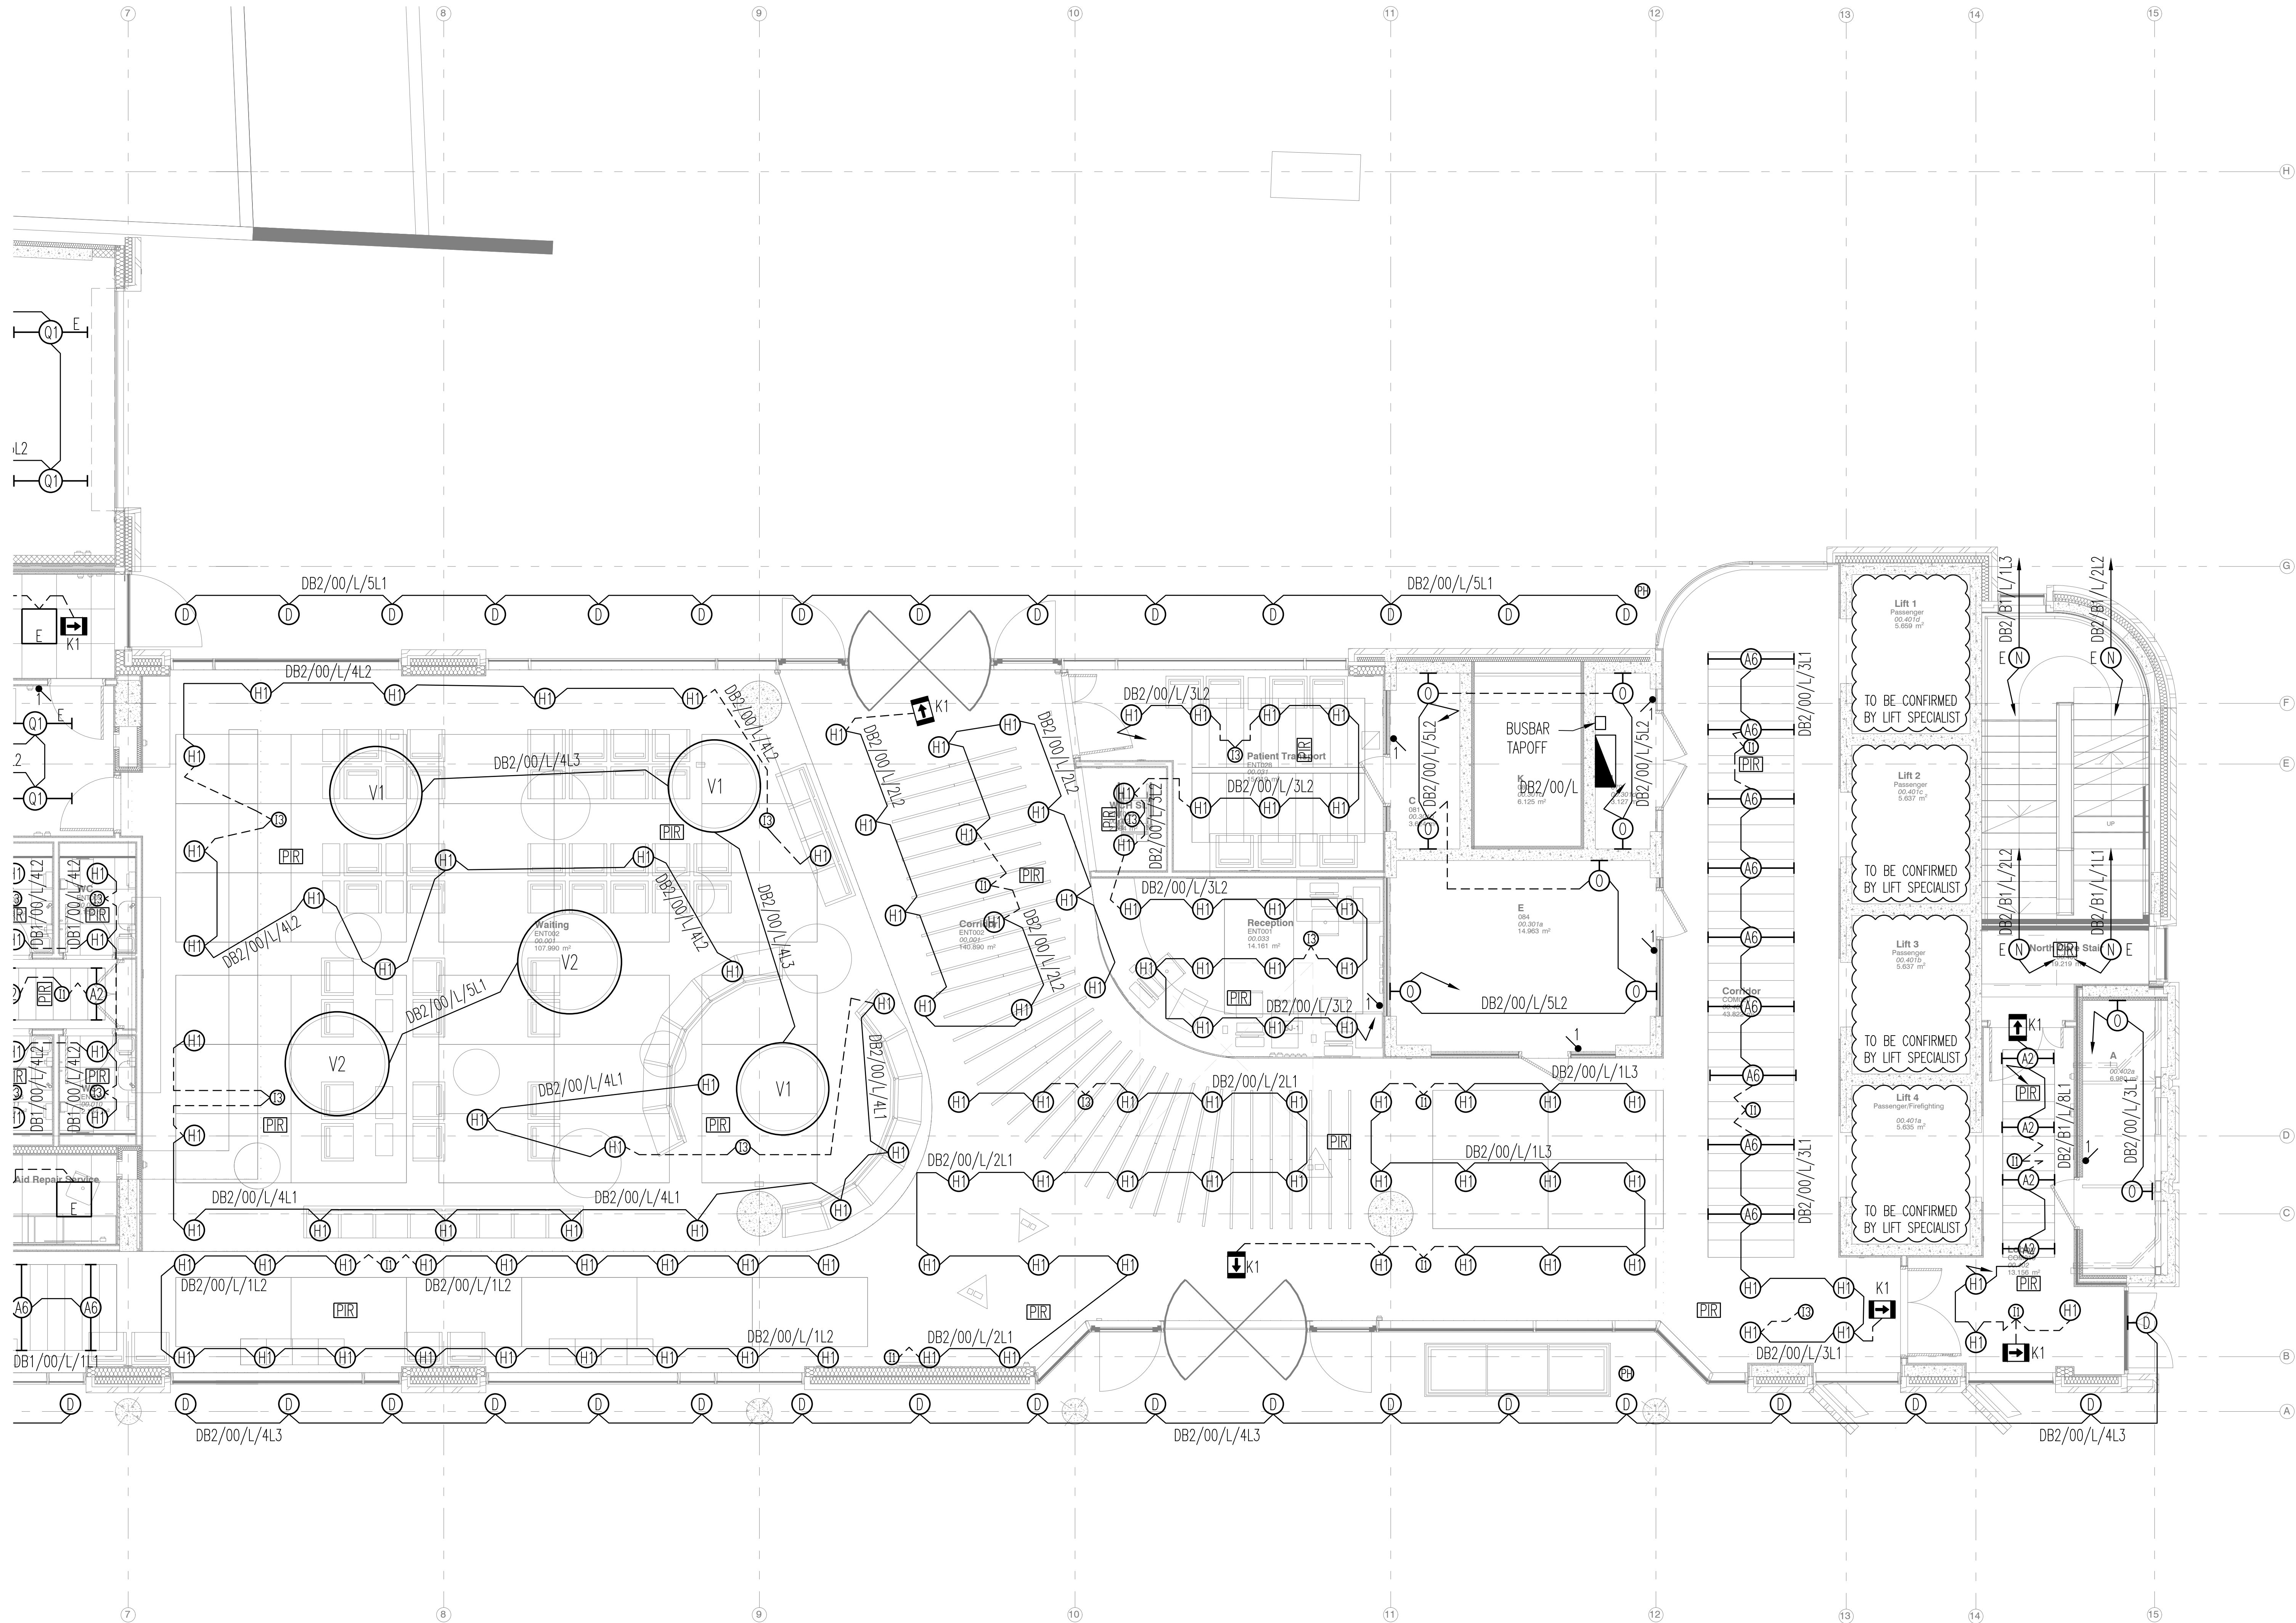

This drawing is the property of Dornan Engineering Ltd. Copyright is reserved by Dornan Engineering Ltd. and the drawing shall not be copied, reproduced or otherwise used without the consent of Dornan Engineering Ltd.

NOTES

1. THIS DRAWING IS TO BE READ IN CONJUNCTION WITH ALL OTHER DRAWINGS, SPECIFICATIONS AND SCOPE OF WORKS.
2. THIS DRAWING IS TO BE READ FOR SERVICES INFORMATION ONLY.
3. ALL SIZES ARE IN MM.
4. DO NOT SCALE FROM THIS DRAWING. ALL DIMENSIONS TO BE VERIFIED FROM SITE MEASUREMENT PRIOR TO COMMENCING WORKS.
5. REFER TO LEGEND DRAWING No. P5-DES-000-XX-DR-E-0001.
6. ALL DETAILS TO BE CONFIRMED.
7. FINAL LOCATIONS AND QUANTITY OF ILLUMINATED EMERGENCY EXIT SIGNS TO BE AGREED WITH BCO.
8. REFER TO SEPARATE TECHNICAL SUBMISSION FOR LIGHTING CONTROL PHILOSOPHY.
9. REFER TO ARCHITECT'S C-SHEETS FOR POSITIONS OF LIGHT SWITCHES AND ILLUMINATED ROOM SIGNS IN CORRIDORS.

LEGEND

REFERENCE DRAWINGS

P01	PRELIMINARY ISSUE	DEC 2017	M.A.
REV	DESCRIPTION	DATE	BY



CLIENT



PROJECT

UCLH - PHASE 5

TITLE

ELECTRICAL SERVICES
GROUND FLOOR - NORTH
LIGHTING LAYOUT

SAFETY, HEALTH AND ENVIRONMENTAL INFORMATION			
READERS OF THE DRAWING: ALL EXPERTS HAVE BEEN TAKEN BY DORNAN TO DESIGN OUT SIGNIFICANT HAZARDS WITHIN THE DESIGN AND CONSTRUCTION PHASES. IT IS OUR OPINION THAT THE HAZARDS IDENTIFIED BELOW CANNOT BE DESIGNED OUT BY US GIVEN THE CONSTRAINTS OF THE BRIEF AND ARE HIGHLIGHTED AS THAT OTHER MEANS CAN BE DEVELOPED TO MITIGATE THE RESIDUAL RISKS IDENTIFIED.			
NO SIGNIFICANT HAZARDS ASSOCIATED WITH THIS DRAWING			
DISCIPLINE ELECTRICAL			
STATUS Approval			
DRAWN BY M.A.	CHECKED BY A.D.	SIZE A0	
JOB No. P5	SCALE 1:100	DATE DEC 2017	
DRAWING No. P5-DES-001-00-DR-E-1004	REV P01		

IT IS ASSUMED THAT A COMPETENT MACE CONTRACTOR OR USER WILL BE AWARE OF THE STANDARD FORESEEABLE RISKS ASSOCIATED WITH WORKING WITH THE TYPE OF