


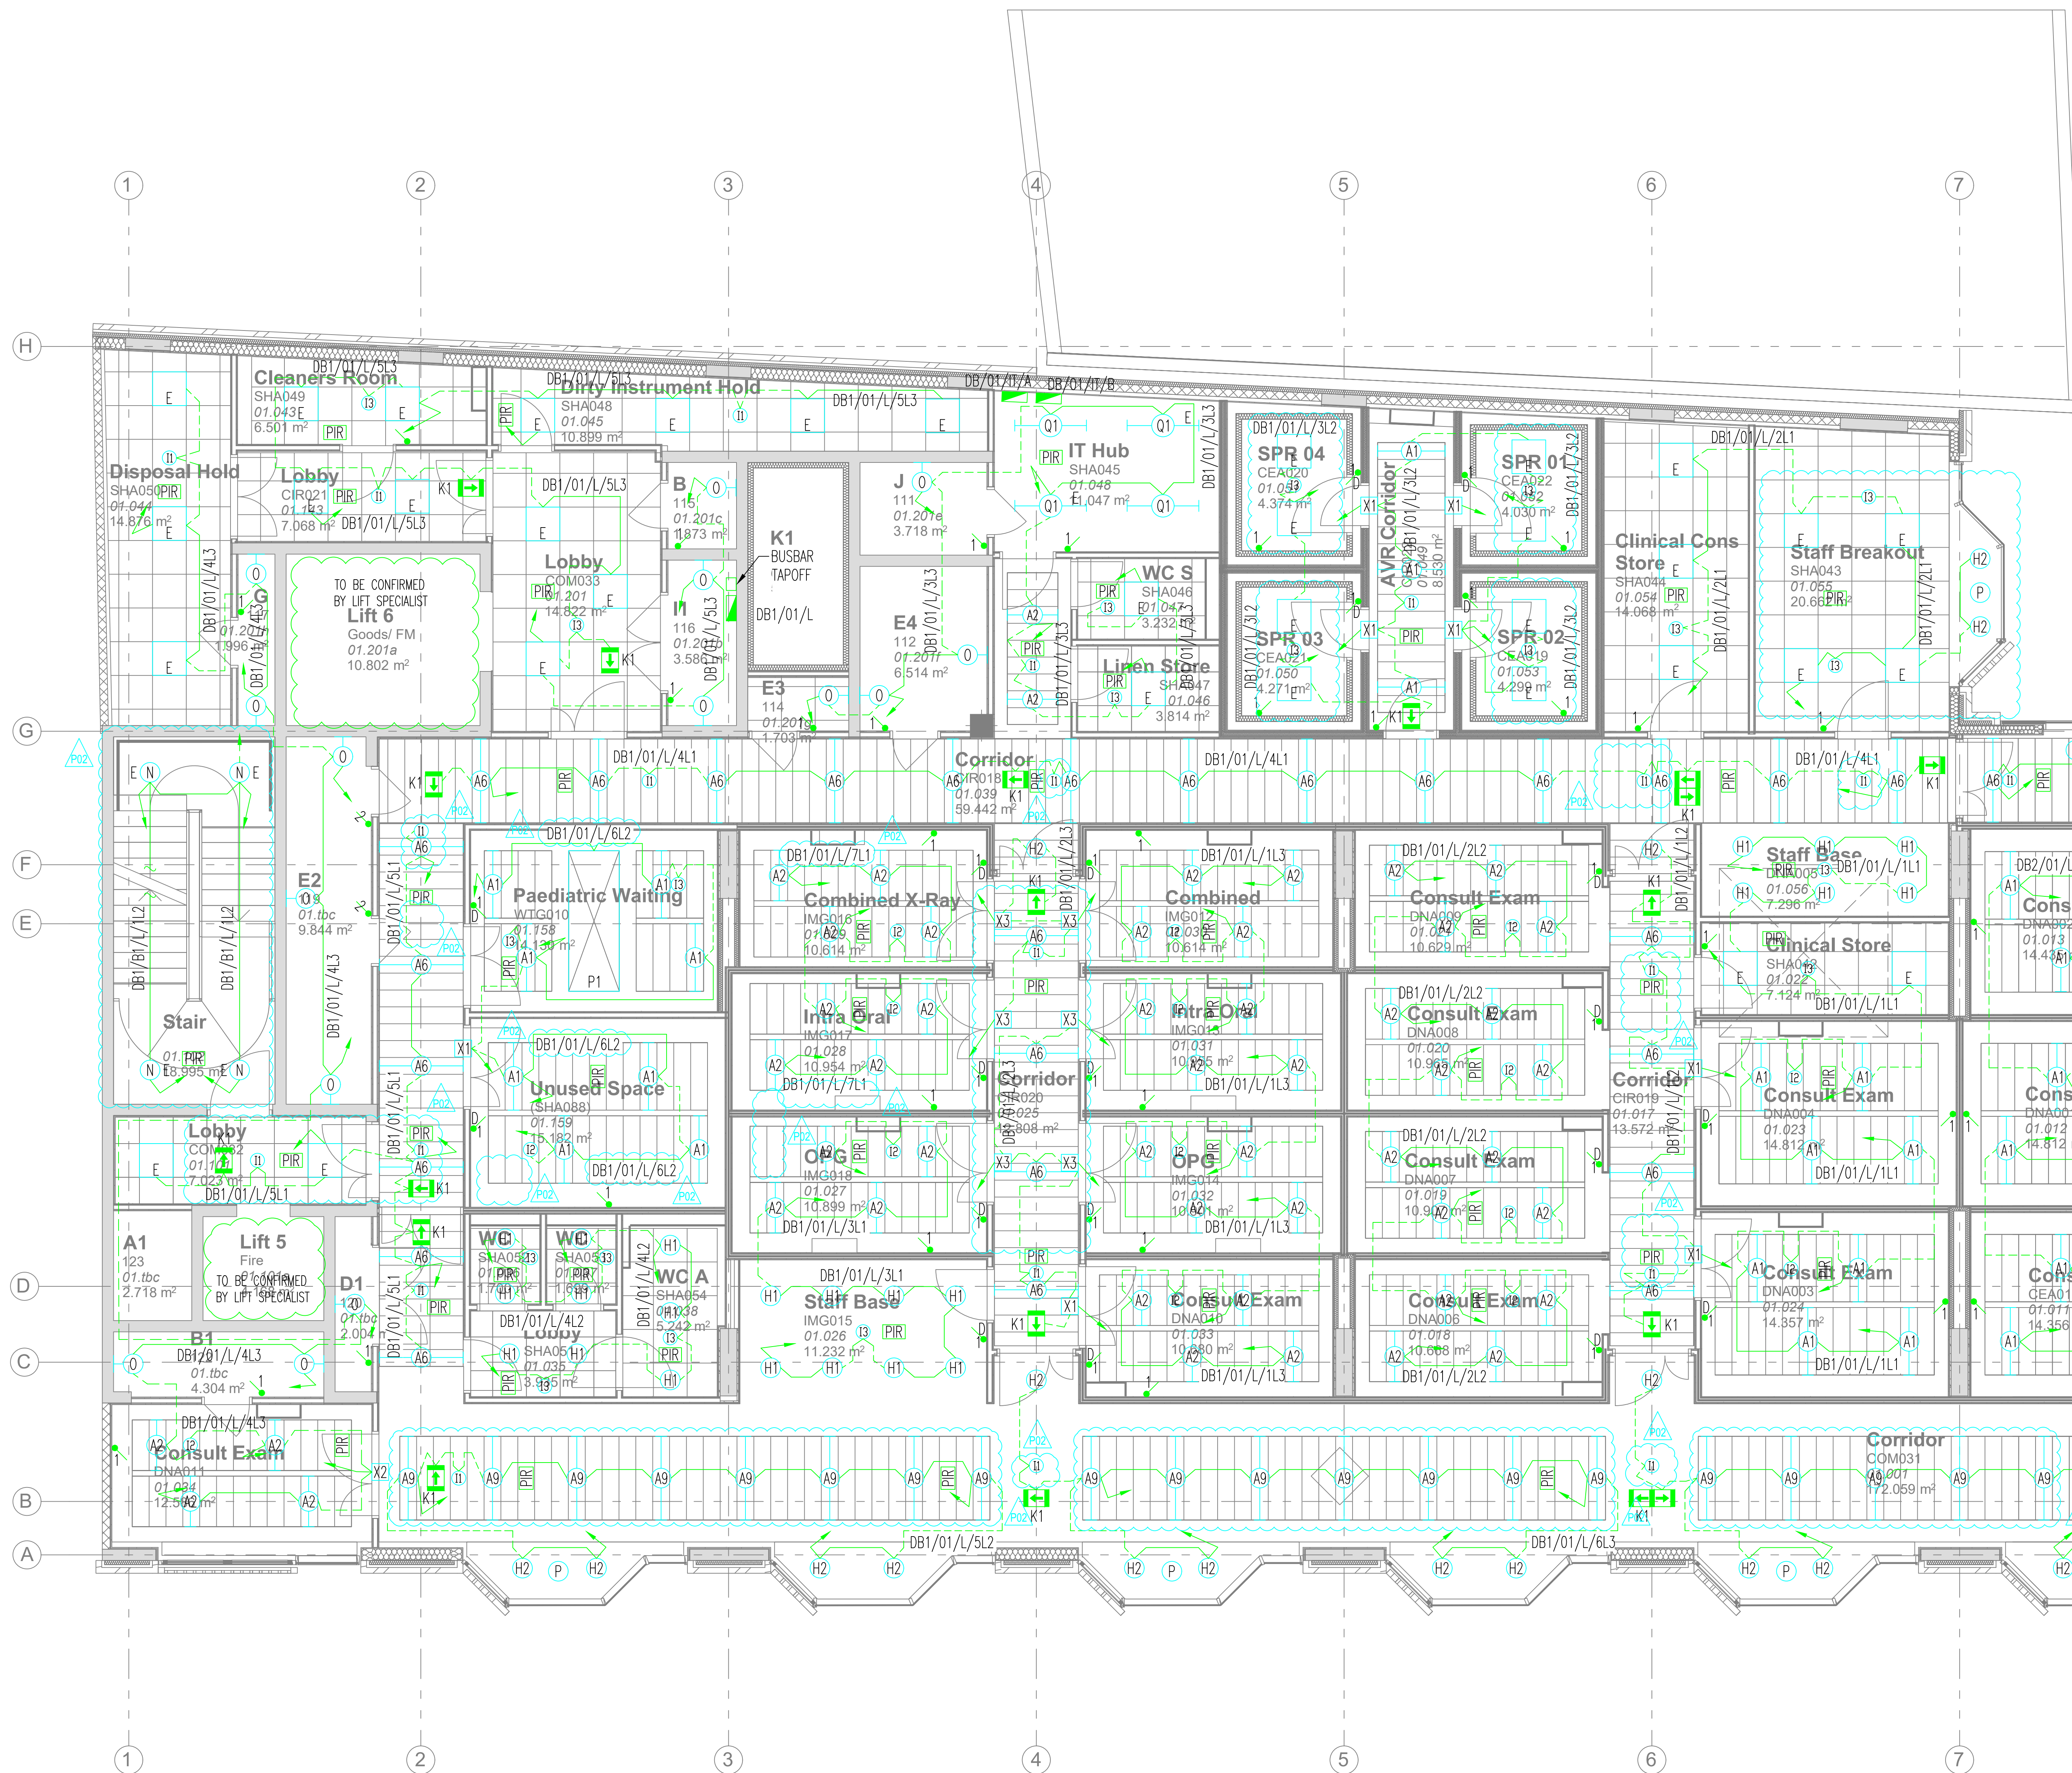

FOR CONTINUATION REFER TO DRAWING No. P5-DES-001-01-DR-E-1004

This drawing is the property of Dornan Engineering Ltd. Copyright is reserved by Dornan Engineering Ltd. and the drawing shall not be copied, reproduced or otherwise used without the consent of Dornan Engineering Ltd.

NOTES

- THIS DRAWING IS TO BE READ IN CONJUNCTION WITH ALL OTHER DRAWINGS, SPECIFICATIONS AND SCOPE OF WORKS.
- THIS DRAWING IS TO BE READ FOR SERVICES INFORMATION ONLY.
- ALL SIZES ARE IN MM.
- DO NOT SCALE FROM THIS DRAWING. ALL DIMENSIONS TO BE VERIFIED FROM SITE MEASUREMENT PRIOR TO COMMENCING WORKS.
- REFER TO LEGEND DRAWING No. P5-DES-000-XV-DR-E-0001.
- ALL DETAILS TO BE CONFIRMED.
- FINAL LOCATIONS AND QUANTITY OF ILLUMINATED EMERGENCY EXIT SIGNS TO BE AGREED WITH BCO.
- REFER TO SEPARATE TECHNICAL SUBMISSION FOR LIGHTING CONTROL PHILOSOPHY.
- REFER TO ARCHITECT'S C-SHEETS FOR POSITIONS OF LIGHT SWITCHES AND ILLUMINATED ROOM SIGNS IN CORRIDORS.
- DUEL SUPPLIES TO CLINICAL SPACES OMITTED AS PER AGREED VE.

LEGEND

REFERENCE DRAWINGS

P02	PRELIMINARY ISSUE - COMMENTS INCORPORATED.	NOV 2018	Y.L.
P01	PRELIMINARY ISSUE	DEC 2017	M.A.
REV	DESCRIPTION	DATE	BY

DORNAN

CLIENT

mace

PROJECT

UCLH - PHASE 5

TITLE

ELECTRICAL SERVICES
FIRST FLOOR - SOUTH
LIGHTING LAYOUT

DISCIPLINE

ELECTRICAL

STATUS

APPROVAL

DRAWN BY	CHECKED BY	SIZE
M.A.	A.D.	A0
JOB No.	SCALE	DATE
P5	1:50	26/04/2018
DRAWING No.	REV	
P5-DES-001-01-DR-E-1003	P02	

SAFETY, HEALTH AND ENVIRONMENTAL INFORMATION

READERS OF THIS DRAWING:

ALL EFFORTS HAVE BEEN TAKEN BY DORNAN TO DESIGN OUT SIGNIFICANT HAZARDS WITHIN THE DESIGN RISK ASSESSMENT PROCESS. IT IS OUR OPINION THAT THE HAZARDS DETAILLED BELOW CANNOT BE DESIGNED OUT BY US GIVEN THE CONSTRAINTS OF THE BRIEF AND ARE HIGHLIGHTED SO THAT OTHER MEANS CAN BE DEVELOPED TO MITIGATE THE RESIDUAL RISK IDENTIFIED.

NO SIGNIFICANT HAZARDS ASSOCIATED WITH THIS DRAWING

IT IS ASSUMED THAT A COMPETENT MACE CONTRACTOR OR USER WILL BE AWARE OF THE STANDARD FORESEEABLE RISKS ASSOCIATED WITH WORKING WITH THE TYPE OF SERVICES DETAILED WITHIN THIS DRAWING.