

Details and example images of recessed flush fit Trickle Vent for timber windows



Details of Trickle Vent on timber windows




Silent intermittent bathroom fan with two speeds selectable at installation (internall on wall)



Stainless Steel Wall Shutter - Gravity Draught Excluder Flap Grille Duct Outlet for Bathroom and Kitchen extractors - 100mm diameter



Cooker Hood with external extraction

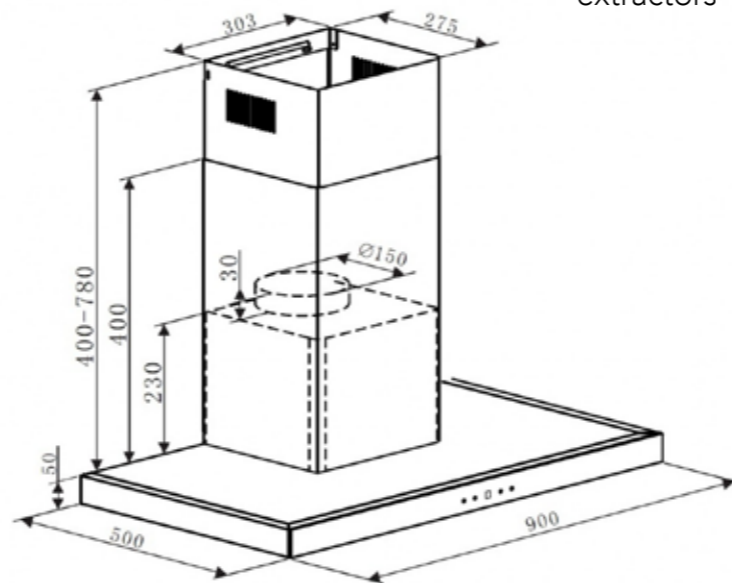

revision	date	amendment
----------	------	-----------

drawing name
Ventilation Details

project
Kentish Town

site address
387 Kentish Town Road,
London, NW5 2TJ

status For planning

scale NTS

date	drawing number	revision
10/04/19	KT_PL_V07	