

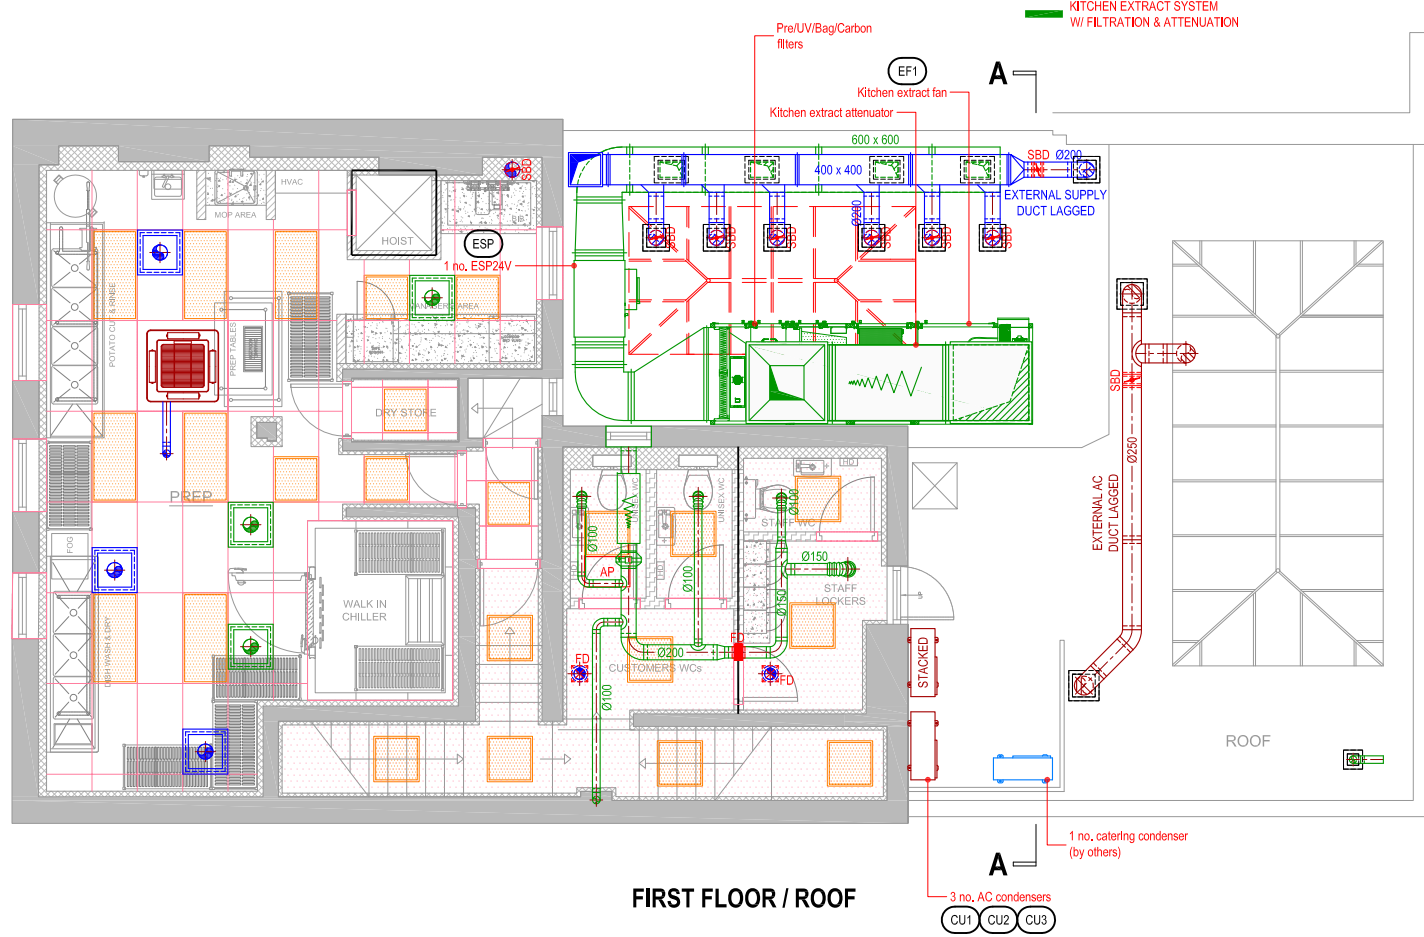



SECOND FLOOR

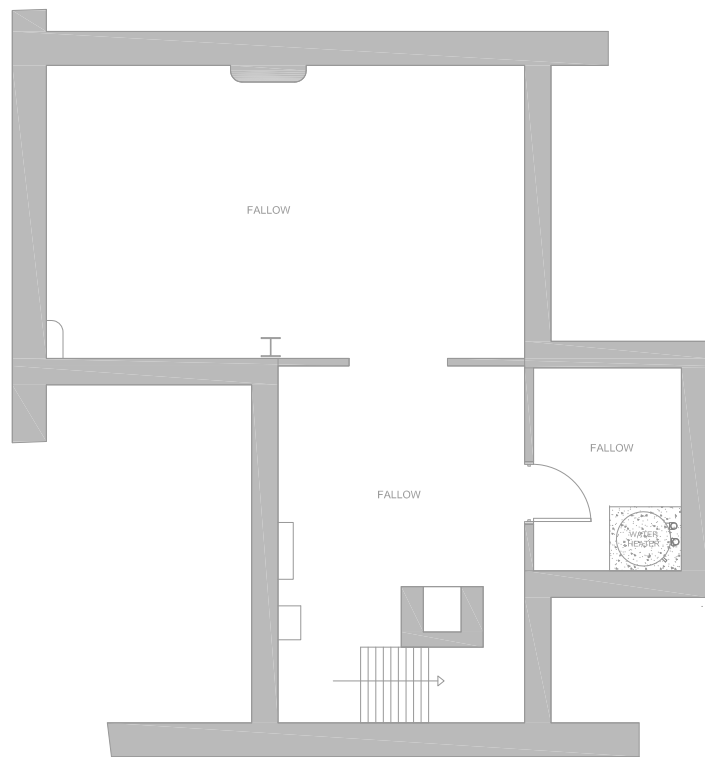

FIRST FLOOR / ROOF

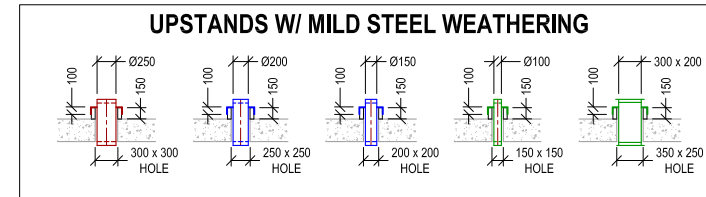

BASEMENT

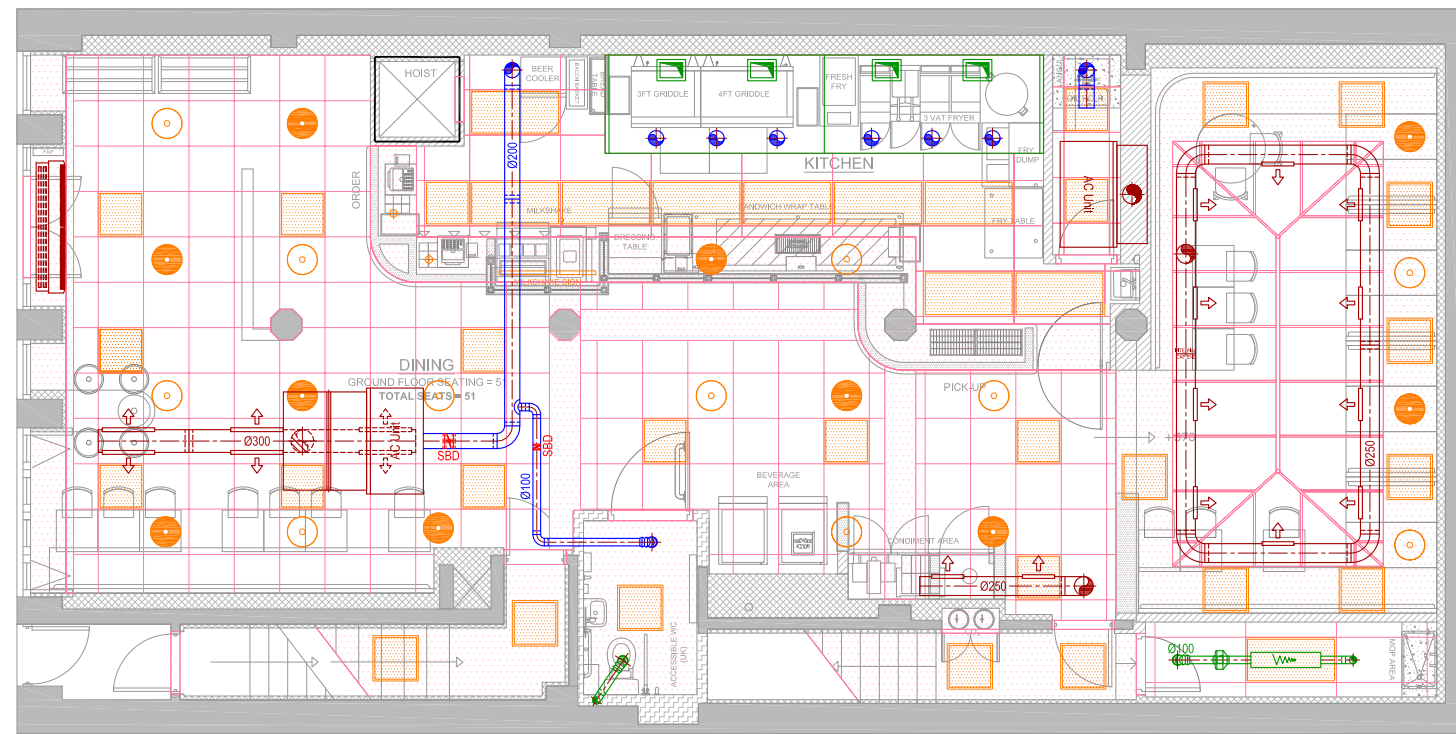

GROUND FLOOR

H	14-03-19	RL	Revised GA, Amendments to suit.
G	21-02-19	RL	Additional comments added.
F	18-02-19	RL	Revised GA, Amendments to suit.
E	07-02-19	RL	Amendments to ducts.
D	05-02-19	RL	Amendments to ducts.
C	22-01-19	RL	Amendments to ducts.
B	21-01-19	RL	Amendments to plant.
A	12-12-18	RL	Amendments to plant.

No.	Date	Rev. By	Revision Description
-----	------	---------	----------------------

Project :

32 Parkway  
Camden Town  
London  
NW1 7AH

Drawing Title :  
Proposed Ventilation Layout  
Basement, Ground, First  
& Second Floor

Drawing No: 016-166-11 Rev: H

Scale: 1:50 @ A1 1:100 @ A3  
Drawn By: RL Date: 05-12-18

**chapman ventilation**  
15-20 Woodfield Road, Welwyn Garden City  
Hertfordshire AL7 1JQ  
Tel: 01707 372658 Fax: 01707 325001  
E-mail: info@chapmanventilation.co.uk  
Web: www.chapmanventilation.co.uk

Copyright of this drawing resides with Chapman Ventilation Limited ©