


SERVICES LEVEL NOTE
 THE LEVELS GIVEN ON THIS DRAWING ARE MEASURED FROM
 FINISHED FLOOR LEVEL 96.448 TO THE CENTRELINE OF
 PIPEWORK AND CIRCULAR DUCTWORK AND TO THE
 UNDERSIDE OF ELECTRICAL CONTAINMENT. RECTANGULAR
 DUCTWORK & DRAINAGE PIPEWORK, UNLESS OTHERWISE
 STATED.

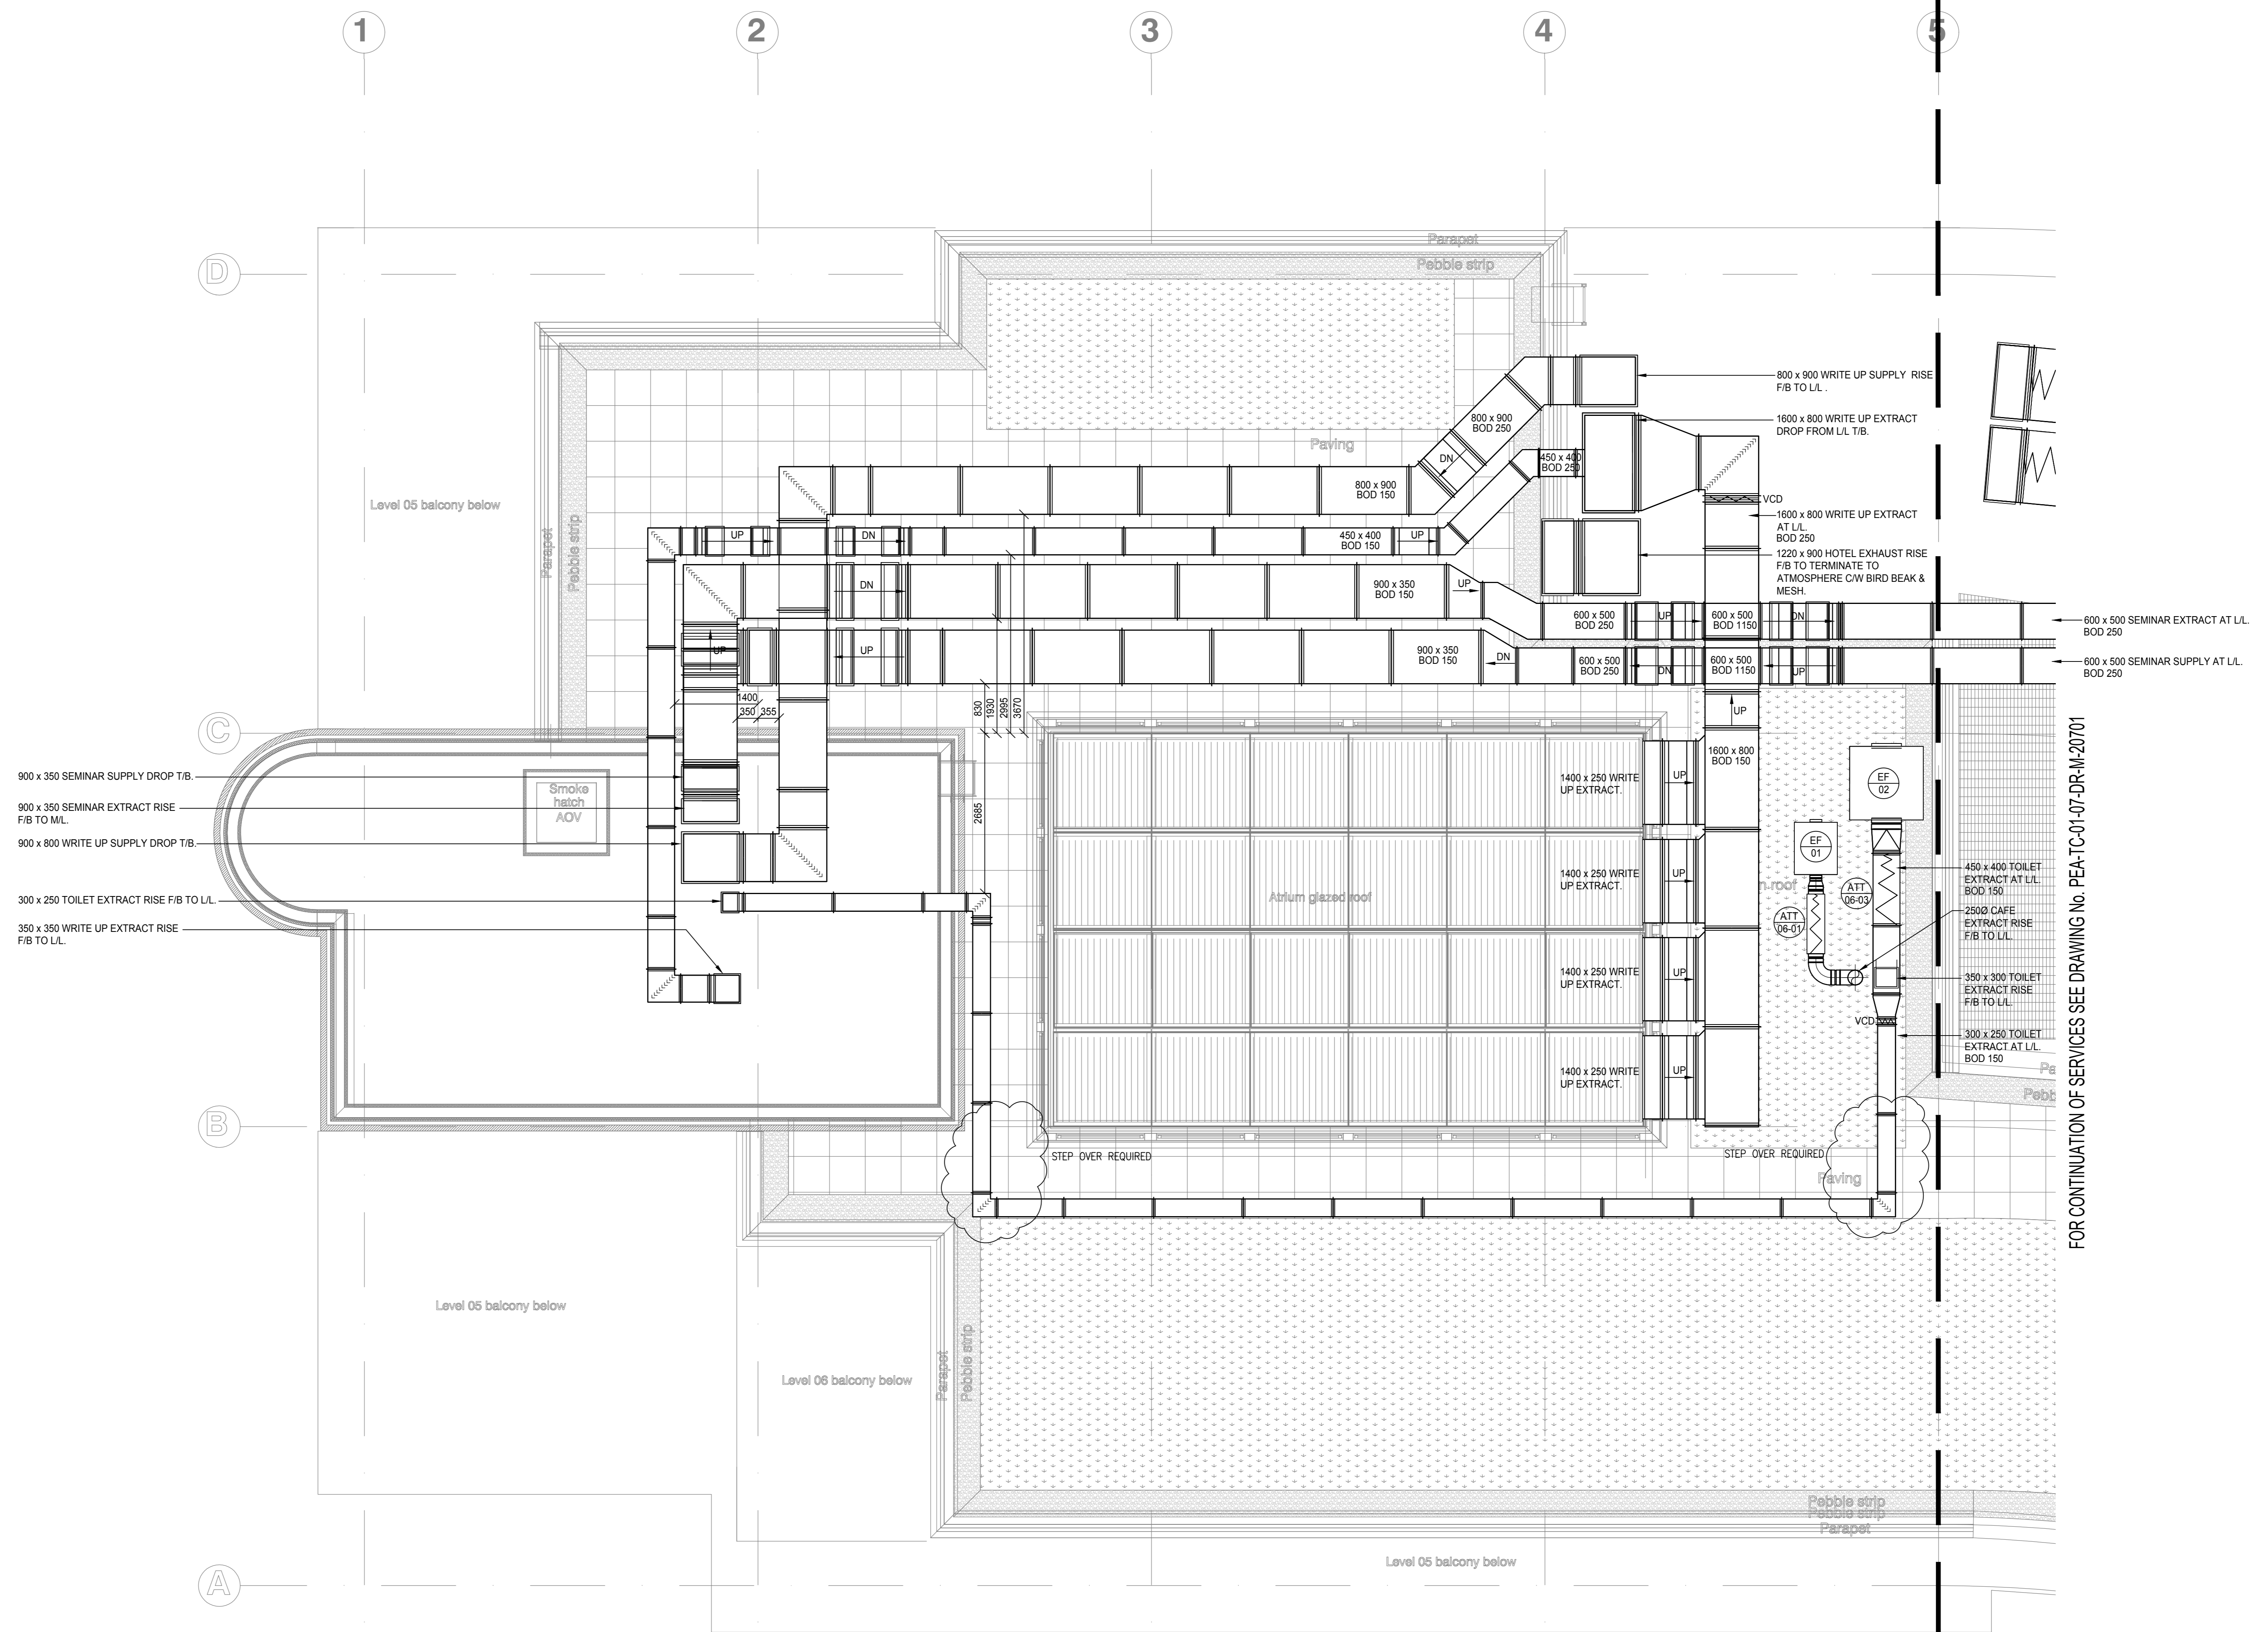

900 x 350 SEMINAR SUPPLY DROP T/B.
 900 x 350 SEMINAR EXTRACT RISE
 F/B TO M/L.
 900 x 800 WRITE UP SUPPLY DROP T/B.
 300 x 250 TOILET EXTRACT RISE F/B TO L/L.
 350 x 350 WRITE UP EXTRACT RISE
 F/B TO L/L.

800 x 800 WRITE UP SUPPLY RISE
 F/B TO L/L.
 1600 x 800 WRITE UP EXTRACT
 DROP FROM L/L T/B.
 VCD
 1600 x 800 WRITE UP EXTRACT
 AT L/L
 BOD 250
 1220 x 900 HOTEL EXHAUST RISE
 F/B TO TERMINATE TO
 ATMOSPHERE CW BIRD BEAK &
 MESH.
 600 x 500 SEMINAR EXTRACT AT L/L
 BOD 250
 600 x 500 SEMINAR SUPPLY AT L/L
 BOD 250

450 x 400 TOILET
 EXTRACT AT L/L
 BOD 150
 2500 CAFETERIA
 EXTRACT RISE
 F/B TO L/L
 300 x 300 TOILET
 EXTRACT RISE
 F/B TO L/L
 300 x 250 TOILET
 EXTRACT AT L/L
 BOD 150

FOR CONTINUATION OF SERVICES SEE DRAWING No. PEA-TC-01-07-DR-M-20701

ARCHITECTS REFERENCE NOTE
 THIS LAYOUT WAS PRODUCED USING
 ARCHITECTS DRAWING NUMBER
 AL10707 REV F3

REV	DATE	DESCRIPTION	MRG	JC	APP'D
001	10/07/2018	PRELIMINARY ISSUE			

PRELIMINARY

Job Title
**PEARS BUILDING
 ROYAL FREE HOSPITAL**

Drawing Title
**LEVEL 07
 MECHANICAL SERVICES
 VENTILATION LAYOUT
 SHEET 1 OF 2**

TClarke
 DESIGN AND BUILD

Commodity Centre
 Braxted Park Road, Great Braxted t: +44 (0)2036 931776
 Essex, CM8 3EW w: www.tclarke.co.uk

Scale	Drawn By	Checked By	Date
1:50 @/A	MRG	JC	MAY 2018

TC Project Ref	Status	Revision
TC260012	S3	P01

PEA - TCL - 01 - 07 - DR - M - 20700