


SERVICES LEVEL NOTE
 THE LEVELS GIVEN ON THIS DRAWING ARE MEASURED FROM FINISHED FLOOR LEVEL 95.448 TO THE CENTRELINE OF PIPEWORK AND CIRCULAR DUCTWORK AND TO THE UNDERSIDE OF ELECTRICAL CONTAINMENT. RECTANGULAR DUCTWORK & DRAINAGE PIPEWORK, UNLESS OTHERWISE STATED.

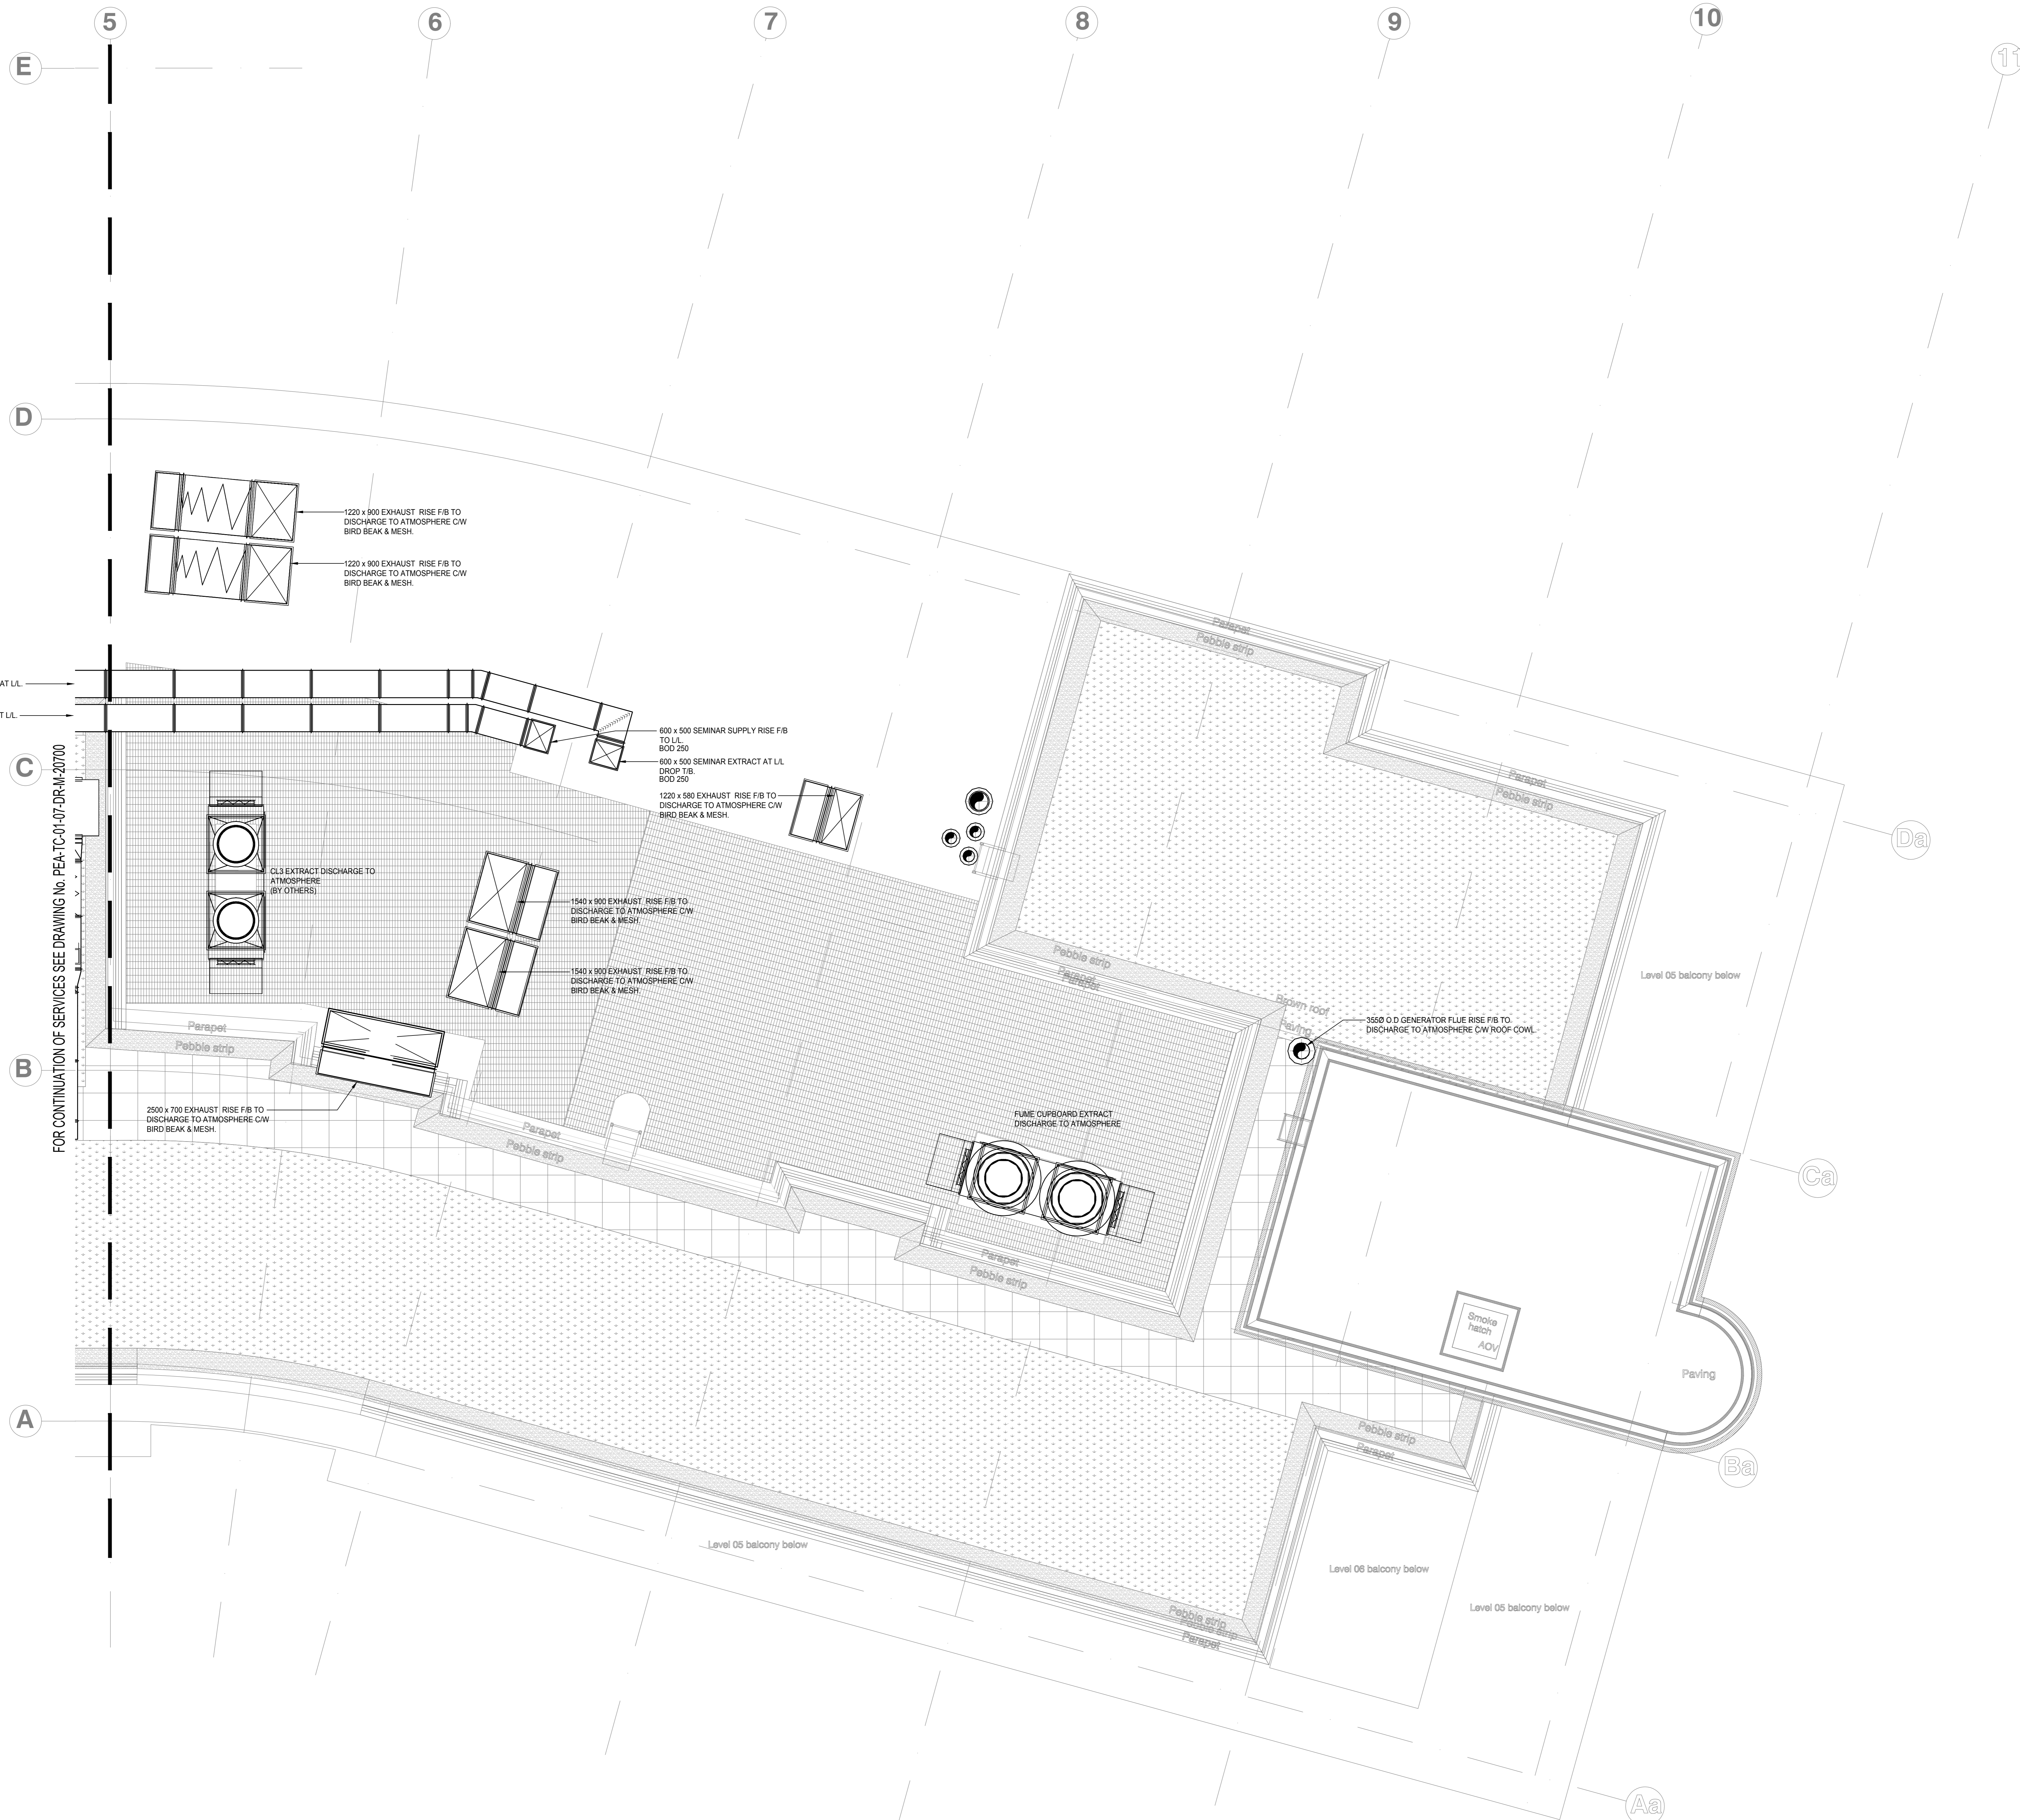

ARCHITECTS REFERENCE NOTE
 THIS LAYOUT WAS PRODUCED USING ARCHITECTS DRAWING NUMBER AL1107 REV P3.

REV	DATE	DESCRIPTION	MRG	JC	APP'D
01		PRELIMINARY ISSUE			

PRELIMINARY

Job Title
**PEARS BUILDING
 ROYAL FREE HOSPITAL**

Drawing Title
**LEVEL 07
 MECHANICAL SERVICES
 VENTILATION LAYOUT
 SHEET 2 OF 2**

TClarke
 DESIGN AND BUILD

Commodity Centre
 Braxted Park Road, Great Braxted Essex, CM8 3EW t: +44 (0)2036 931776
 www.tclarke.co.uk

Scale	Drawn By	Checked By	Date
1:50 @/A	MRG	JC	MAY 2014

TC Project Ref	Status	Revision
TC260012	S3	P01

PROJECT	ORIGIN	ZONE	LEVEL	TYPE	SCALE	NUMBER
PEA	TCL	01	07	DR	M	20701