


# 01/ROOF

## LEGEND




- Ⓐ KITCHEN SPECIALIST CONDENSER FOR COLDROOMS ETC  
DIM. 1390Lx683Dx1345H  
WT. —  
SOUND LEVEL (LpA @10m) 43 dB(A)
  - Ⓑ KITCHEN SUPPLY AHU CONDENSER  
DIM. 990Lx790Dx1635H  
WT. 219KG
- |    |    |     |     |     |      |      |      |      |
|----|----|-----|-----|-----|------|------|------|------|
| HZ | 63 | 125 | 250 | 500 | 1000 | 2000 | 4000 | 8000 |
| DB | 41 | 43  | 51  | 52  | 50   | 47   | 40   | 30   |
- Ⓒ KITCHEN OFFICE A/C UNIT CONDENSER  
DIM. 870Lx320Dx655H  
WT. 45KG  
SOUND POWER — 63 dBA
  - Ⓓ KITCHEN SPECIALIST CONDENSER OF FREEZER  
DIM. 1029Lx424Dx840H  
WT. 81KG  
SOUND LEVEL — 40 dB(A)

## LEGEND

- SALSA CONDENSER
- MADE.COMCONDENSER

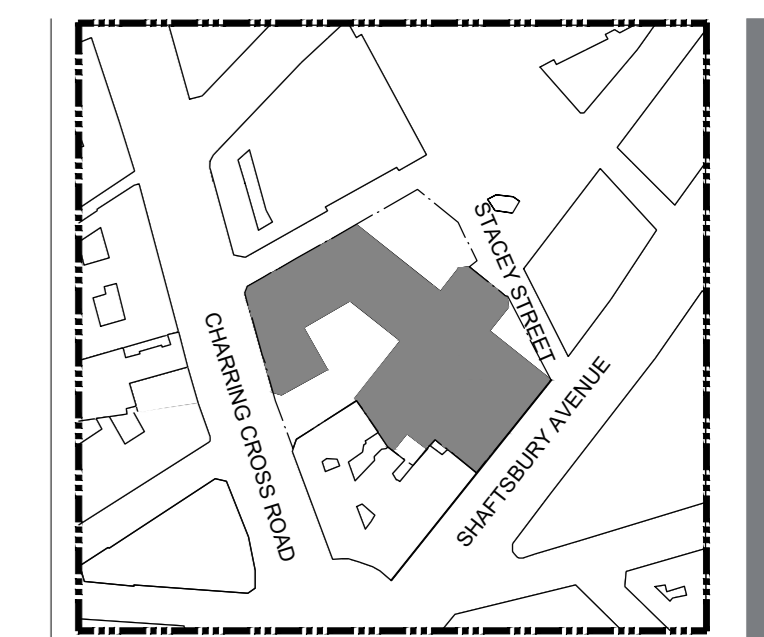

LOCATION PLAN NTS

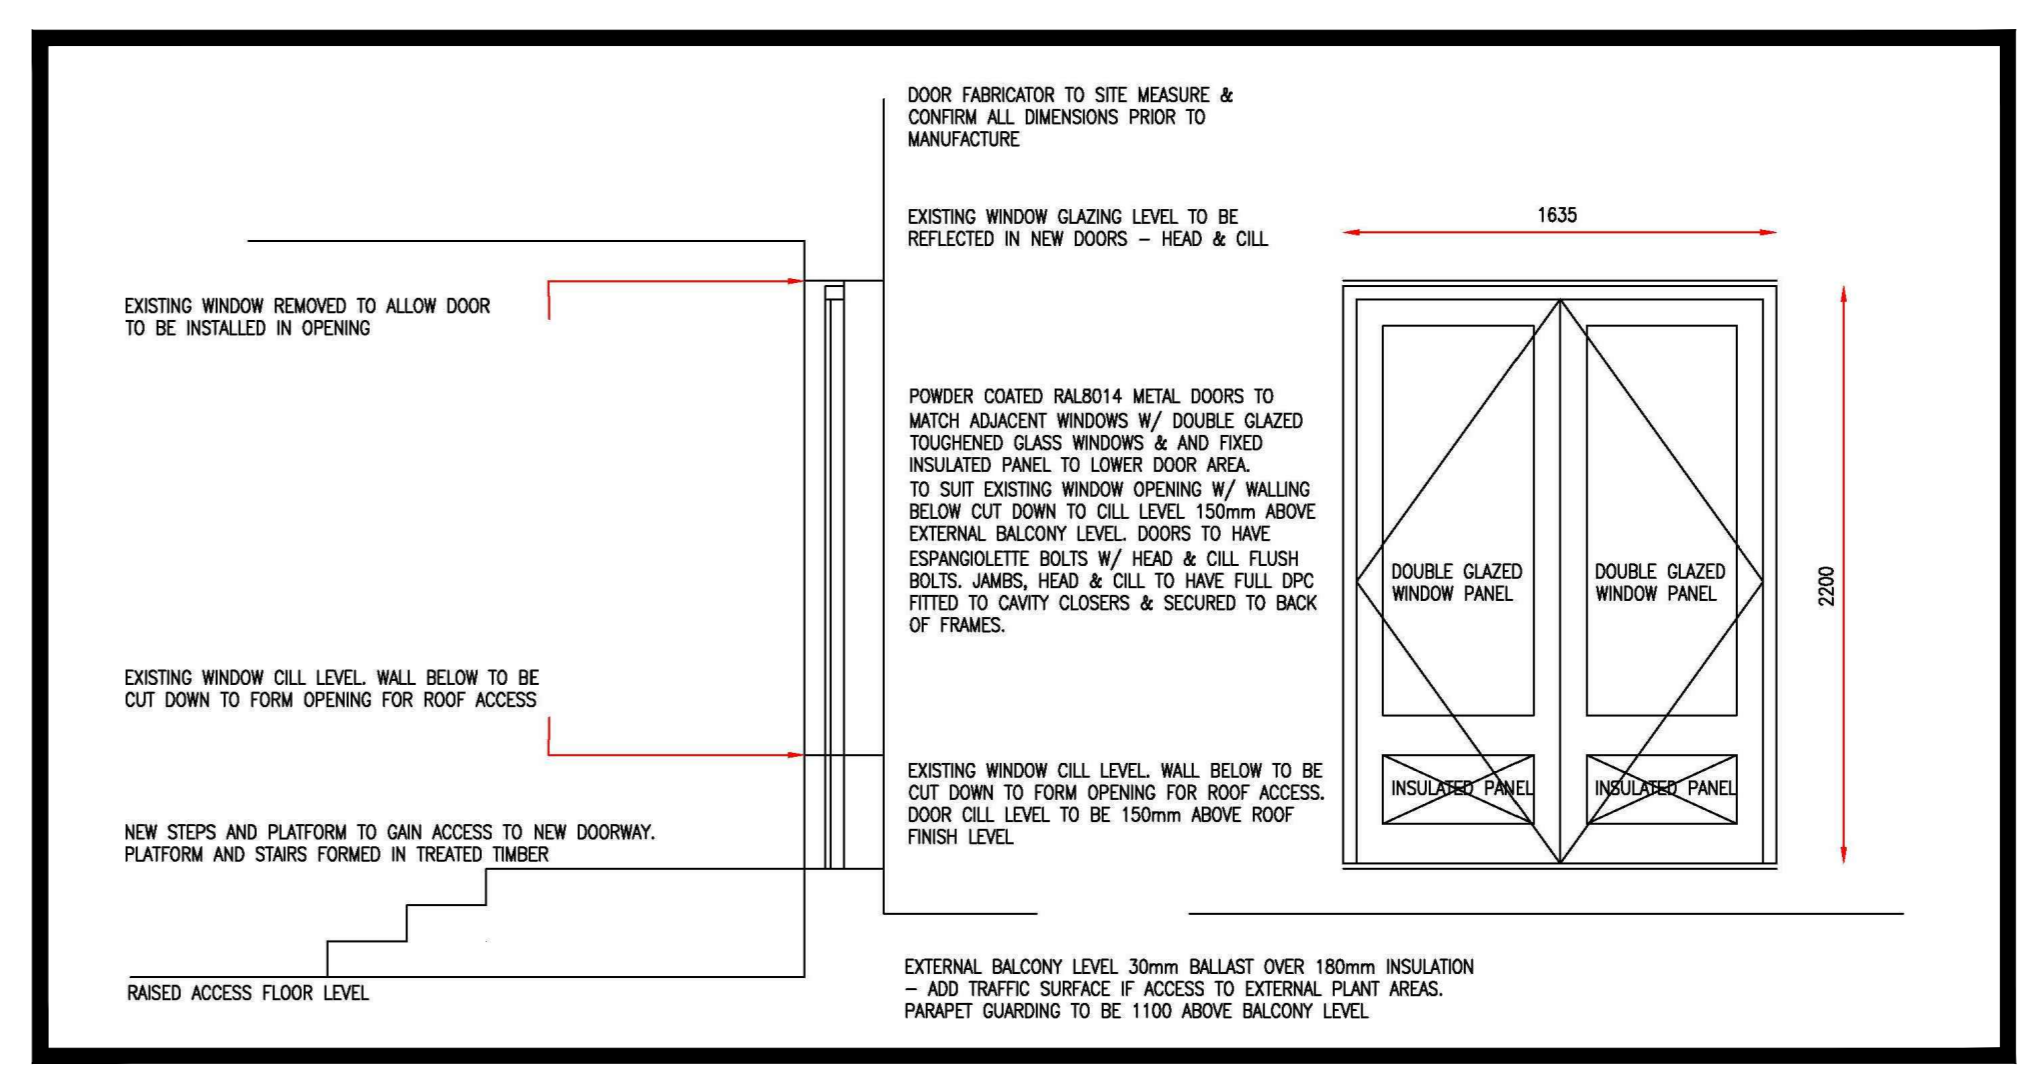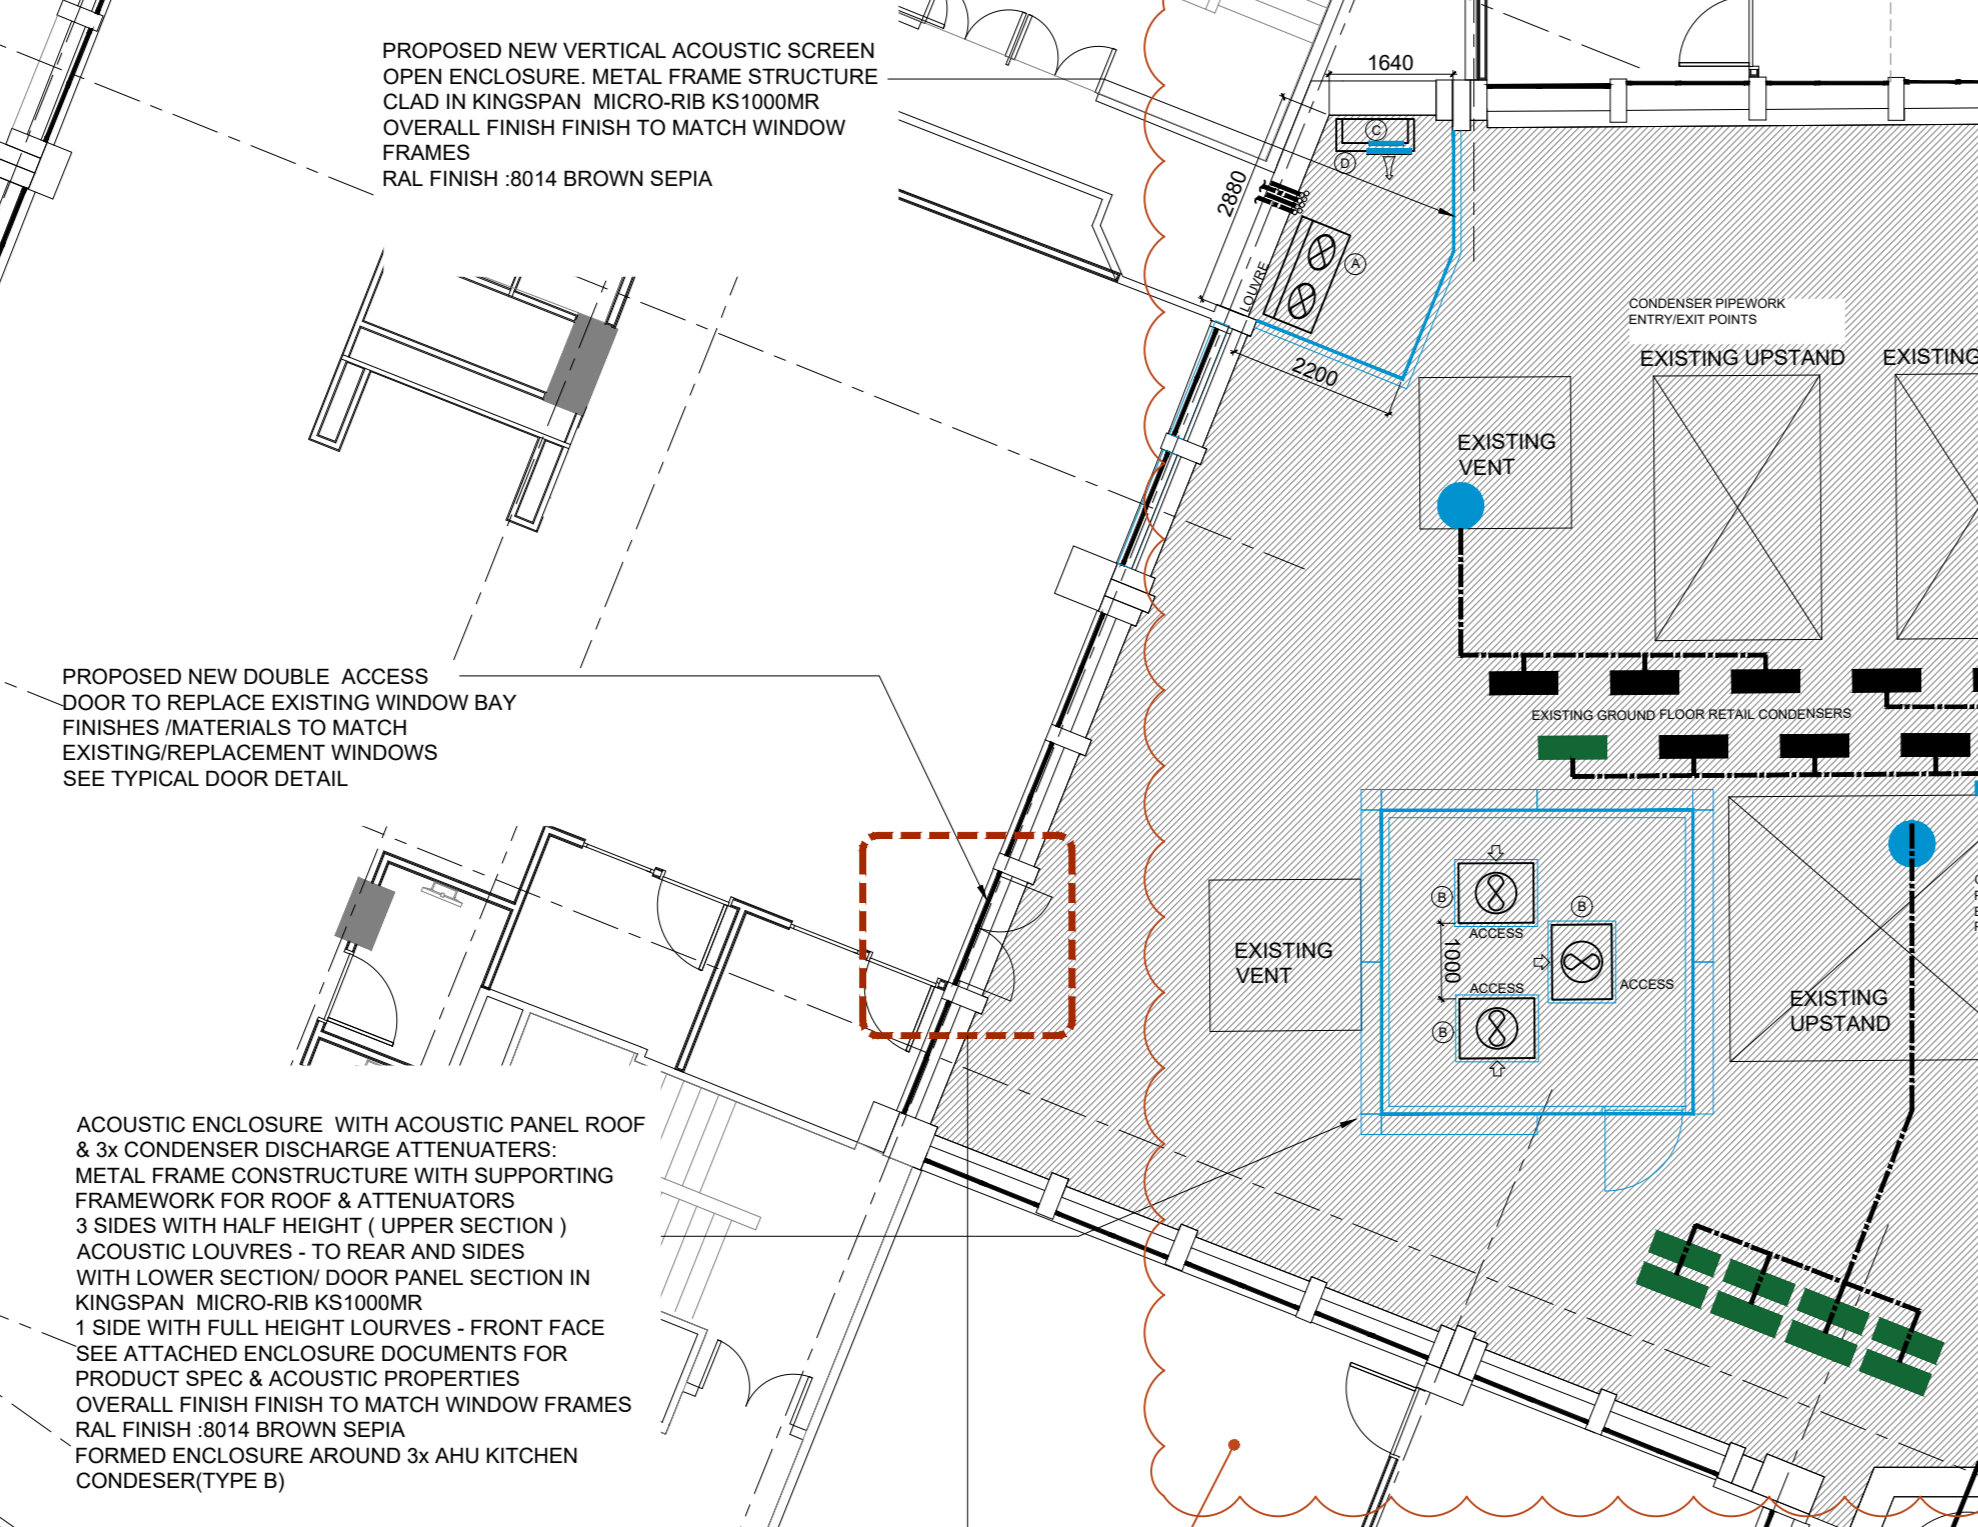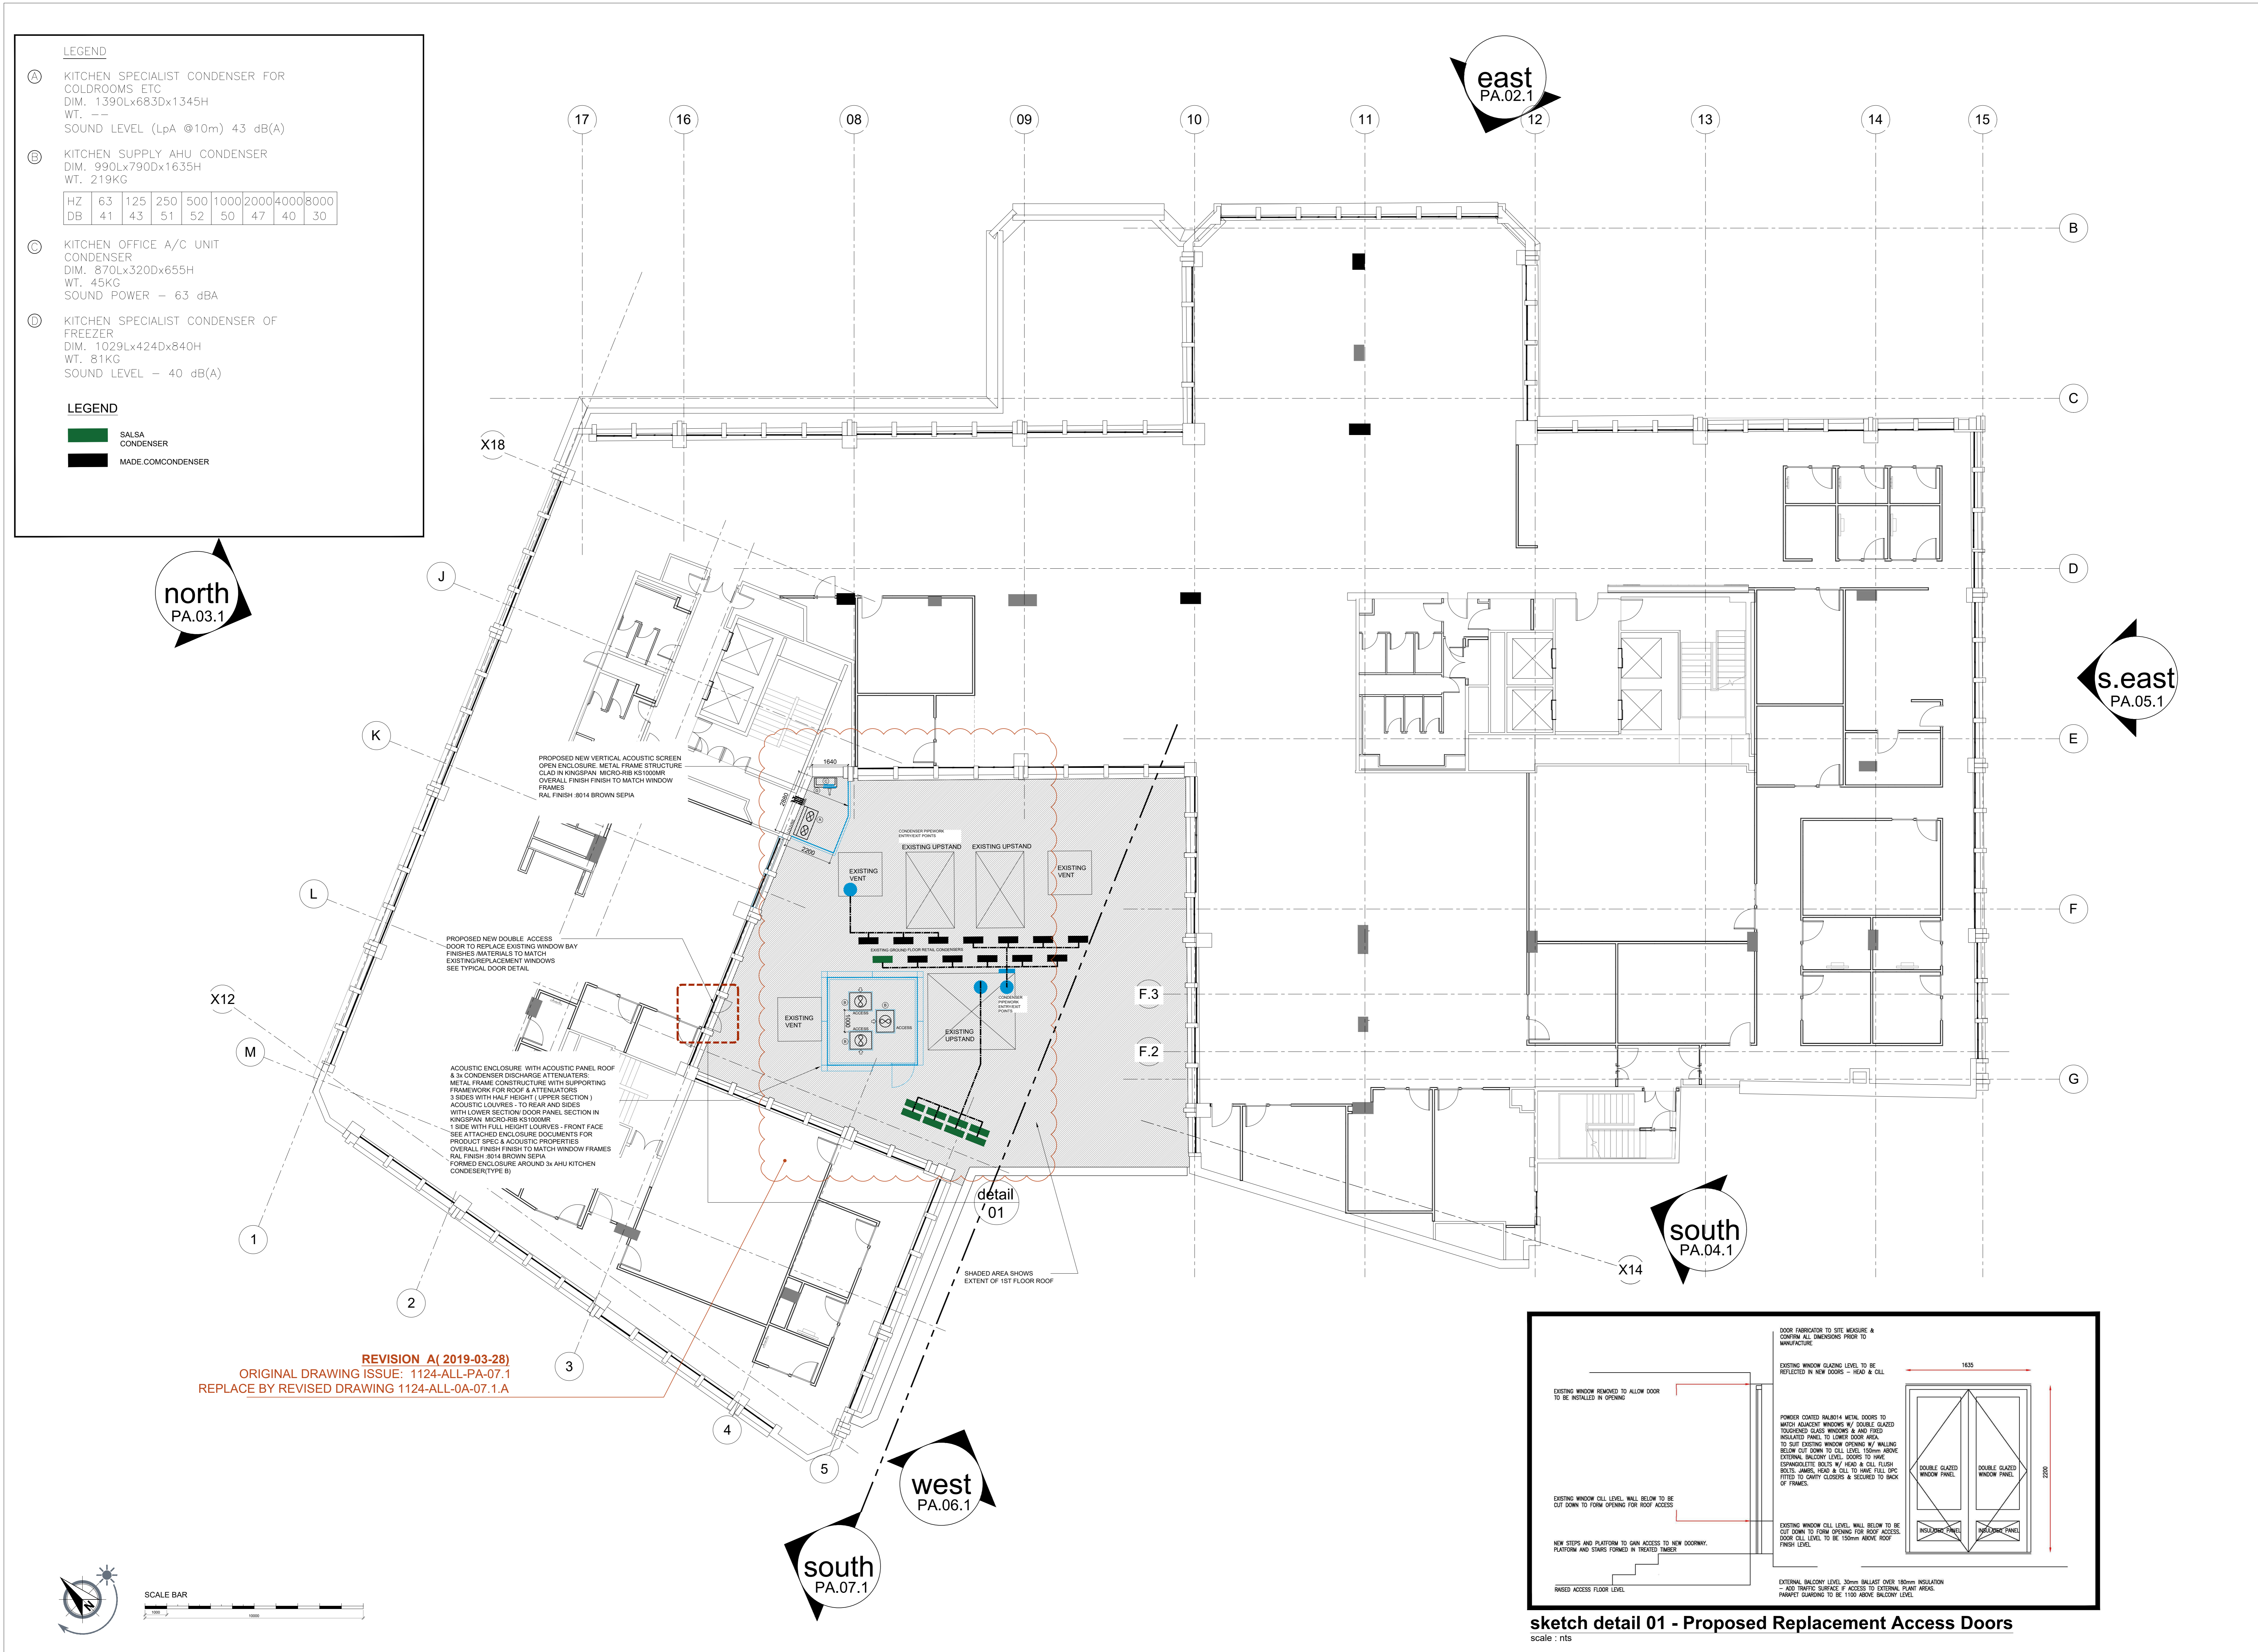

sketch detail 01 - Proposed Replacement Access Doors  
scale : nts

REVISION A (2019-03-28)  
ORIGINAL DRAWING ISSUE: 1124-ALL-PA-07.1  
REPLACE BY REVISED DRAWING 1124-ALL-0A-07.1.A



Rev	Descriptive amendments	Drawn by	Date
A	REVISED ISSUE	NJ	29.03.19
-	Drawing first produced	ANNJ	28.08.18

Client: WeWork  
Site Address: 125 Shaftesbury Avenue  
Drawing Title: 1st Floor Roof Plan - Proposed  
Designer: Senior Tech Designer / Project Manager  
N.HASSEY / P.HUGO / L.GRAYLAND  
Scale: 1:100 @ A0  
Contract Number: 1124  
Floor: ALL  
Detail: PA-01.3  
Revision: A

lbt. Aldwych House  
71-81 Aldwych  
London  
WC2B 4HN

This drawing is the exclusive Copyright of lbt and may not be copied or handed to any Third parties without prior consent. All dimensions must be checked on site and not scaled from the drawing. All drawings and proposals are subject to approval by statutory authorities.