



01/ROOF

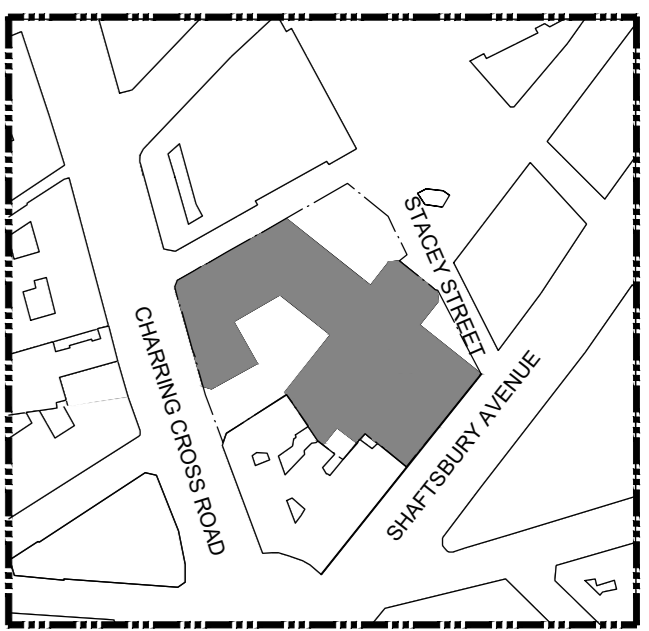


LOCATION PLAN
NTS

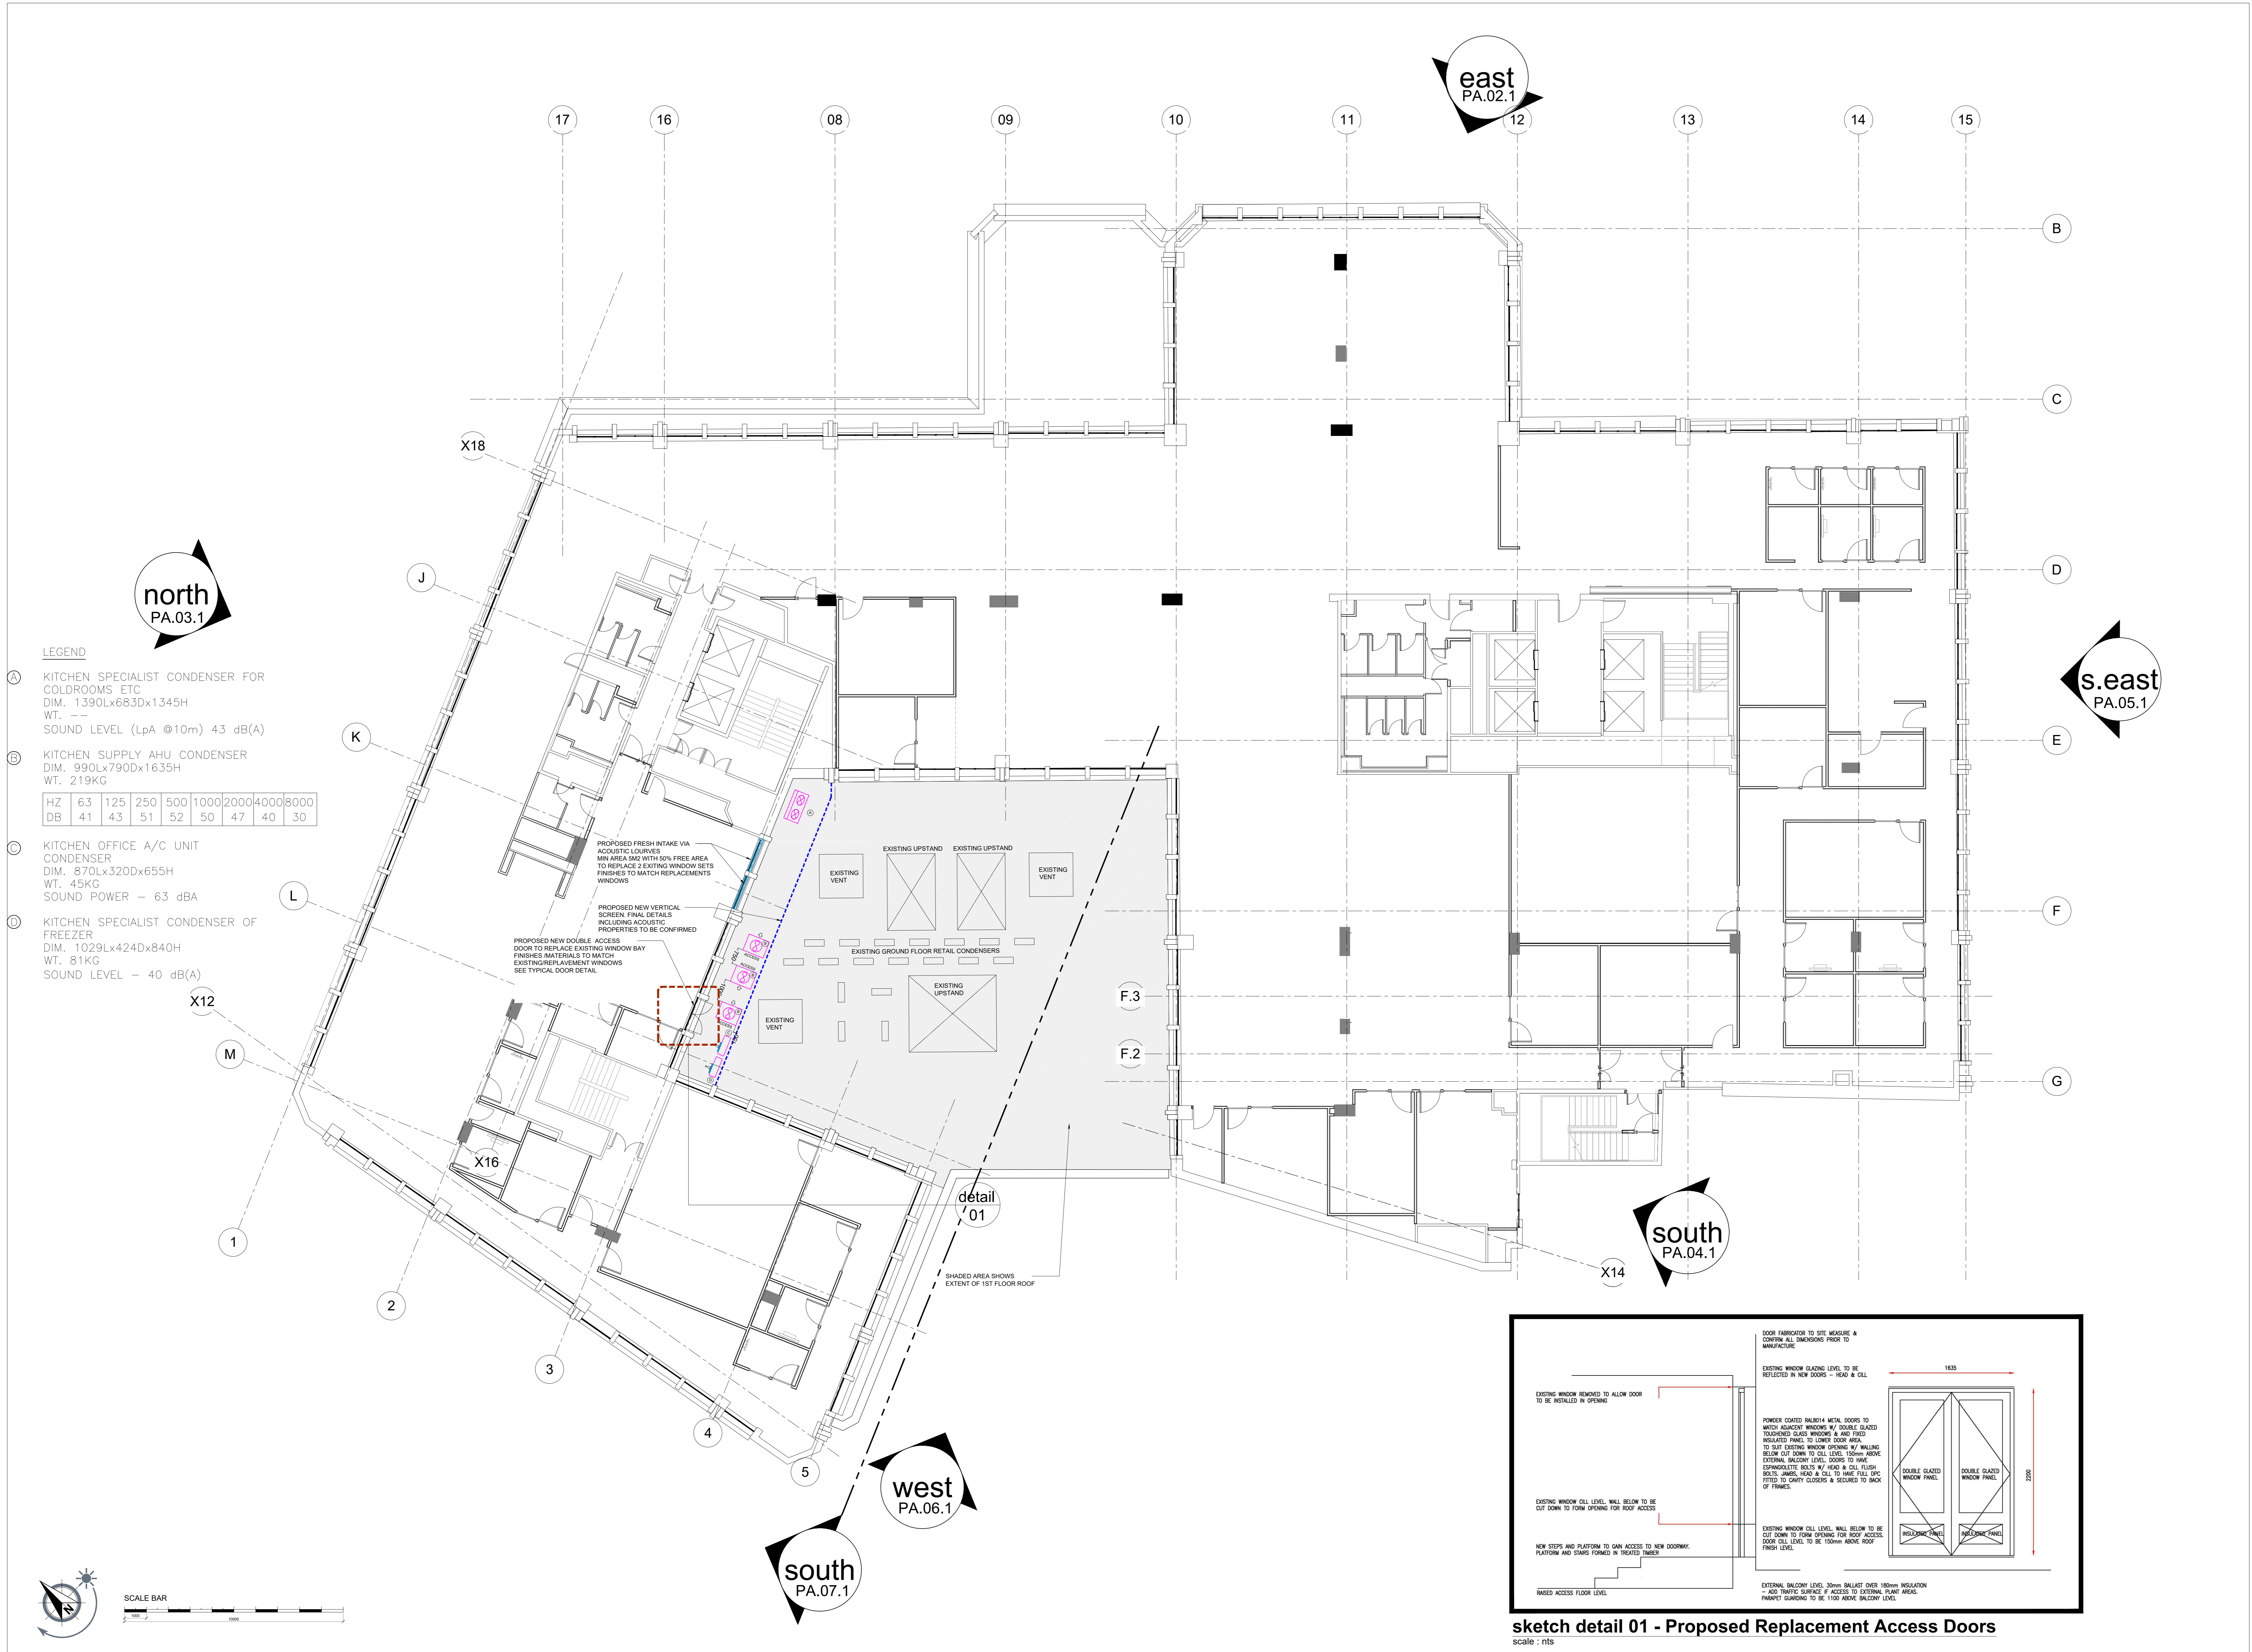

- LEGEND**
- A KITCHEN SPECIALIST CONDENSER FOR COLDROOMS ETC
DIM. 1390Lx683Dx1345H
WT. ---
SOUND LEVEL (LpA @10m) 43 dB(A)
 - B KITCHEN SUPPLY AHU CONDENSER
DIM. 990Lx790Dx1635H
WT. 219KG
 - C KITCHEN OFFICE A/C UNIT CONDENSER
DIM. 870Lx320Dx655H
WT. 45KG
SOUND POWER - 63 dBA
 - D KITCHEN SPECIALIST CONDENSER OF FREEZER
DIM. 1029Lx424Dx840H
WT. 81KG
SOUND LEVEL - 40 dB(A)

HZ	63	125	250	500	1000	2000	4000	8000
DB	41	43	51	52	50	47	40	30

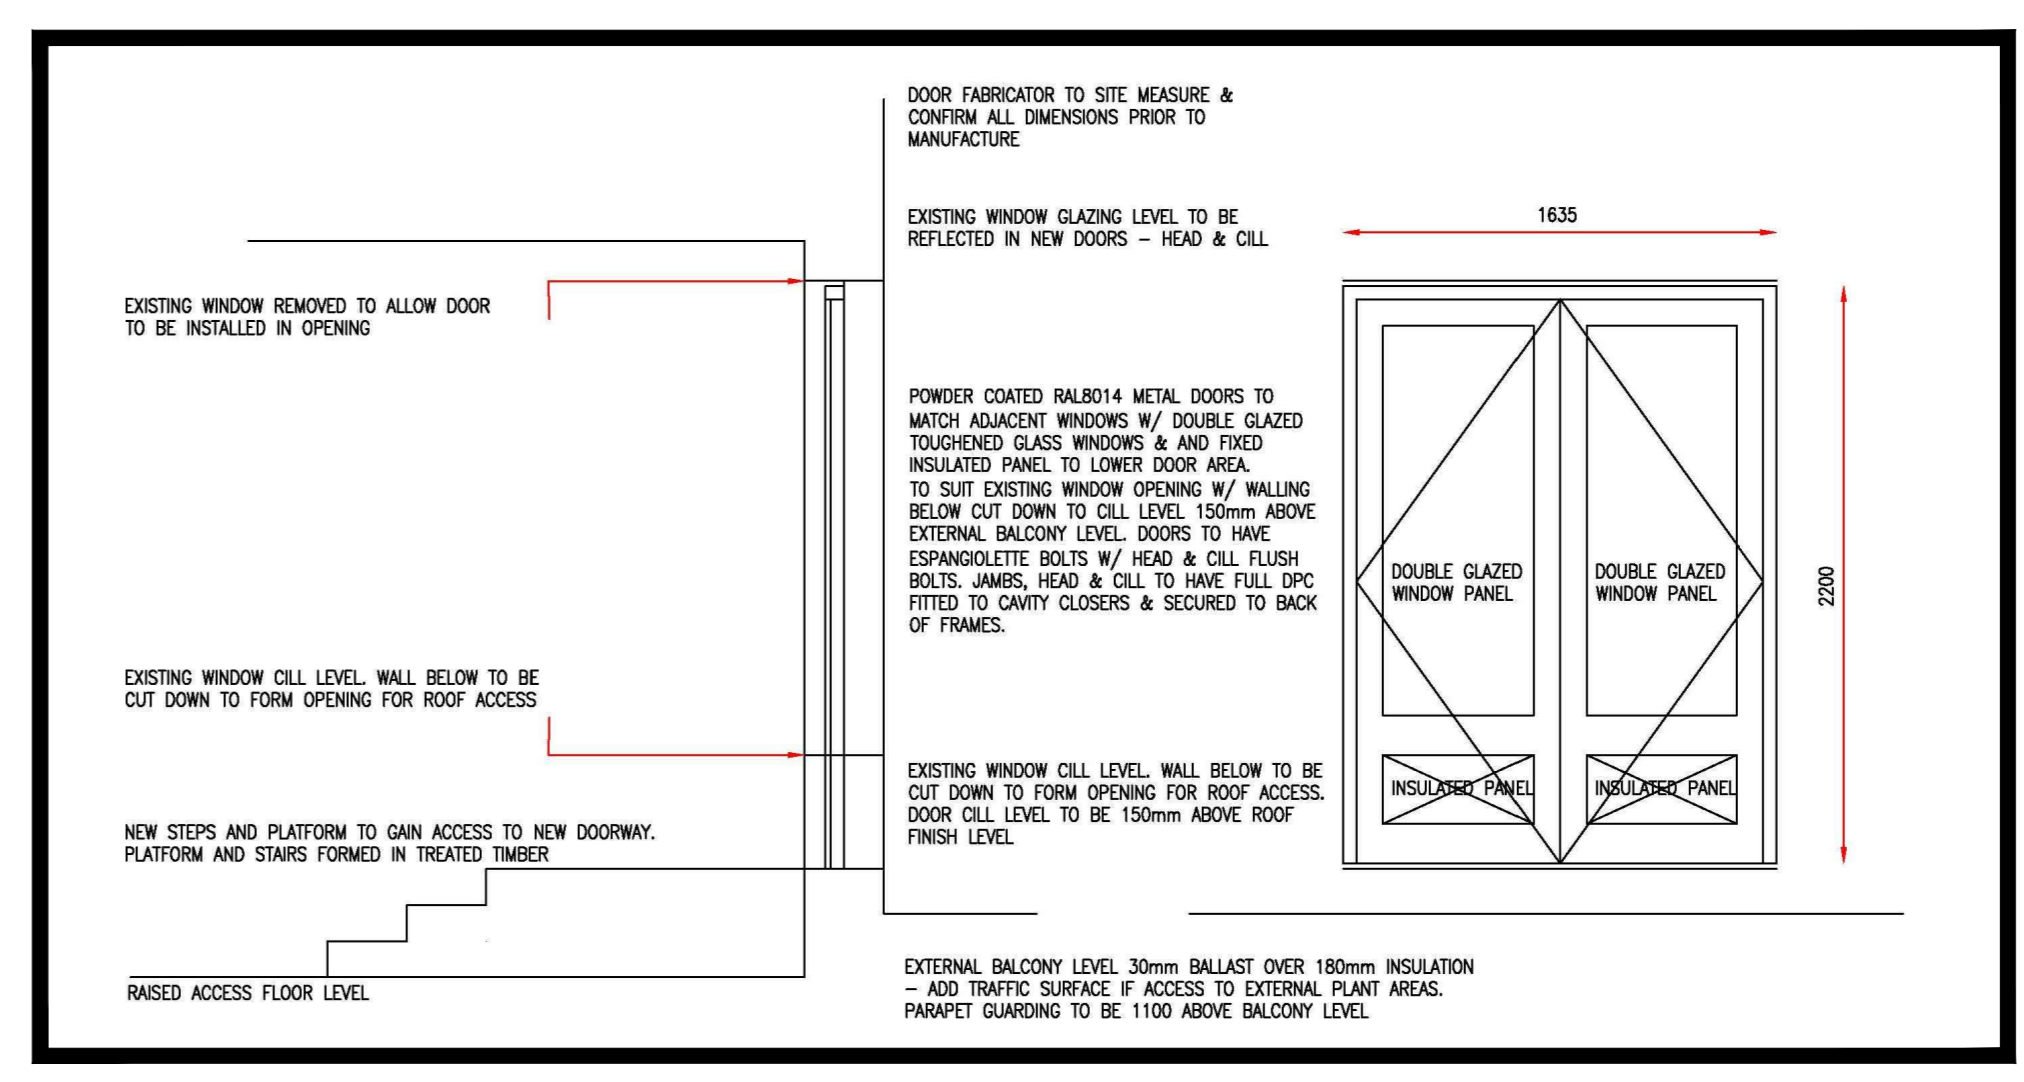

Rev	Description	Drawn by	Date
-	Drawing first produced	ANNJ	28.08.18
-	Descriptive amendments	ANNJ	28.08.18

Planning Application

Client: **WeWork**

Site Address: 125 Shaftesbury Avenue

Drawing Title: 1st Floor Roof Plan - Proposed

Designer: Senior Tech. Designer / Project Manager
N. HASSEY / J. VAUGHAN / L. GRAYLAND

Scale: 1:100 @ AD
Drawn By: AN
First Drawing Date: 22/08/18

Contract Number: 1124
Floor: ALL
Detail: PA-01.3
Revision: -

ltb. Aldwych House
71-81 Aldwych
London
WC2B 4HN

This drawing is the exclusive Copyright of ltb and may not be copied or handed to any Third parties without prior consent. All dimensions must be checked on site and not scaled from the drawing. All drawings and proposals are subject to approval by statutory authorities.