




Vicarage - First Floor Plan  
1:20

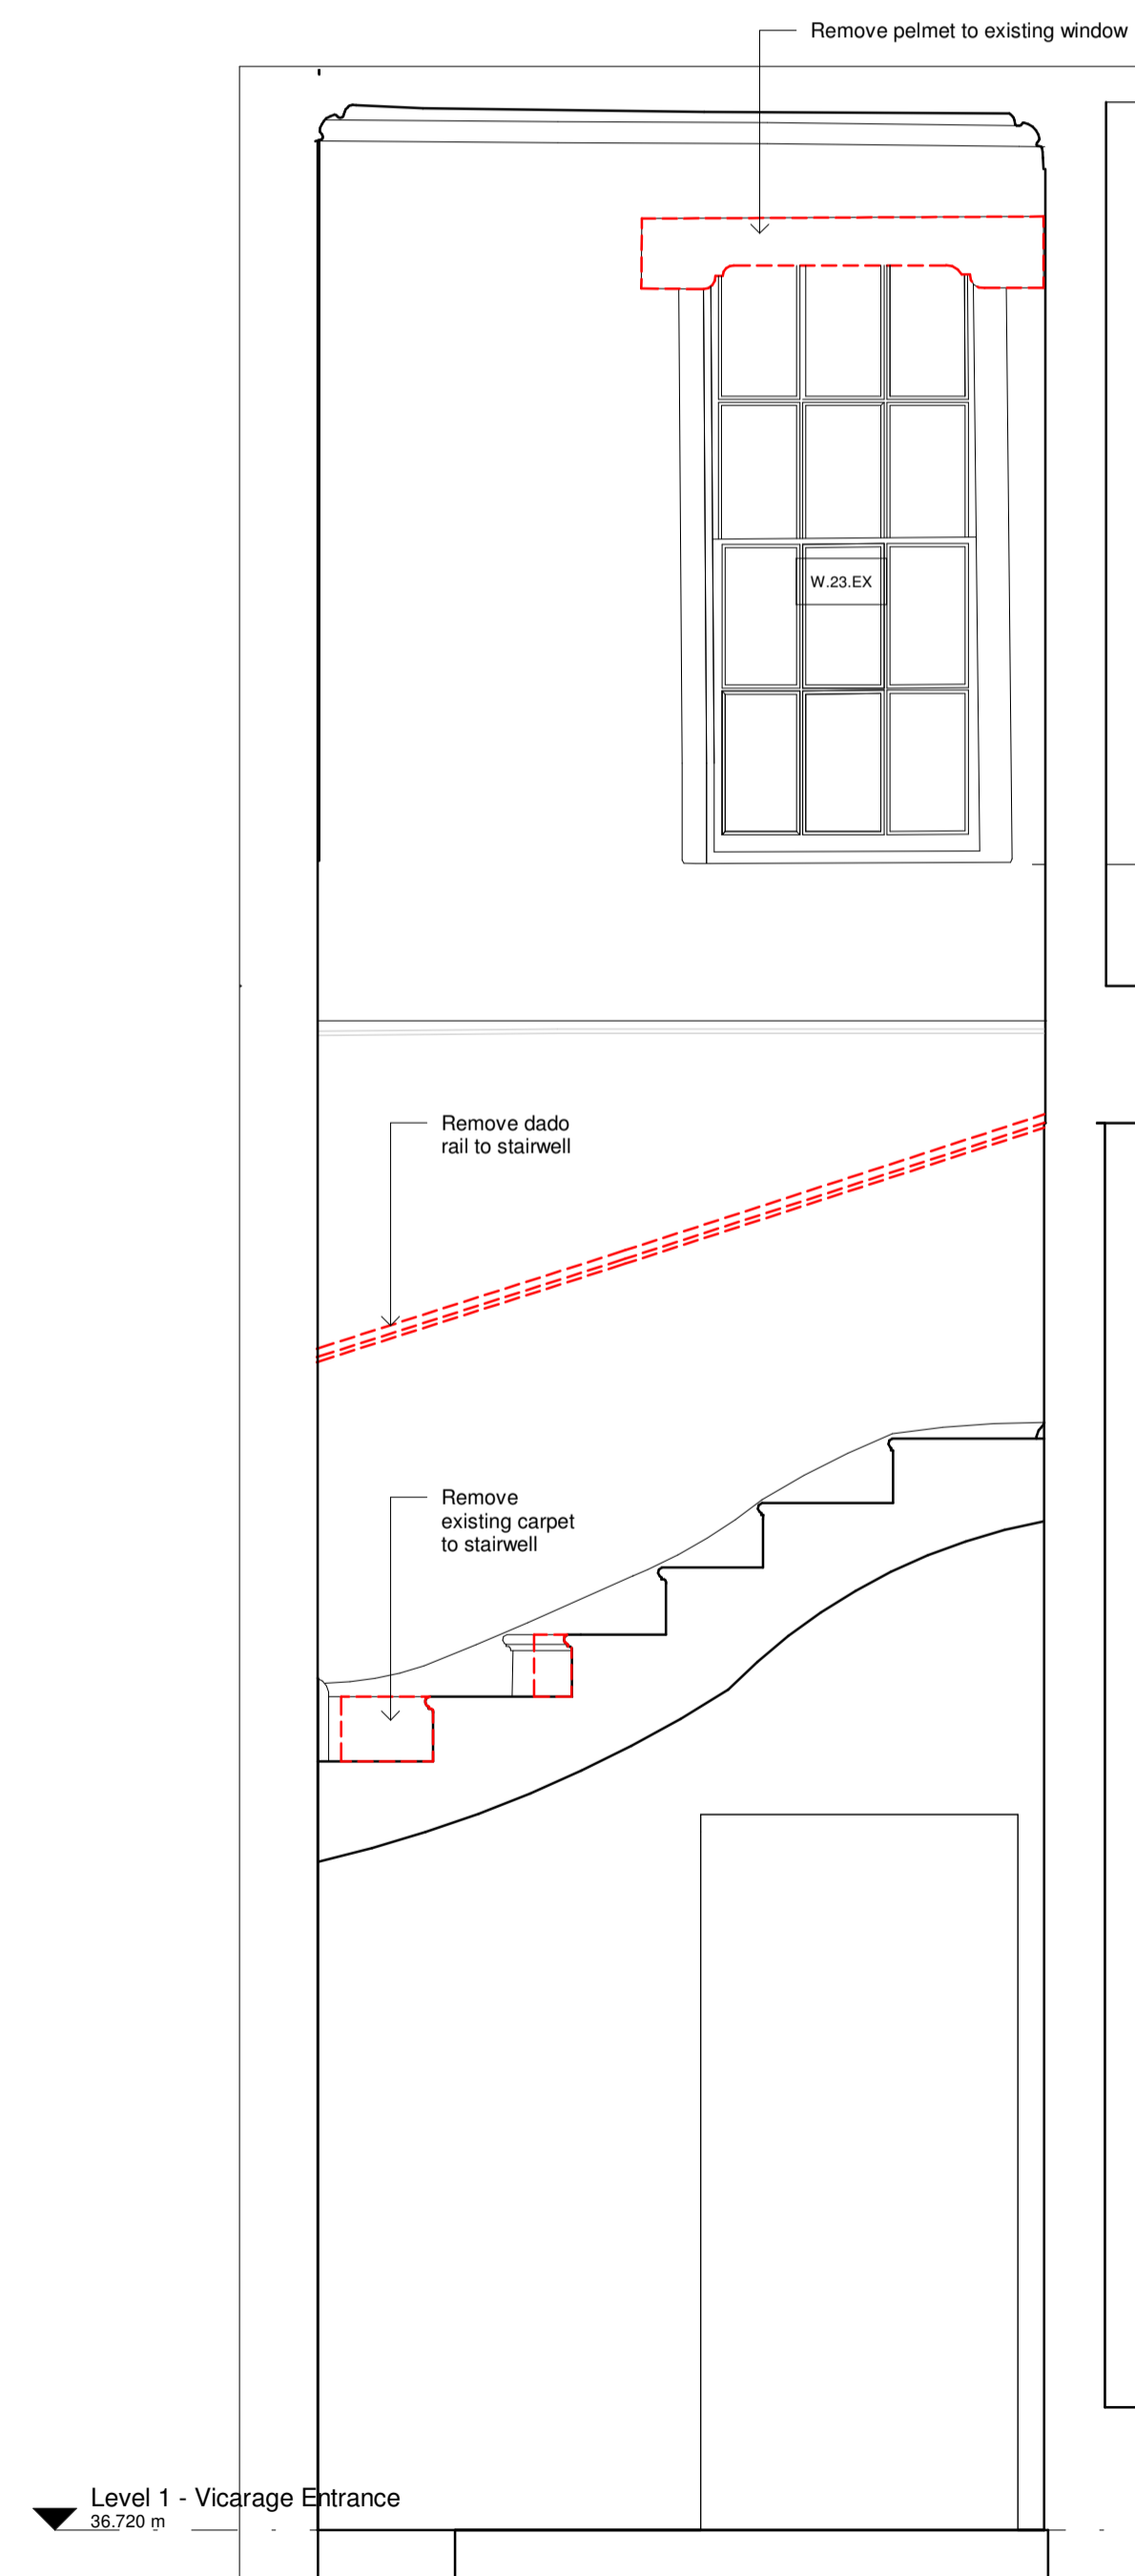

Vicarage - Cross-Section B\_B - Existing  
1:20



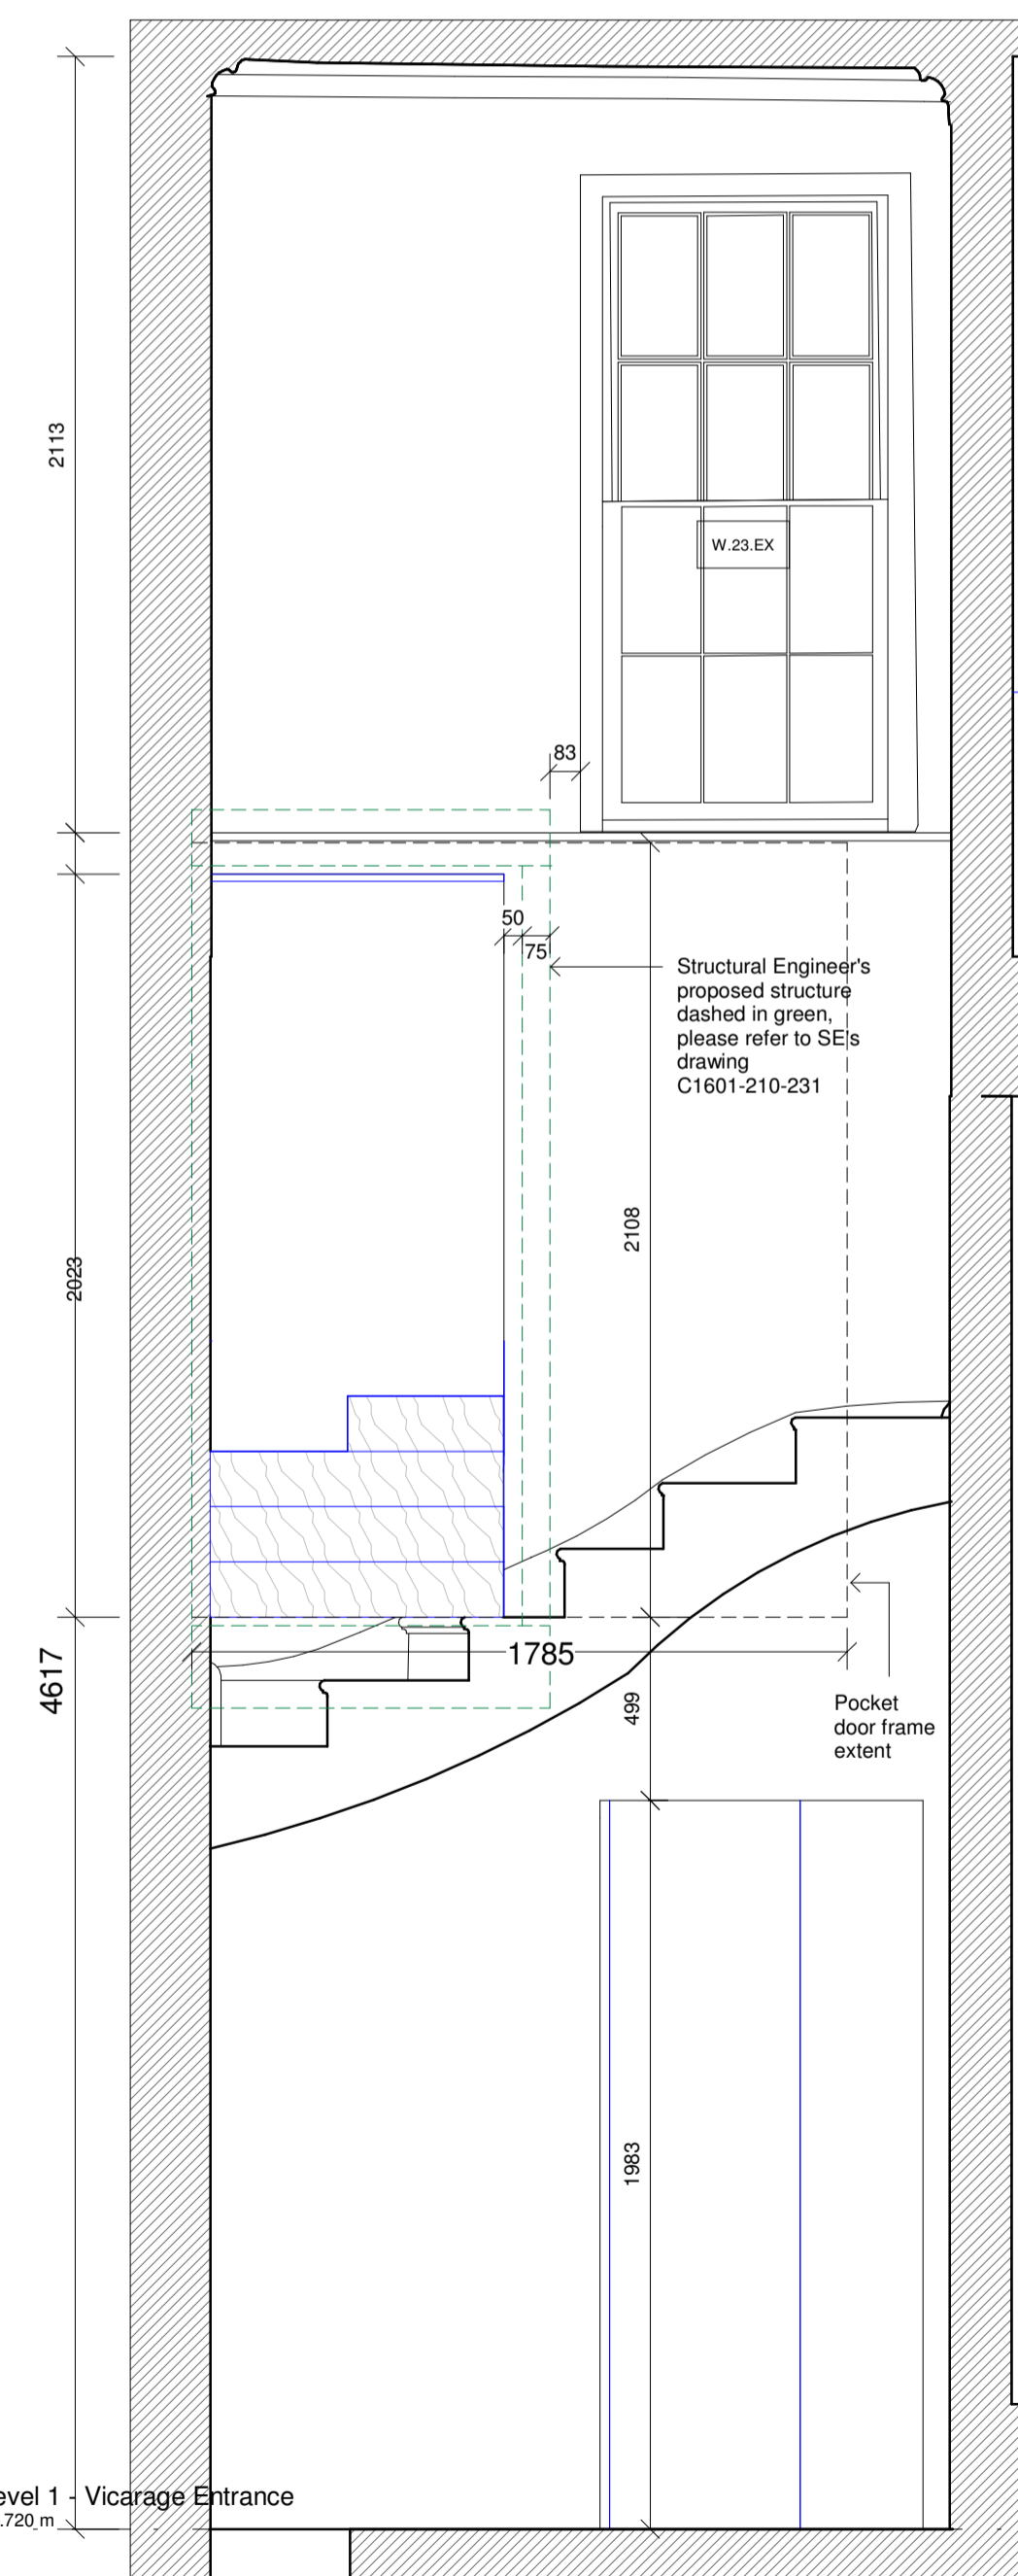


Vicarage - Cross-Section B\_B - Proposed  
1:20

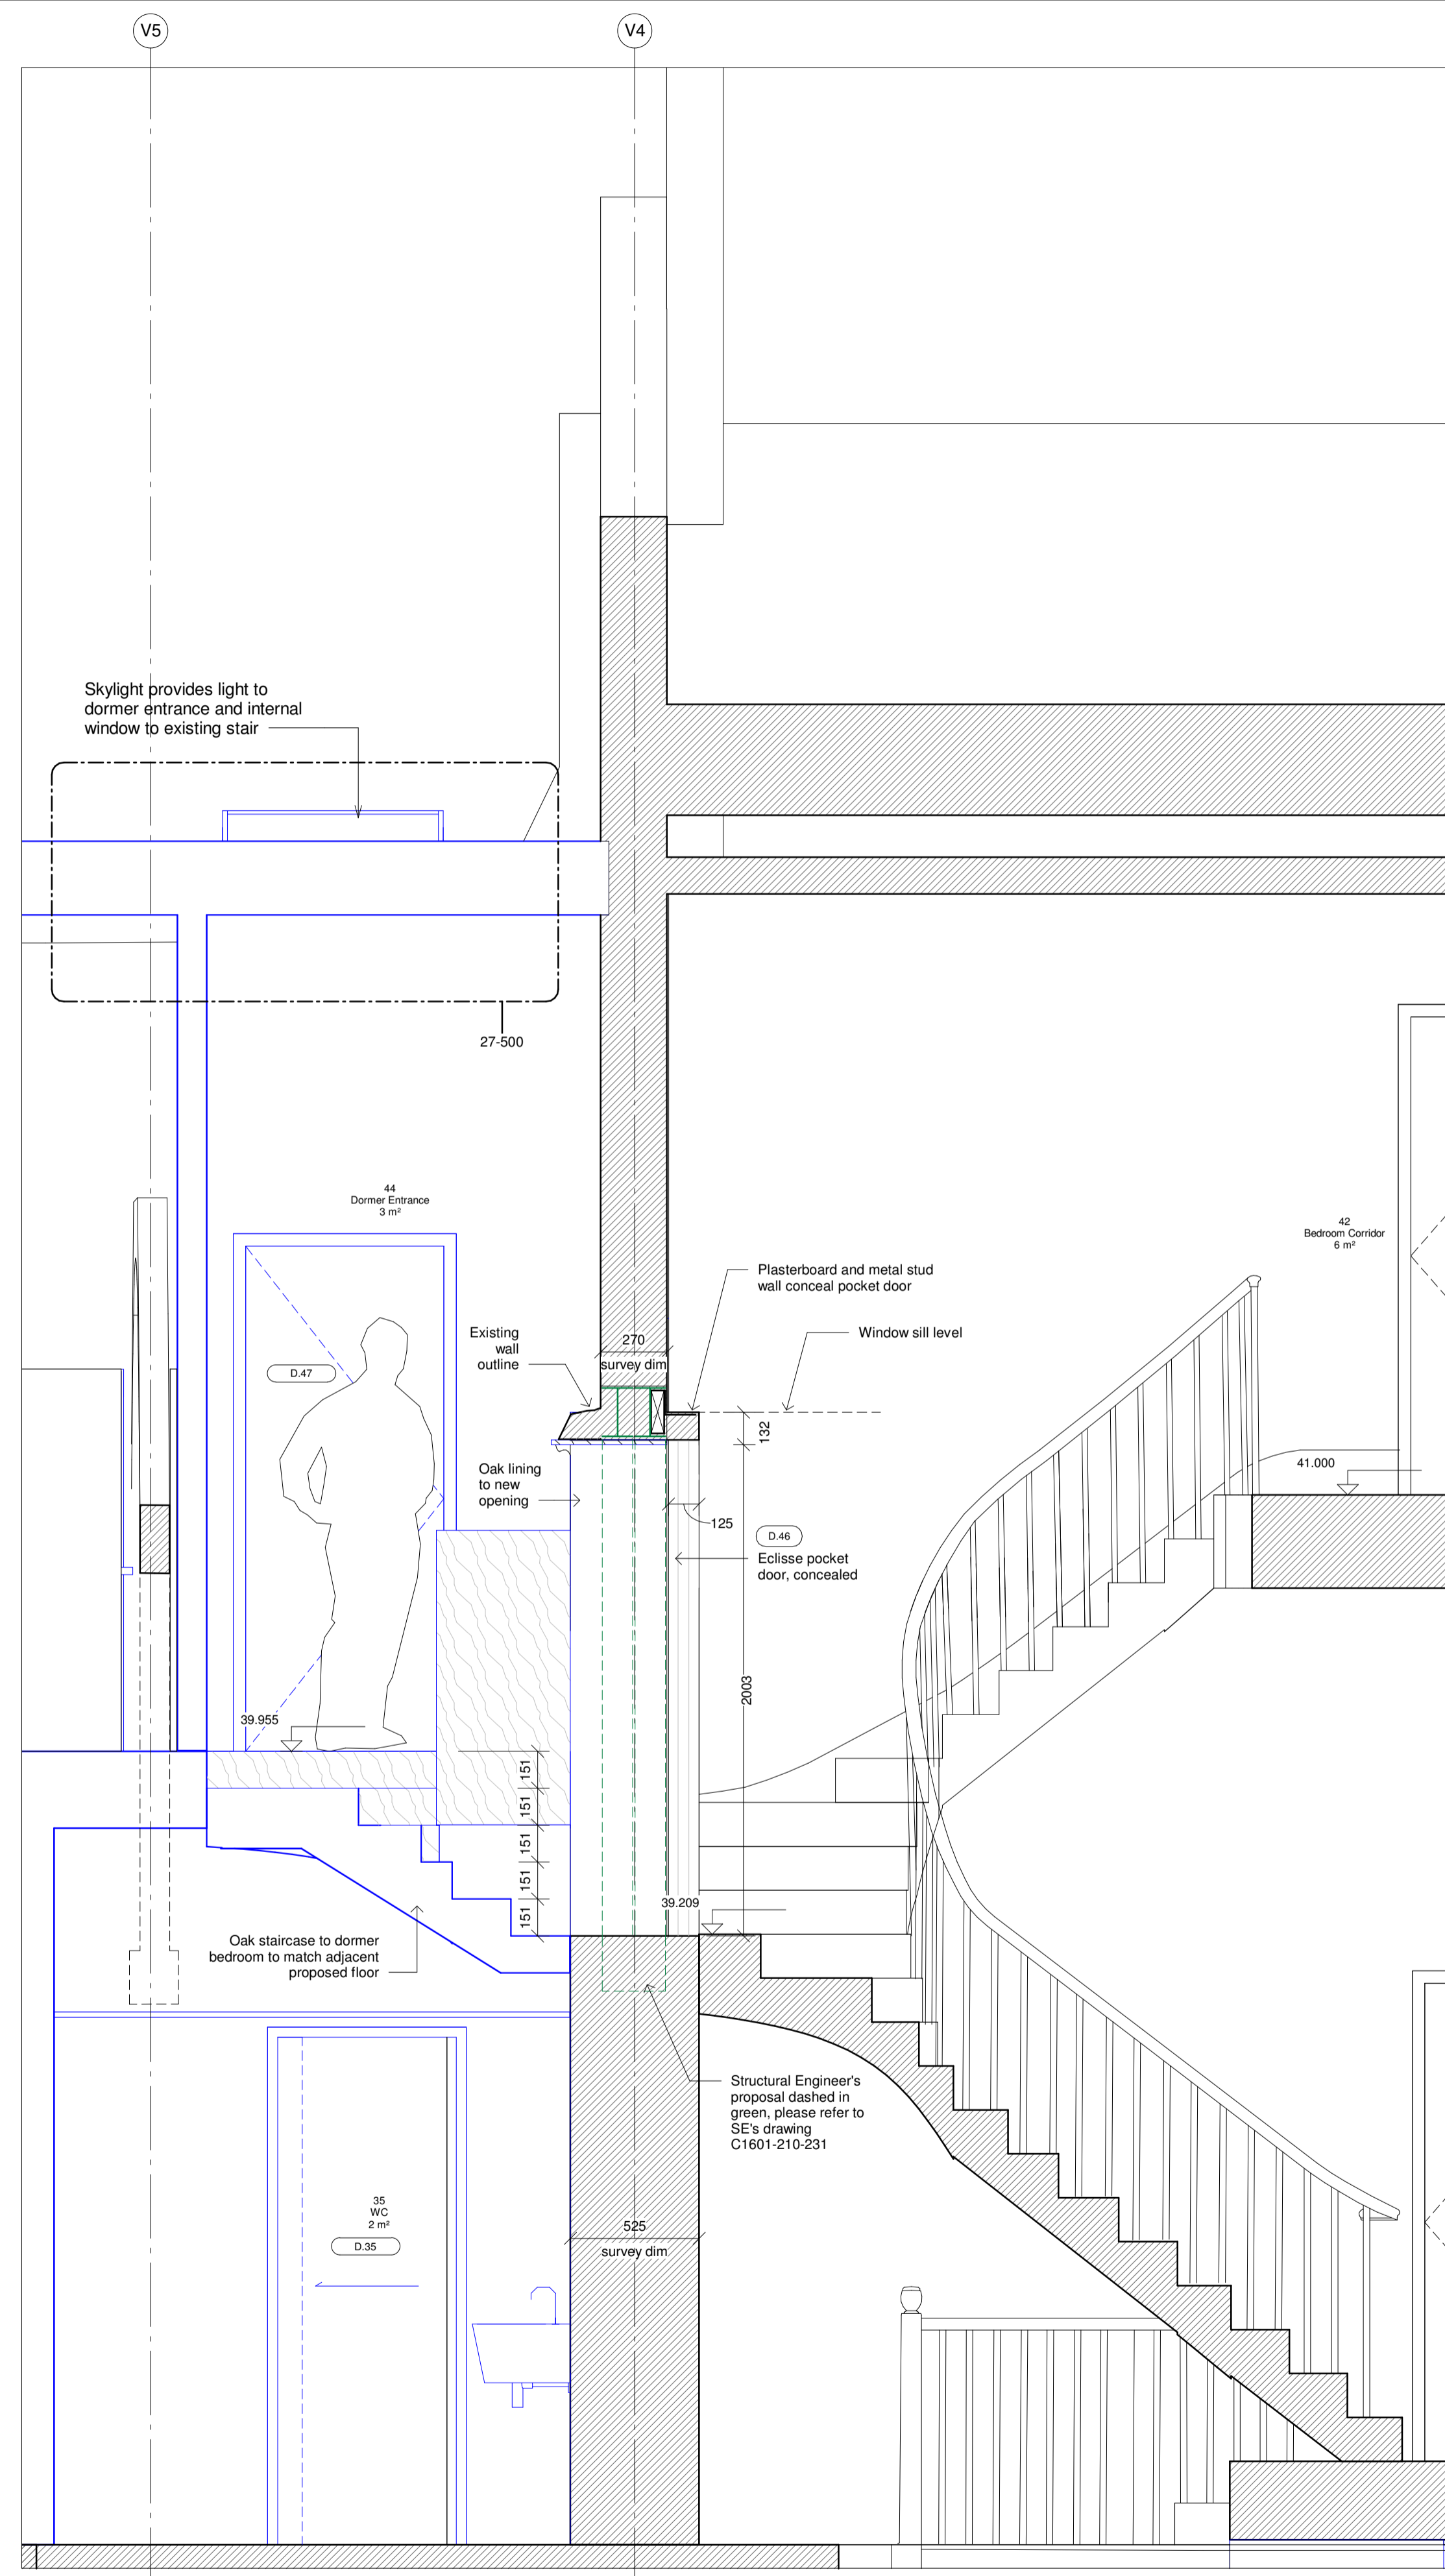

Vicarage - Long Section C.C.  
1:20

 GENERAL NOTES  
DO NOT SCALE OFF THIS DRAWING.  
ALL DIMENSIONS MUST BE CHECKED ON SITE INFORM THE ARCHITECT OF ANY DISCREPANCIES PRIOR TO CONSTRUCTION.  
THIS DRAWING IS COPYRIGHT & MAY NOT BE OTHERWISE USED OR COPIED.  
READ IN CONJUNCTION WITH M.E.P. S.E. AND CIVIL ENGINEER'S DRAWINGS.  
CDM REGULATIONS 2015  
ALL CURRENT DRAWINGS AND SPECIFICATIONS FOR THE PROJECT MUST BE READ IN CONJUNCTION WITH THE DESIGNER'S HAZARD AND ENVIRONMENTAL ASSESSMENT RECORD

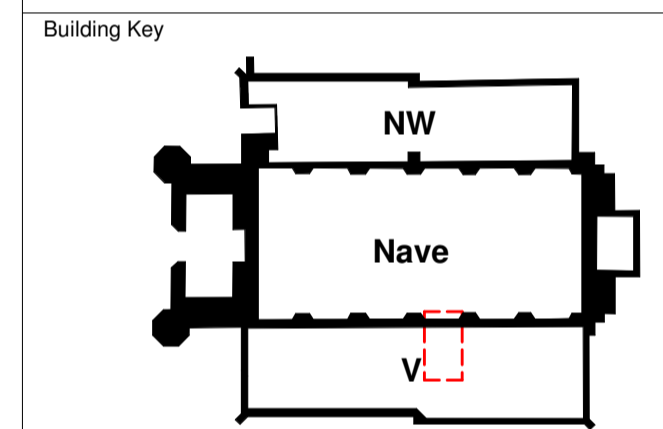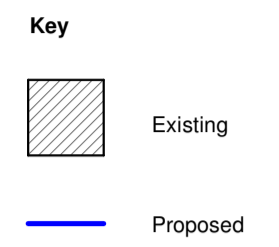

Client

The Danish Church  
4 St Katharine's Precinct  
London NW1 4HH

**C.F. Møller**

Telephone House, 69-77 Paul Street  
London, EC2A 4NW  
United Kingdom  
Tel.: +44 20 7427 1530  
london@cfmoller.com

Europaplads 2, 11  
8000 Aarhus C  
Denmark  
Tel.: +45 8730 5300  
www.cfmoller.com

Rev	Description	By	Chk	Date
A	Tender Issue	HBA	RN	08/02/19

The Danish Church

Vicarage - Dormer Entrance  
Connection

Project No.  
**85331**

Status  
**Stage 4 - TENDER**

Scale @ A1	Date	Revision
1:20	08/02/19	A

Drawing Number  
**85331-CFM-24-500**