


Copyright. All Rights Reserved.
This work is copyright and cannot be produced or copied in any form or by any means (graphic, electronic or mechanical including photocopying) without the written permission of the originator. Any license, express or implied, to use this document or any purpose whatsoever is restricted to the terms of the agreement or implied agreement between the originator and the instructing party.
DO NOT SCALE FROM THIS DRAWING. WORK ONLY FROM FIGURED DIMENSIONS.
THIS DRAWING TO BE READ IN CONJUNCTION WITH RELEVANT CONSULTANT'S DRAWINGS.

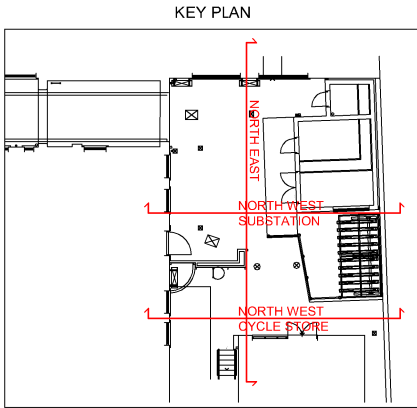


REV P01 | DATE 16/04/2019 | DRAWN / CHECKED / APPROVED KK / BW / BW
First Issue



adjoining building

adjoining building

PROPOSED NORTH EAST ELEVATION 1:50
Sub-station & Cycle Store

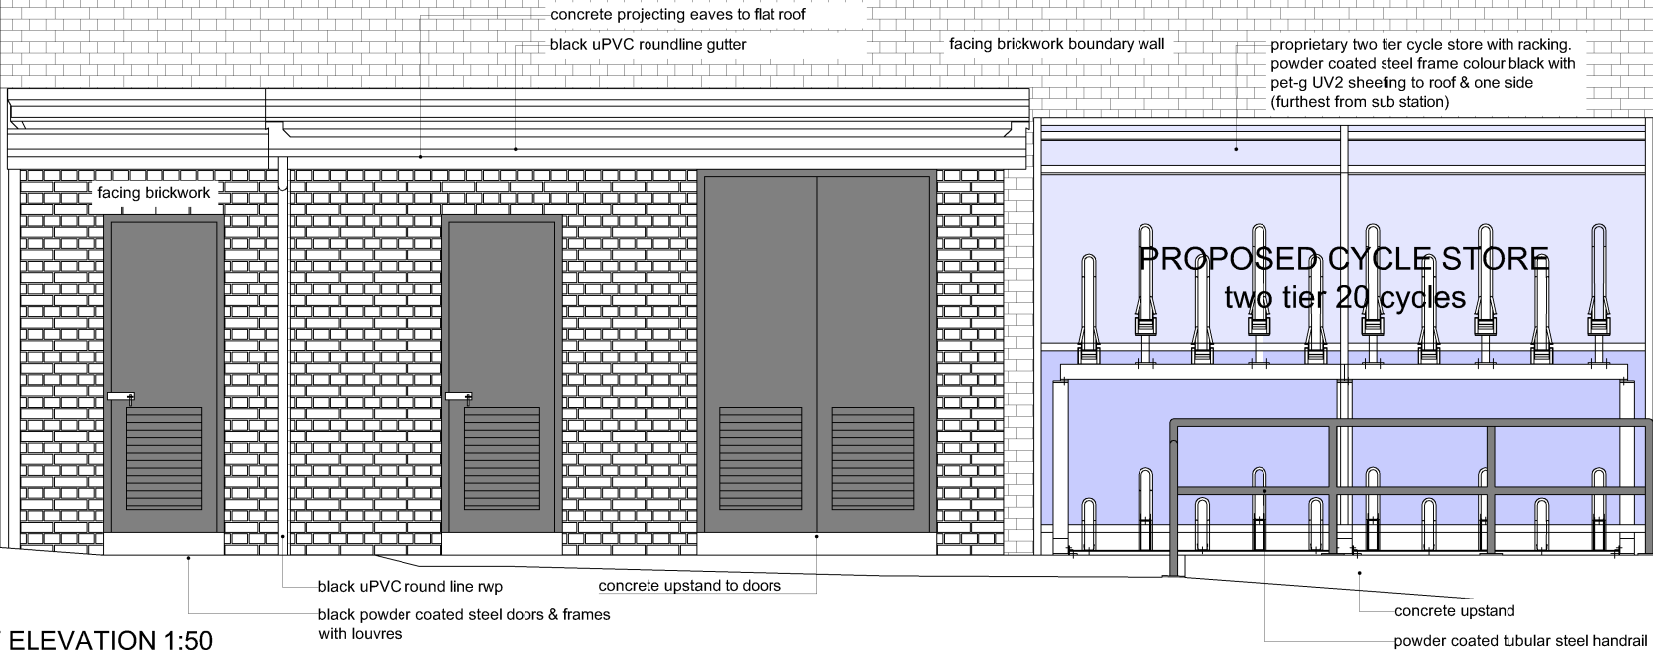

4 Northington Street
London WC1N 2JG
+44 (0)20 7490 1904
london@medicalarchitecture.com
medicalarchitecture.com

Medical
Architecture

CLIENT
UNIVERSITY COLLEGE LONDON HOSPITALS

PROJECT
8-11 Queen Square
Mains Power Infrastructure

TITLE
PROPOSED NORTH EAST ELEVATION

STAGE
02

STATUS
-

PROJECT NUMBER
775

SCALE @A3
1:50

DRAWING NUMBER
5846-MAA-81-00-DR-A-307-S3-P01

REVISION
P01

FILE REFERENCE
\\LON-SRV-01\Projects\775_UCLH_ElectricalInfrastructure\Design\Location\01_Zone\DWG\8-11QS