


SCALE 1:200
SCALE 1:1

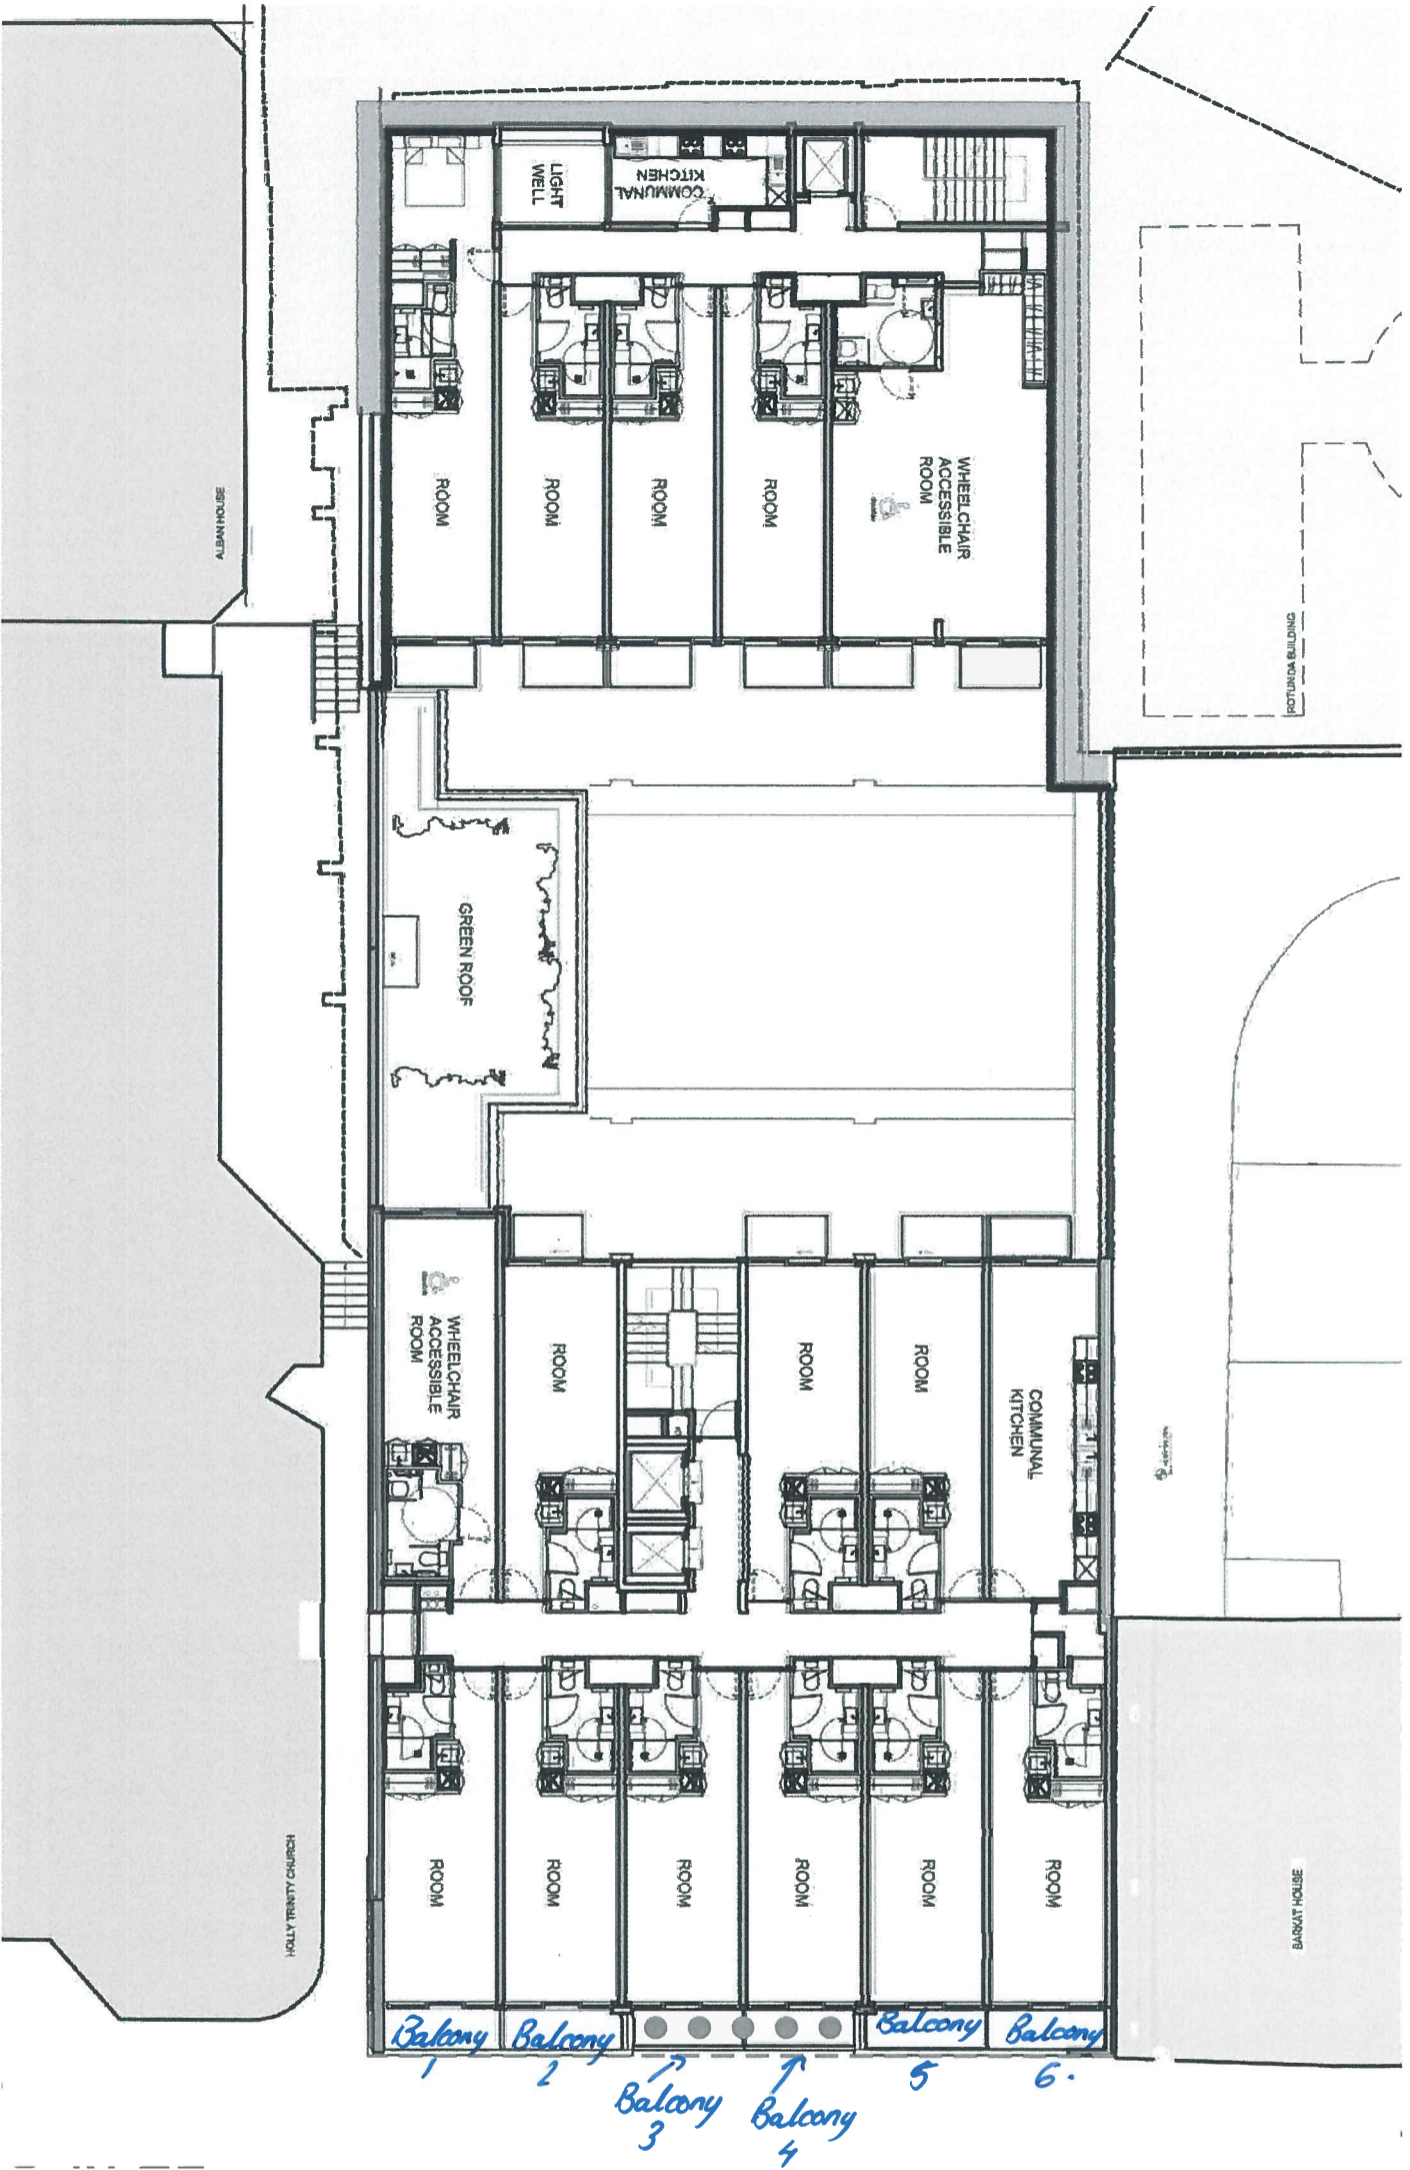

Lighting Legend

- L1 - WALL MOUNTED CUBE LIGHTING
- L2 - LED STRIP LIGHTING TO UNDERSTRE OF BALCONIES
- L3 - LINEAR LIGHTING FOR FACIOL
- L4 - RECESSED DOWNLIGHT

Drawing Notes




- 01 - DIMENSIONS OBTAINED FROM APPROVED SUBMISSION
- 02 - ALL ORIGINAL DRAWINGS CREATED BY SYM ARCHITECTURE

AS PROPOSED

As Proposed - First Floor Plan

Scale 1:200

 

As Proposed - Second Floor Plan
 Scale 1:200

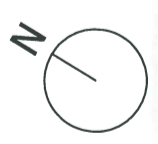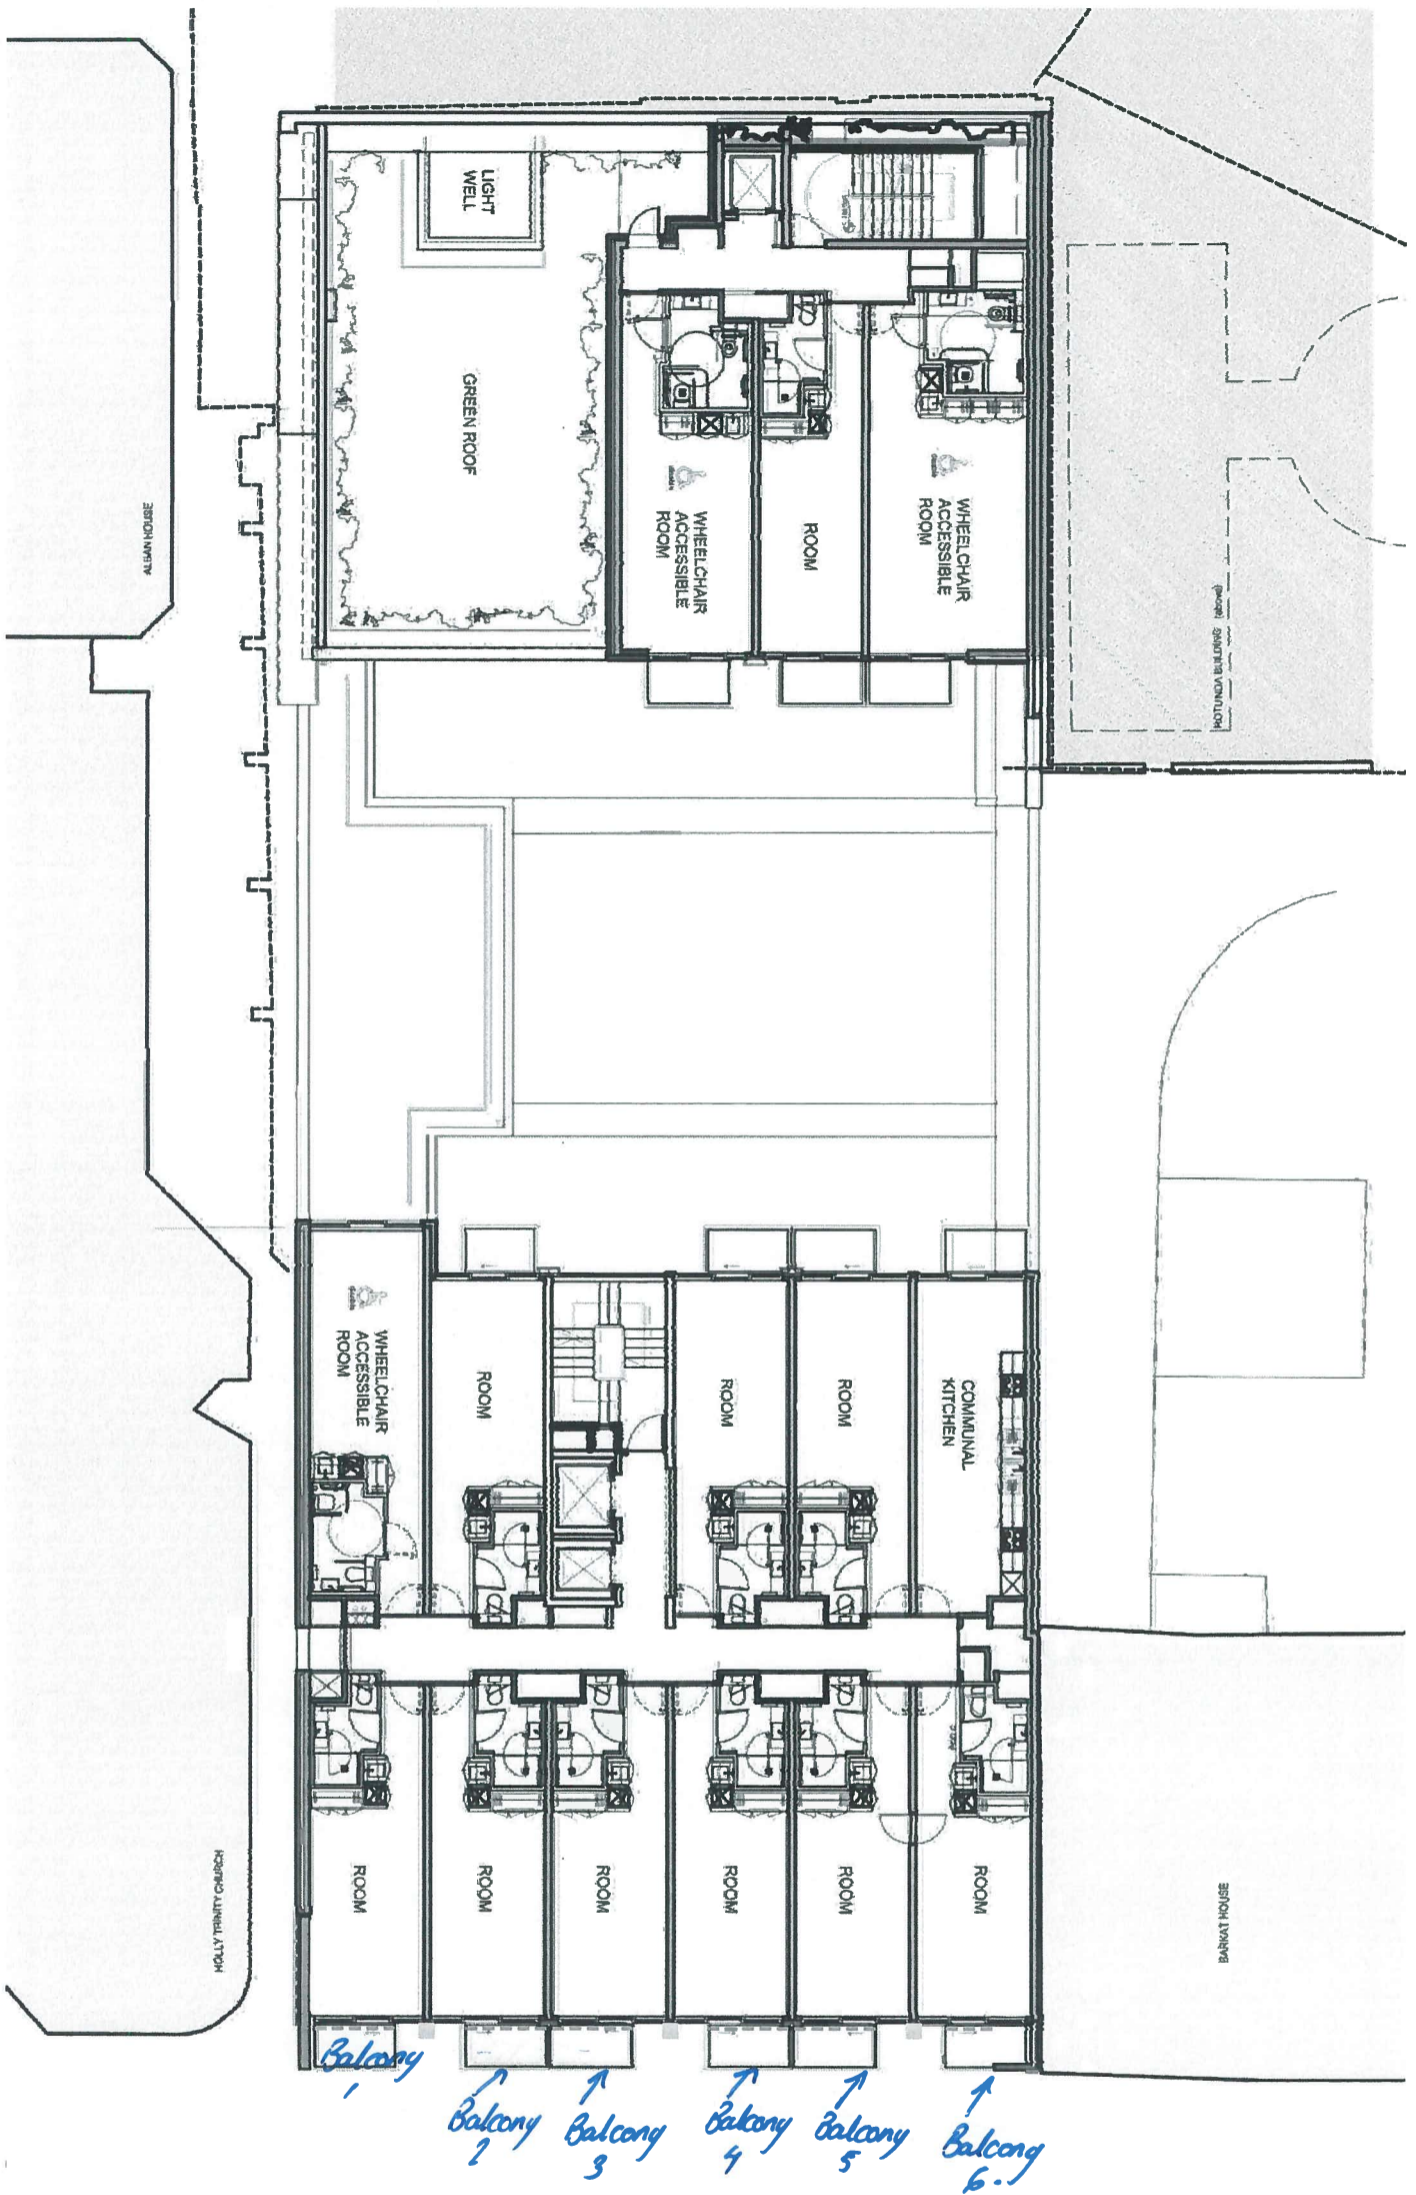

<p>Lighting Legend</p> <ul style="list-style-type: none"> L1 - WALL MOUNTED CUBE LIGHTING L2 - LED STRIP LIGHTING TO UNDERSIDE OF BALCONIES L3 - LINEAR LUMINAIRE FOR FACADE L4 - RECESSED DOWNLIGHT 	<p>Drawing Notes</p> <ul style="list-style-type: none"> 01 - DRAWINGS EXTRACTED FROM APPROVED SUBMISSION REFERENCE 2018/0587 02 - ALL ORIGINAL DRAWINGS CREATED BY SIAW ARCHITECTURE
---	---

AS PROPOSED

SCALE 1:200
SCALE 1:1

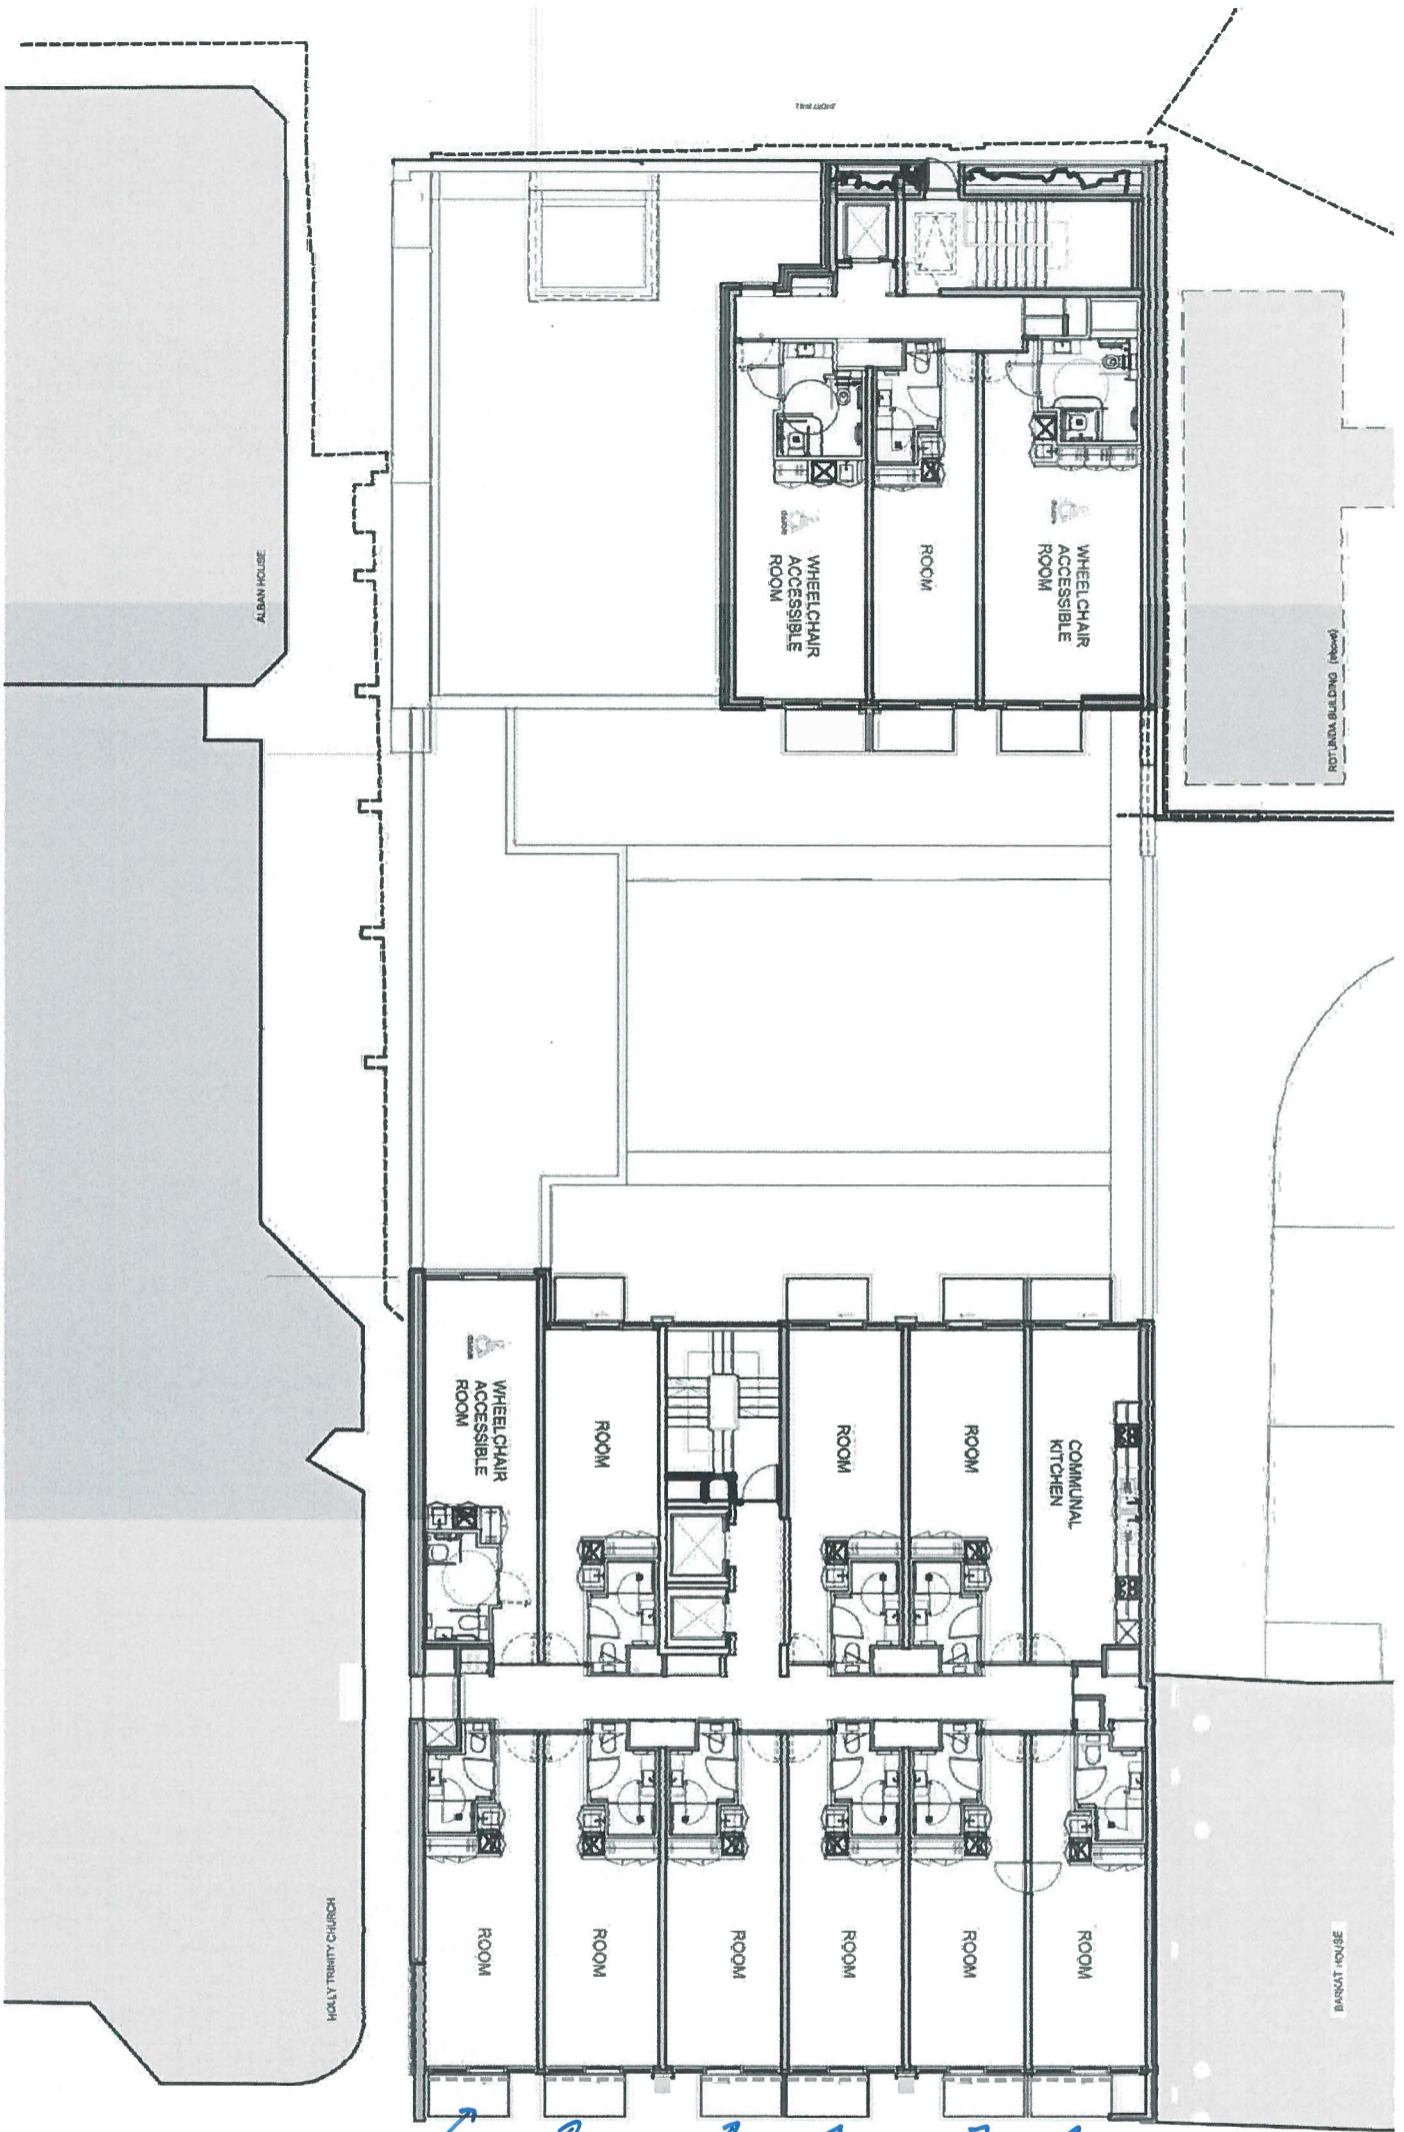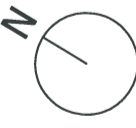

Balcony 1
Balcony 2
Balcony 3
Balcony 4
Balcony 5
Balcony 6

Lighting Legend	
	L1 - WALL MOUNTED CUBE LIGHTING
	L2 - LED STRIP LIGHTING TO UNDERSIDE OF BALCONIES
	L3 - LINEAR LUMINAIRE FOR FACADE
	L4 - RECESSED DOWNLIGHT


Drawing Notes

01 - DRAWINGS EXTRACTED FROM APPROVED SUBMISSION REFERENCE 2018/0508/01/01
02 - ALL ORIGINAL DRAWINGS CREATED BY S/AM ARCHITECTURE

AS PROPOSED

As Proposed - Third Floor Plan
Scale 1:200

SCALE 1:200
SCALE 1:1

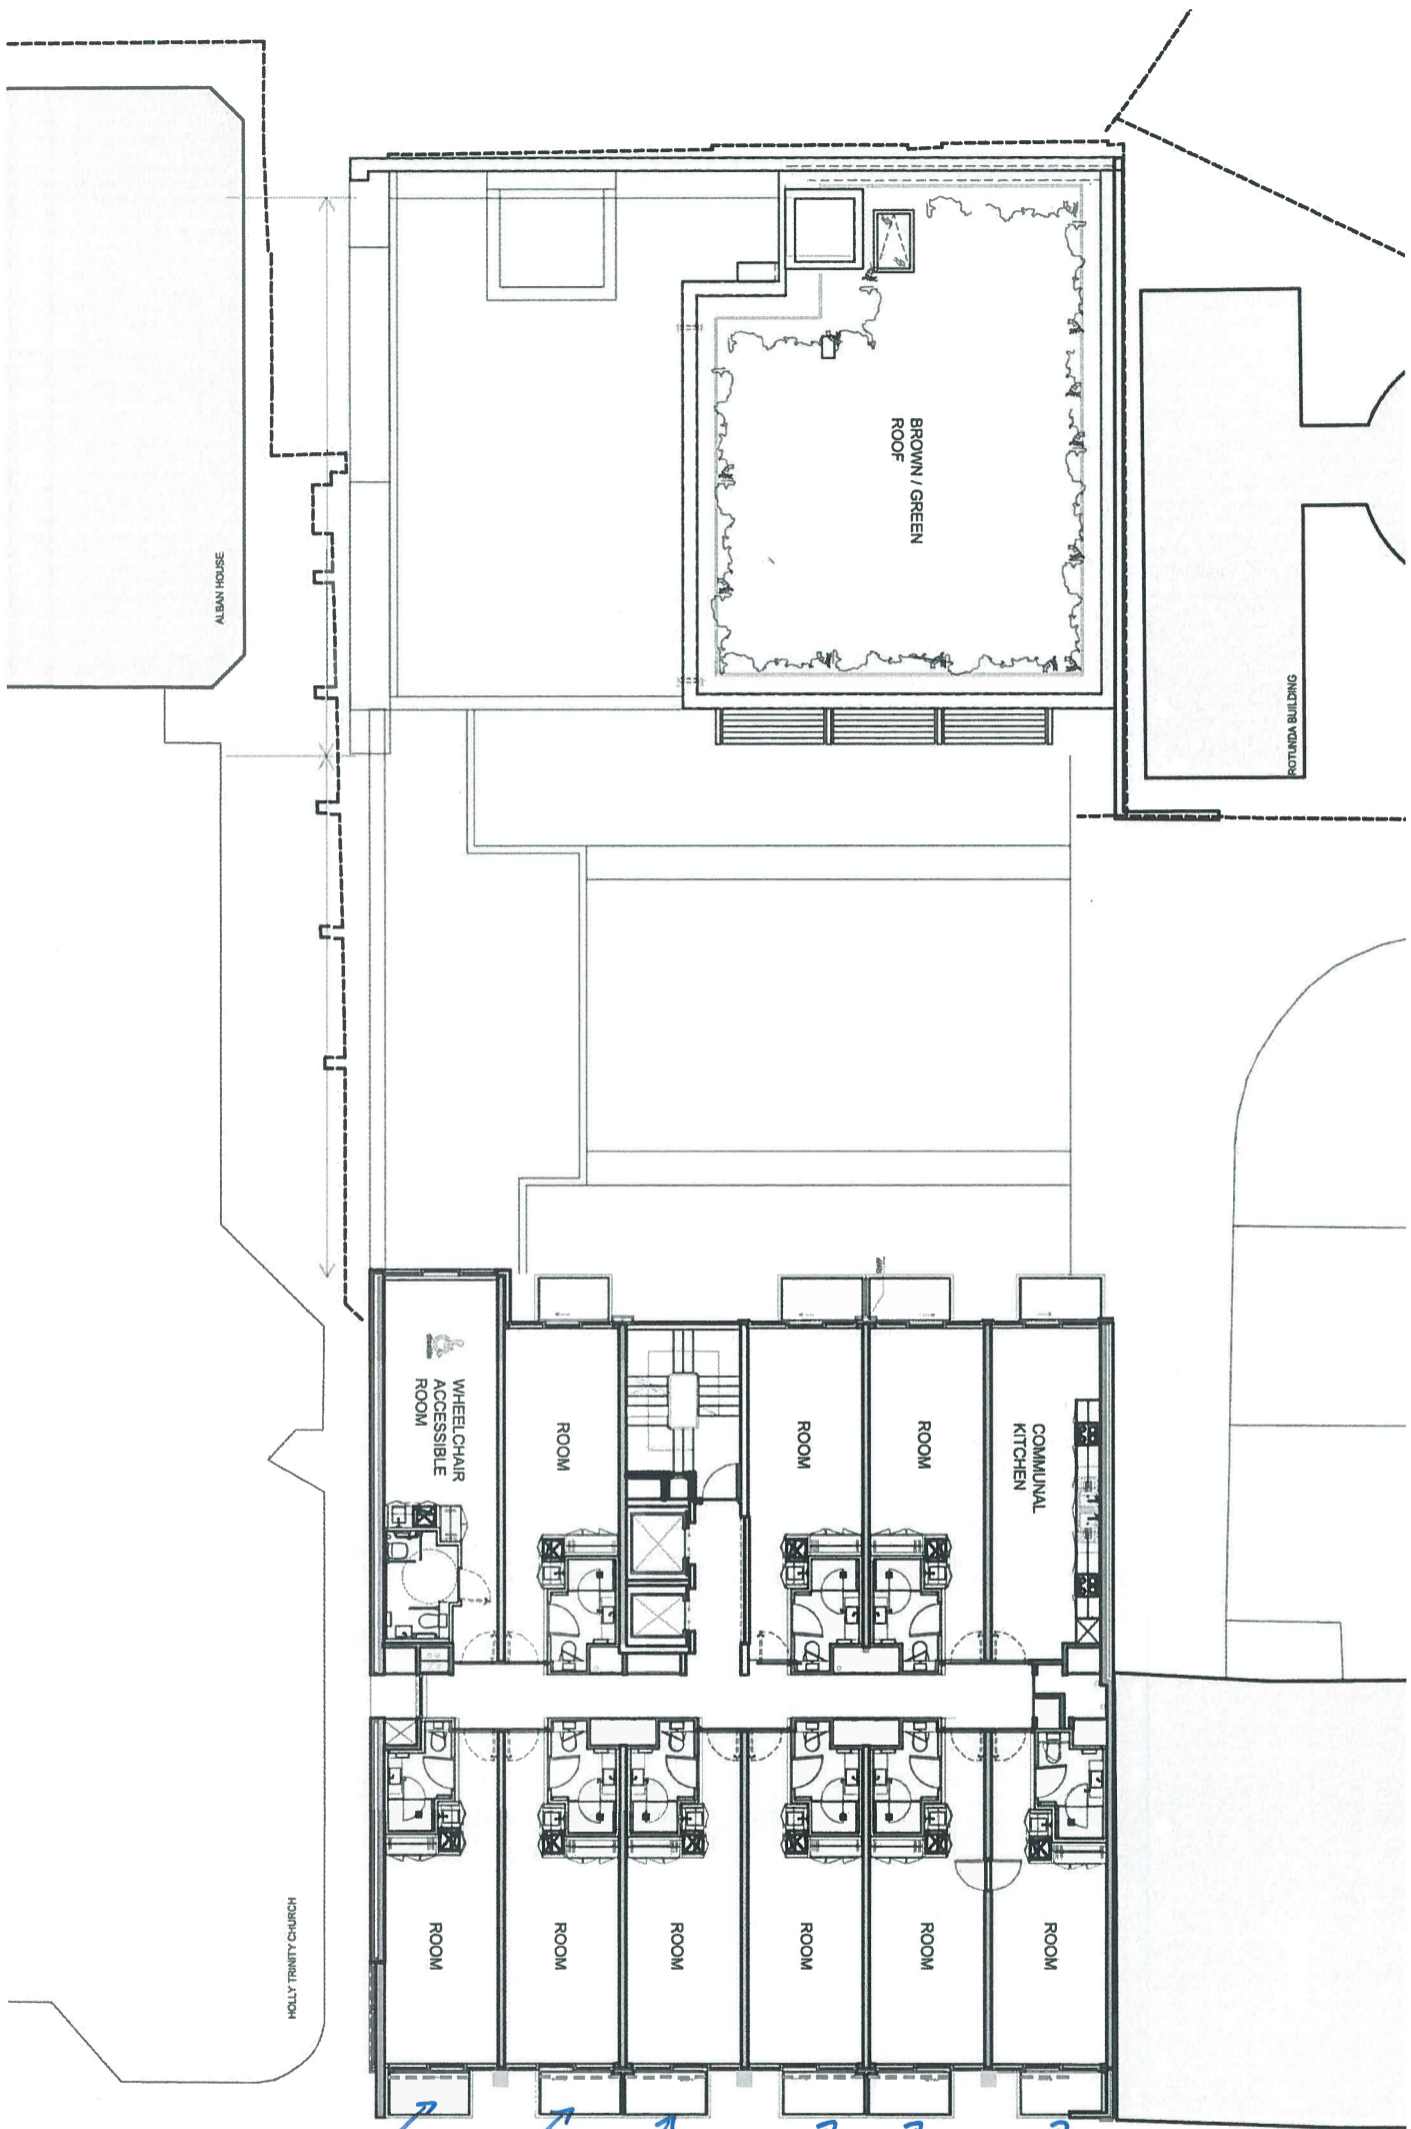

Balcony 1
Balcony 2
Balcony 3
Balcony 4
Balcony 5
Balcony 6

Lighting Legend

- L1 - WALL MOUNTED CURB LIGHTING
- L2 - LED STRIP LIGHTING TO UNDERSIDE OF BALCONIES
- L3 - LINEAR LUMINAIRE FOR FACADE
- L4 - RECESSED DOWNLIGHT


Drawing Notes

- 01 DRAWINGS EXTRACTED FROM APPROVED SUBMISSION
- 02 ALL ORIGINAL DRAWINGS CREATED BY SANW ARCHITECTURE

AS PROPOSED

AS Proposed - Fourth Floor Plan
Scale 1:200

SCALE 1:200
SCALE 1:1

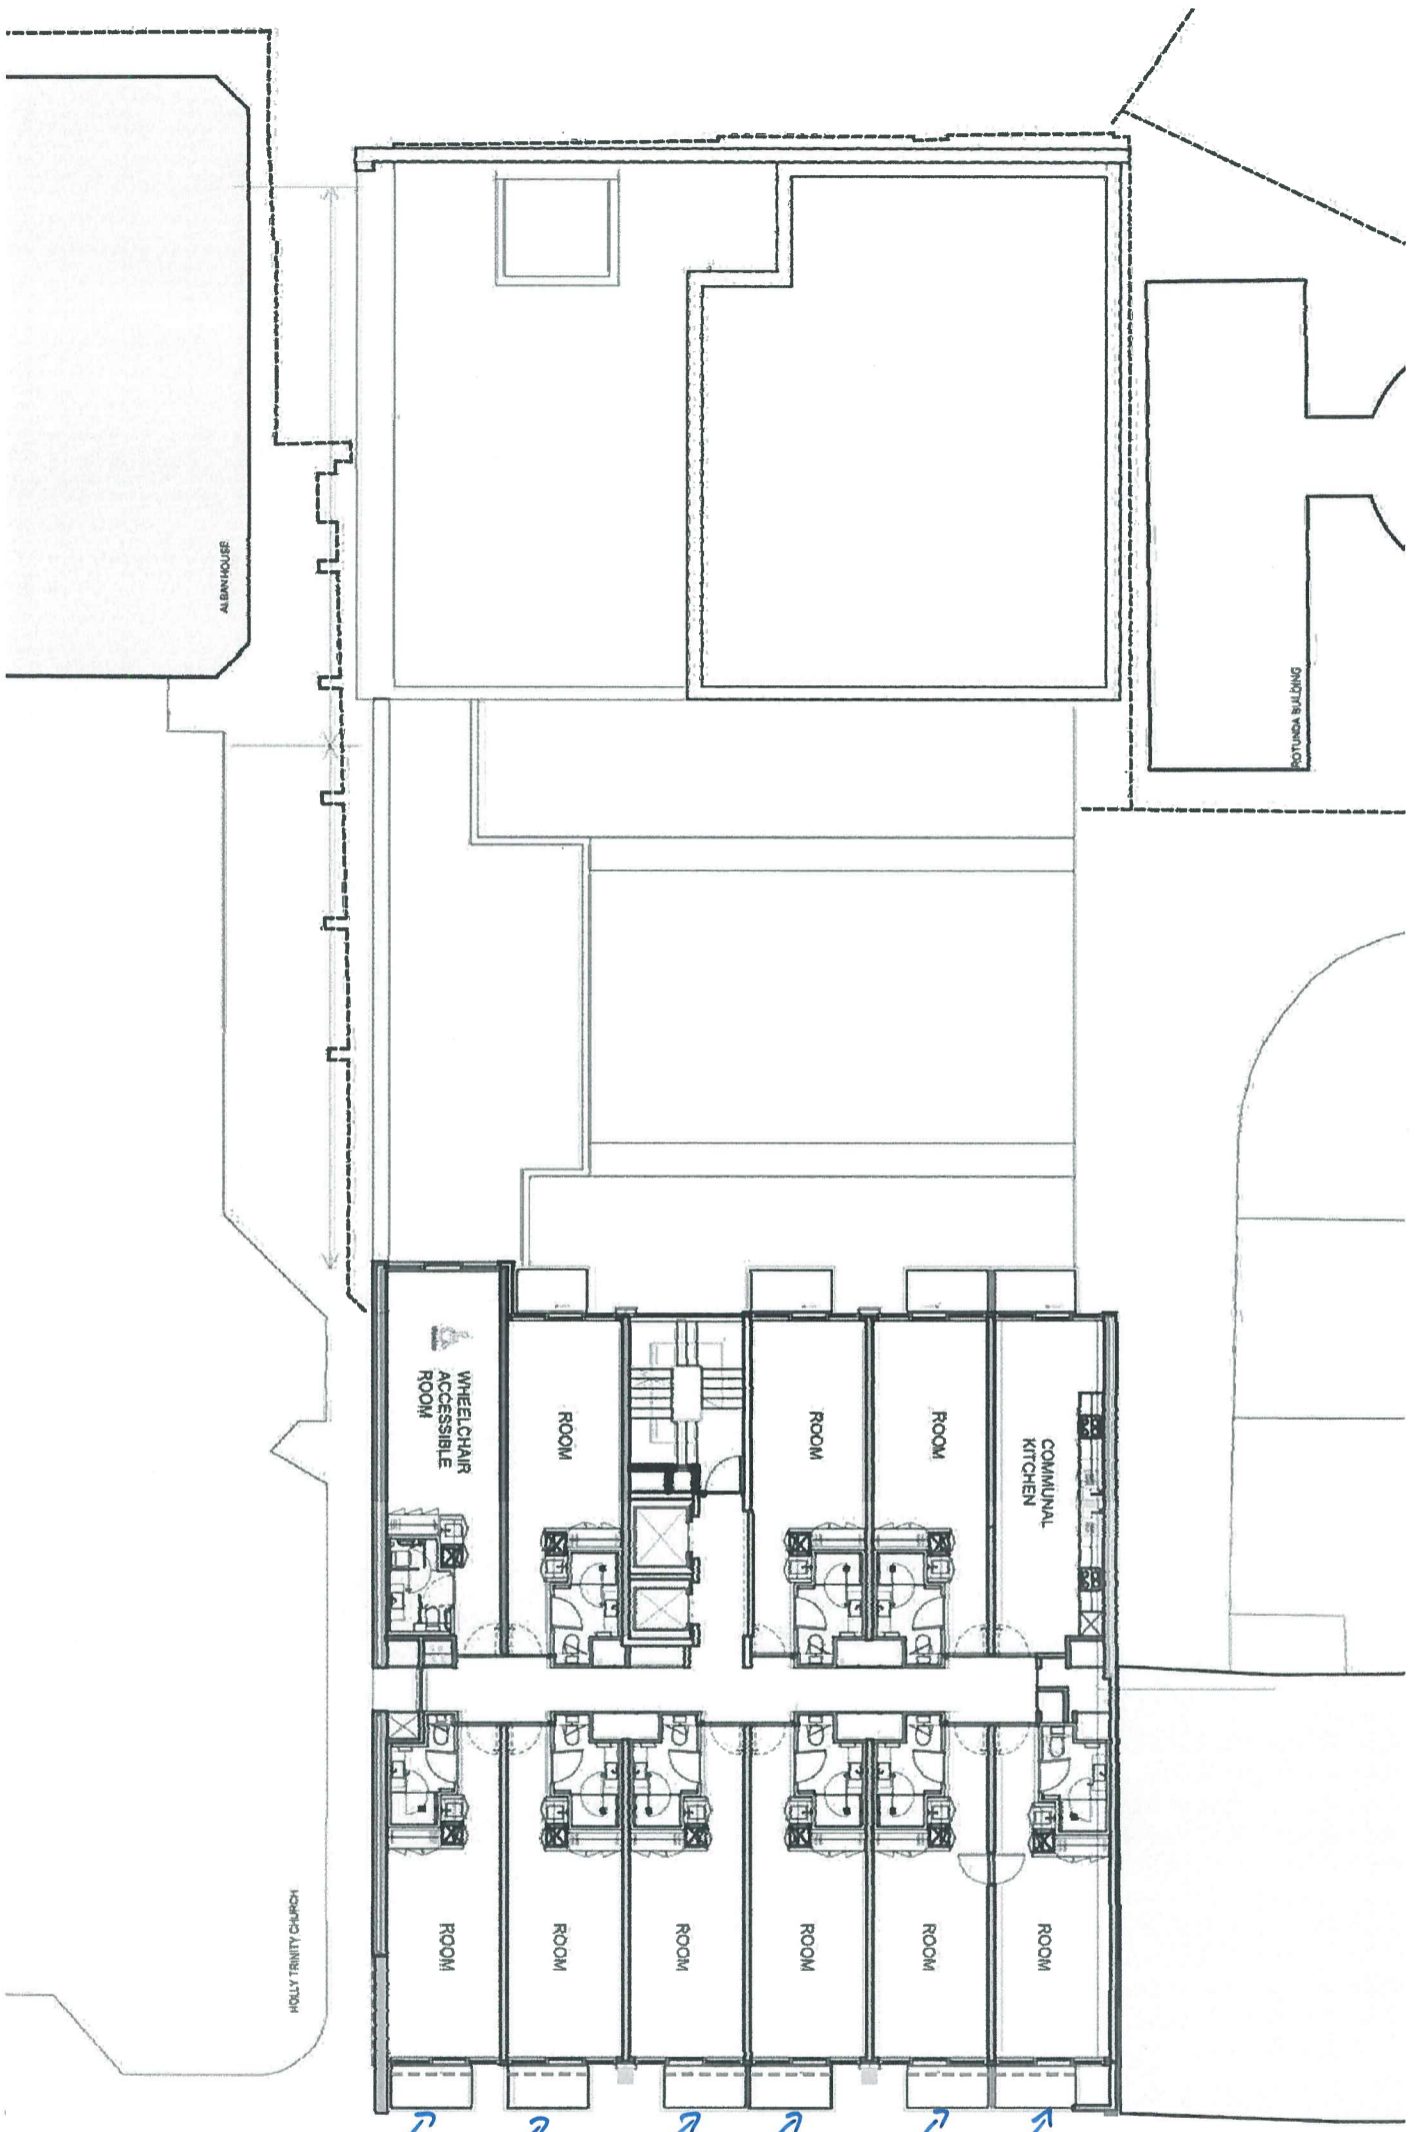

Balcony 1
Balcony 2
Balcony 3
Balcony 4
Balcony 5
Balcony 6

Lighting Legend

- L1 - WALL MOUNTED CURB LIGHTING
- L2 - LED STRIP LIGHTING TO UNDERSIDE OF BALCONIES
- L3 - LINEAR LUMINAIRE FOR FACADE
- L4 - RECESSED DOWNLIGHT



Drawing Notes

- 01 - DRAWINGS EXTRACTED FROM APPROVED SUBMISSION REFERENCE 2016/0505/01
- 02 - ALL ORIGINAL DRAWINGS CREATED BY 'SIW ARCHITECTURE'

AS PROPOSED

As Proposed - Fifth Floor Plan
Scale 1:200

SCALE 1:200
SCALE 1:1

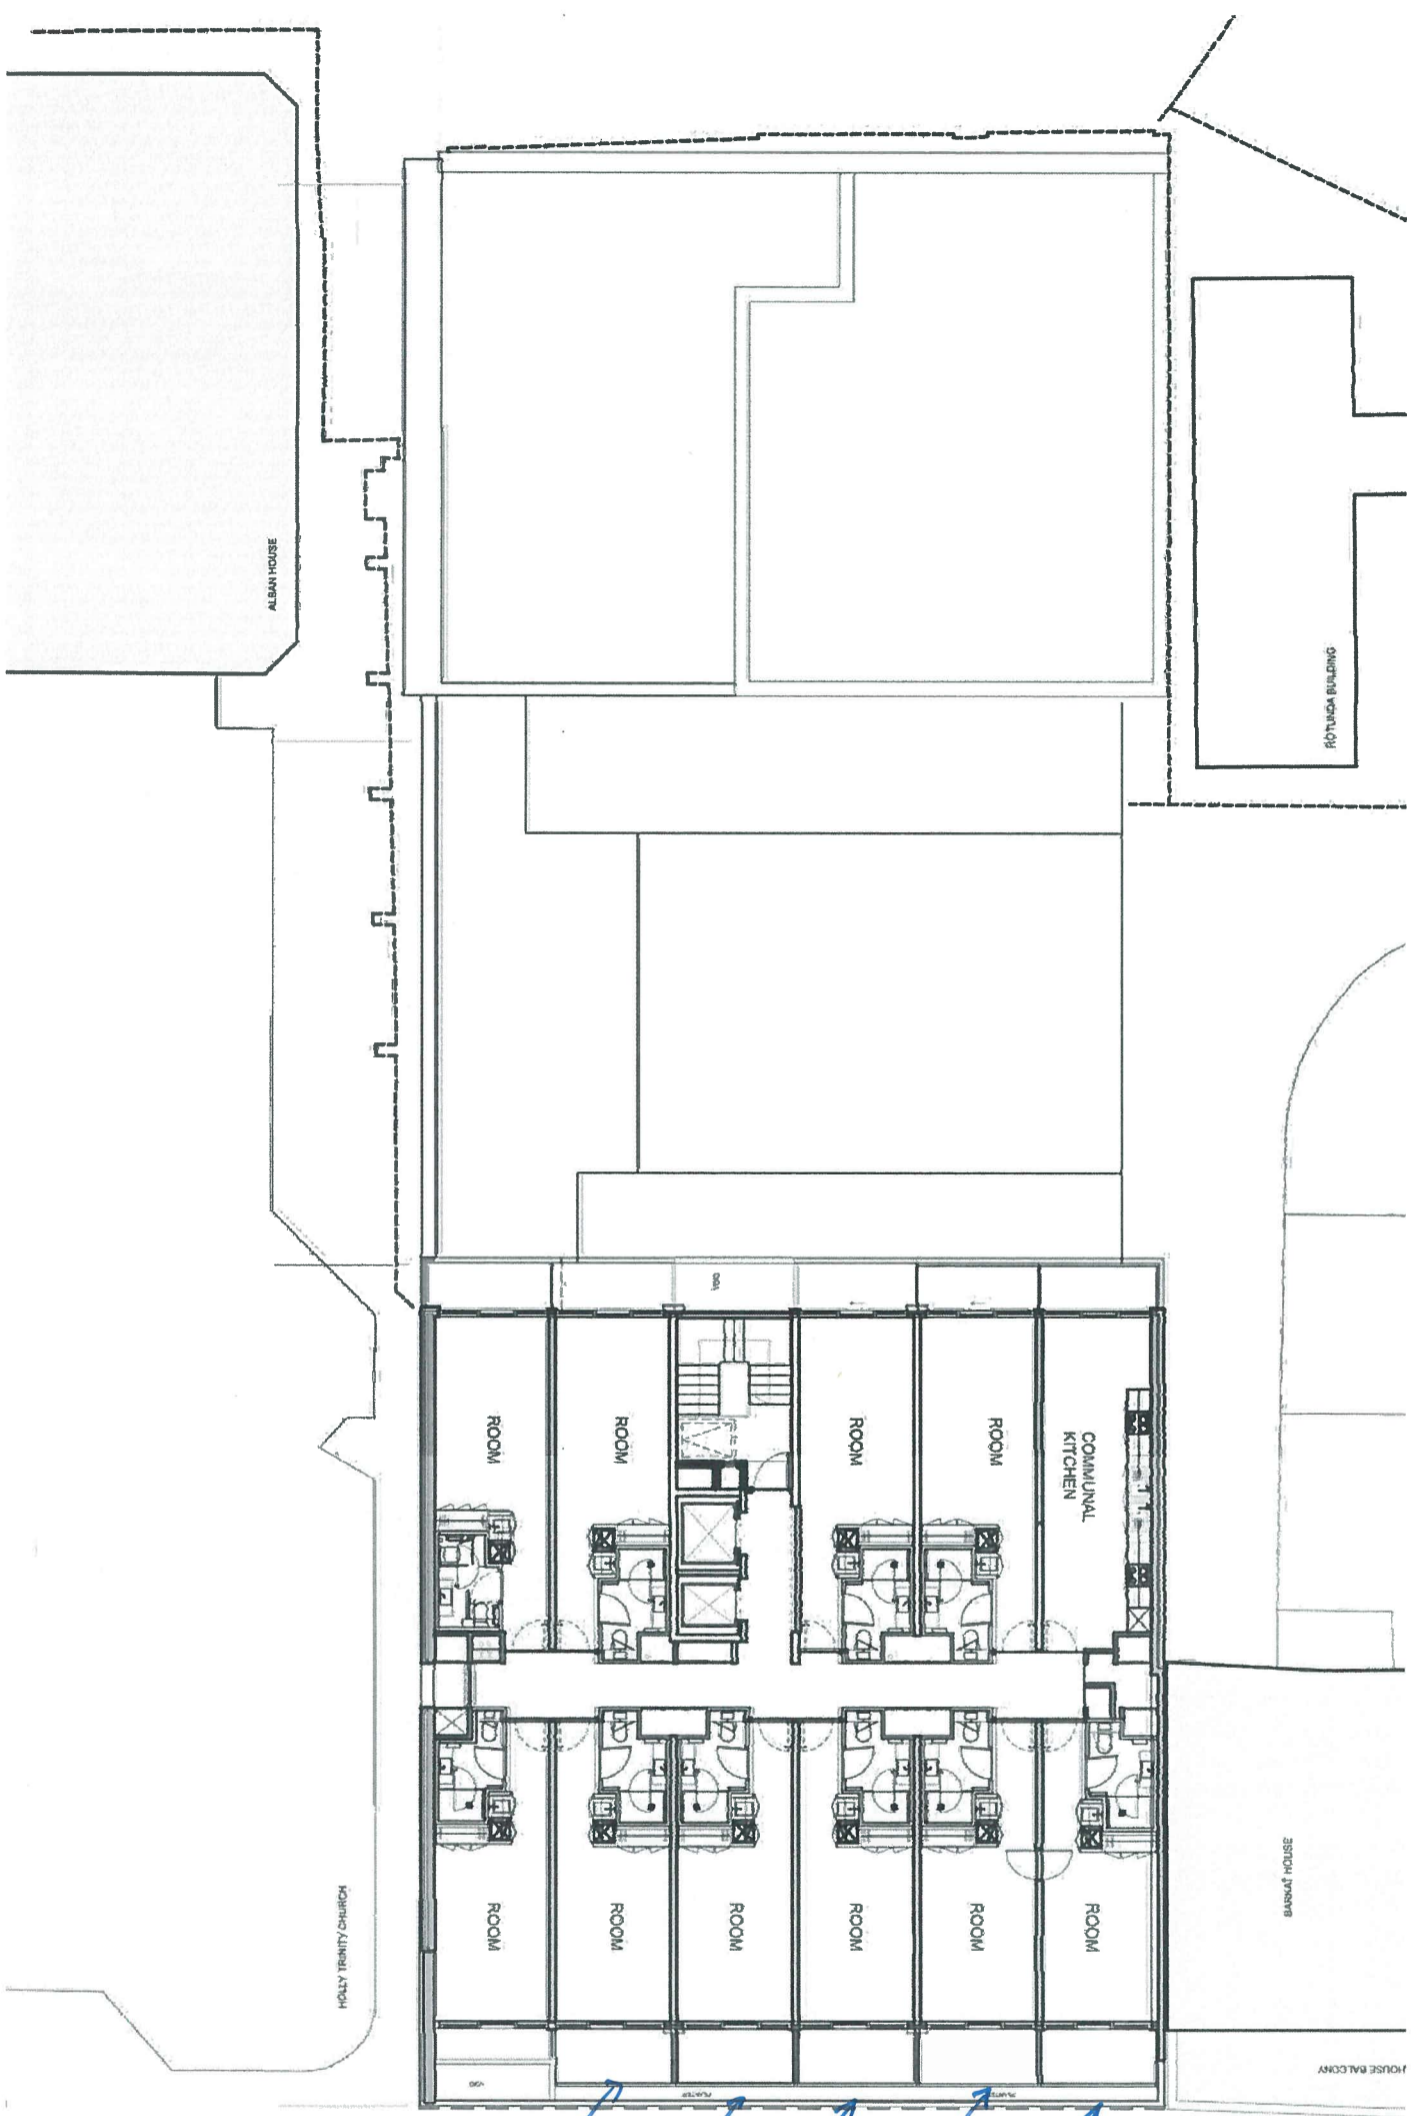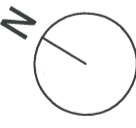

Balcony 1
Balcony 2
Balcony 3
Balcony 4
Balcony 5.

Lighting Legend

	L1 - WALL MOUNTED CUBE LIGHTING
	L2 - LED STRIP LIGHTING TO UNDERSIDE OF BALCONIES
	L3 - LINEAR LUMINAIRE FOR FACIOL
	L4 - RECESSED DOWNLIGHT

Drawing Notes

01 - DRAWINGS EXTRACTED FROM APPROVED SUBMISSION REFERENCE 2016/0505/PA
02 - ALL ORIGINAL DRAWINGS CREATED BY SIAW ARCHITECTURE

AS PROPOSED

As Proposed - Sixth Floor Plan
Scale 1:200