
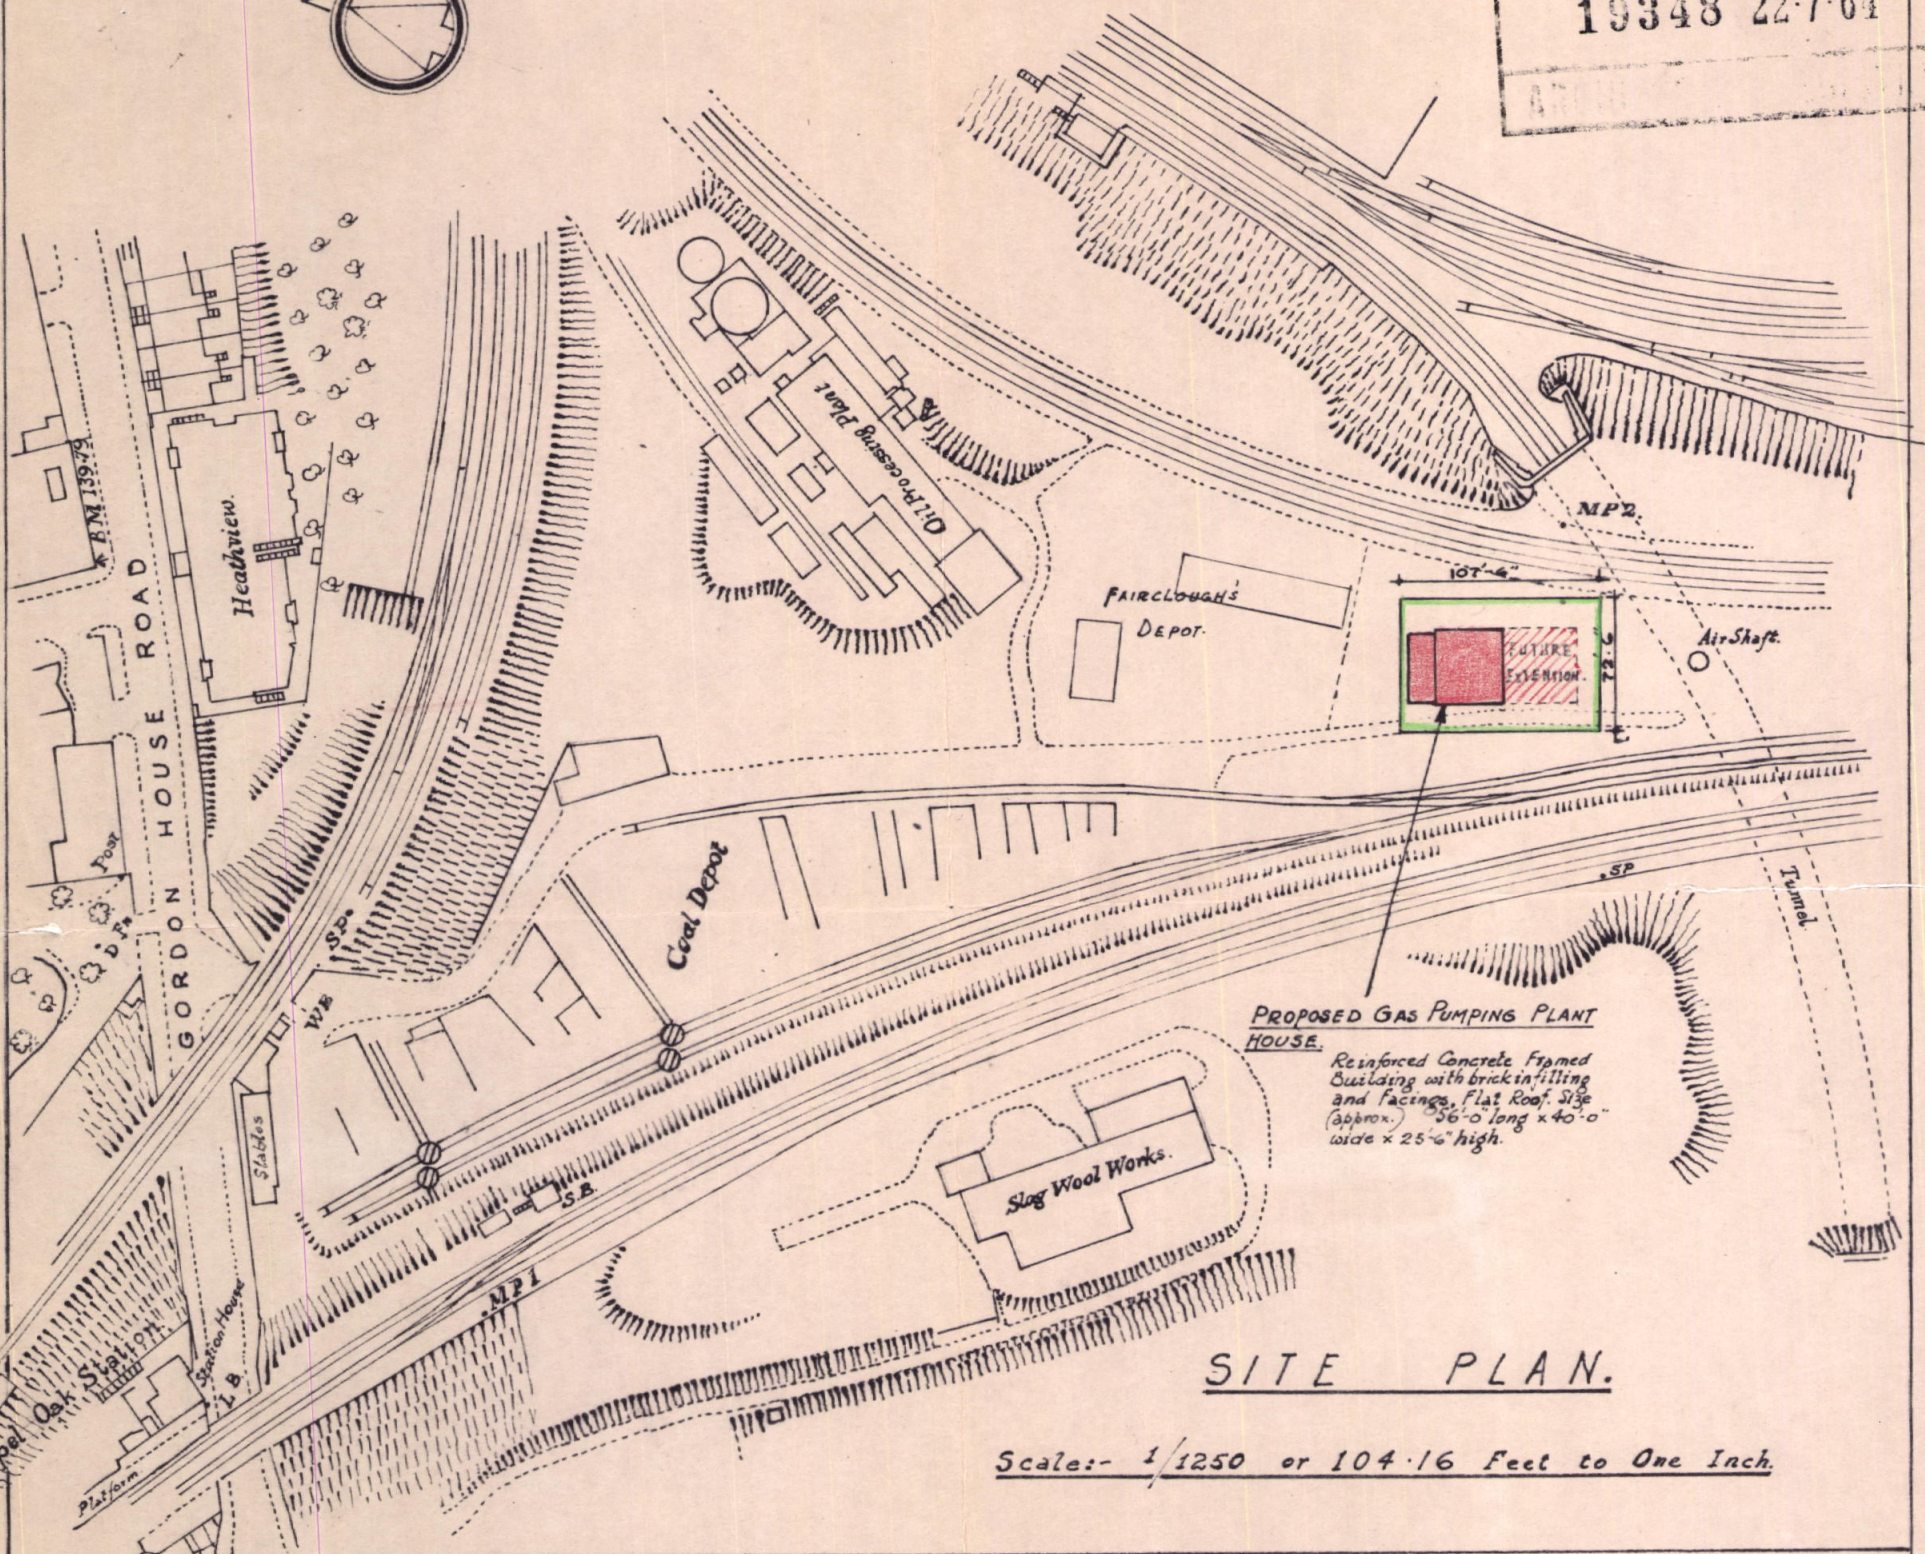


LONDON COUNTY COUNCIL
19348 22-7-64

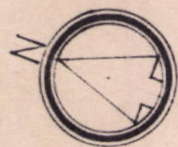

SITE PLAN.

Scale:- 1/1250 or 104.16 Feet to One Inch.

GAS PUMPING PLANT HOUSE
AT GOSPEL OAK
NORTH THAMES GAS BOARD.

CHIEF ENGINEER'S DEPARTMENT					
DRAWN	TRACED	CHECKED	PASSED	APPROVED	DATE
MR.	-	MR.	MR.	MR.	13-7-64
JOB NO: KG. 494.					
DRAWING NO: KG. 494/40.					