
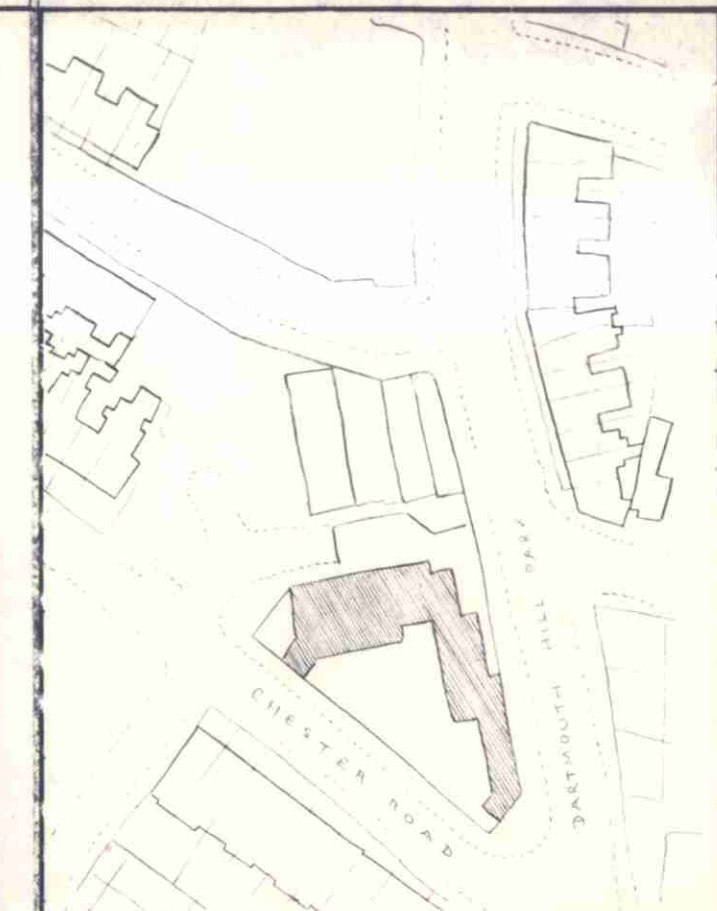


EACH UNIT OF GRID
REPRESENTS 400 MM
NUMBERS SHOWN ON
GRID LINES ARE FOR
REFERENCE ONLY

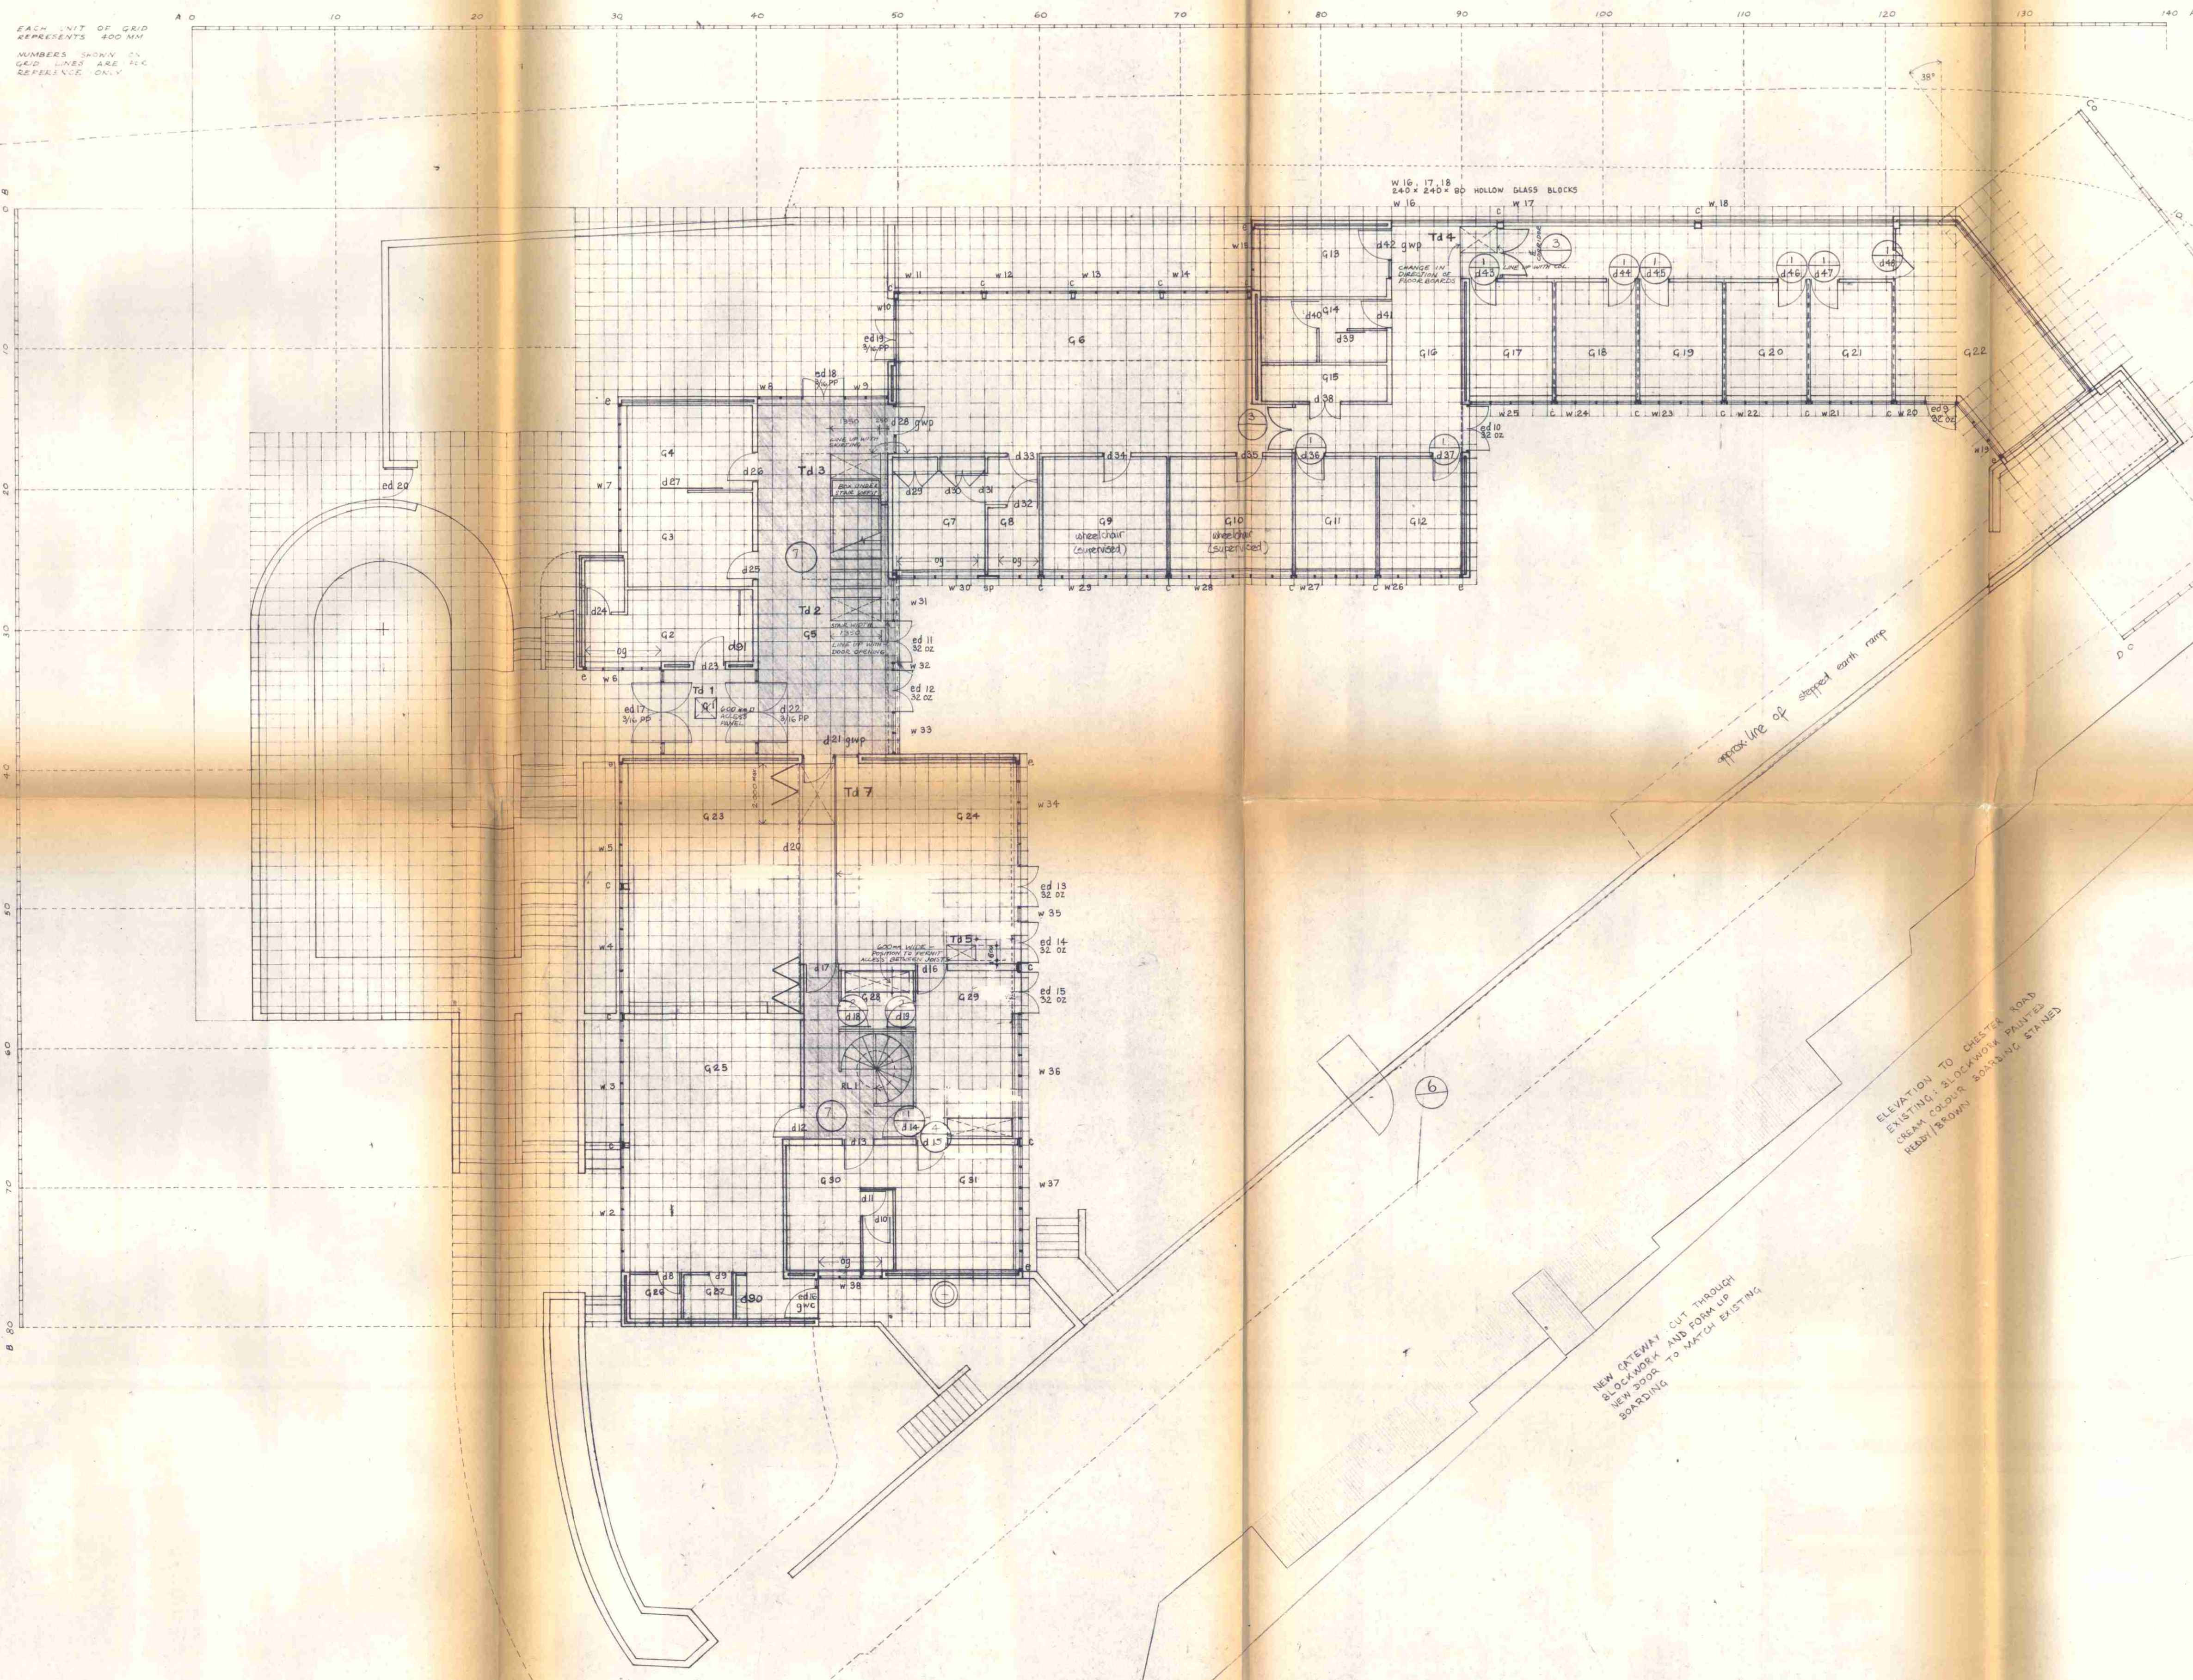

LOCATION PLAN 1:250

Revision	Date
A	codes 5,6,7 modified

JOHN WINTER AND ASSOCIATES
80 LAMBLE STREET
LONDON NW5

2 CHESTER ROAD, N19
HOME FOR THE MENTALLY
HANDICAPPED

FIRE PRECAUTIONS SURVEY
GROUND FLOOR PLAN
RECOMMENDATIONS

CTI/C11/14/B/31109.

scale 1:100 date Feb 80
LBC Director of Architecture copy negative
amended as necessary

CAM/59/5A