 


A circular purple ink stamp is located in the upper right quadrant of the document. The text "BOROUGH OF HASTINGS" is curved along the top inner edge, and "ENGINEER &amp; DEPARTMENT" is curved along the bottom inner edge. In the center of the stamp, the date "26 OCT 1964" is stamped in a straight line.


 
 
 










24' PROPELLER FAN AT 900 RPM.  
FORM "B" MOUNTED IN STANDARD  
M.S. CHAMBER.  
ELECTRIC SUPPLY: 220/240/1/50.

FOR ANGLE BRACKETS SEE  
SEPARATE DETAILS.

OUTLET FITTED WITH WIRE  
MESH GRID.

NOTE! ALL EXTERNAL DUCTWORK  
IN 10 g. G. S. S.

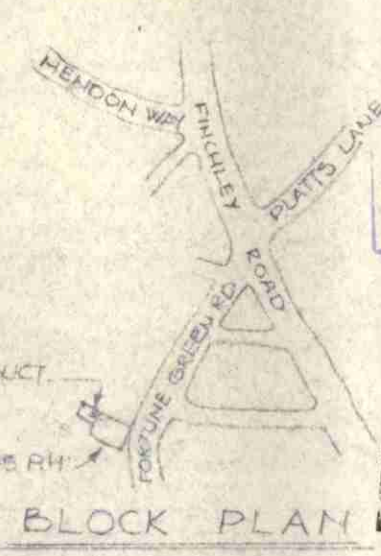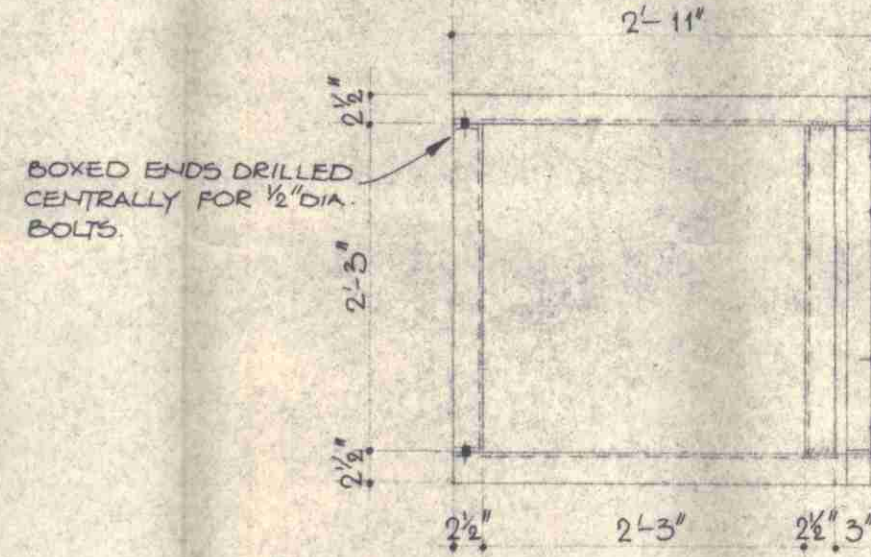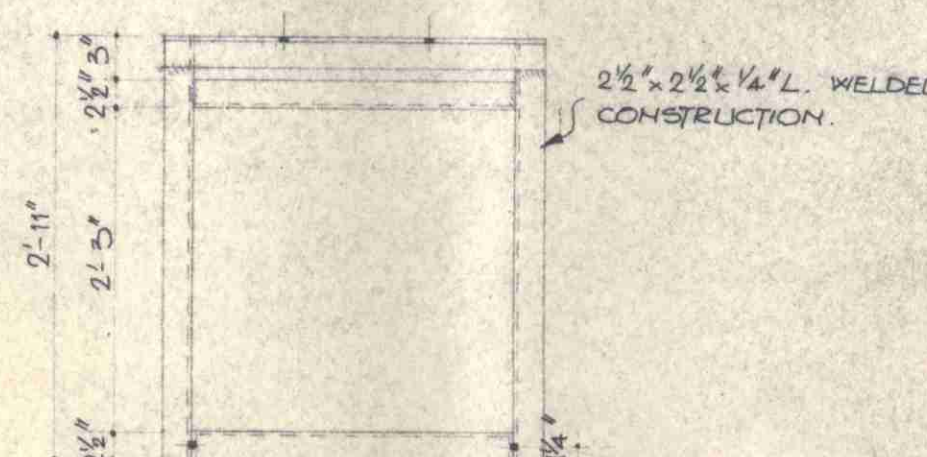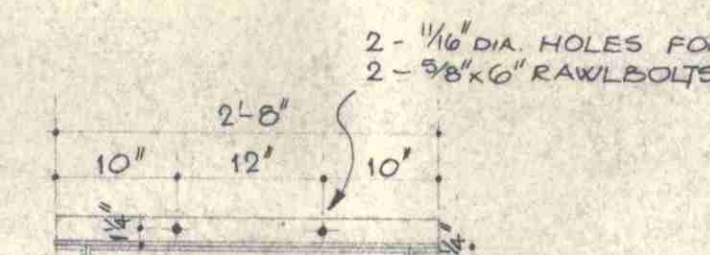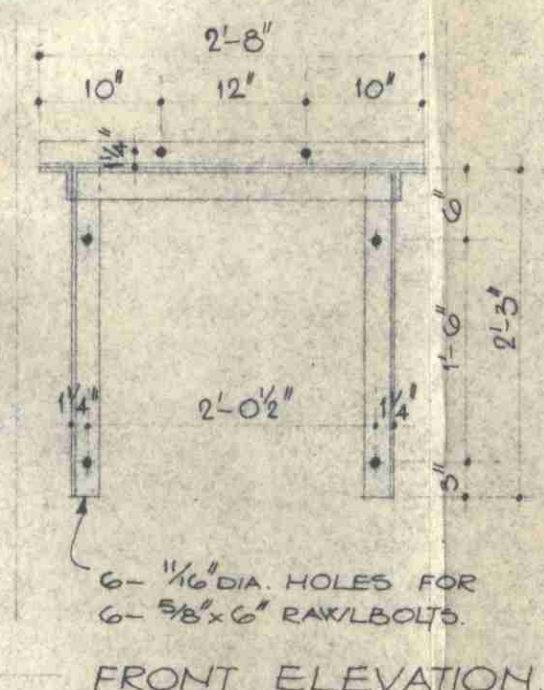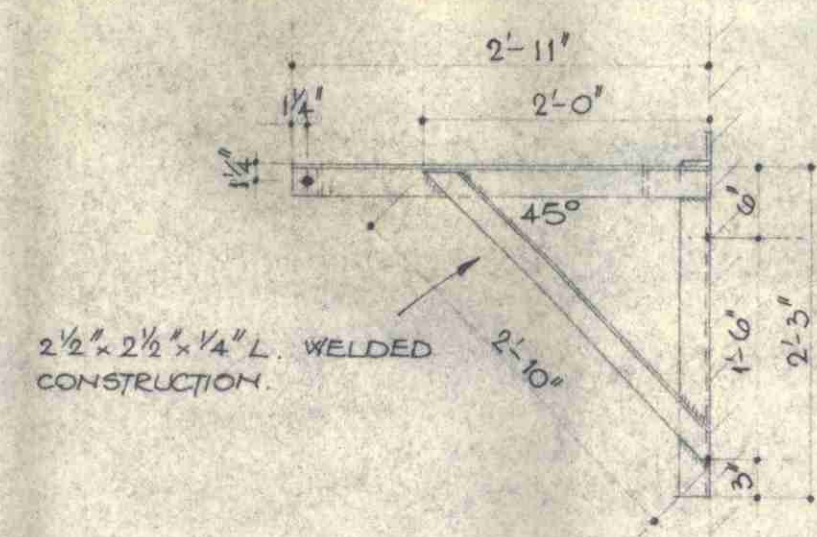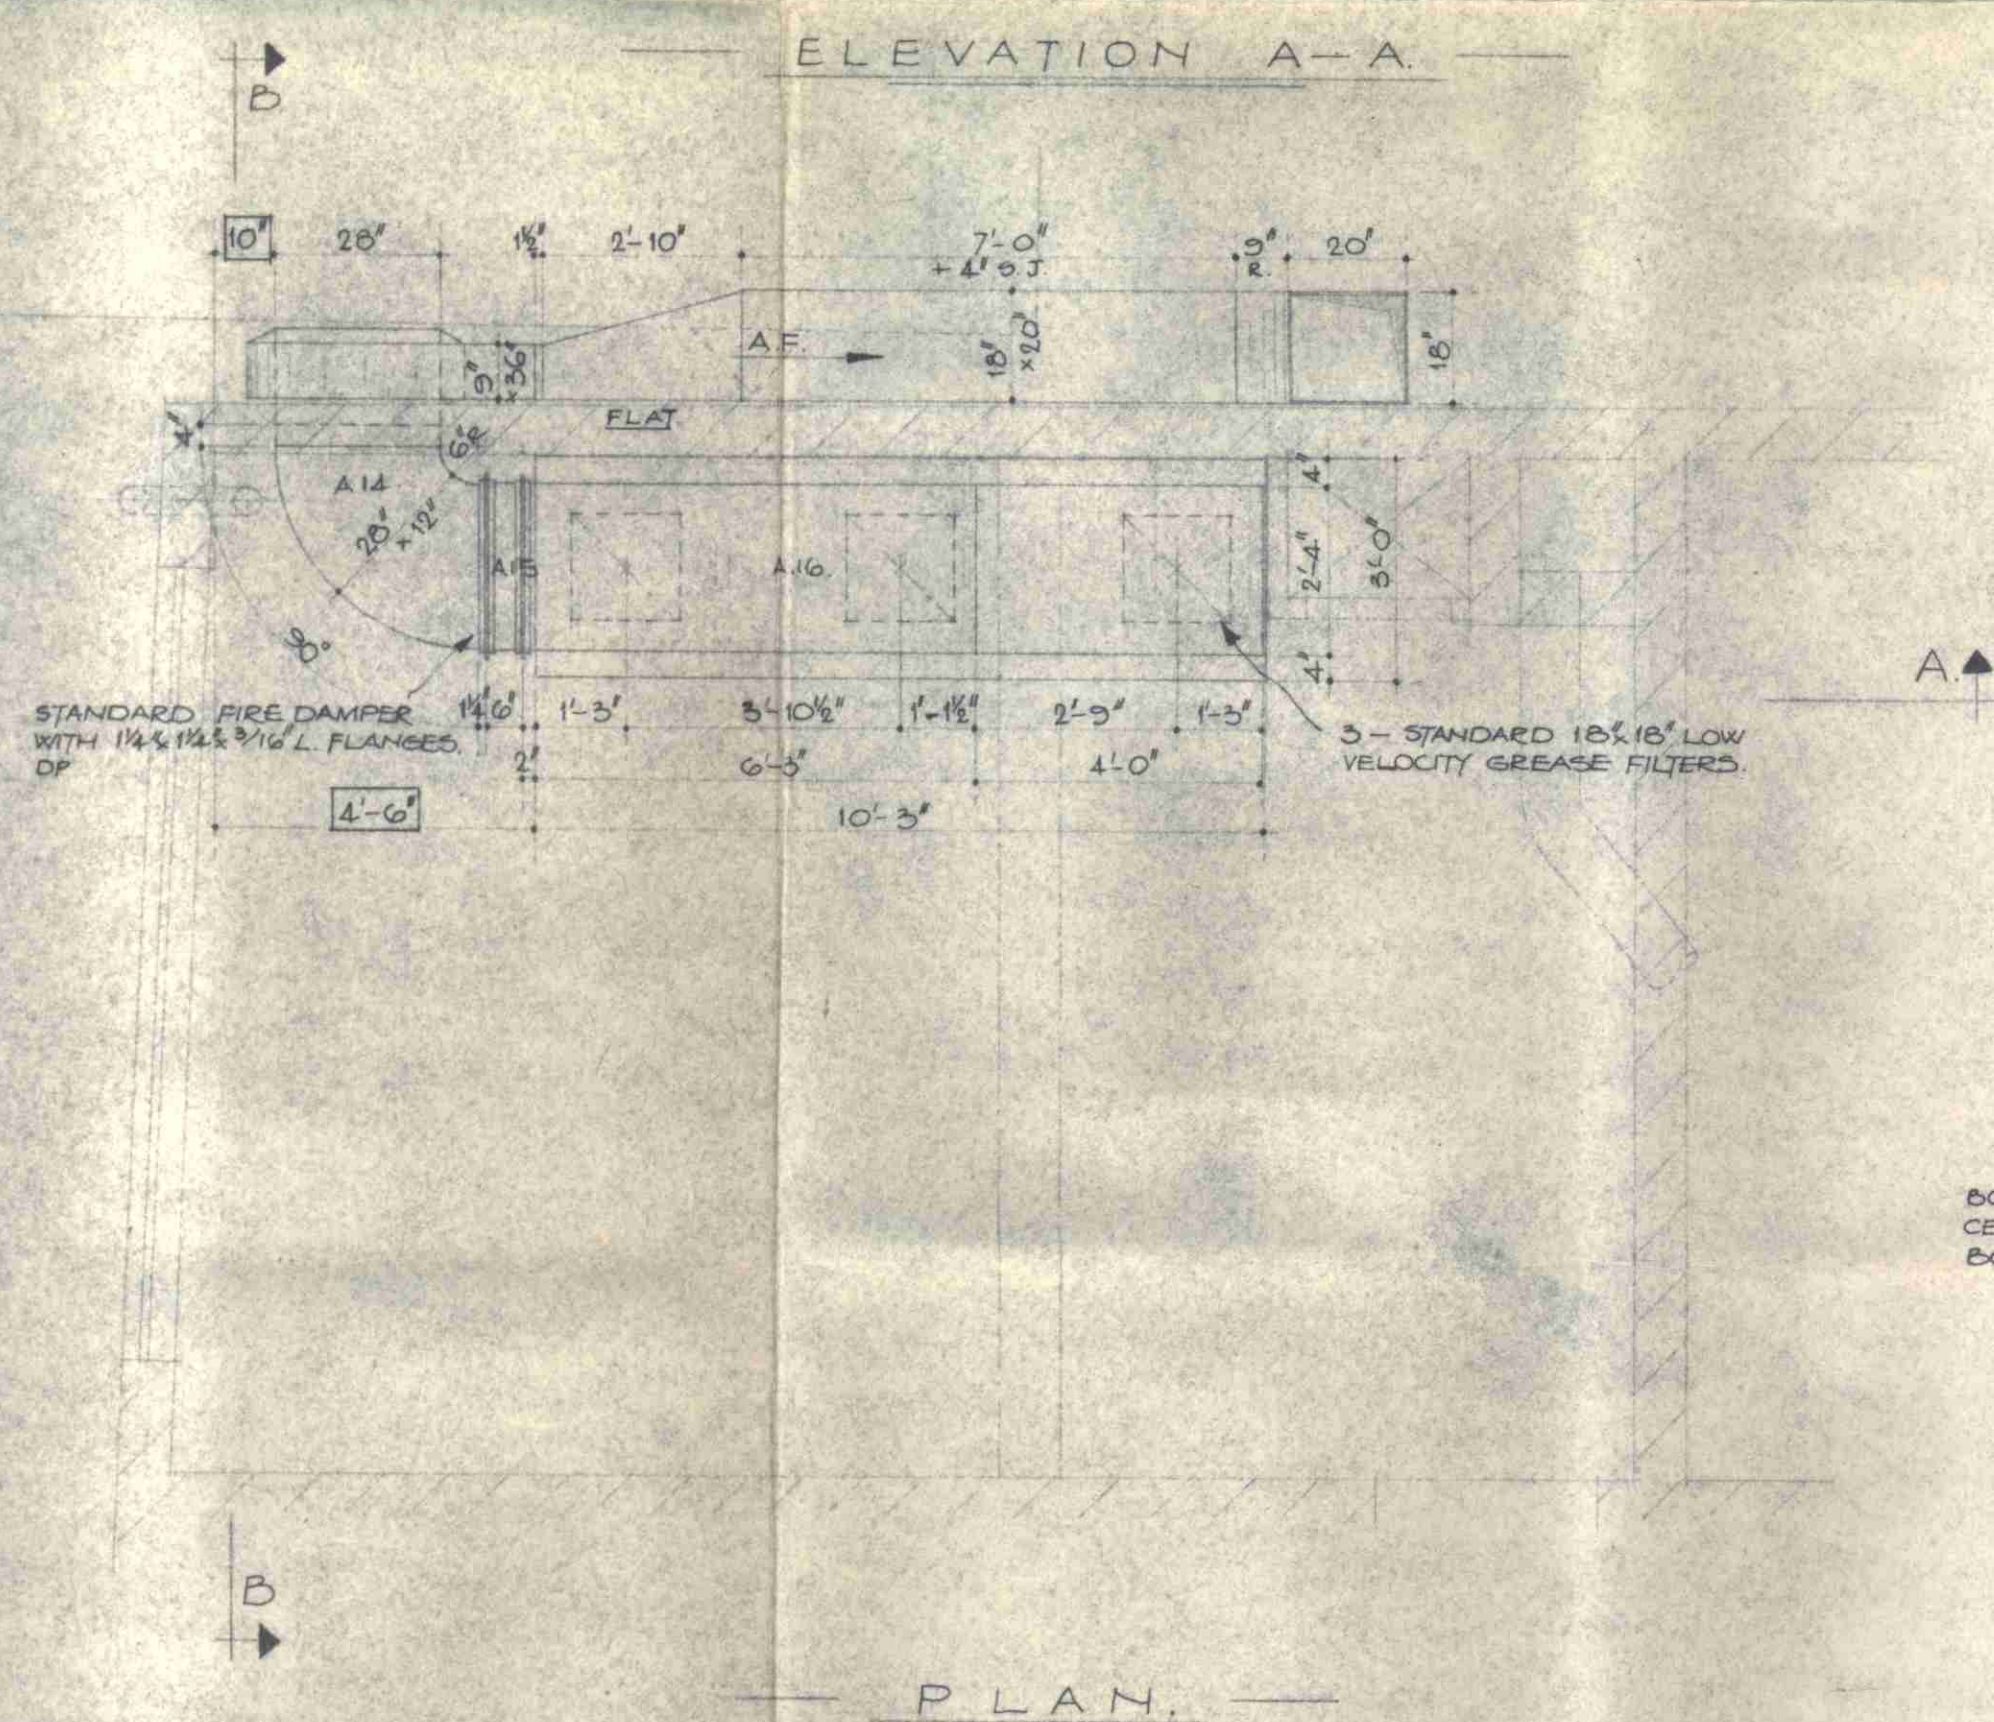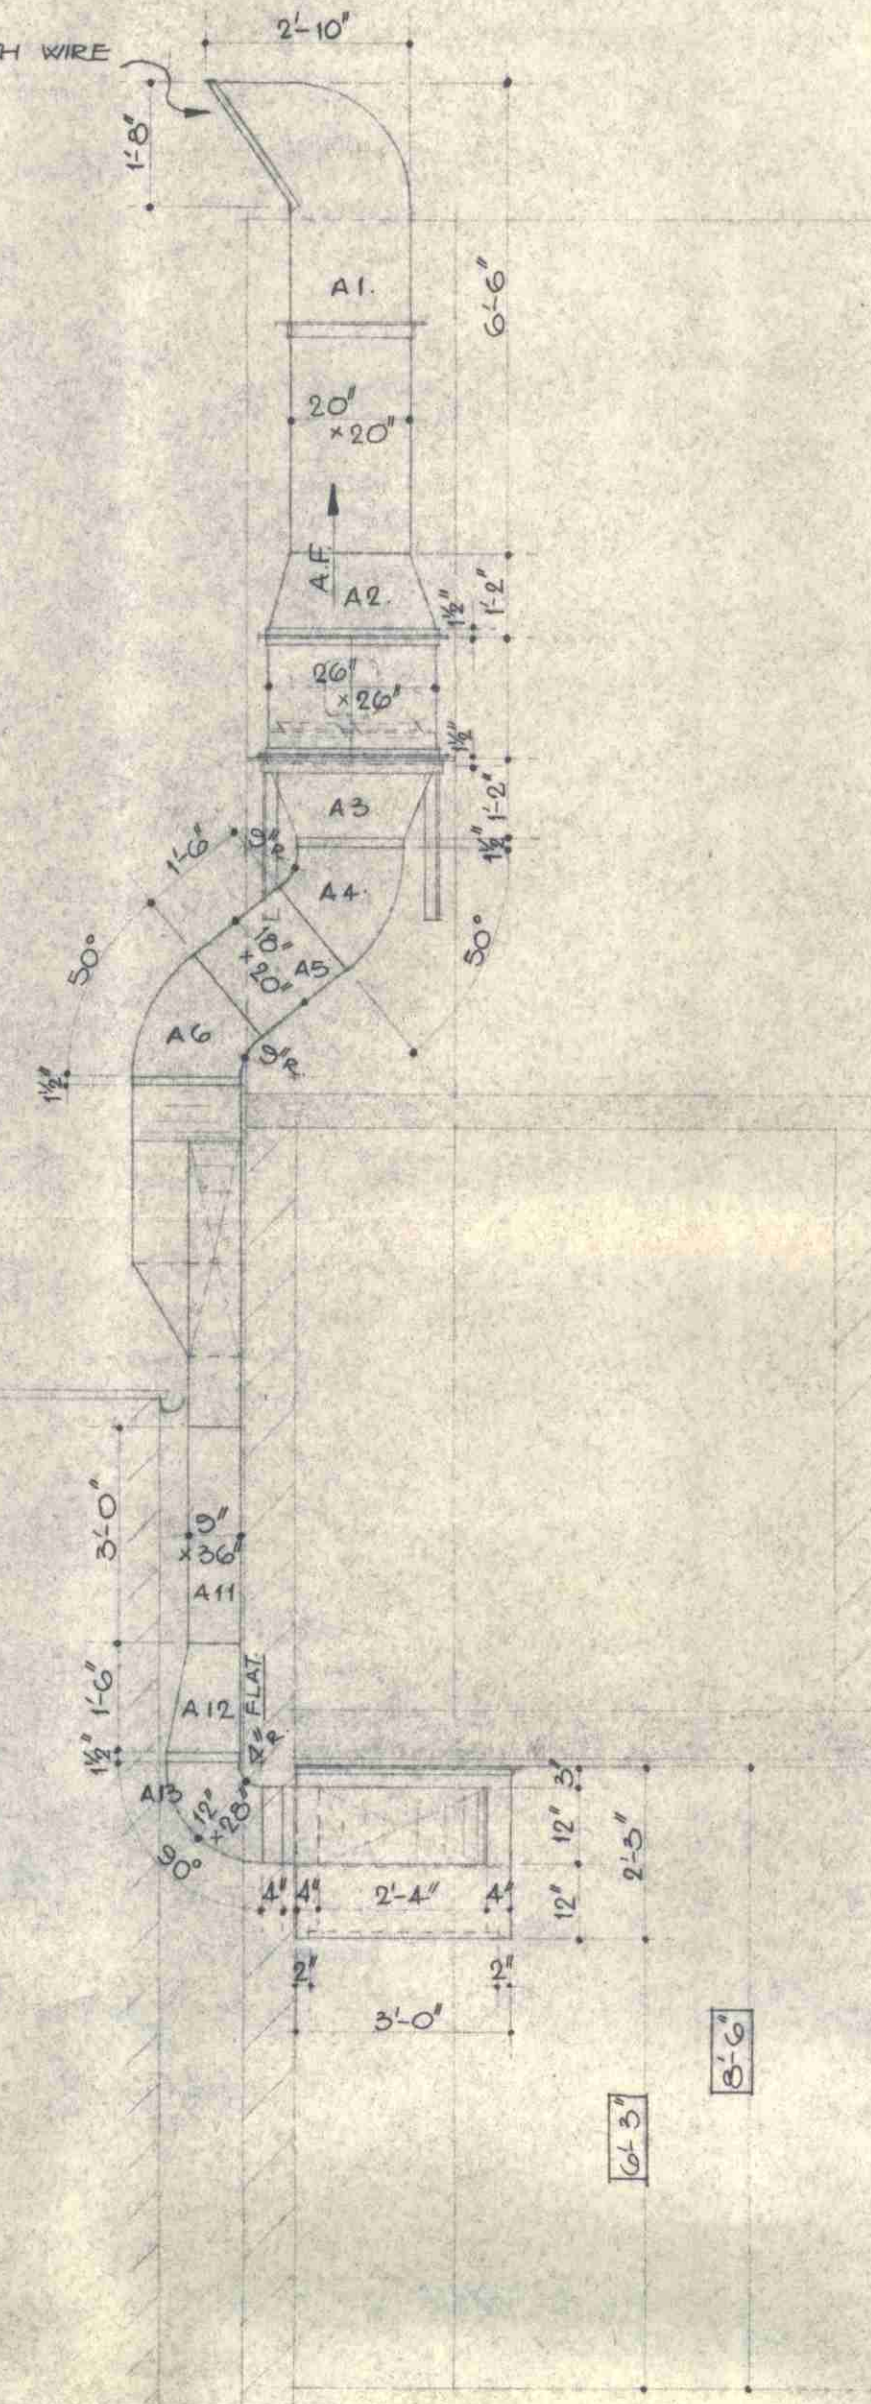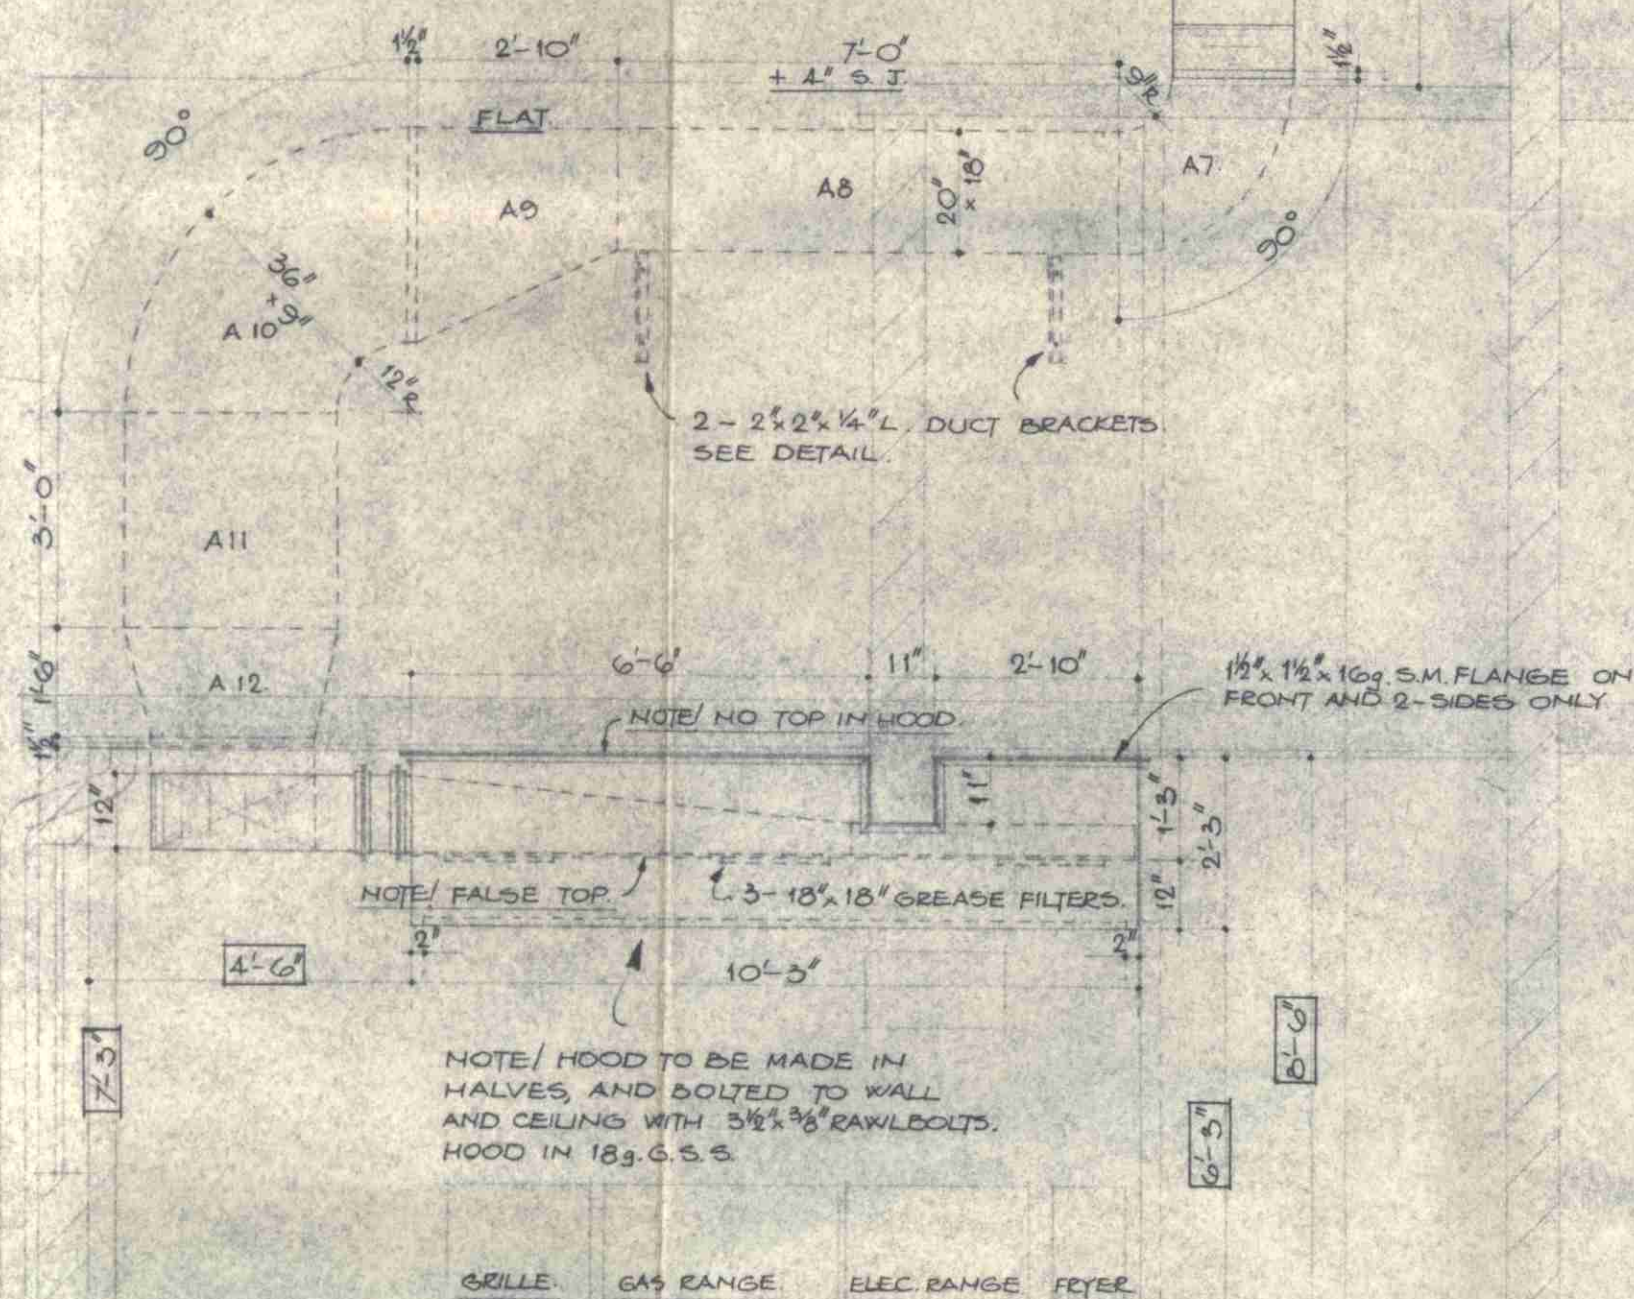

PL-14 NO. 1731  
DATE 1 DEC 1964

LONDON COUNTY COUNCIL  
27229 22-10-64

HEAT, INSULATION, & VENTILATION, Co. Ltd.  
9 BROWNLOW STREET, LONDON, W.C.1.

DRAWN. AB DATE. 24-6-64  
CHECKED SCALE  $\frac{3}{8}'' = \frac{3}{4}'' = 1'$

DRG. No. 2822 SHEET 1.

DETAIL ARRANGEMENT OF KITCHEN VENTILATION PLANT.  
FOR THE PRINCE OF WALES P.H., FORTUNE GREEN ROAD, N.W.6