 













Notes:

1. This drawing should be read in conjunction with JSH electrical services specification ref: EB/CR/5557/E.
2. The School has advised that there is asbestos products in the working areas. The Contractor shall communicate with the Main Contractor and the School prior to any works being undertaken.

Legend:

-  REF Surface mounted linear fluorescent
-  REF Recessed downlighter
-  Internally illuminated emergency bulk head
-  REF Surface mounted round luminaire
-  N Lighting switch one way (n=no of gangs)
-  N Lighting switch two way (n=no of gangs)
-  Pull cord switch
-  Typical circuit line
-  Typical switch line
-  Typical switch link
-  EM Denotes emergency

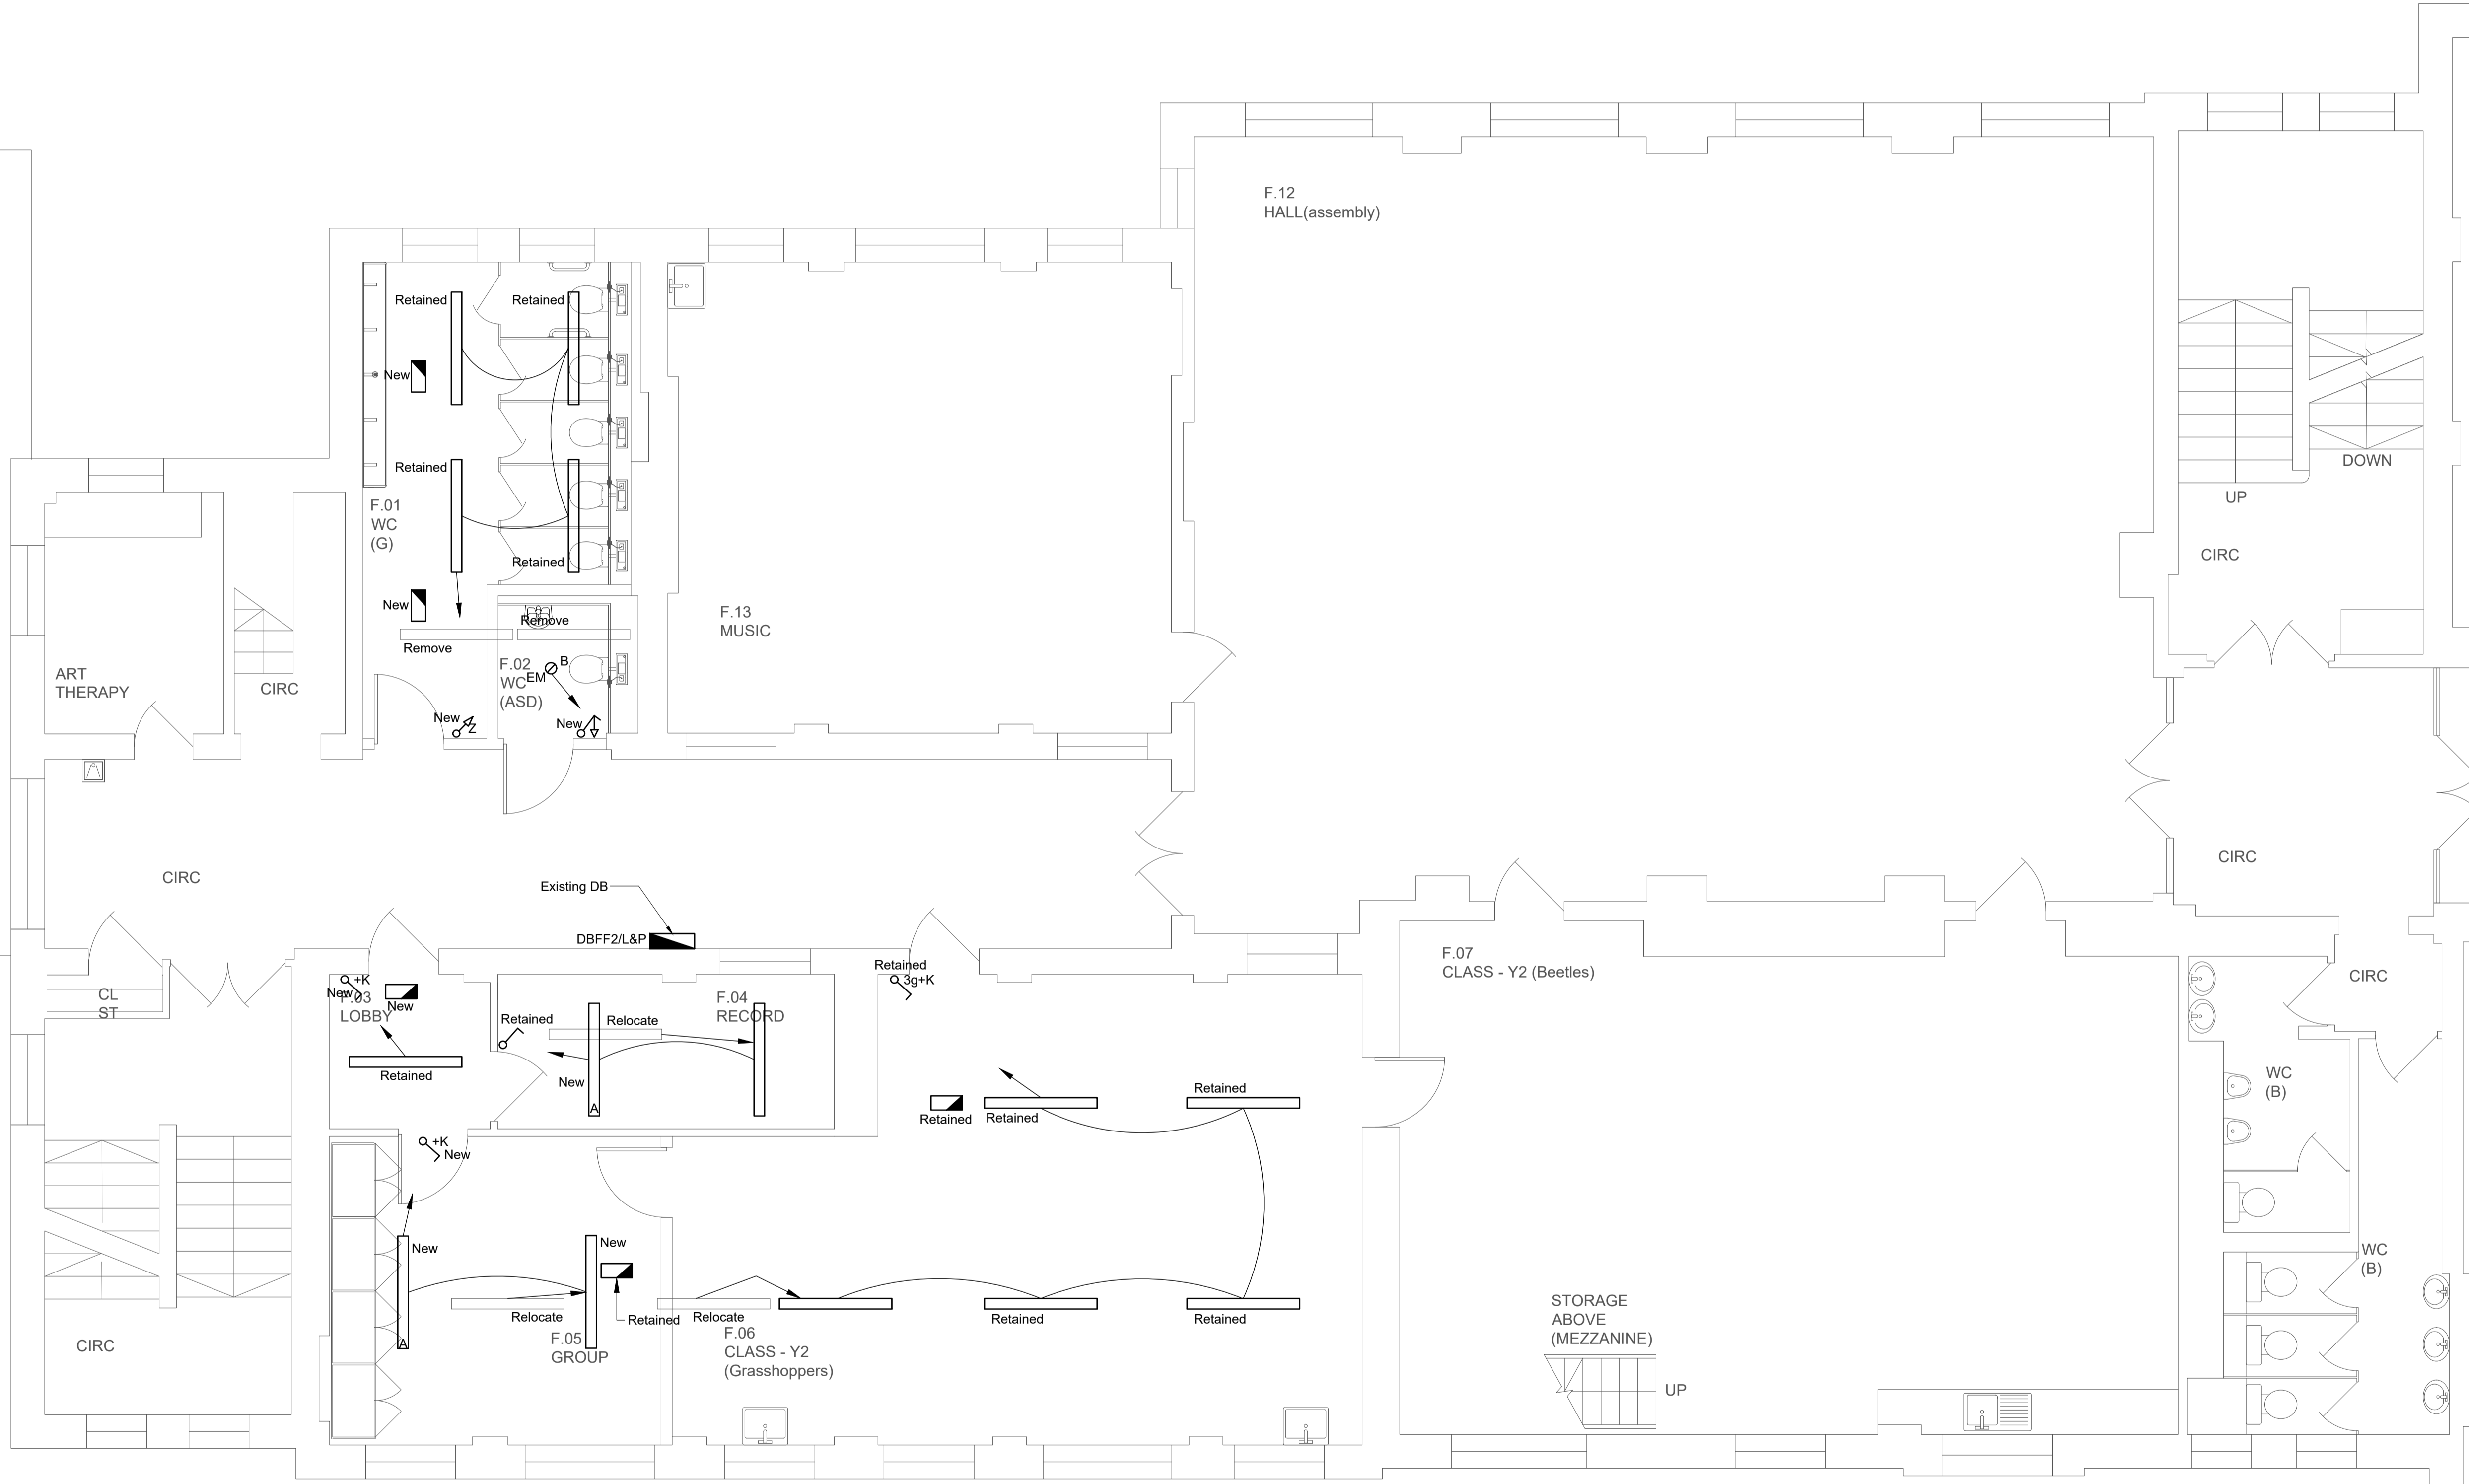

P01	Tender Issue	JH	EB	05/19
REV	DESCRIPTION	DR'WN	CHK'D	DATE

Johns Slater and Haward
 Chartered Building Services Consultants
 Ardman's House, 6 Sorrel Horse Mews, Grimwade St, Ipswich IP4 1LN
 01473 255965, engineers@jshipswich.co.uk, www.jshipswich.co.uk



CLIENT:


PROJECT:
 Primrose Hill Primary School ARP

DRG TITLE:
 First Floor
 Proposed Lighting Layout

SCALE: 1:50 @ A1	STATUS: D2 - Tender	PROJECT: 5557.00	ORIGINATOR: JSH
ZONE: XX	LEVEL: 01	TYPE: DR	DRG No. REV E-0203 P01



Ref:"A" - College LED4200-840 HF L1500



Ref:"B" - Cetus LED 2000 HF 830



Ref:"C" - Voyager Solid L MS E3D-S WH



Ref:"Z" - I LumoS Luxury White Glass Panel LED Dimmer